



DRAINAGE STRUCTURE CROSS-SECTION C-C

SCALE: 1"=10'

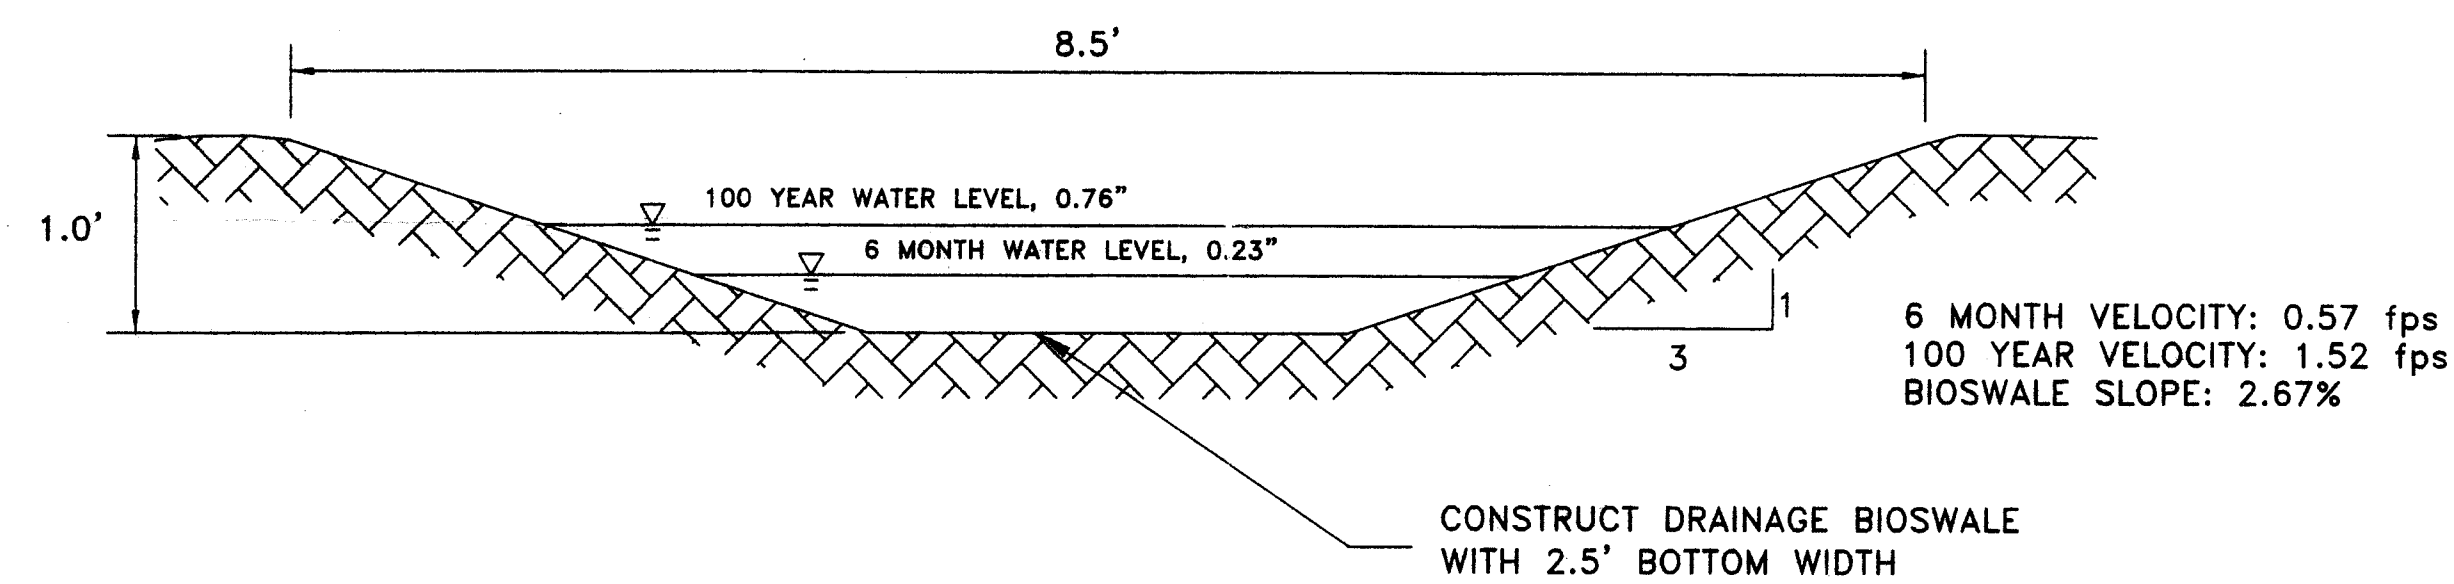


DRAINAGE SWALE CROSS-SECTION B-B

SCALE: 1"=1'

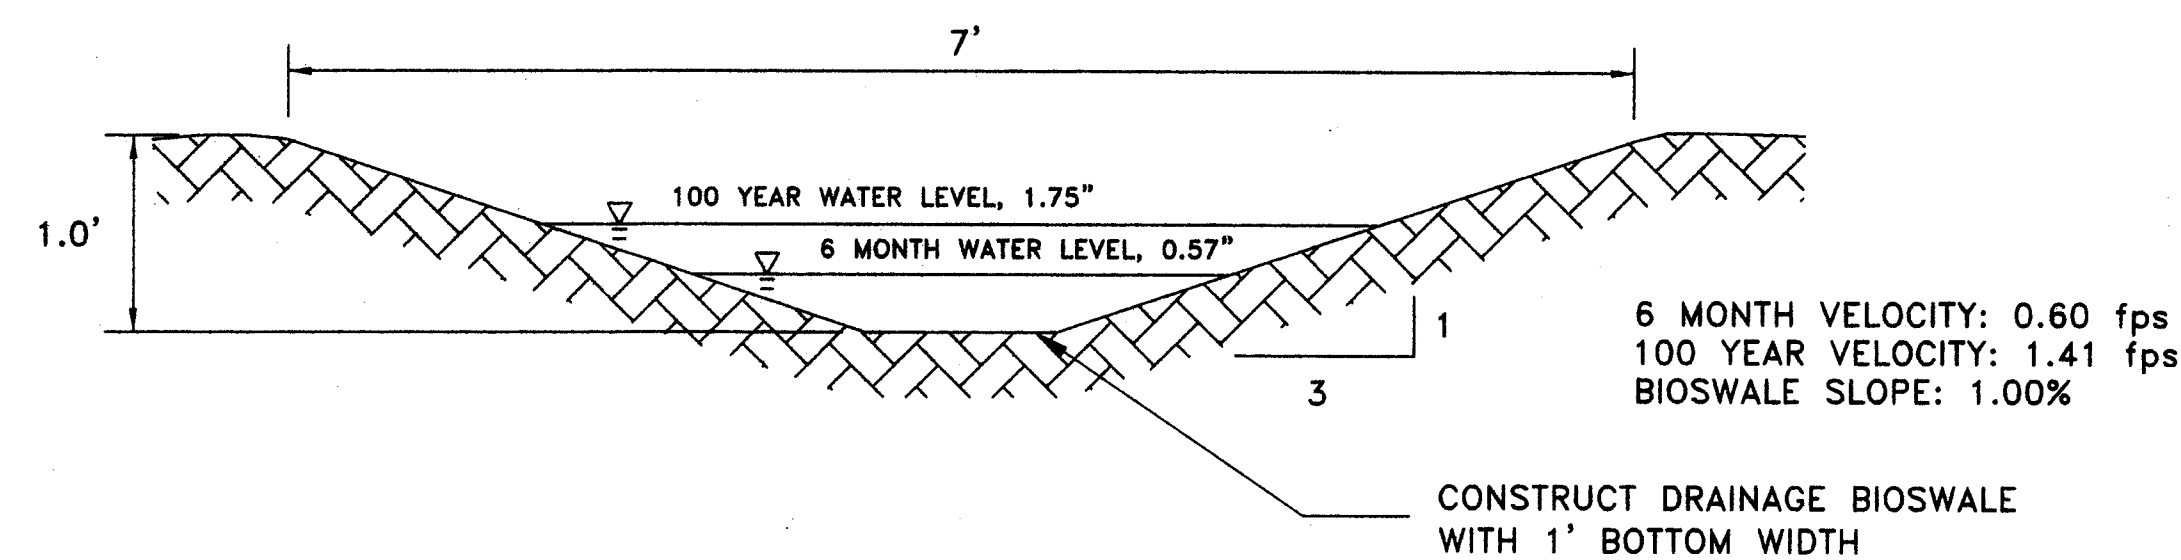

DRAINAGE SWALE CROSS-SECTION A-A


SCALE: 1"=1'

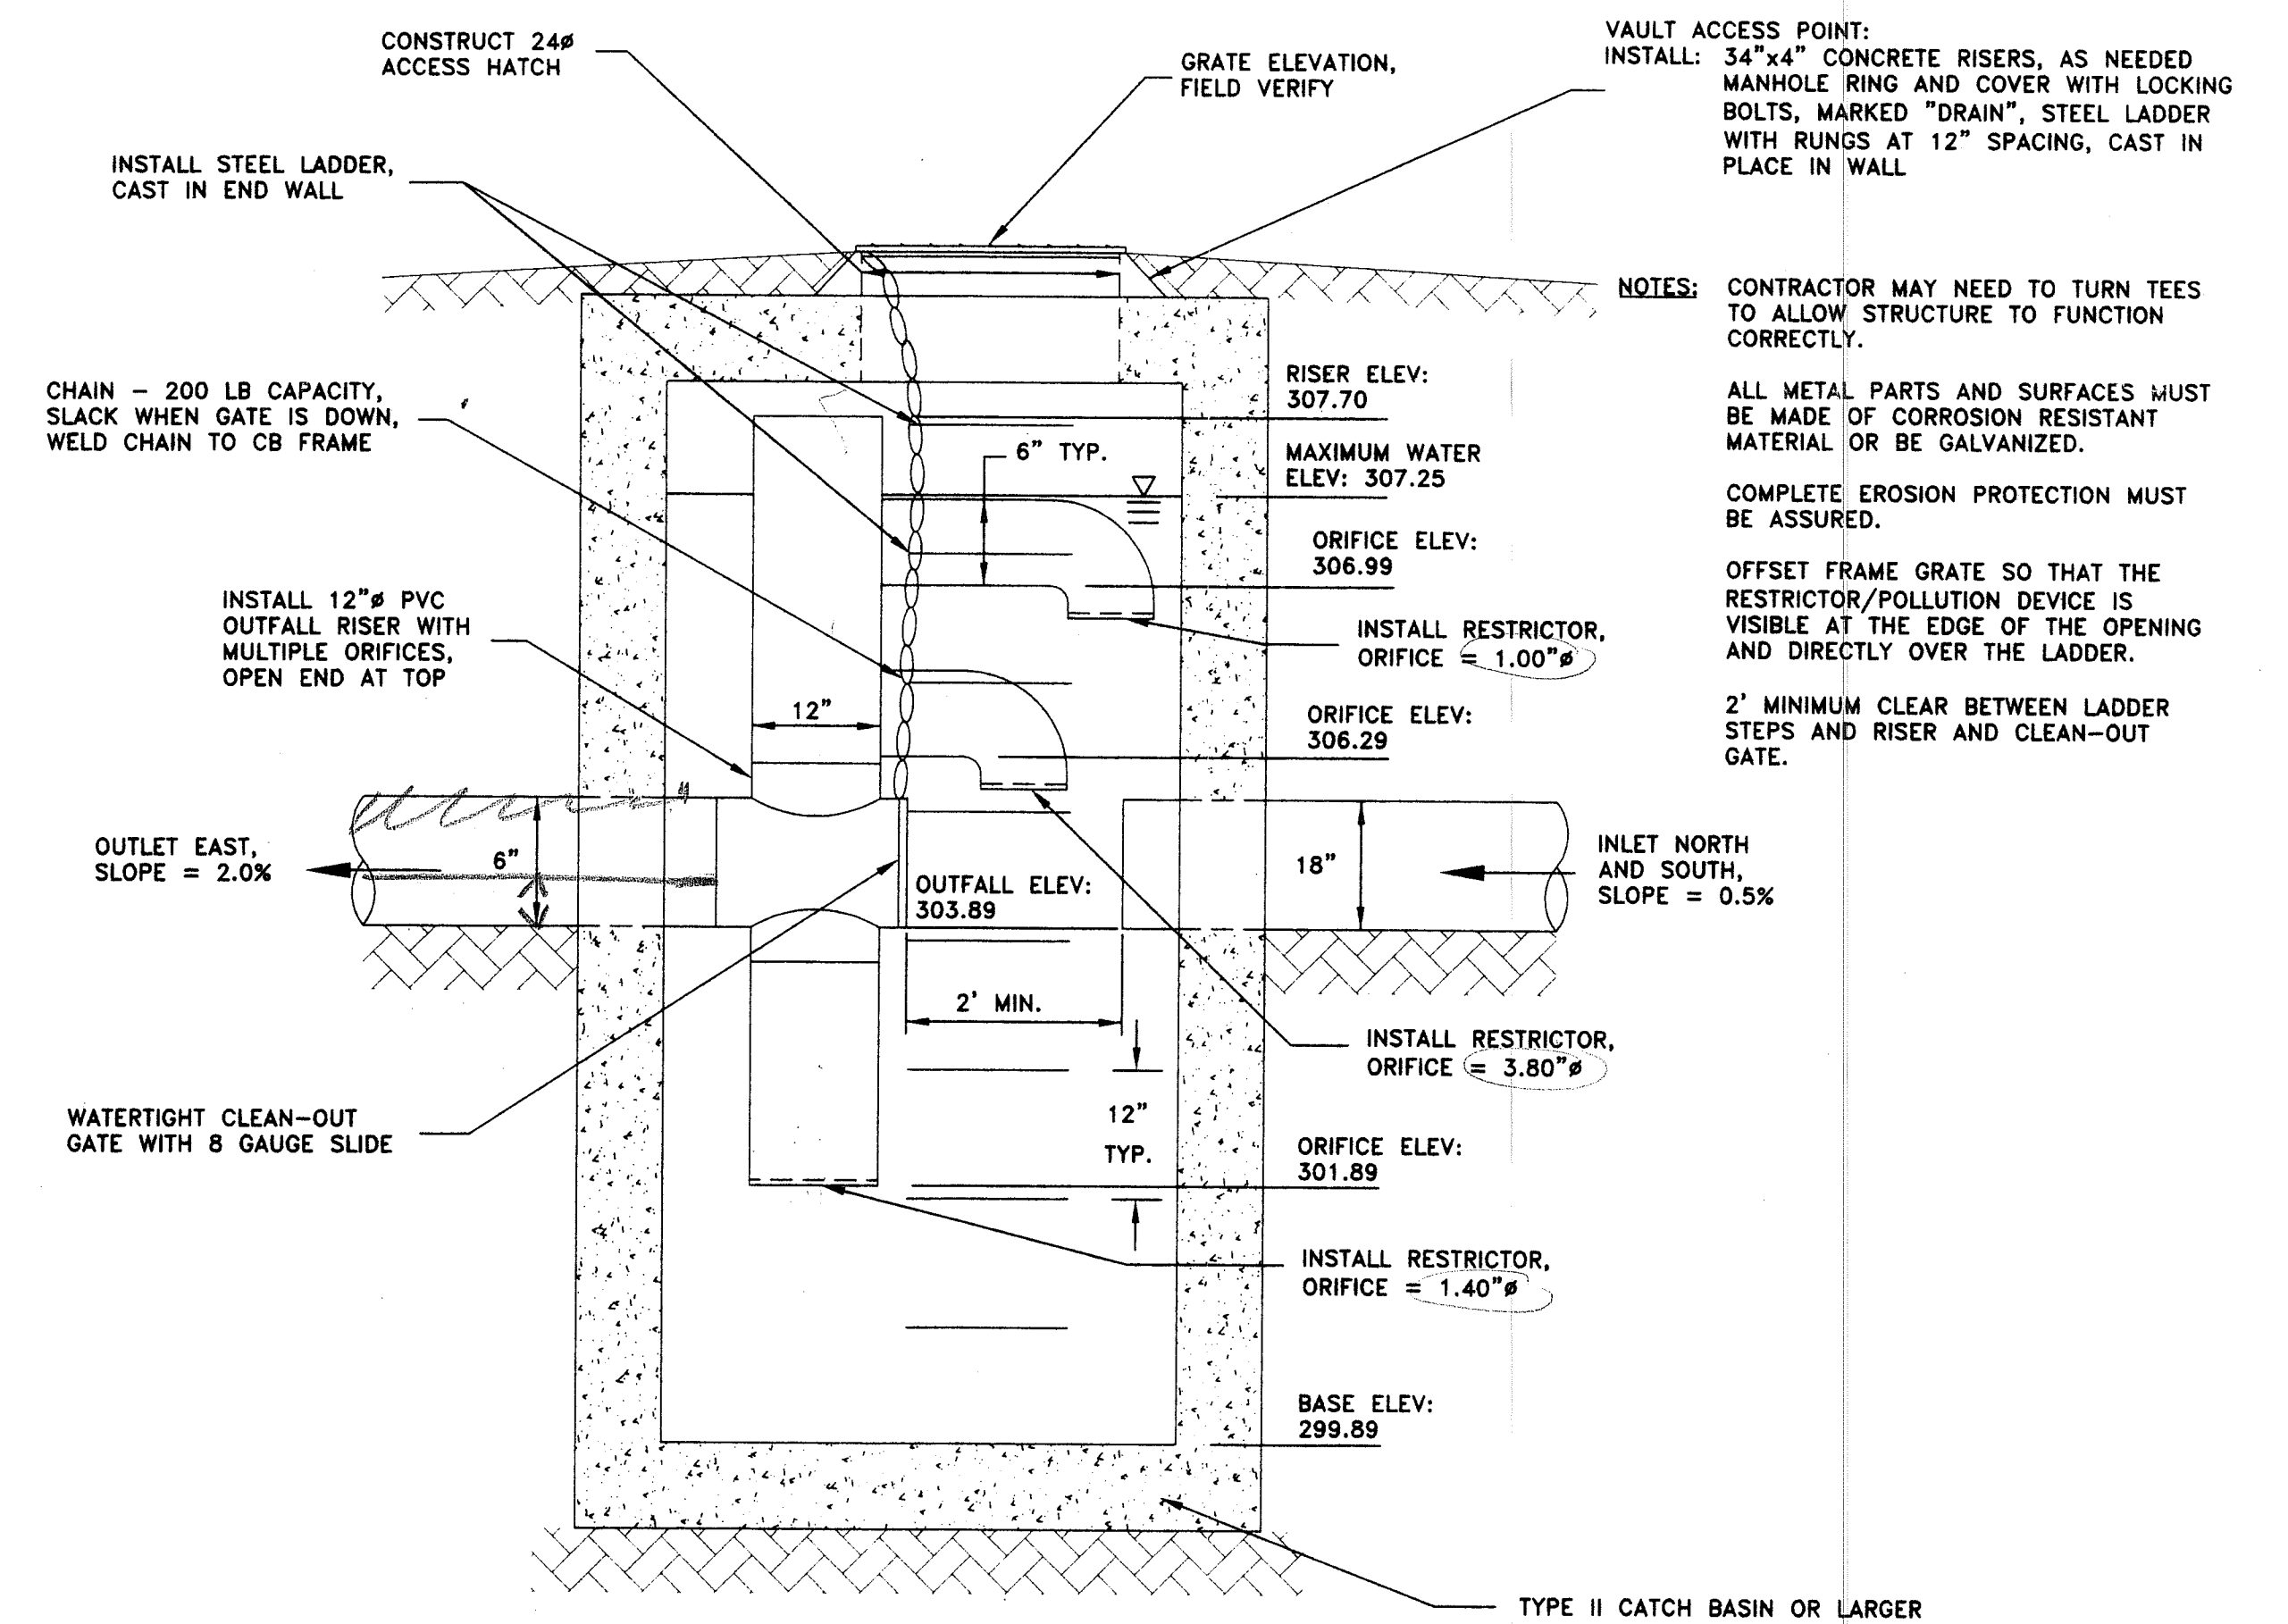

FLOW RESTRICTING STRUCTURE

SCALE: N.T.S.

REVISIONS:	DRAWN BY	DATE	CHECKED BY	DATE	SEAL
1	BDS	11-12-98			
2	BDS	12-11-98			
3					
4					

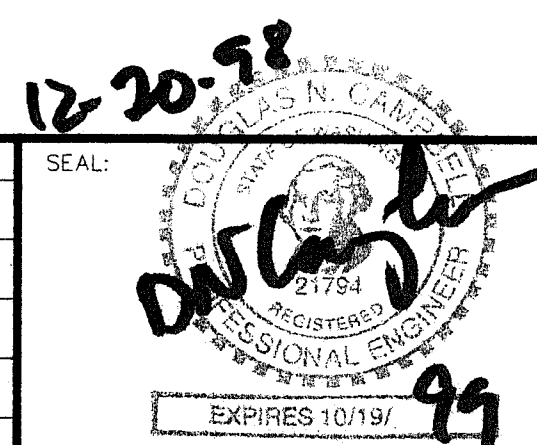


ASSOCIATED
PROJECT CONSULTANTS, INC., P.S.
PROFESSIONAL CONSULTING ENGINEERS
1401 ASTOR STREET BELLINGHAM, WASHINGTON 98225 (360) 671-1146

HORIZONTAL SCALE: 1"=20'
VERTICAL SCALE: DRAWN BY: BDS
DATE: 10/07/98 APPROVED BY:
NORTH ROTATION:

CLIENT:	NORTHSHORE CORPORATION	JOB NO.:	97-109
PROJECT:	NORTHSHORE LONG PLAT	ACAD FILE:	DRAIN2.DWG
TITLE:	DRAINAGE DETAILS	SHEET:	2
		OF:	2

John Eley 12-23-98
JOHN ELEY, CITY OF FERNDALE CITY ENGINEER

Private Storm System

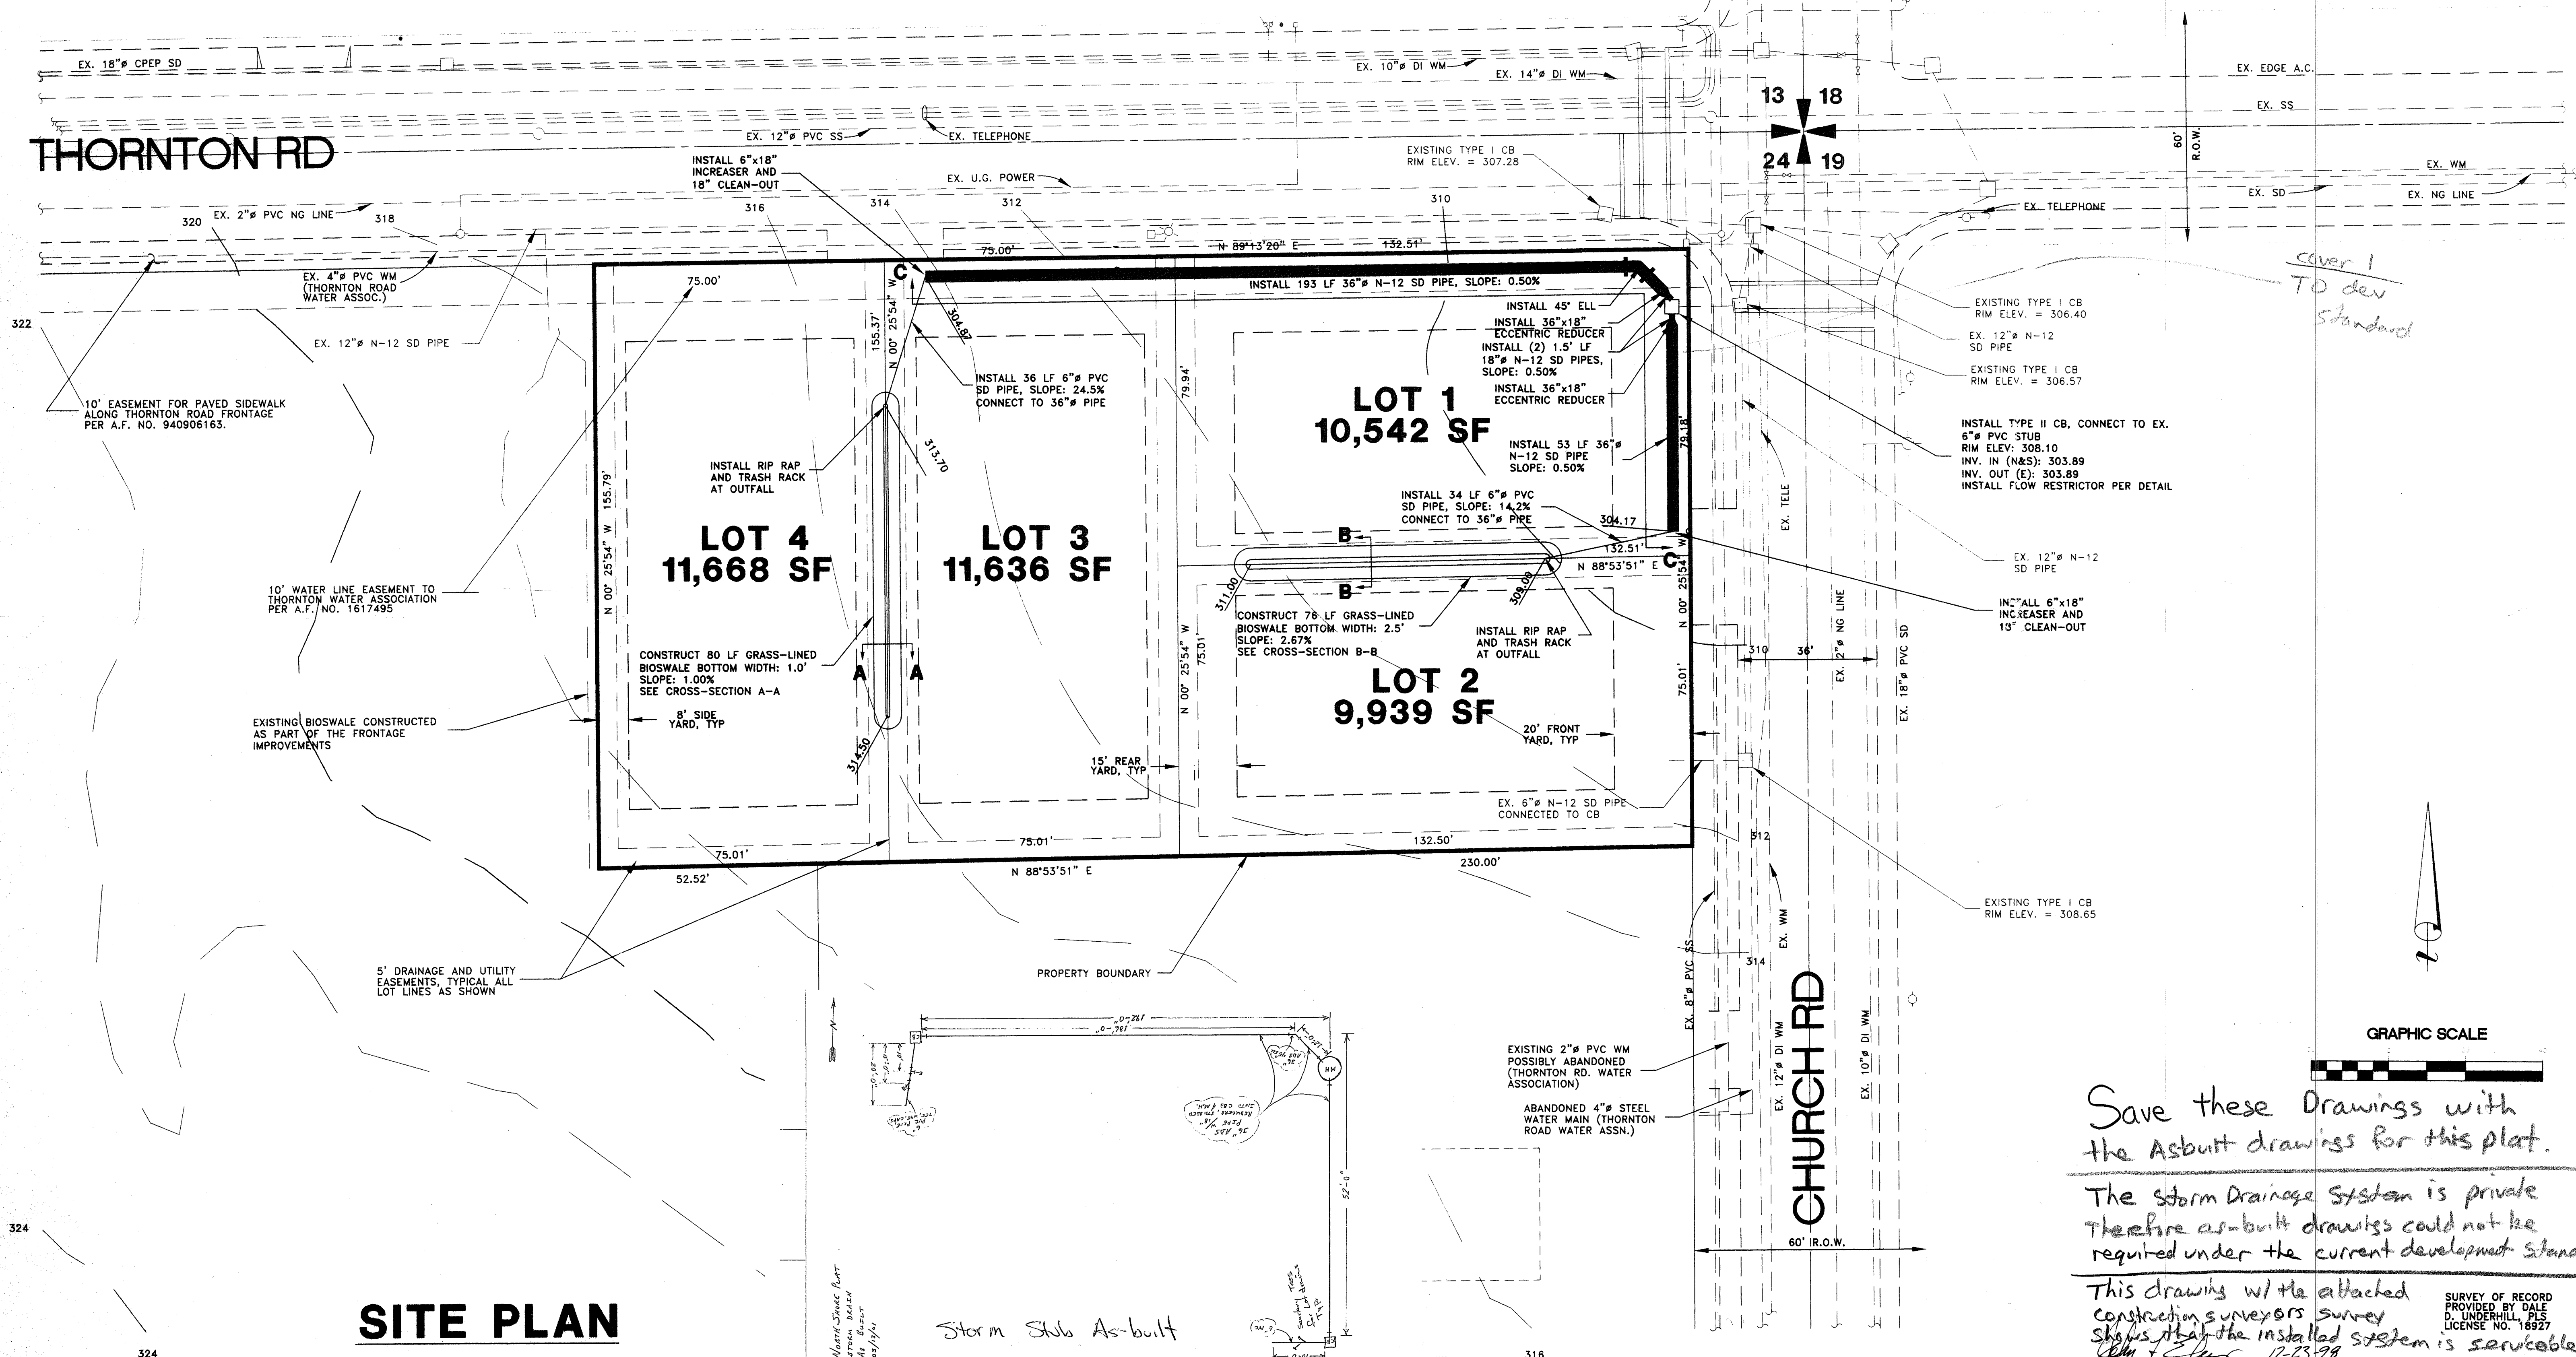

SITE PLAN

Save these Drawings with the Asbuilt drawings for this plat.

The storm Drainage System is private Therefore as-built drawings could not be required under the current development standard.

This drawings w/ the attached construction surveyors survey shows that the installed system is serviceable.

JOHN ELEY, CITY OF FERNDALE, CITY ENGINEER

REVISIONS:				DRAWN BY		DATE	CHECKED BY	DATE	SEAL:			HORIZONTAL SCALE: 1"=20'		CLIENT:	NORTHSHORE CORPORATION		JOB NO.:	97-109
1	CHANGES PER REDLINE COMMENTS FROM CITY OF FERNDALE			BDS		11/12/98						VERTICAL SCALE:	DRAWN BY:	PROJECT:	NORTHSHORE LONG PLAT		ACAD FILE:	DRAIN1.DWG
2	CHANGES PER REDLINE COMMENTS FROM CITY OF FERNDALE			BDS		12/11/98						DATE:	APPROVED BY:	TITLE:	DRAINAGE PLAN		SHEET:	1
3												NORTH ROTATION:					OF:	2