



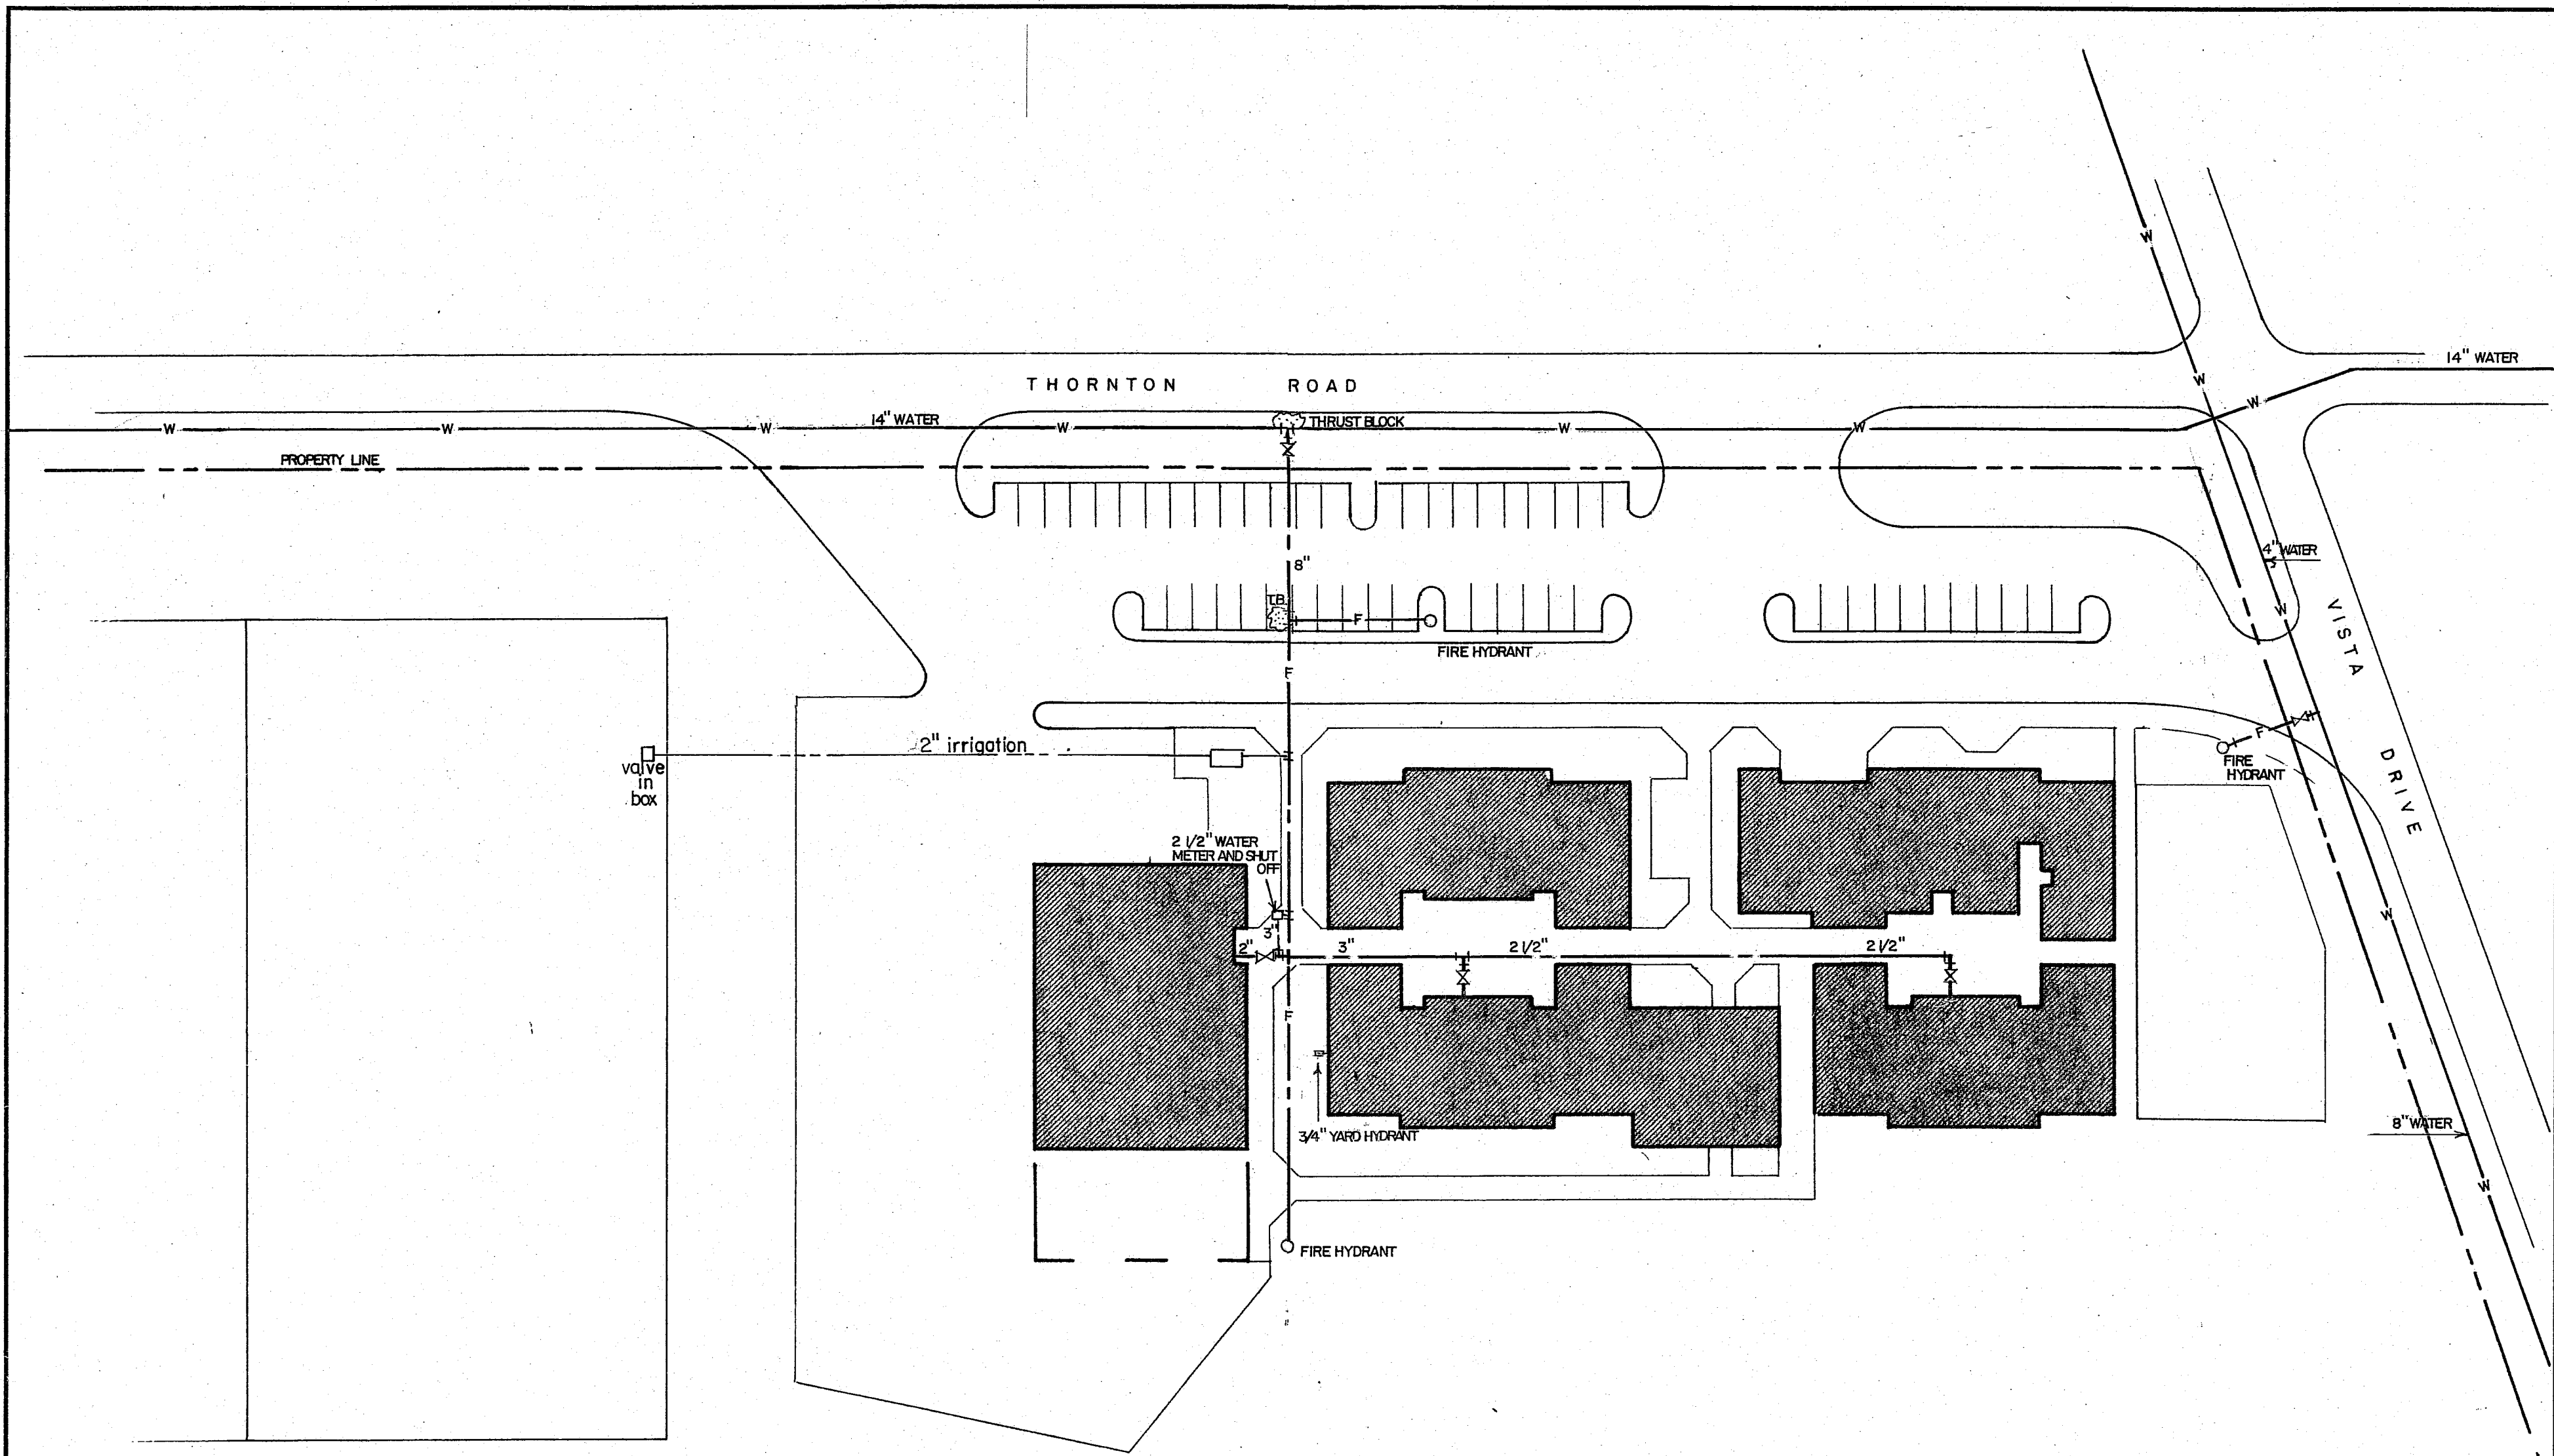

SITE PLAN - WATER

SYMBOL	ABBREVIATIONS	EXPLANATION
---	C.W.	Cold Water (Domestic)
F	F	Fireline
O	F.H.	Fire Hydrant
X	G.V.	Gate Valve
+	U	Union
+	T.B.	Thrust Block

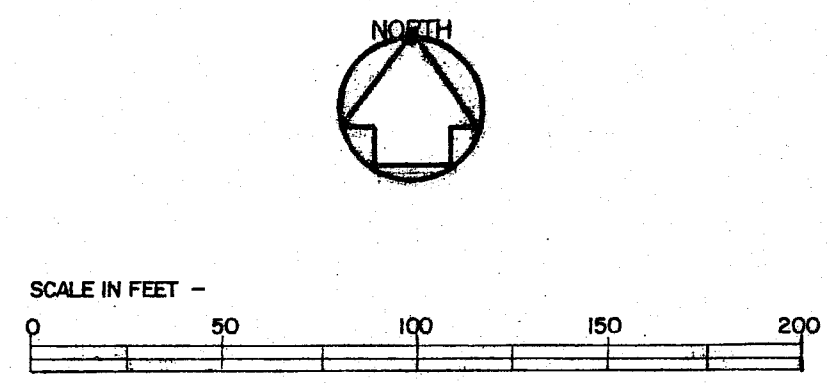


REVISIONS	BY

**SKYLINE ELEMENTARY SCHOOL
FERNDAL SCHOOL DISTRICT NO. 502
FERNDAL, WASHINGTON**


Date 6/27/84
Scale AS NOTED
Drawn CAB

00020.001 8/1/17 SH

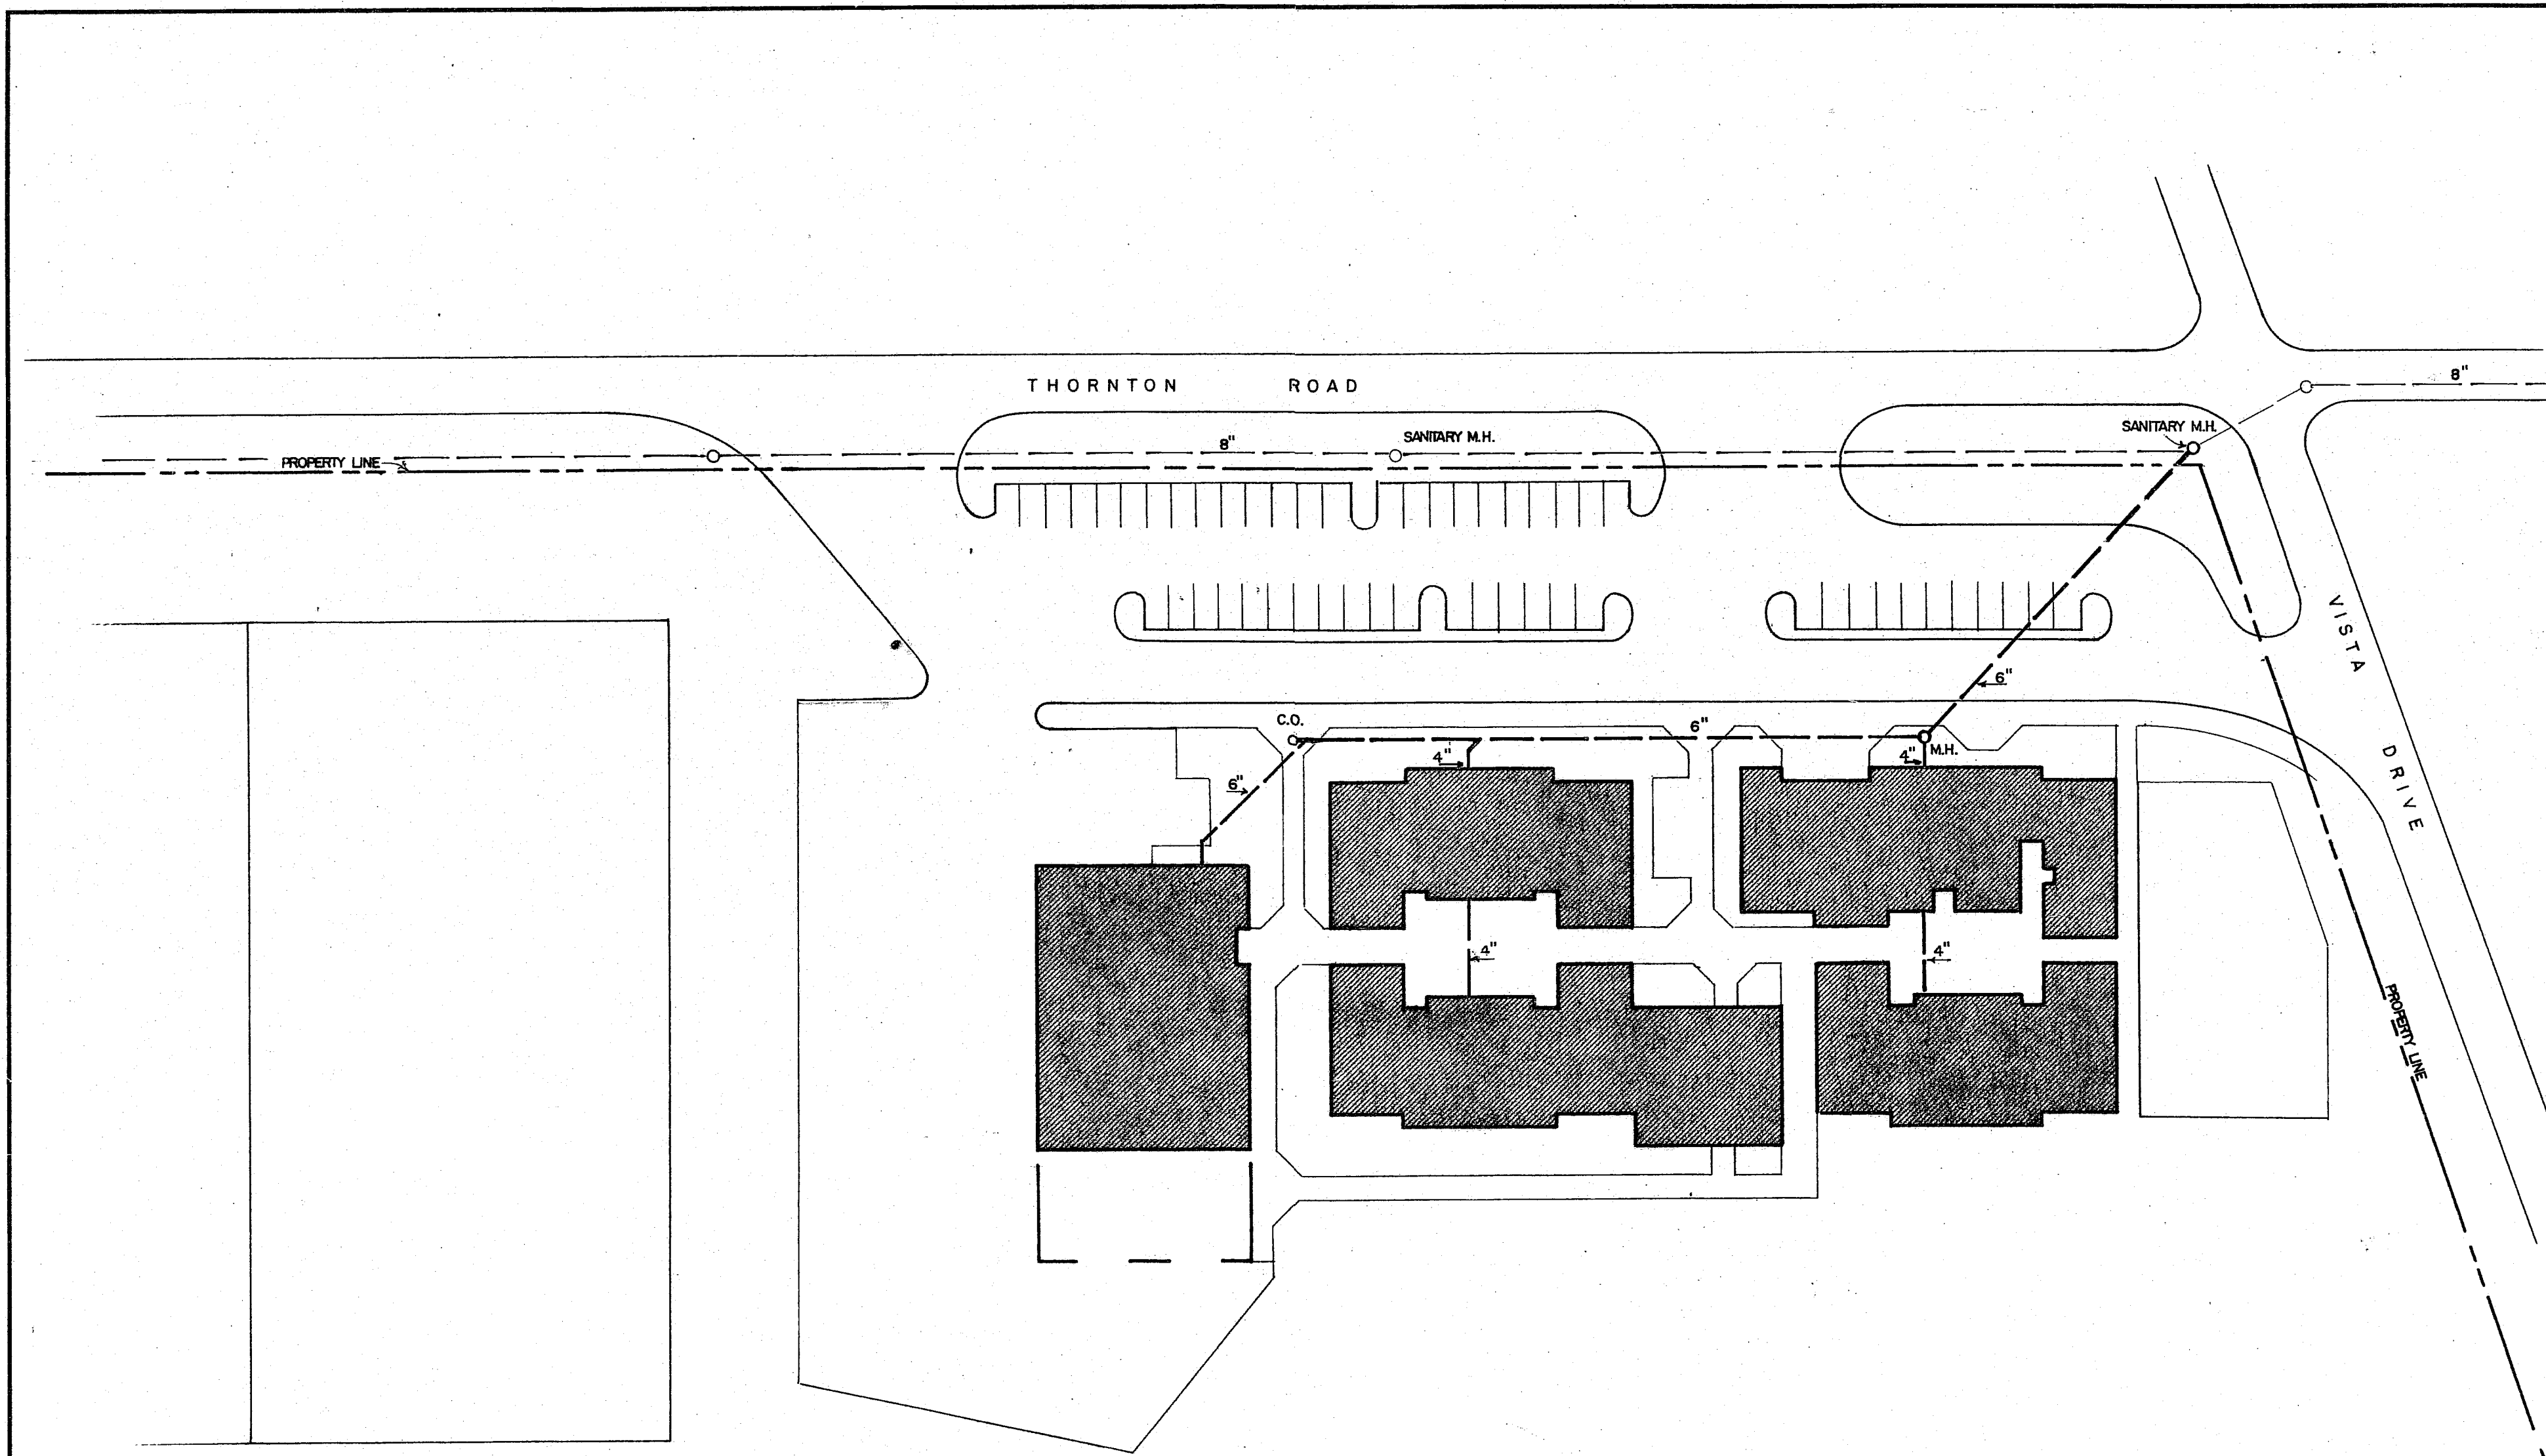

SITE PLAN - SANITARY SEWER

LEGEND		
SYMBOL	ABBREVIATIONS	EXPLANATION
		Sanitary Sewer Above Ground
		Sanitary Sewer Below Ground
	M.H.	Manhole
	C.O.	Cleanout

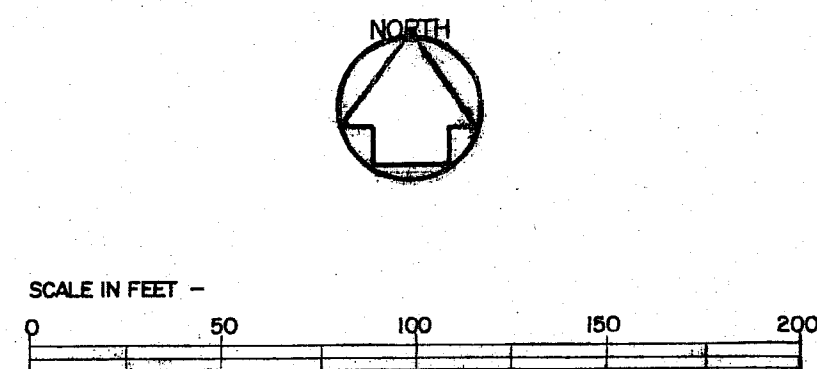

REVISIONS	BY

SKYLINE ELEMENTARY SCHOOL FERNDALE SCHOOL DISTRICT NO. 502 FERNDALE, WASHINGTON	
Date	6/27/84
Scale	AS NOTED
Drawn	CAB

00620.002 8/1/17 st