

TOWN OF FERNDALE, WASHINGTON

SEWAGE SYSTEM IMPROVEMENTS
INTERCEPTOR SEWERS

THORNTON ROAD INTERCEPTOR

STEVENS, THOMPSON & RUNYAN, INC.

Engineers / Planners

SEATTLE


PORTLAND

BOISE

ANCHORAGE


MICROFILMED

MICROFILMED

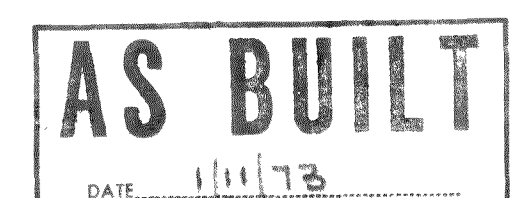

MICROFILMED

00219.001 2-7-06 K12

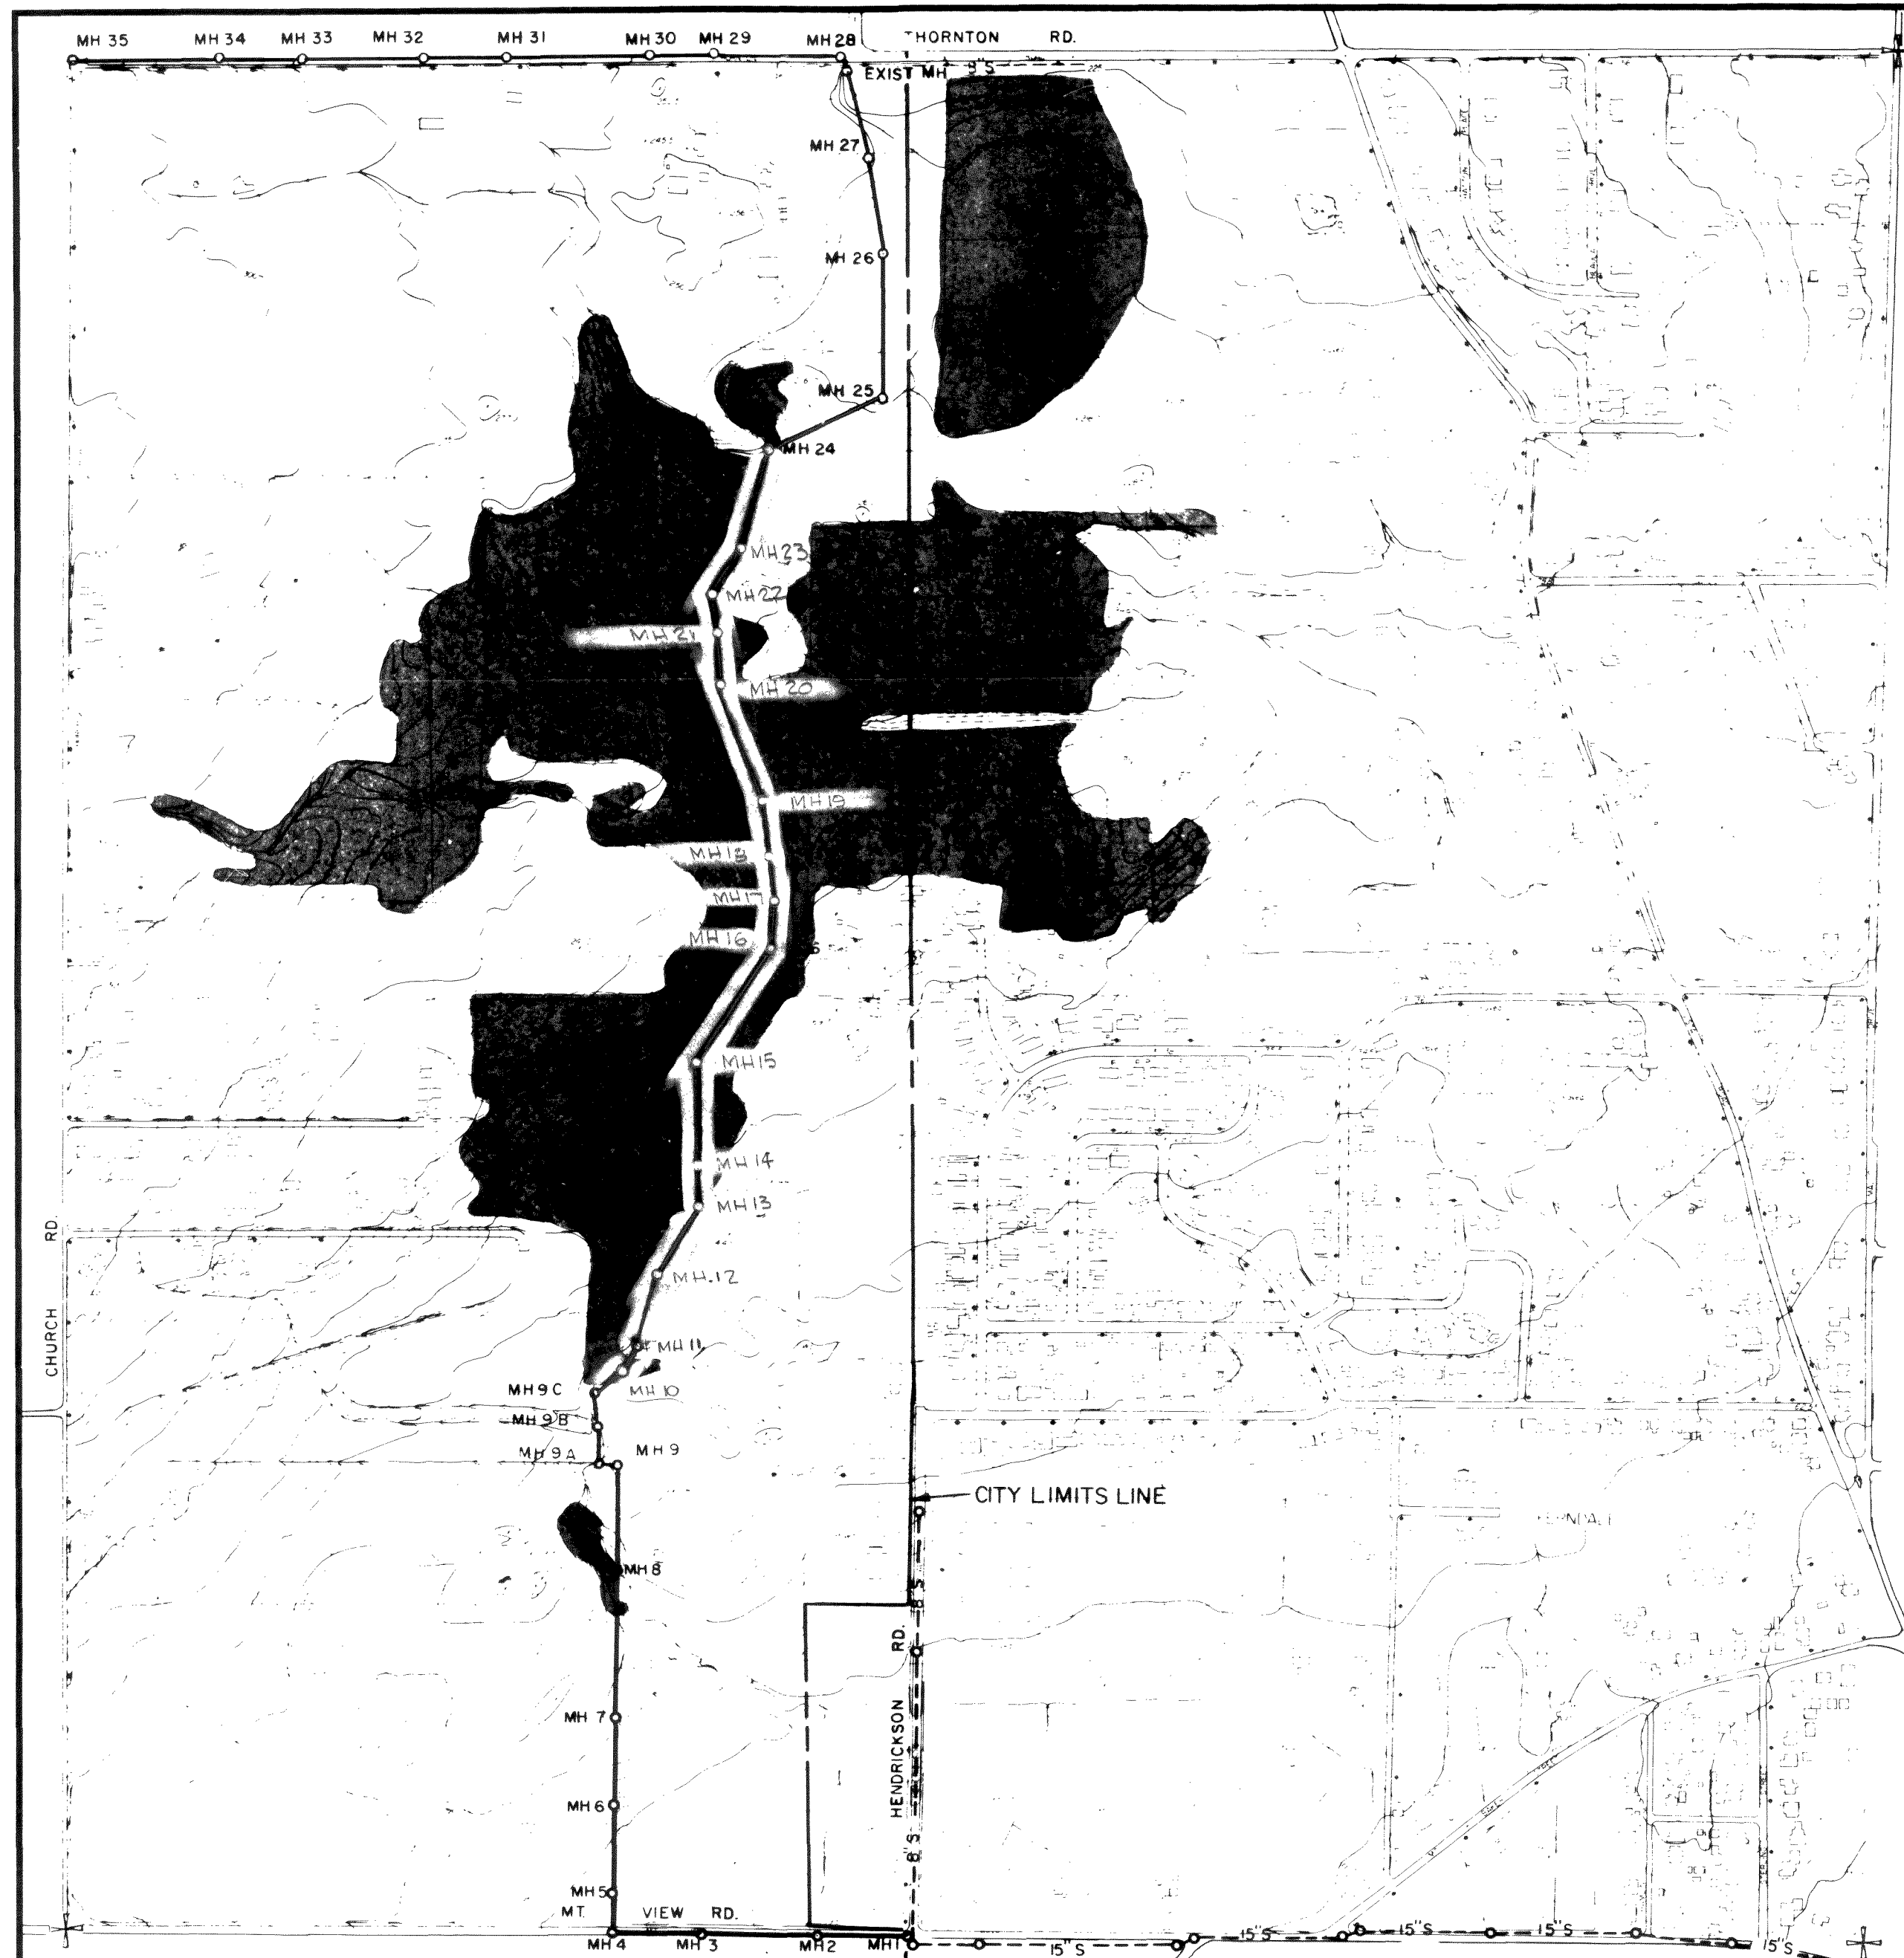

LOCATION PLAN
SCALE 1"=400'

GENERAL NOTES

- ALL ELEVATIONS REFER TO M.S.L.
- DETAIL NUMBERING SYSTEM:
DETAIL $\frac{1}{5}$ SHEET NUMBER ON WHICH DETAIL APPEARS.
- ALL SEWER LINE DIMENSIONS ARE HORIZONTAL DISTANCES
- ALL TRENCHING, BEDDING, BACKFILL AND RESURFACING SHALL BE IN ACCORDANCE WITH DETAILS $\frac{5}{5}$ $\frac{8}{5}$ UNLESS OTHERWISE INDICATED OR SPECIFIED
- ALL MH'S SHALL BE IN ACCORDANCE WITH DETAILS $\frac{3}{5}$ OR $\frac{4}{5}$ UNLESS OTHERWISE INDICATED OR SPECIFIED.
- WHERE STUBS IN MH'S ARE INDICATED ON THE PLANS THEY SHALL BE IN ACCORDANCE WITH DETAIL $\frac{7}{5}$
- LOCATIONS OF EXISTING UTILITIES ARE APPROXIMATE ONLY AND SOME UTILITIES MAY BE NOT BE SHOWN. IT SHALL BE THE CONTRACTOR'S RESPONSIBILITY TO DETERMINE THE EXACT LOCATION OF ALL EXISTING UTILITIES WITHIN THE CONSTRUCTION LIMITS.
- REPLACE ALL PRIVATE SIDEWALKS, STEPS, DRIVEWAYS TO MATCH EXISTING (SEE SPEC'S)
- CONSTRUCT CUT-OFF WALLS IN ACCORDANCE WITH DETAIL $\frac{6}{5}$ INDICATED ON THE PLAN & PROFILE SHEETS $\frac{6}{5}$ AND WHERE DIRECTED BY THE ENGINEER

DRAWING INDEX

SHEET NO.	TITLE
1	LOCATION PLAN, INDEX, LEGEND & GENERAL NOTES
2	PLAN AND PROFILE
3	PLAN AND PROFILE
4	PLAN AND PROFILE
5	SEWER DETAILS

LEGEND

EXISTING	PROPOSED
$\frac{6}{5}$ 6" W	WATER LINE W/ SIZE & VALVE
$\frac{6}{5}$	WATER METER
$\frac{6}{5}$ 8" S	SANITARY SEWER W/ SIZE & MANHOLE
$\frac{6}{5}$	CATCH BASIN & STORM SEWER
$\frac{6}{5}$	CULVERT
$\frac{6}{5}$ 2" G	GAS LINE W/ SIZE & VALVE
$\frac{6}{5}$	POWER OR TELEPHONE POLE
$\frac{6}{5}$	FENCE
$\frac{6}{5}$	EXISTING ROAD SURFACE
$\frac{6}{5}$	TREES & BRUSH (LOCATION PLAN)
$\frac{6}{5}$ T T	UNDERGROUND TELEPHONE CABLE & MARKER
$\frac{6}{5}$	SURVEY POINTS (HUB & TACK OR PK NAIL)
$\frac{6}{5}$	DITCH & DRAINAGE
$\frac{6}{5}$	ROAD R/W
$\frac{6}{5}$	SECTION CORNER
$\frac{6}{5}$	1/4 CORNER

MICROFILMED



AS BUILT
DATE 11/1/73



TOWN OF FERNDALE, WASHINGTON
INTERCEPTOR SEWERS
THORNTON ROAD INTERCEPTOR

LOCATION PLAN, INDEX,
LEGEND & GENERAL NOTES

1
5



00219.002 2-7-00 KL

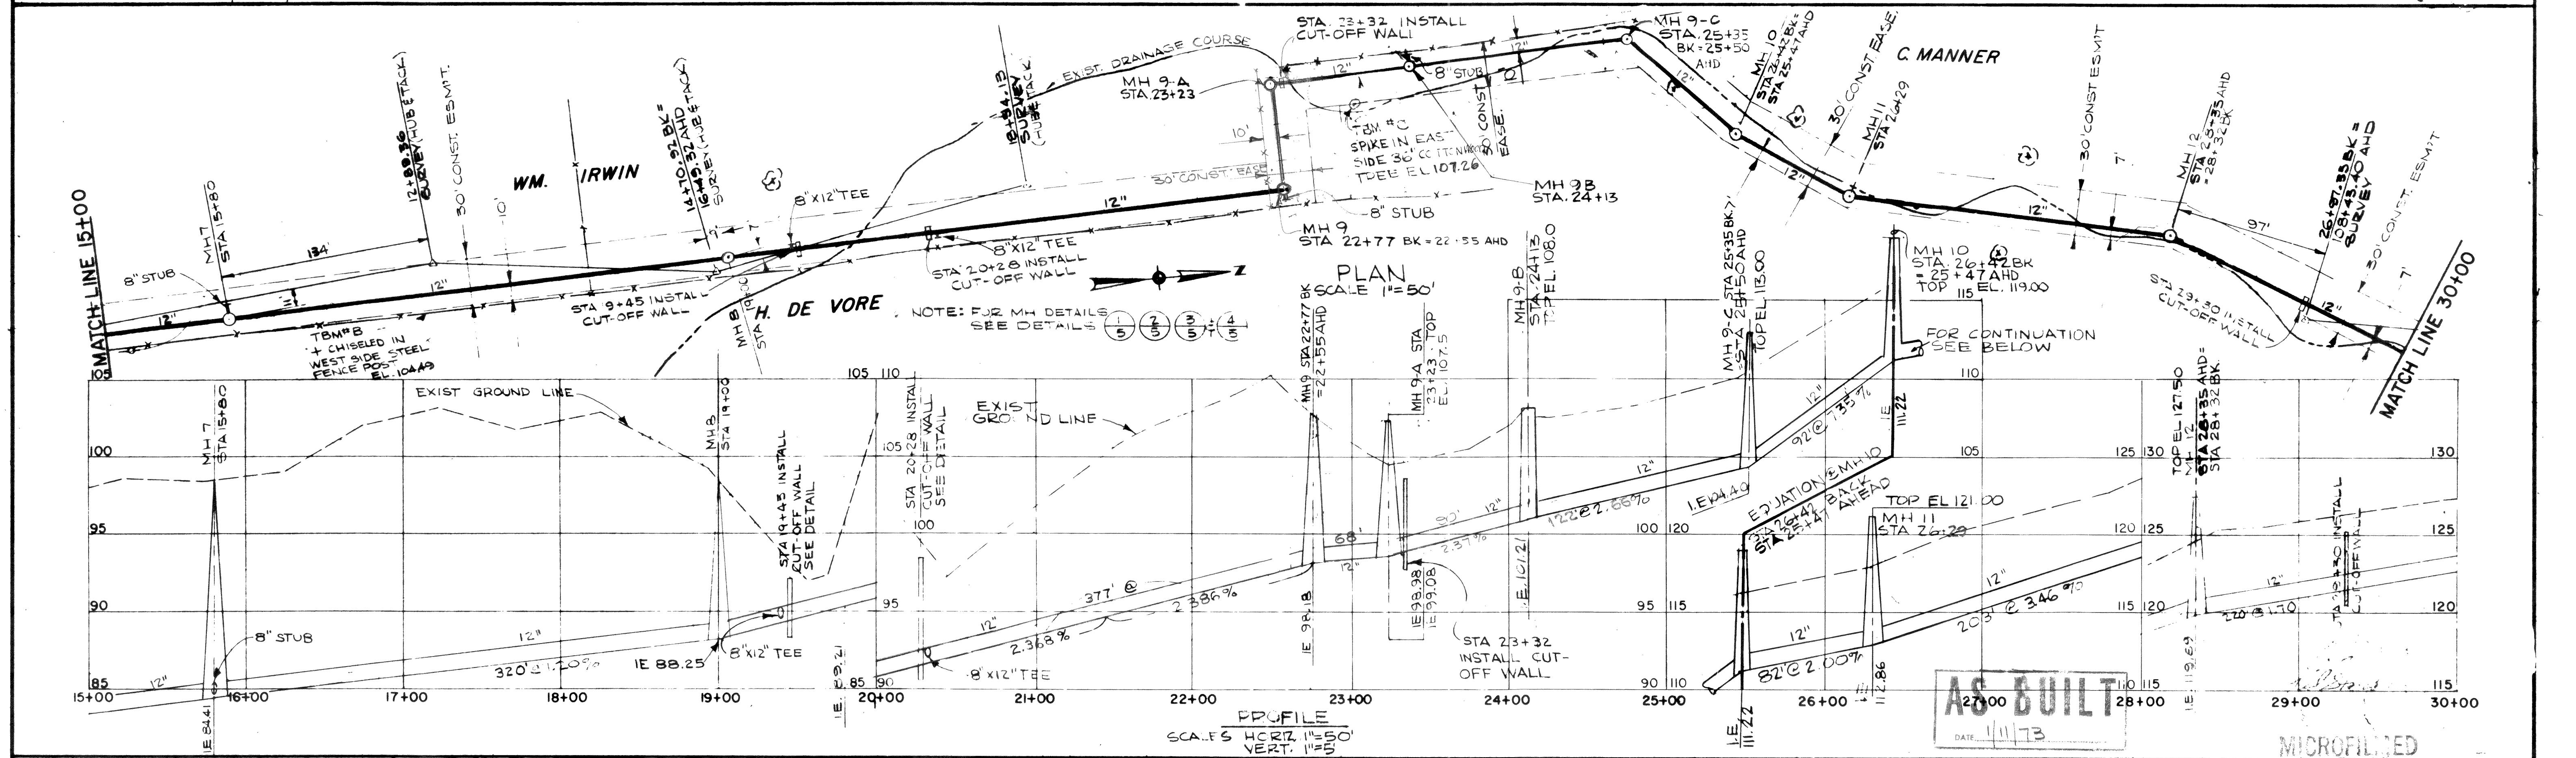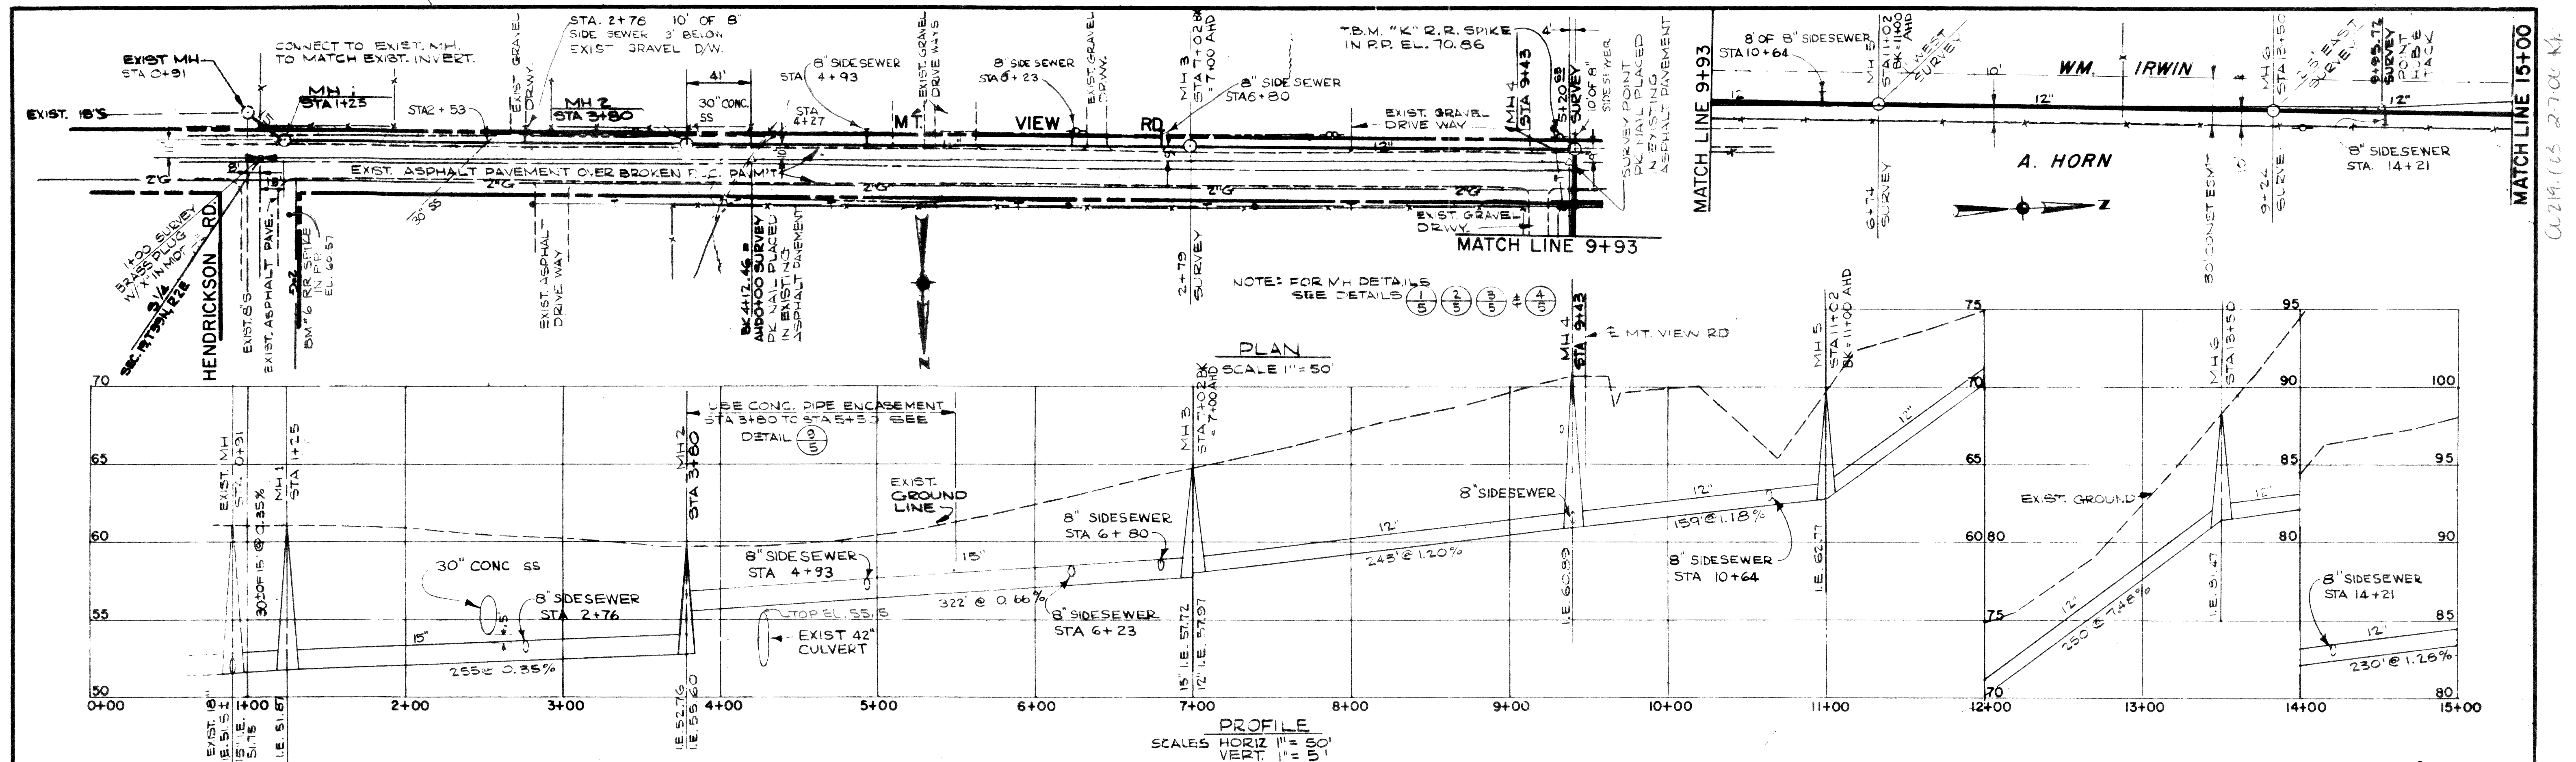

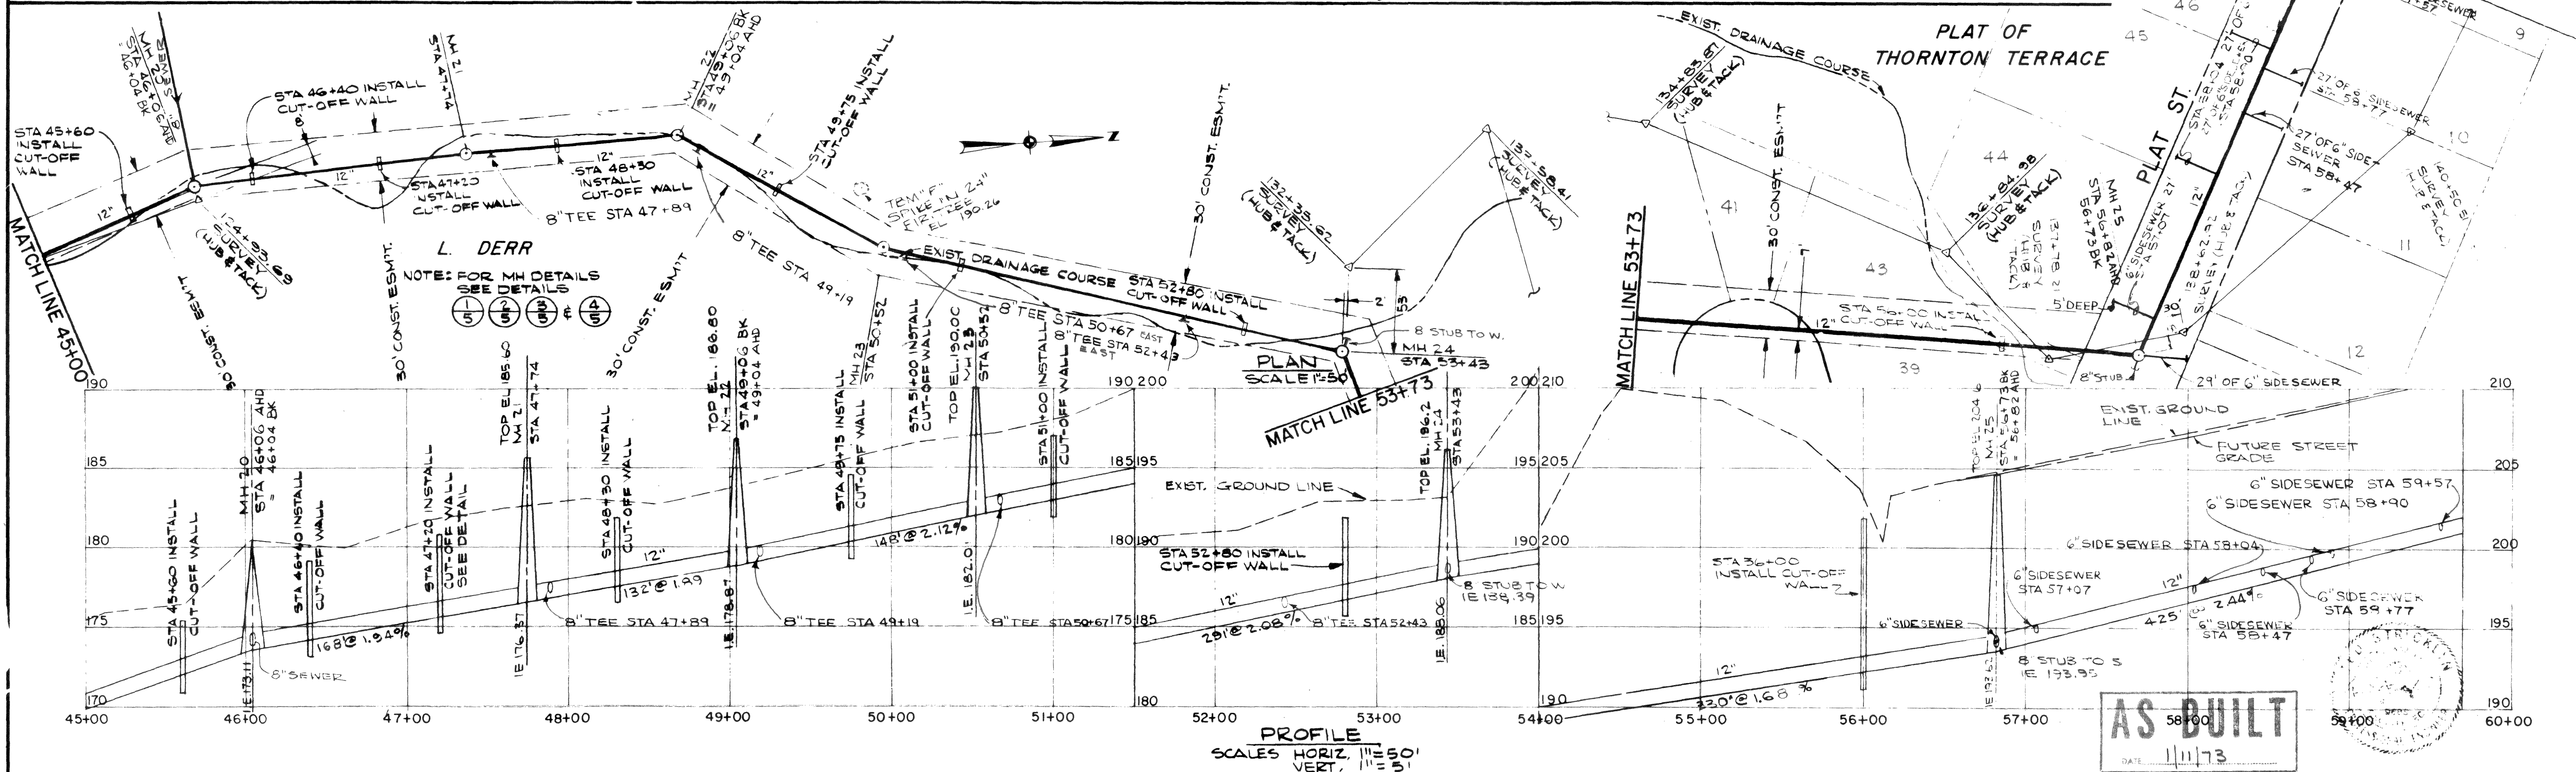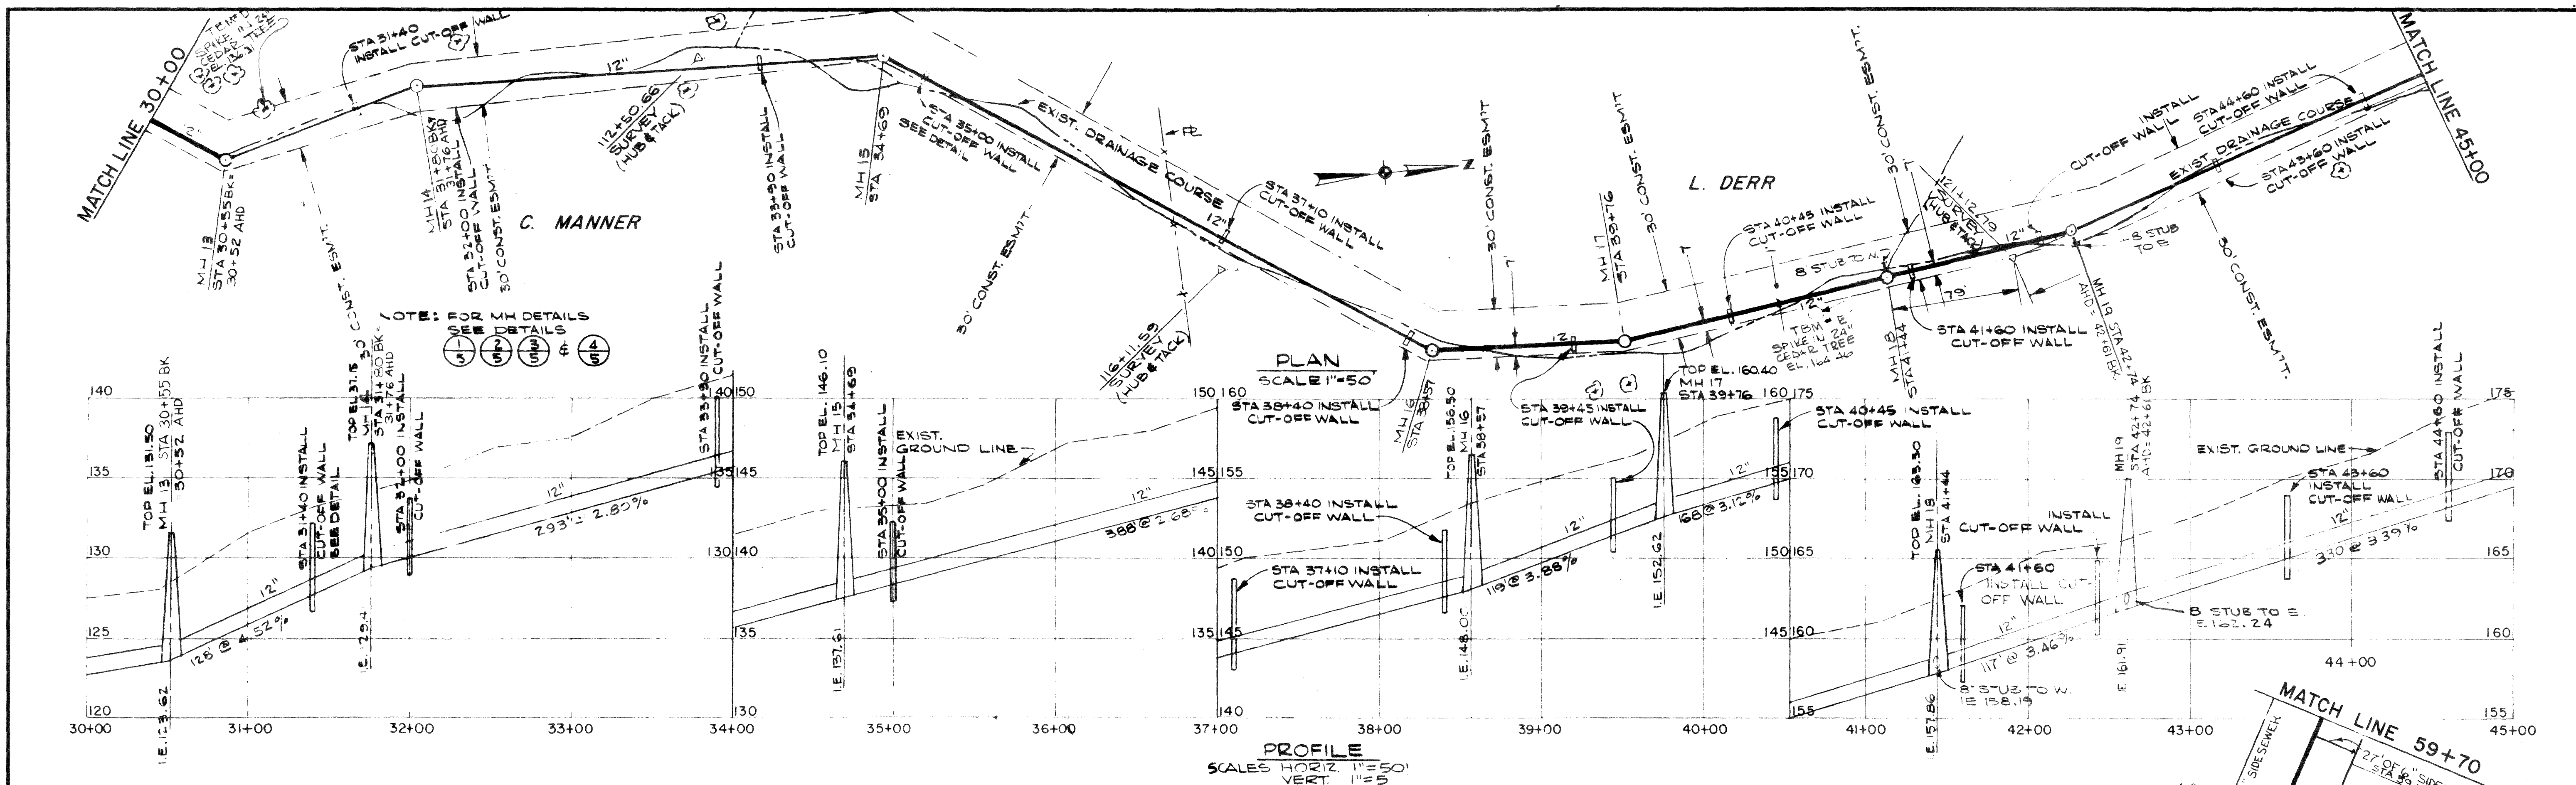

DESIGNED T.S.	APPROVED <i>James M. Little</i>	ST	Stevens, Thompson & Runyan, Inc.	TOWN OF FERDALE, WASHINGTON	3 5
DRAWN DEC.	SCALE AS SHOWN DATE OCT 1971	TR	Engineers/Planners	INTERCEPTOR SEWERS	
CHECKED <i>SHV</i>	FILE 71-S-362.002		PORTLAND SEATTLE BOISE	THORNTON ROAD INTERCEPTOR	

MICROFILMED 5-362

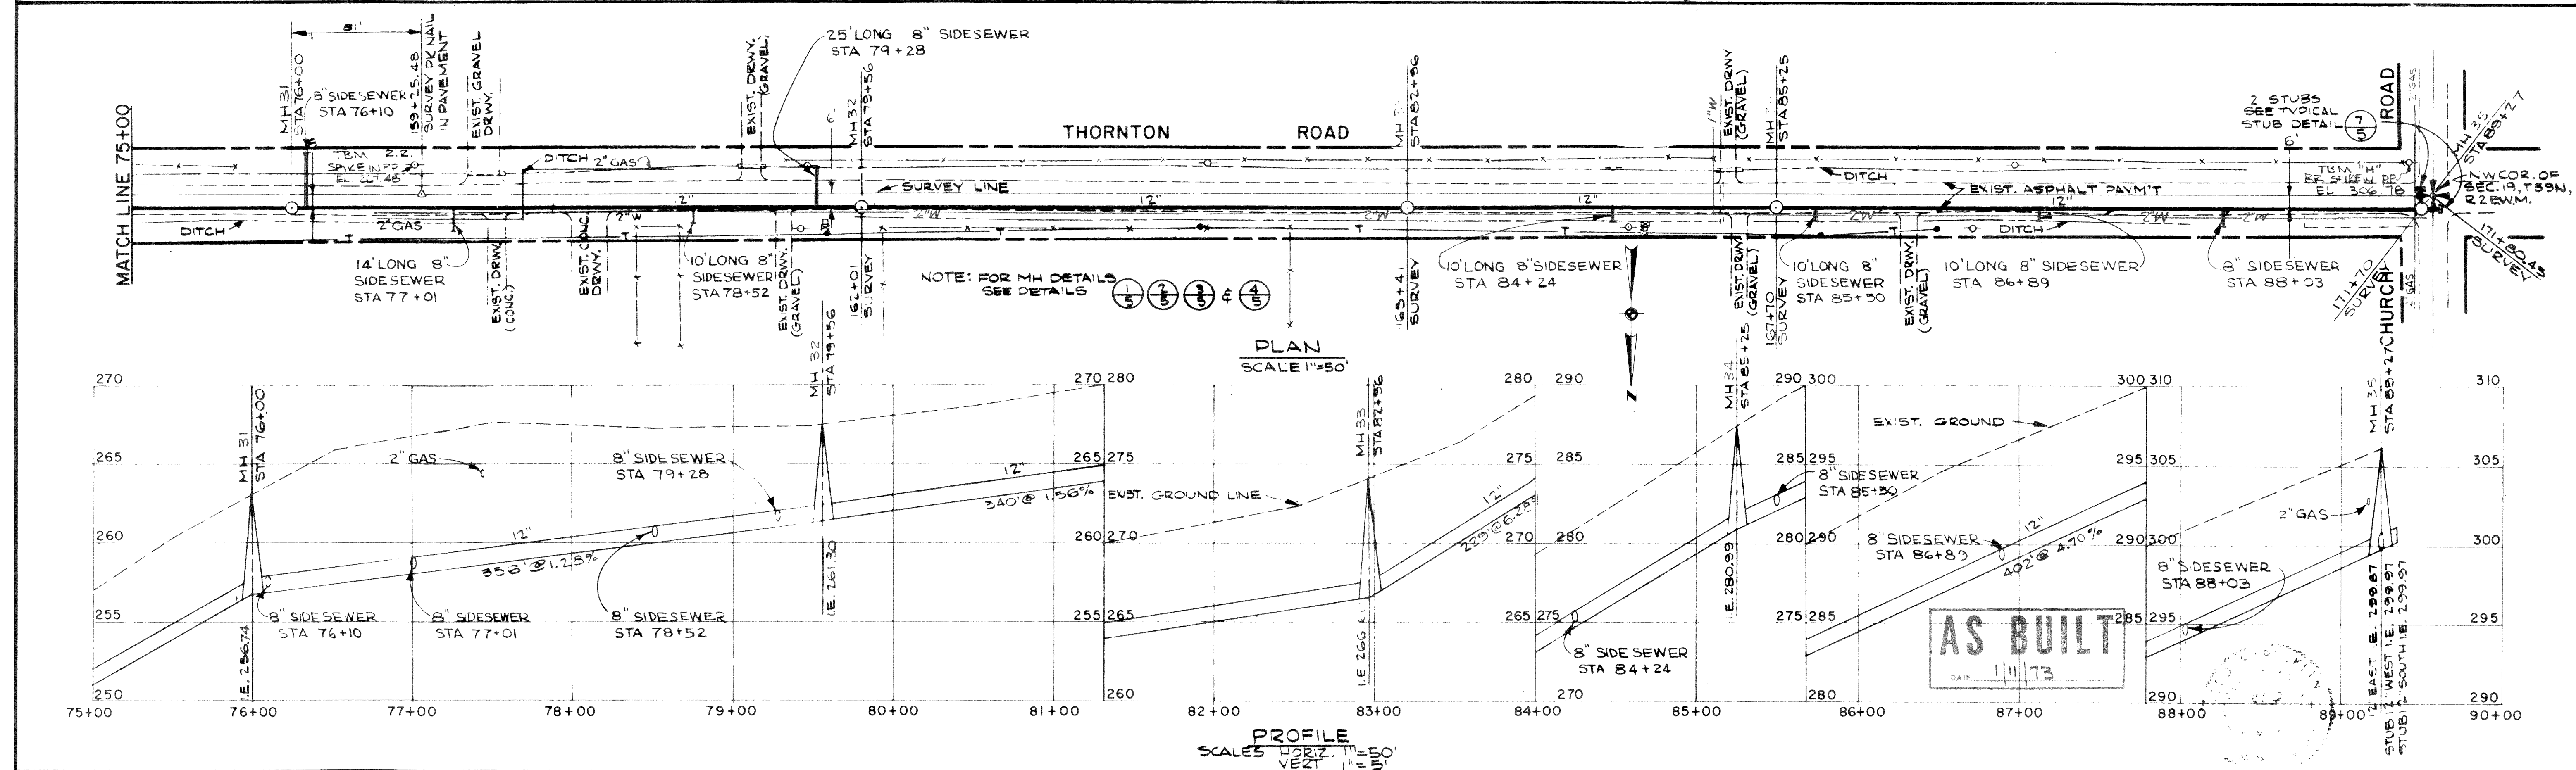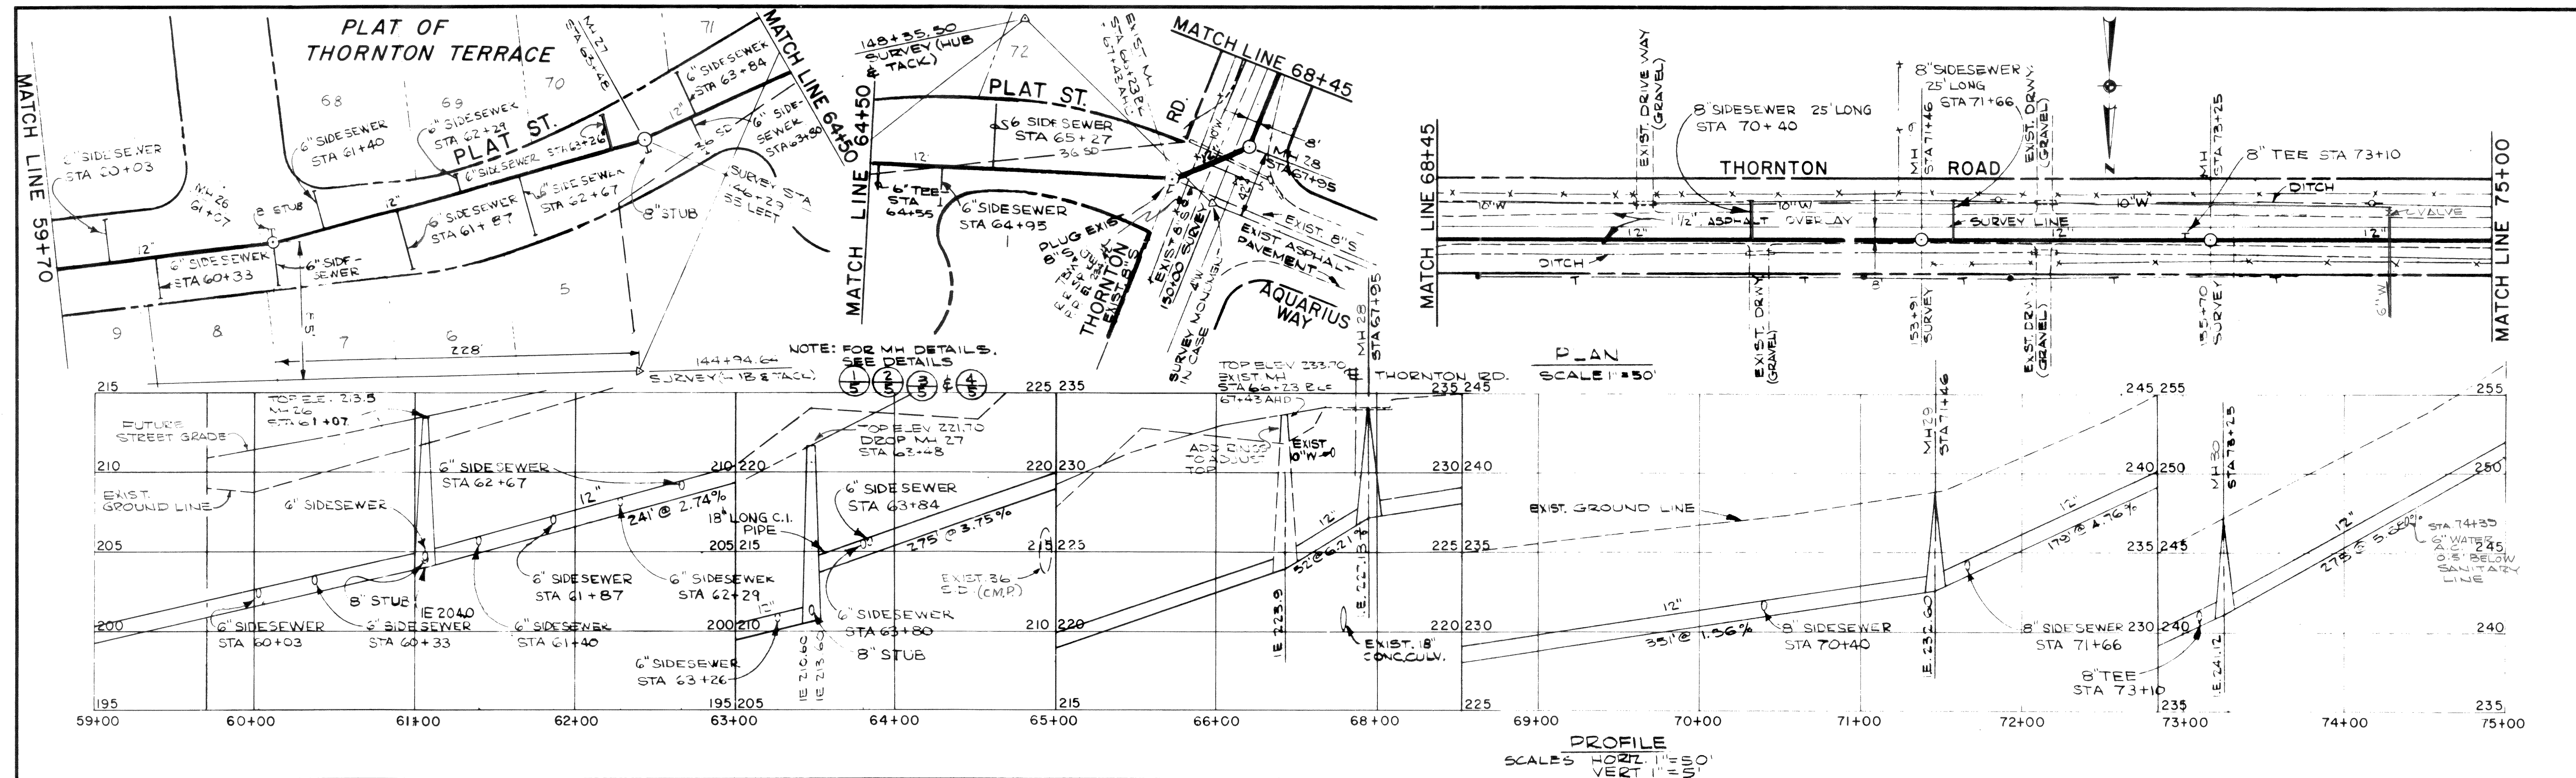

00219.DCS 2-7-06 AK

