
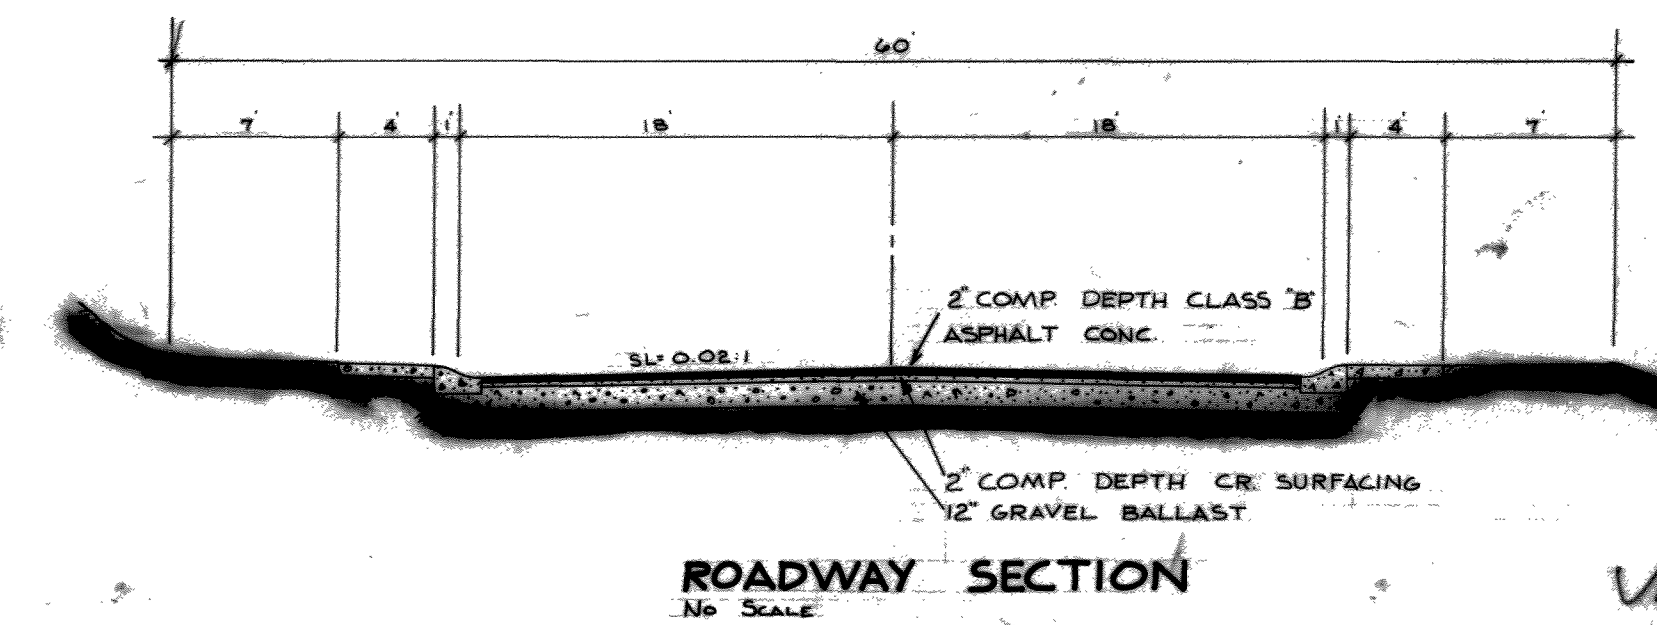
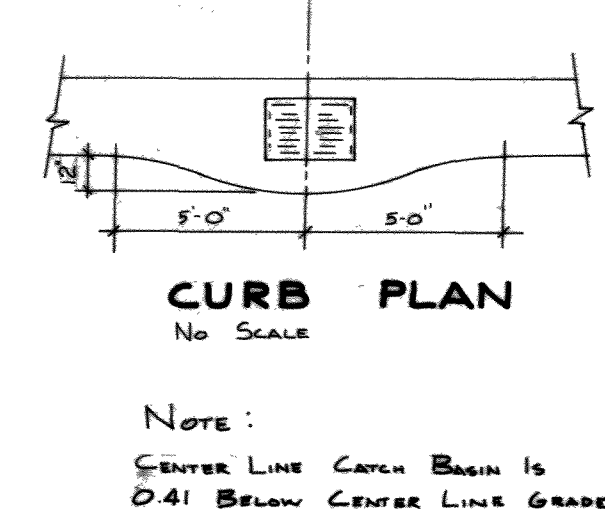
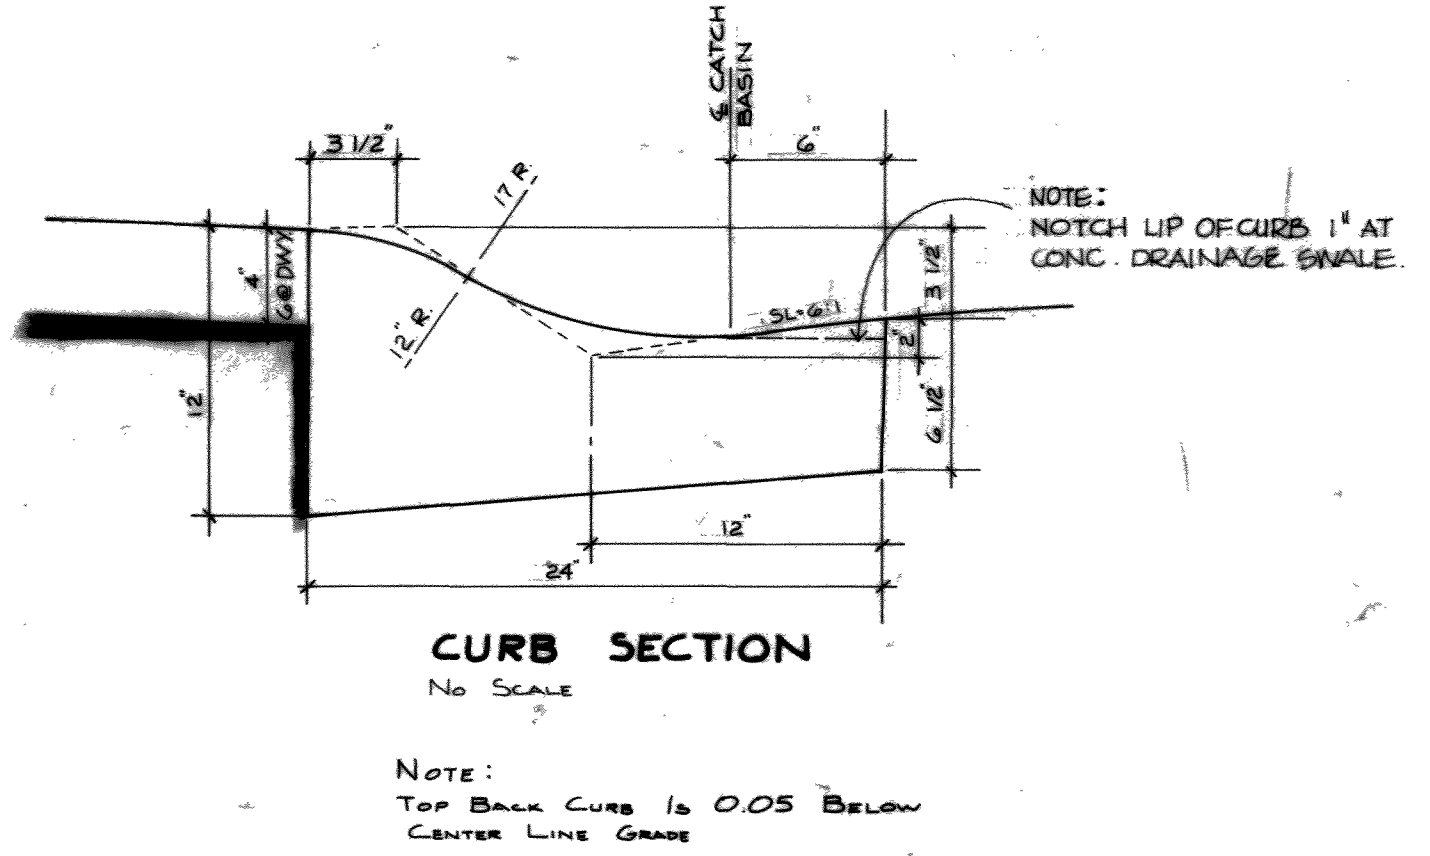
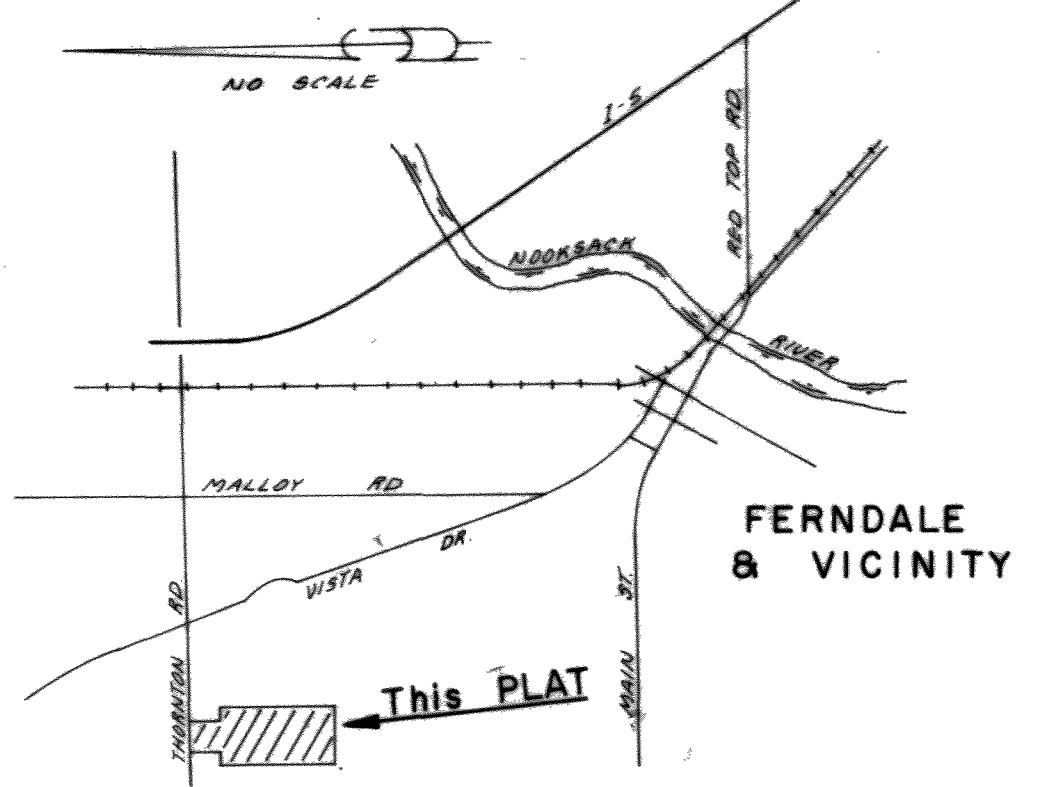


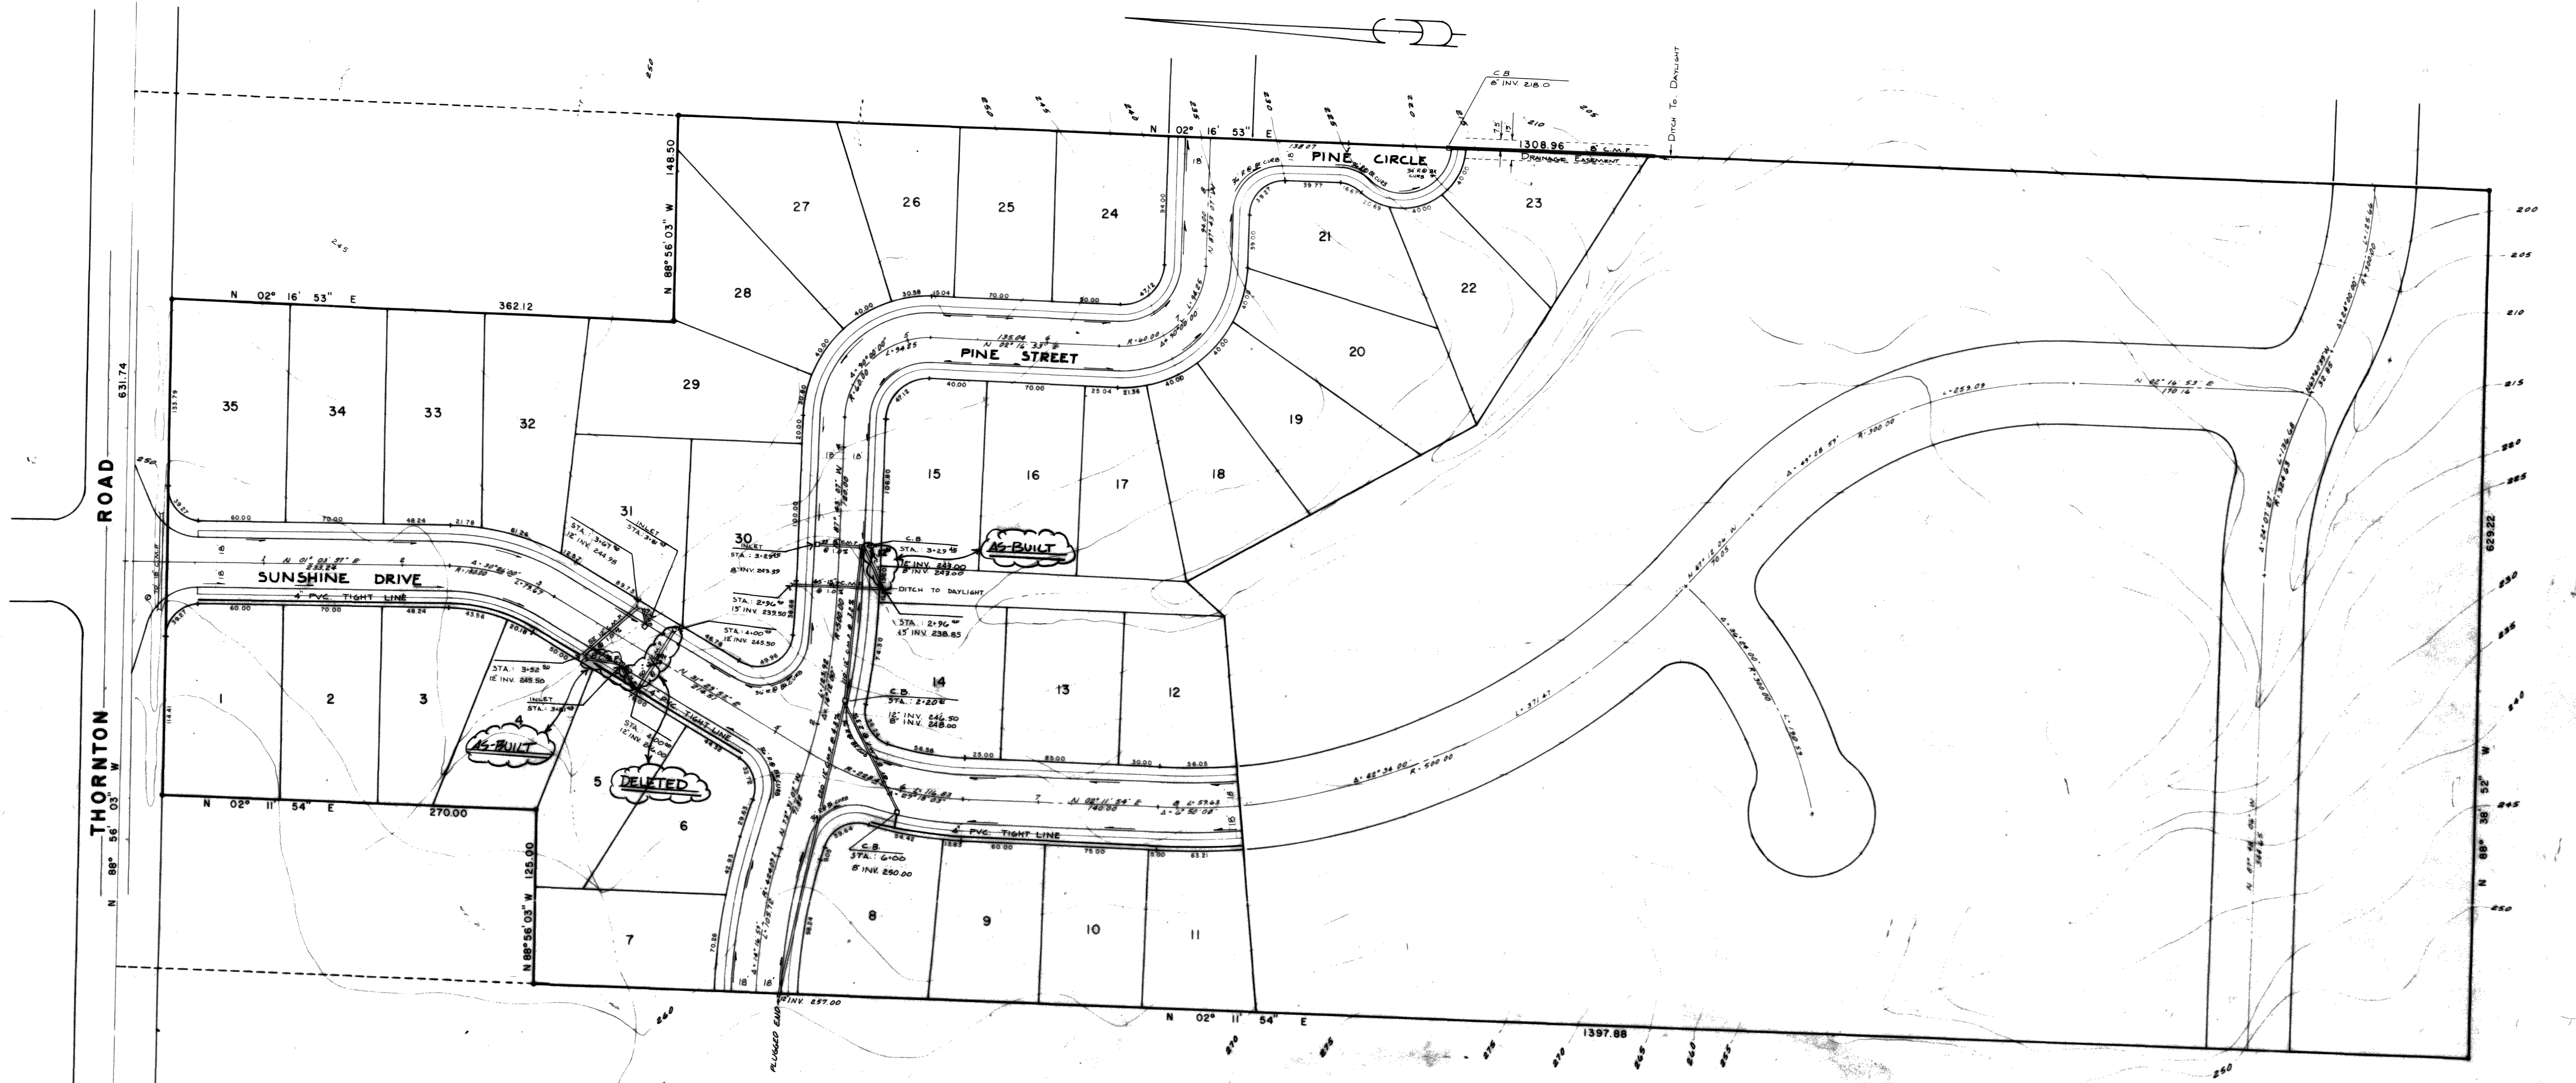

NORTHWEST CONSULTANTS
1310 Broadway, Suite 2-B, Bellingham, Washington 98225 (206-676-9058)


FERDALE DEVELOPMENT INC.

Scale: 1"=50' Date: _____
Drawn By: _____
Checked By: _____
Approved: _____


Revisions
1. AS-BUILT / JWP

SUNSHINE HEIGHTS DIV. I




ROADWAY & STORM DRAINAGE PLAN
Sheet 1 of 7

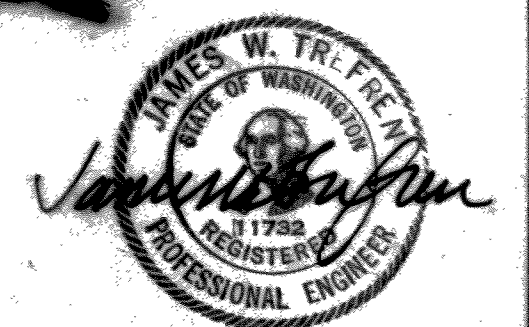

00236.001 2-16-06 KR

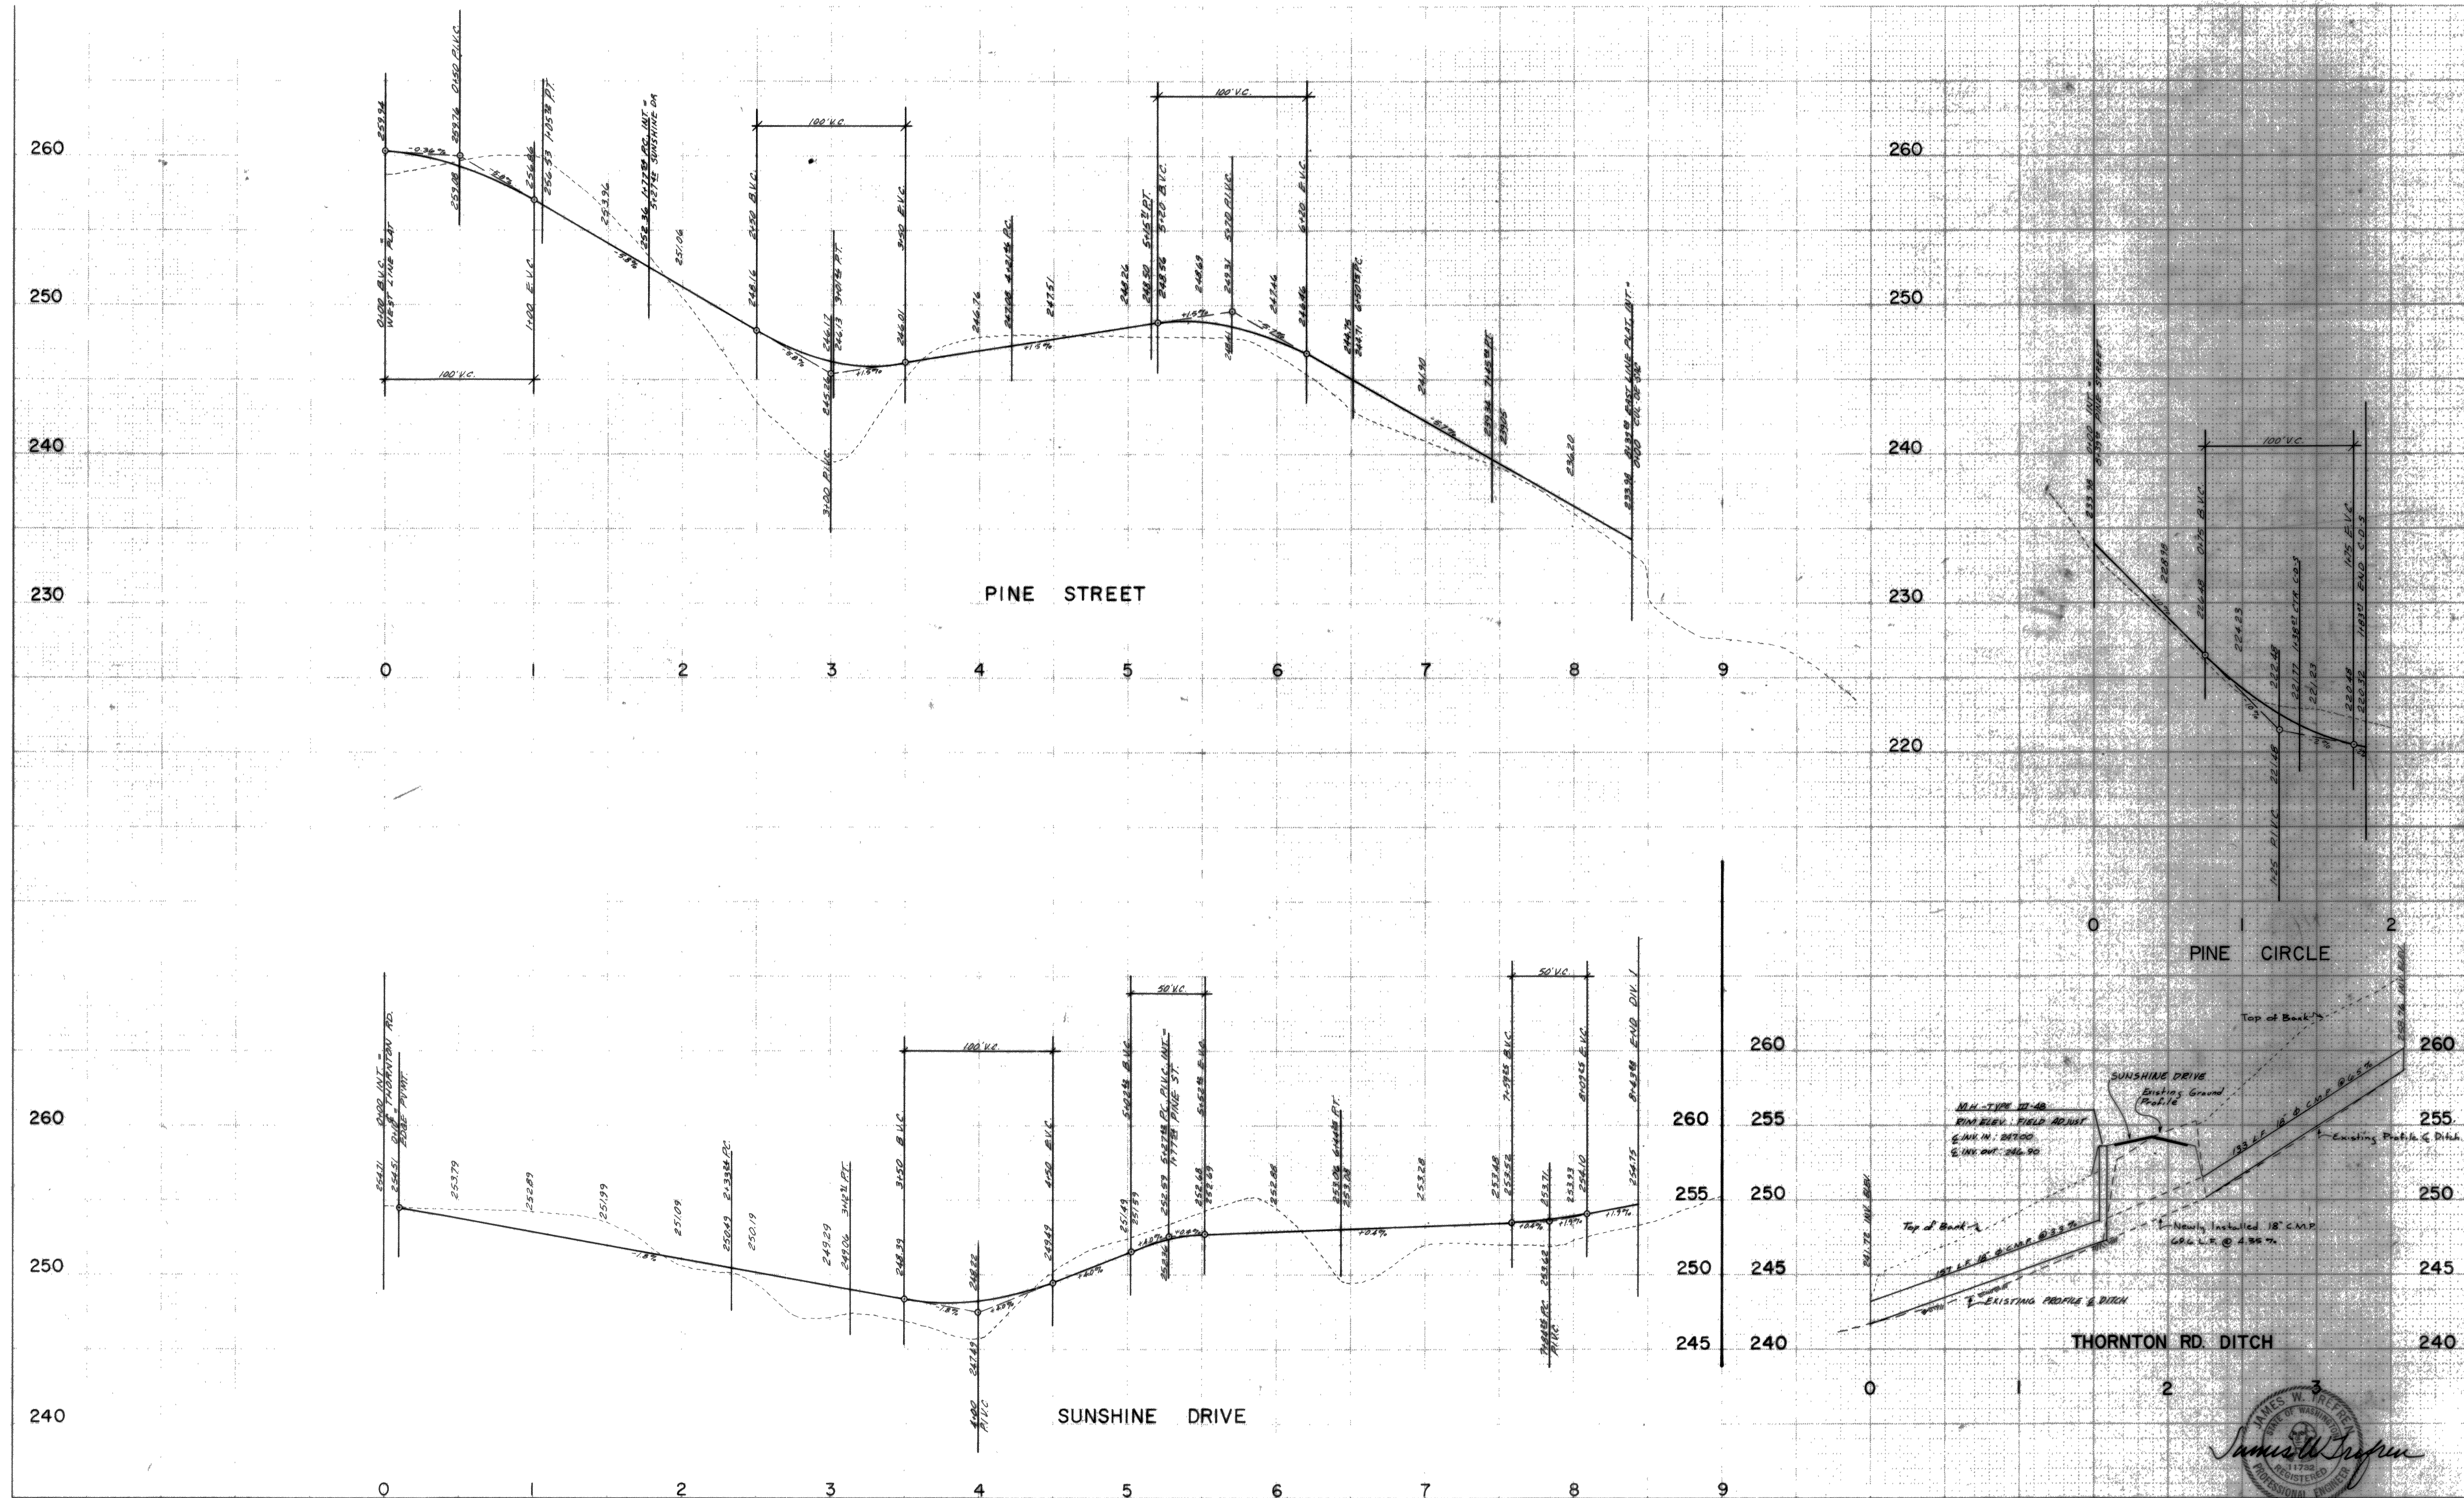

00230.003 2-16-00

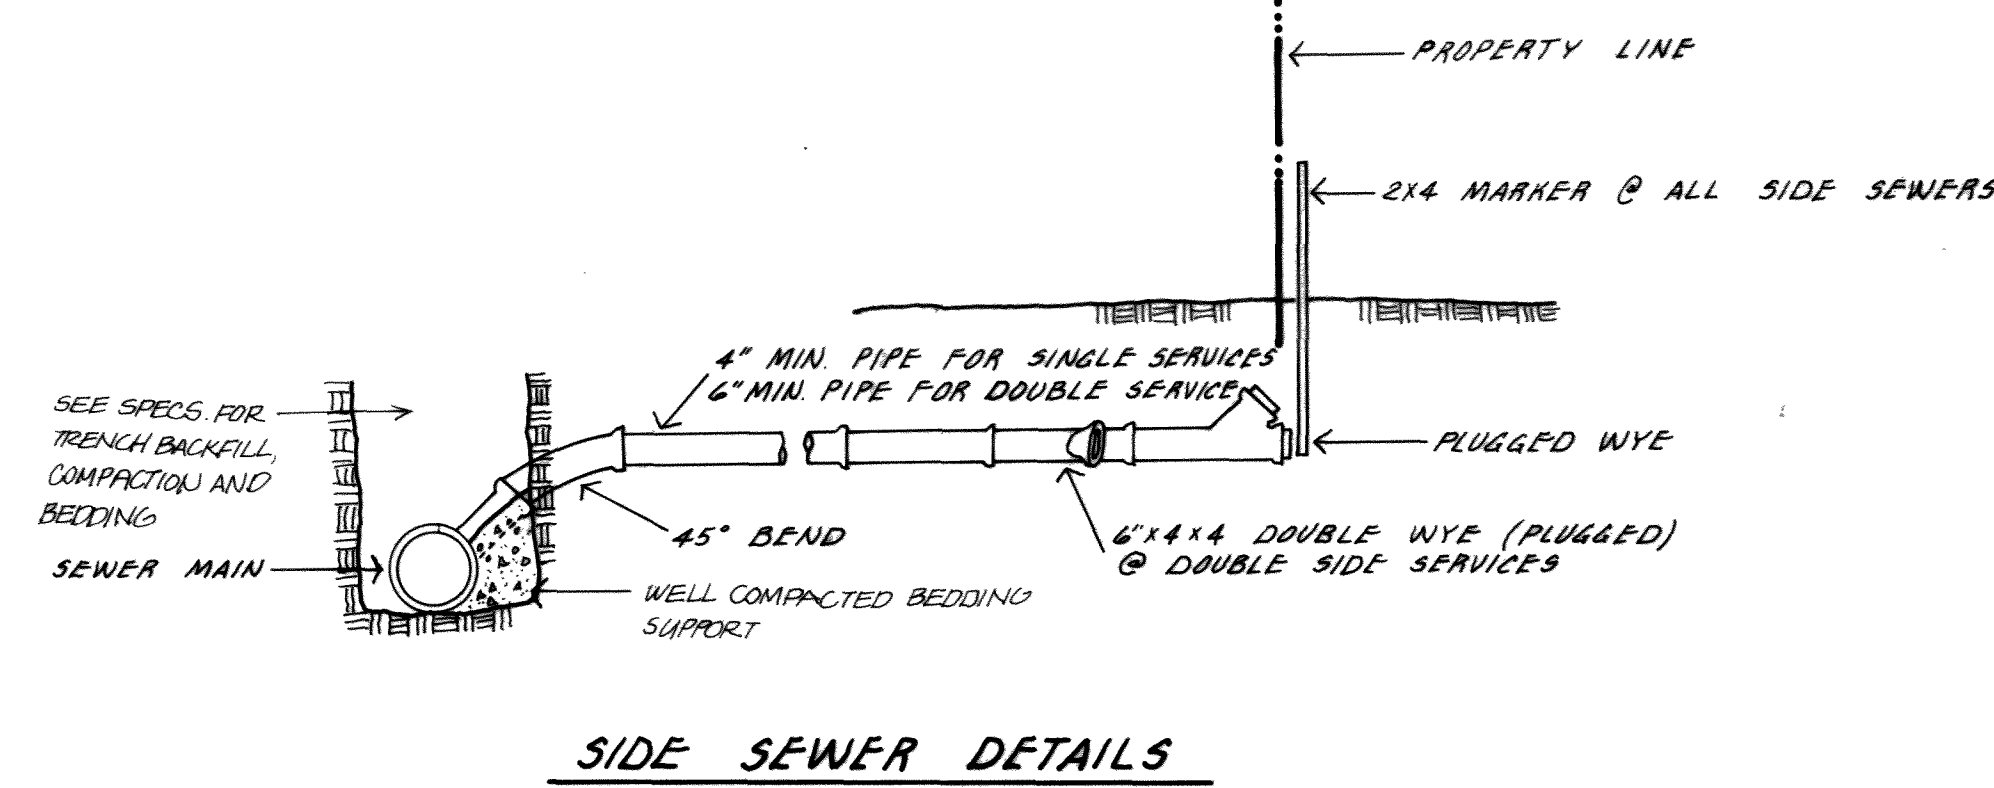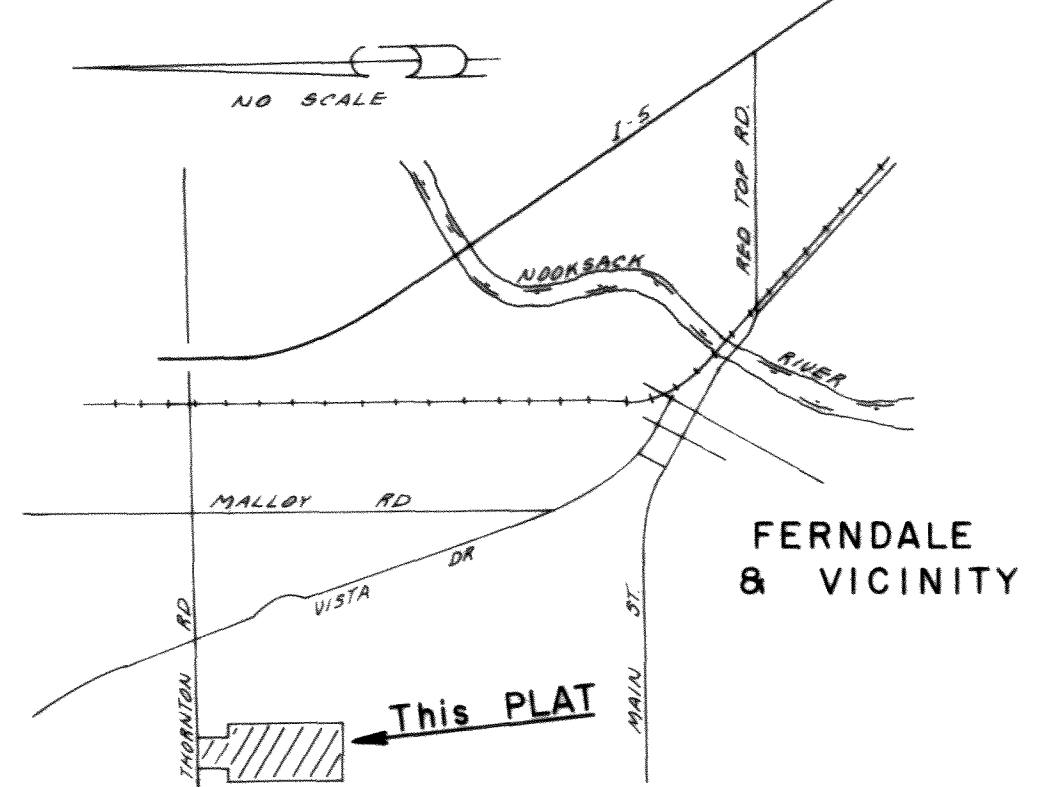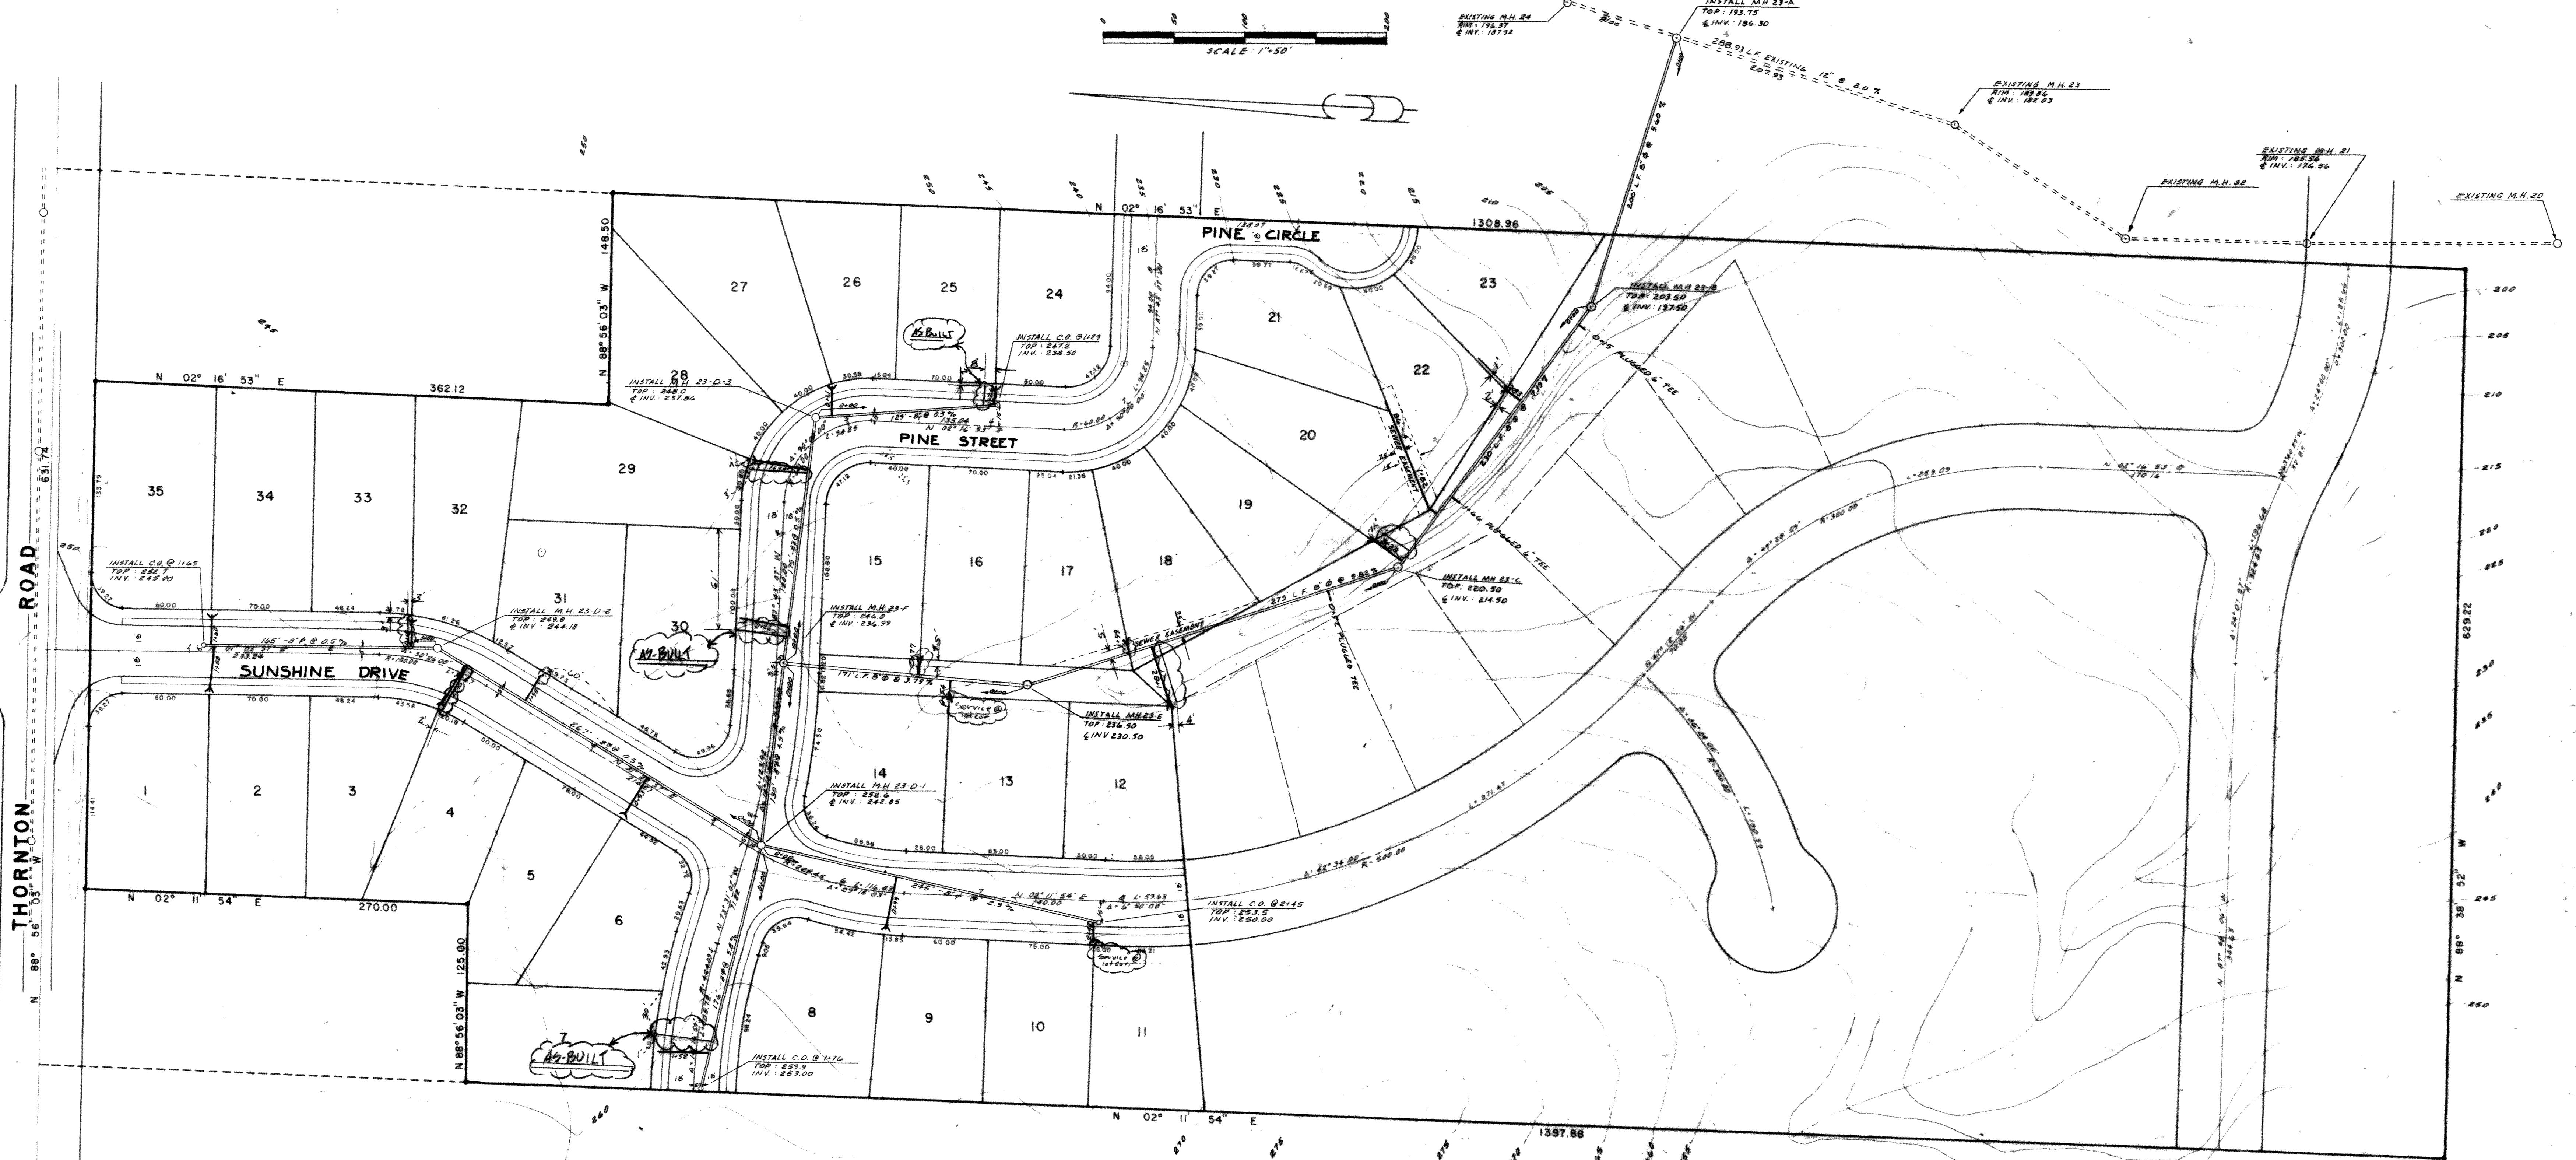

NORTHWEST CONSULTANTS
1310 Broadway, Suite 2-B, Bellingham, Washington 98225 (206-676-9058)

FERNDALE DEVELOPMENT INC.

Scale: 1"=50' Date: 06-13-76
Drawn By: JWS
Checked By: JWS
Approved: JWS

Revisions
1. M.H. 21-A, 21-B, 21-C, 21-D, 21-E, 21-F, 21-G, 21-H, 21-I, 21-J, 21-K, 21-L, 21-M, 21-N, 21-O, 21-P, 21-Q, 21-R, 21-S, 21-T, 21-U, 21-V, 21-W, 21-X, 21-Y, 21-Z, 21-AA, 21-AB, 21-AC, 21-AD, 21-AE, 21-AF, 21-AG, 21-AH, 21-AI, 21-AJ, 21-AL, 21-AM, 21-AN, 21-AO, 21-AP, 21-AQ, 21-AR, 21-AS, 21-AT, 21-AU, 21-AV, 21-AW, 21-AX, 21-AY, 21-AZ, 21-BA, 21-BB, 21-BC, 21-BD, 21-BE, 21-BF, 21-BG, 21-BH, 21-BI, 21-BJ, 21-BL, 21-BM, 21-BN, 21-BO, 21-BP, 21-BQ, 21-BR, 21-BS, 21-BT, 21-BU, 21-BV, 21-BW, 21-BX, 21-BY, 21-BZ, 21-CA, 21-CB, 21-CC, 21-CD, 21-CE, 21-CF, 21-CG, 21-CH, 21-CI, 21-CJ, 21-CL, 21-CM, 21-CN, 21-CO, 21-CP, 21-CQ, 21-CR, 21-CS, 21-CT, 21-CU, 21-CV, 21-CW, 21-CX, 21-CY, 21-CZ, 21-DA, 21-DB, 21-DC, 21-DD, 21-DE, 21-DF, 21-DG, 21-DH, 21-DI, 21-DJ, 21-DL, 21-DM, 21-DN, 21-DO, 21-DP, 21-DQ, 21-DR, 21-DS, 21-DT, 21-DU, 21-DV, 21-DW, 21-DX, 21-DY, 21-DZ, 21-EA, 21-EB, 21-EC, 21-ED, 21-EE, 21-EF, 21-EG, 21-EH, 21-EI, 21-EJ, 21-EL, 21-EM, 21-EN, 21-EO, 21-EP, 21-EQ, 21-ER, 21-ES, 21-ET, 21-EU, 21-EV, 21-EW, 21-EX, 21-EY, 21-EZ, 21-FA, 21-FB, 21-FC, 21-FD, 21-FE, 21-FG, 21-FH, 21-FI, 21-FJ, 21-FL, 21-FM, 21-FN, 21-FO, 21-FP, 21-FQ, 21-FR, 21-FS, 21-FT, 21-FU, 21-FV, 21-FW, 21-FX, 21-FY, 21-FZ, 21-GA, 21-GB, 21-GC, 21-GD, 21-GE, 21-GF, 21-GG, 21-GH, 21-GI, 21-GJ, 21-GL, 21-GM, 21-GN, 21-GO, 21-GP, 21-GQ, 21-GR, 21-GS, 21-GT, 21-GU, 21-GV, 21-GW, 21-GX, 21-GY, 21-GZ, 21-HA, 21-HB, 21-HC, 21-HD, 21-HE, 21-HF, 21-HG, 21-HH, 21-HI, 21-HJ, 21-HL, 21-HM, 21-HN, 21-HO, 21-HP, 21-HQ, 21-HR, 21-HS, 21-HT, 21-HU, 21-HV, 21-HW, 21-HX, 21-HY, 21-HZ, 21-IA, 21-IB, 21-IC, 21-ID, 21-IE, 21-IF, 21-IG, 21-IH, 21-II, 21-IJ, 21-IL, 21-IM, 21-IN, 21-IO, 21-IP, 21-IQ, 21-IR, 21-IS, 21-IT, 21-IU, 21-IV, 21-IW, 21-IX, 21-IY, 21-IZ, 21-JA, 21-JB, 21-JC, 21-JD, 21-JE, 21-JF, 21-JG, 21-JH, 21-JI, 21-JJ, 21-JL, 21-JM, 21-JN, 21-JO, 21-JP, 21-JQ, 21-JR, 21-JS, 21-JT, 21-JU, 21-JV, 21-JW, 21-JX, 21-JY, 21-JZ, 21-KA, 21-KB, 21-KC, 21-KD, 21-KE, 21-KF, 21-KG, 21-KH, 21-KI, 21-KJ, 21-KL, 21-KM, 21-KN, 21-KO, 21-KP, 21-KQ, 21-KR, 21-KS, 21-KT, 21-KU, 21-KV, 21-KW, 21-KX, 21-KY, 21-KZ, 21-LA, 21-LB, 21-LC, 21-LD, 21-LE, 21-LF, 21-LG, 21-LH, 21-LI, 21-LJ, 21-LK, 21-LM, 21-LN, 21-LO, 21-LP, 21-LQ, 21-LR, 21-LS, 21-LT, 21-LU, 21-LV, 21-LW, 21-LX, 21-LY, 21-LZ, 21-MA, 21-MB, 21-MC, 21-MD, 21-ME, 21-MF, 21-MG, 21-MH, 21-MI, 21-MJ, 21-MK, 21-ML, 21-MN, 21-MO, 21-MP, 21-MQ, 21-MR, 21-MS, 21-MT, 21-MU, 21-MV, 21-MW, 21-MX, 21-MY, 21-MZ, 21-NA, 21-NB, 21-NC, 21-ND, 21-NE, 21-NF, 21-NG, 21-NH, 21-NI, 21-NJ, 21-NK, 21-NL, 21-NM, 21-NO, 21-NP, 21-NQ, 21-NR, 21-NS, 21-NT, 21-NU, 21-NV, 21-NW, 21-NX, 21-NY, 21-NZ, 21-OA, 21-OB, 21-OC, 21-OD, 21-OE, 21-OF, 21-OG, 21-OH, 21-OI, 21-OJ, 21-OK, 21-OL, 21-OM, 21-ON, 21-OO, 21-OP, 21-OQ, 21-OR, 21-OS, 21-OT, 21-OU, 21-OV, 21-OW, 21-OX, 21-OY, 21-OZ, 21-PA, 21-PB, 21-PC, 21-PD, 21-PE, 21-PF, 21-PG, 21-PH, 21-PI, 21-PJ, 21-PK, 21-PL, 21-PM, 21-PN, 21-PO, 21-PP, 21-PQ, 21-PR, 21-PS, 21-PT, 21-PU, 21-PV, 21-PW, 21-PX, 21-PY, 21-PZ, 21-QA, 21-QB, 21-QC, 21-QD, 21-QE, 21-QF, 21-QG, 21-QH, 21-QI, 21-QJ, 21-QL, 21-QM, 21-QN, 21-QO, 21-QP, 21-QQ, 21-QR, 21-QS, 21-QT, 21-QU, 21-QV, 21-QW, 21-QX, 21-QY, 21-QZ, 21-RA, 21-RB, 21-RC, 21-RD, 21-RE, 21-RF, 21-RG, 21-RH, 21-RI, 21-RJ, 21-RK, 21-RL, 21-RM, 21-RN, 21-RO, 21-RP, 21-RQ, 21-RR, 21-RS, 21-RT, 21-RU, 21-RV, 21-RW, 21-RX, 21-RY, 21-RZ, 21-SA, 21-SB, 21-SC, 21-SD, 21-SE, 21-SF, 21-SG, 21-SH, 21-SI, 21-SJ, 21-SK, 21-SL, 21-SM, 21-SN, 21-SO, 21-SP, 21-SQ, 21-SR, 21-SS, 21-ST, 21-SU, 21-SV, 21-SW, 21-SX, 21-SY, 21-SZ, 21-TA, 21-TB, 21-TC, 21-TD, 21-TE, 21-TF, 21-TG, 21-TH, 21-TI, 21-TJ, 21-TK, 21-TL, 21-TM, 21-TN, 21-TO, 21-TP, 21-TQ, 21-TR, 21-TS, 21-TT, 21-TU, 21-TV, 21-TW, 21-TX, 21-TY, 21-TZ, 21-UA, 21-UB, 21-UC, 21-UD, 21-UE, 21-UF, 21-UG, 21-UH, 21-UI, 21-UJ, 21-UK, 21-UL, 21-UM, 21-UN, 21-UO, 21-UP, 21-UQ, 21-UR, 21-US, 21-UT, 21-UT, 21-UV, 21-UW, 21-UX, 21-UY, 21-UZ, 21-VA, 21-VB, 21-VC, 21-VD, 21-VE, 21-VF, 21-VG, 21-VH, 21-VI, 21-VJ, 21-VK, 21-VL, 21-VM, 21-VN, 21-VO, 21-VP, 21-VQ, 21-VR, 21-VS, 21-VT, 21-VU, 21-VV, 21-VW, 21-VX, 21-VY, 21-VZ, 21-WA, 21-WB, 21-WC, 21-WD, 21-WE, 21-WF, 21-WG, 21-WH, 21-WI, 21-WJ, 21-WK, 21-WL, 21-WM, 21-WN, 21-WO, 21-WP, 21-WQ, 21-WR, 21-WS, 21-WT, 21-WU, 21-WV, 21-WW, 21-WX, 21-WY, 21-WZ, 21-XA, 21-XB, 21-XC, 21-XD, 21-XE, 21-XF, 21-XG, 21-XH, 21-XI, 21-XJ, 21-XK, 21-XL, 21-XM, 21-XN, 21-XO, 21-XP, 21-XQ, 21-XR, 21-XS, 21-XT, 21-XU, 21-XV, 21-XW, 21-XX, 21-XY, 21-XZ, 21-YA, 21-YB, 21-YC, 21-YD, 21-YE, 21-YF, 21-YG, 21-YH, 21-YI, 21-YJ, 21-YK, 21-YL, 21-YM, 21-YN, 21-YO, 21-YP, 21-YQ, 21-YR, 21-YS, 21-YT, 21-YU, 21-YV, 21-YW, 21-YX, 21-YY, 21-YZ, 21-ZA, 21-ZB, 21-ZC, 21-ZD, 21-ZE, 21-ZF, 21-ZG, 21-ZH, 21-ZI, 21-ZJ, 21-ZK, 21-ZL, 21-ZM, 21-ZN, 21-ZO, 21-ZP, 21-ZQ, 21-ZR, 21-ZS, 21-ZT, 21-ZU, 21-ZV, 21-ZW, 21-ZX, 21-ZY, 21-ZZ





SUNSHINE HEIGHTS DIV. I

SANITARY SEWER PLAN

JAMES W. TREMPER
STATE OF WASHINGTON
REGISTERED
PROFESSIONAL ENGINEER
11752

Sheet 3 of 7

00226.004 2.16.06 JL

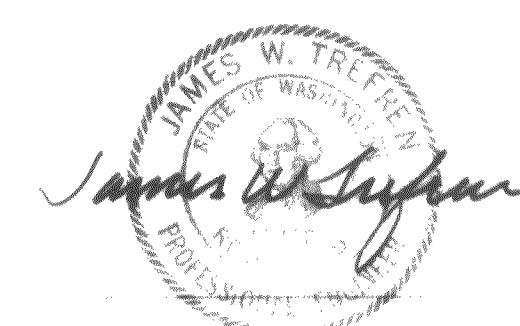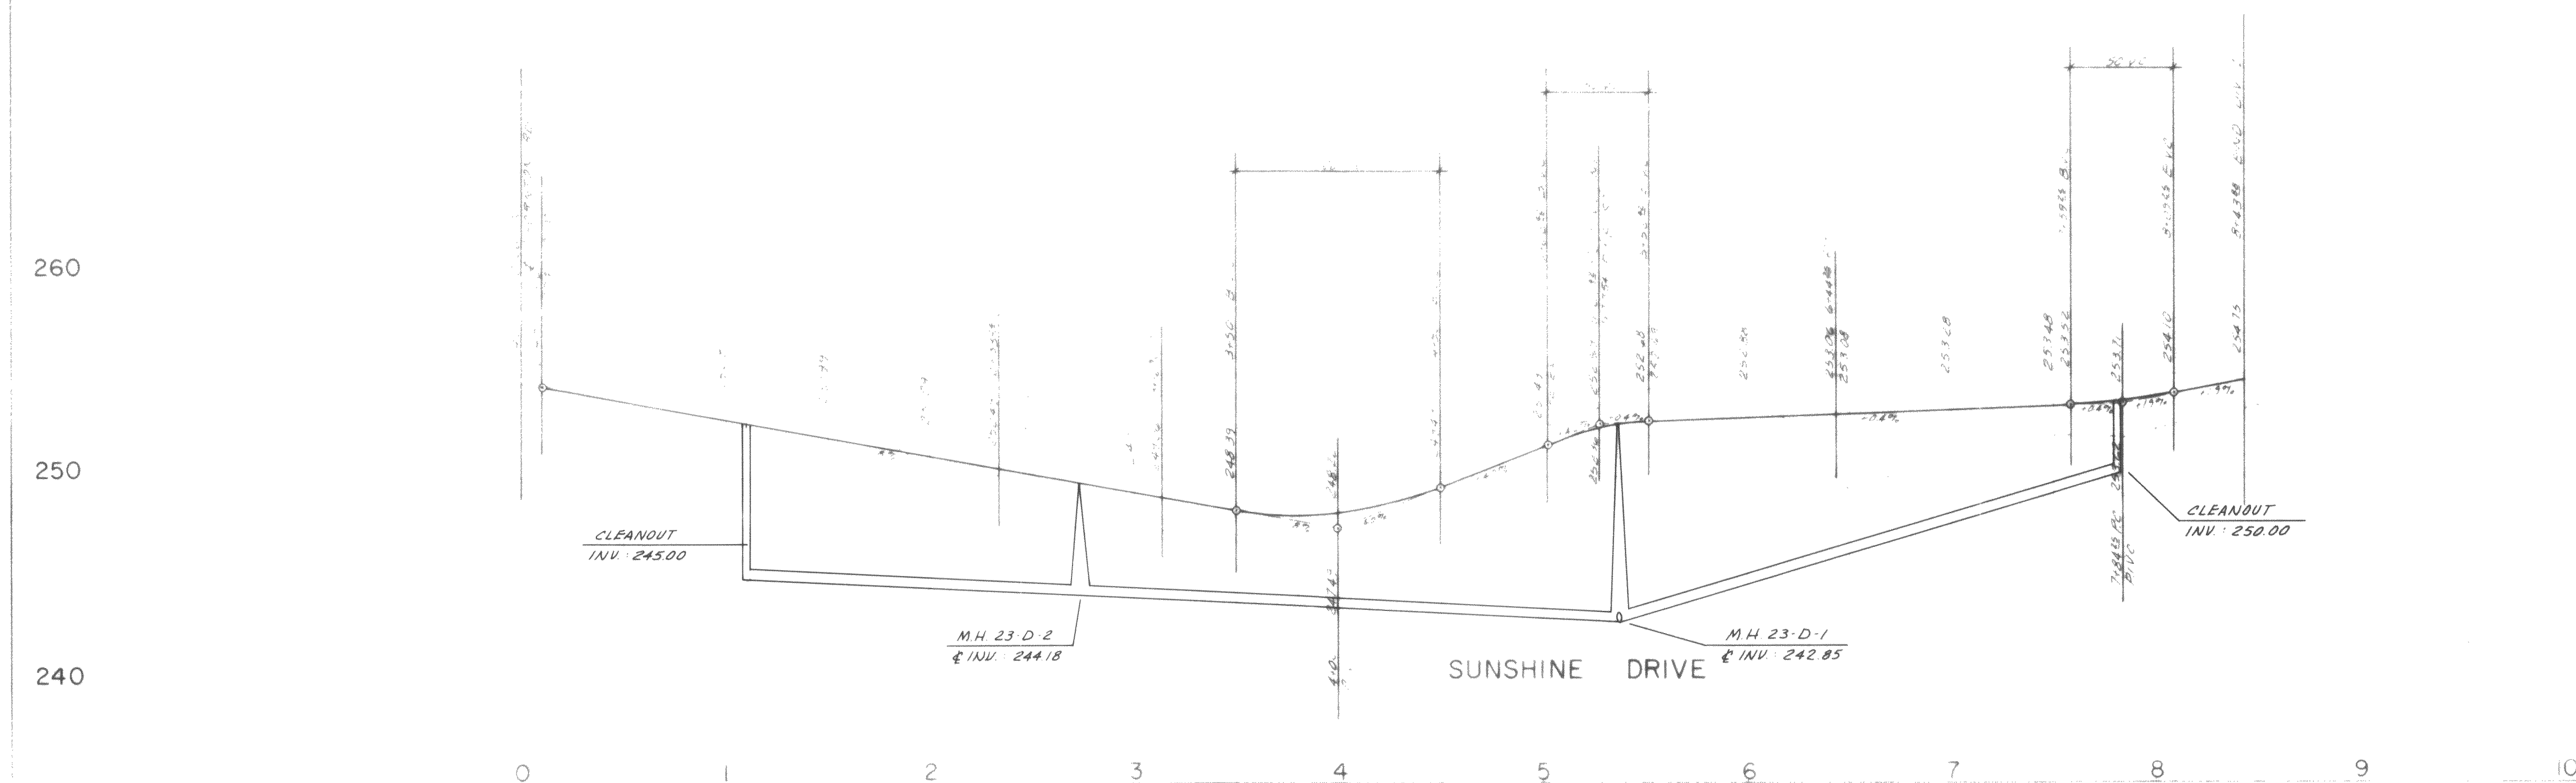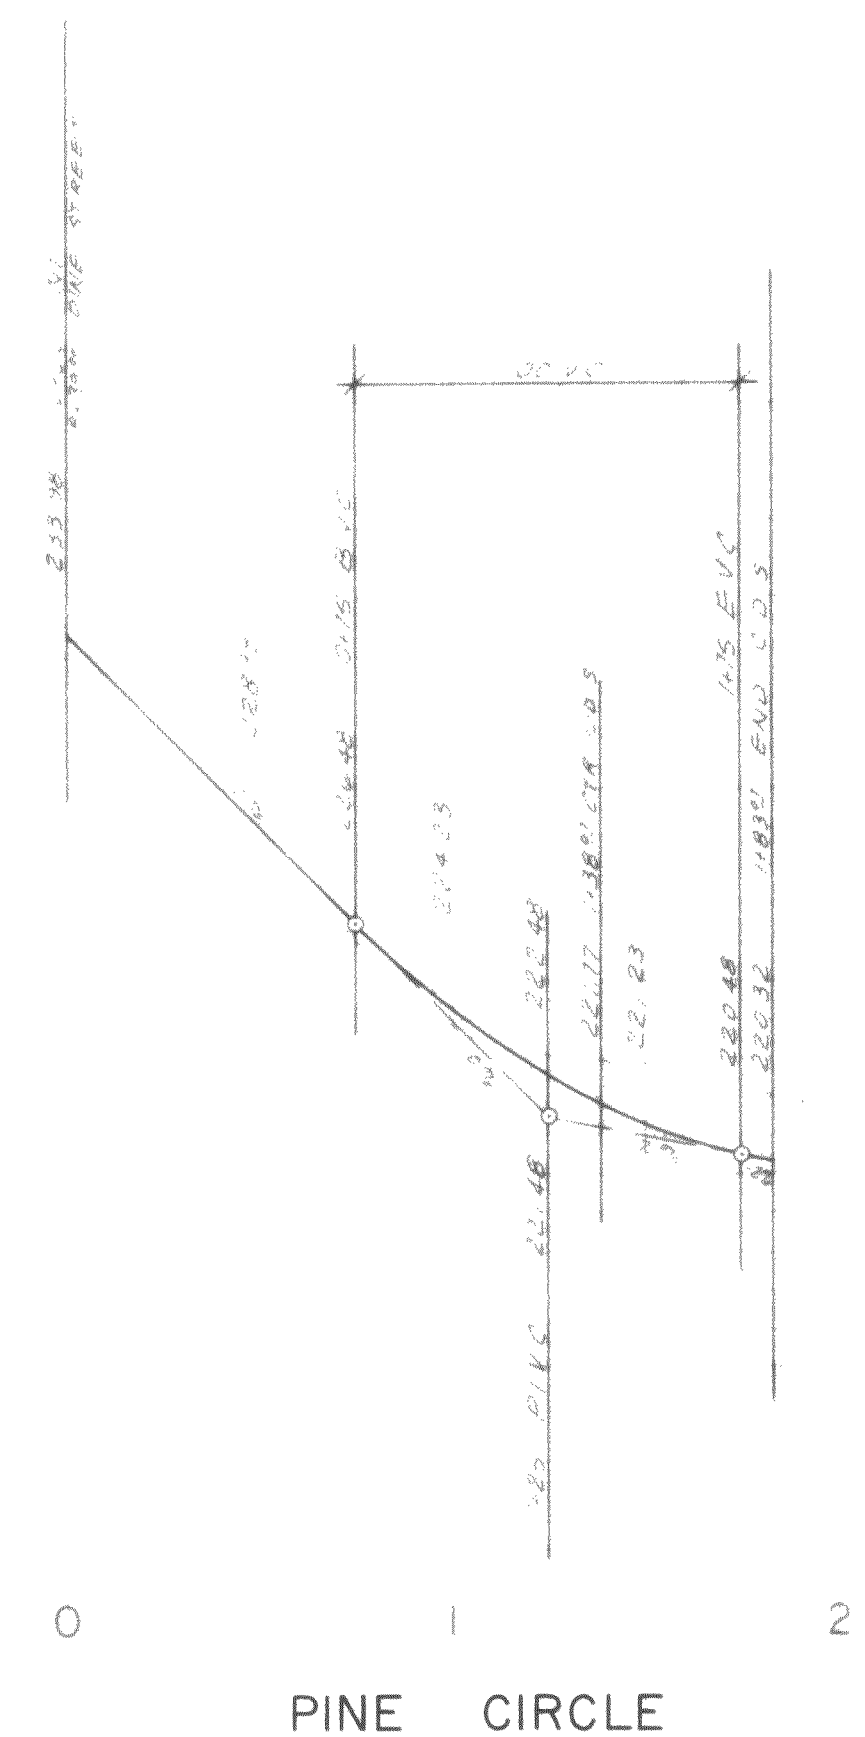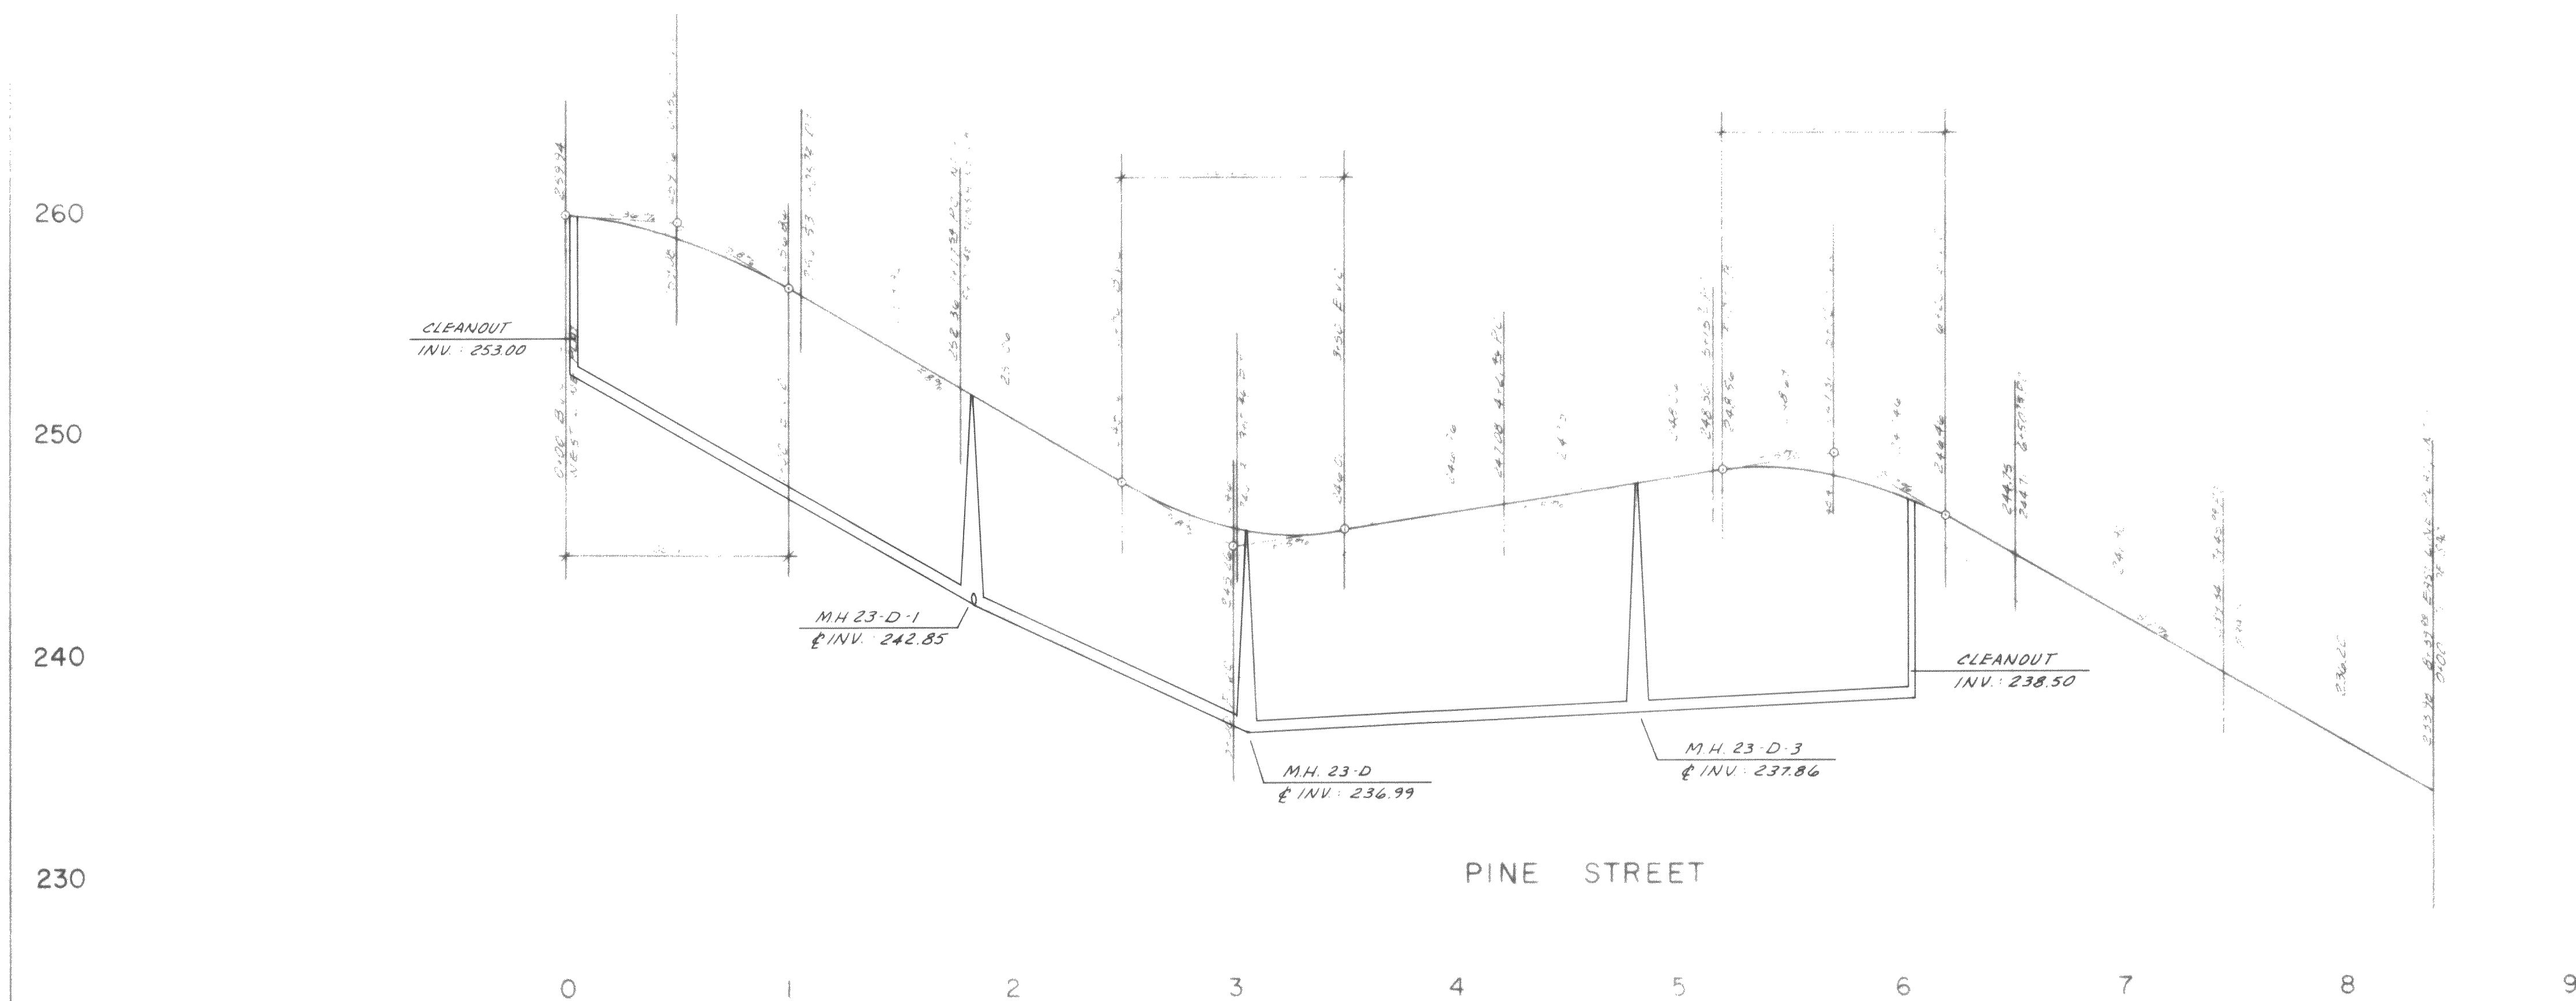

NORTHWEST CONSULTANTS
1310 Broadway, Suite 2-B, Bellingham, Washington 98225 (206-676-9058)

FERNDALE DEVELOPMENT INC.

10/1/04
10/1/04
10/1/04

SUNSHINE HEIGHTS DIV. I







SANITARY SEWER PROFILES

Sheet
4
of
7

LEGEND - WATER SYSTEM

- WATER MAIN
- FIRE HYDRANT
- BLOWOFF
- GATE VALVE
- TEE WITH BLOCKING
- WATER SERVICES (DOUBLE & SINGLE)

SCALE 1"=50'

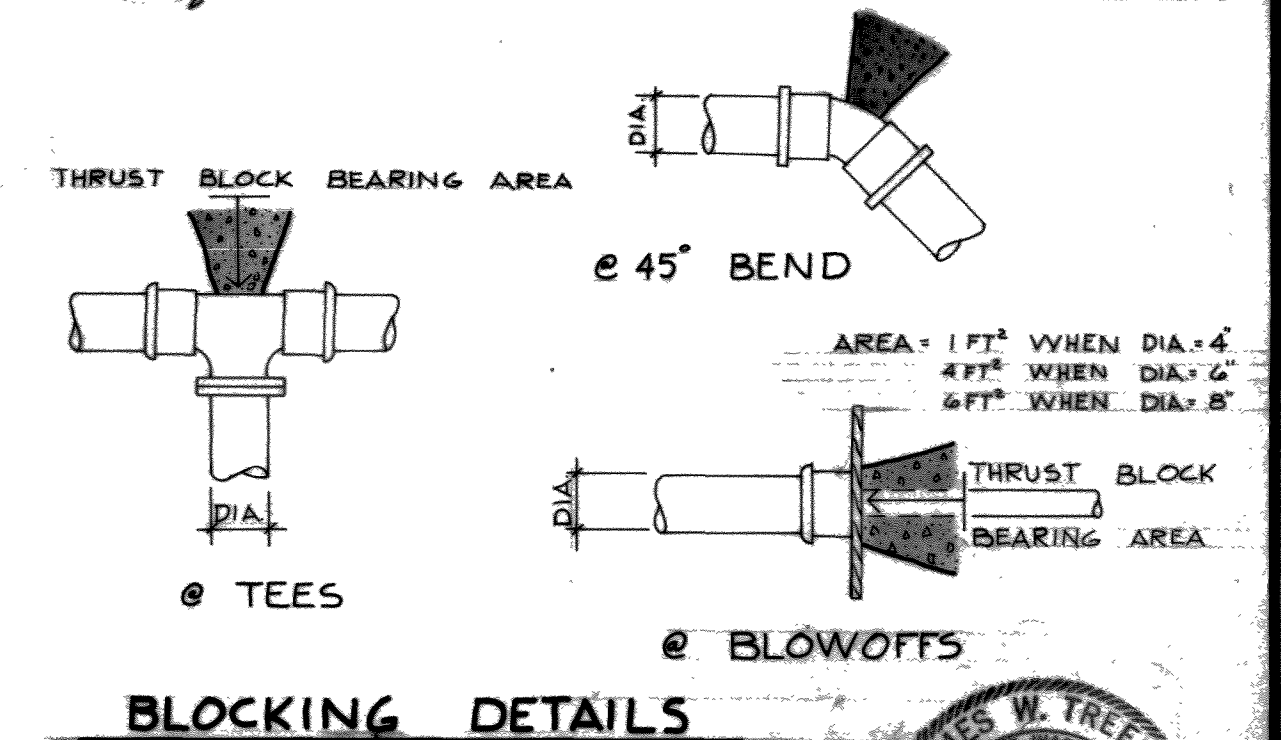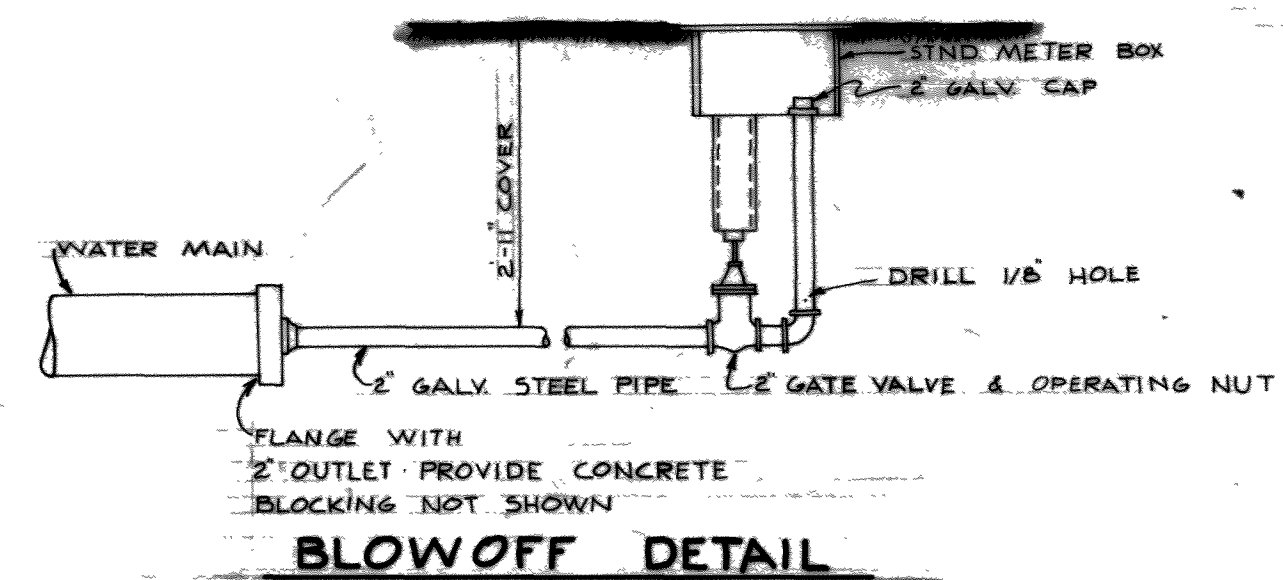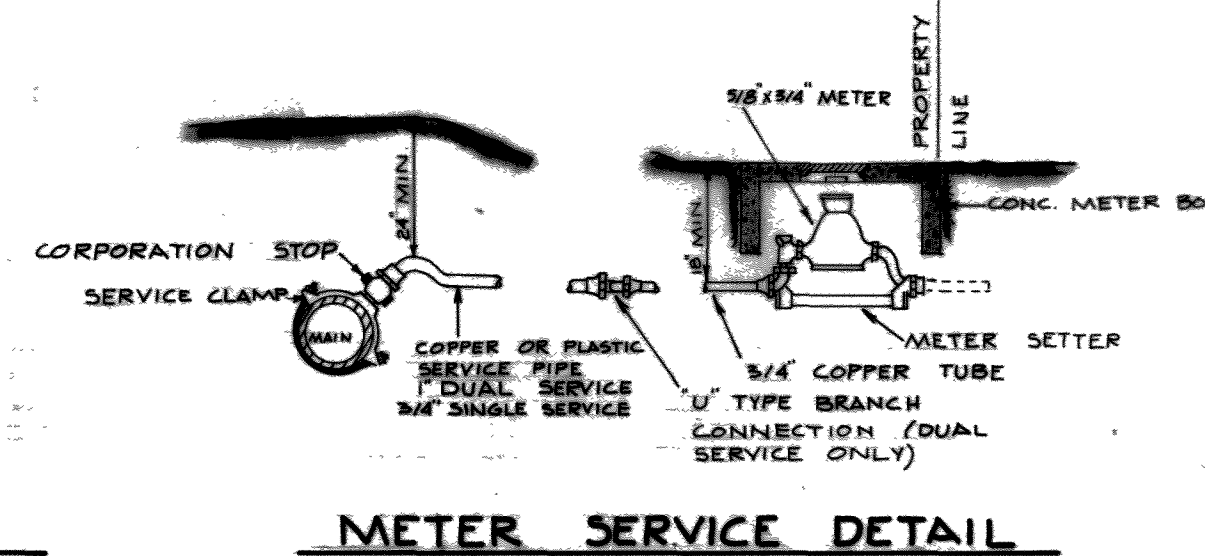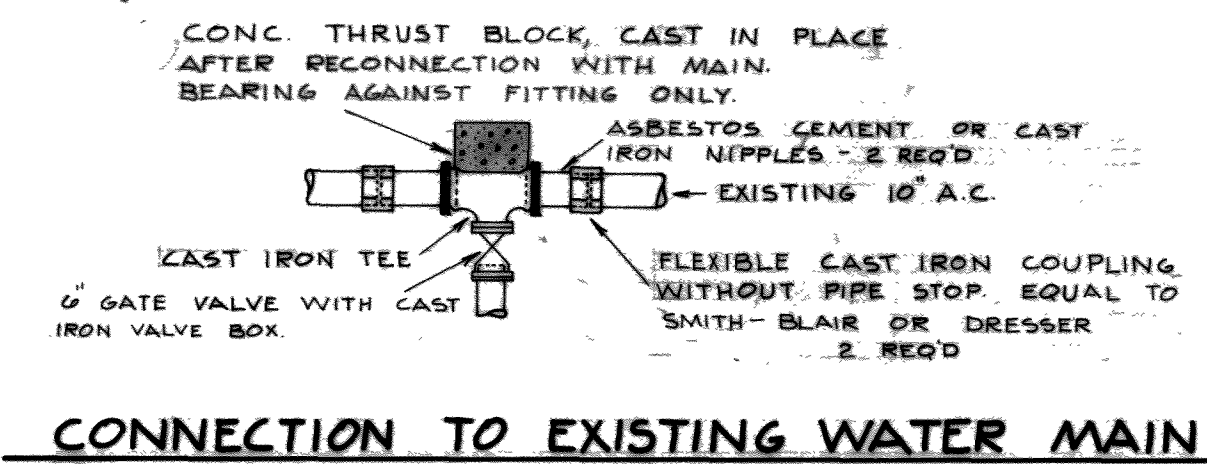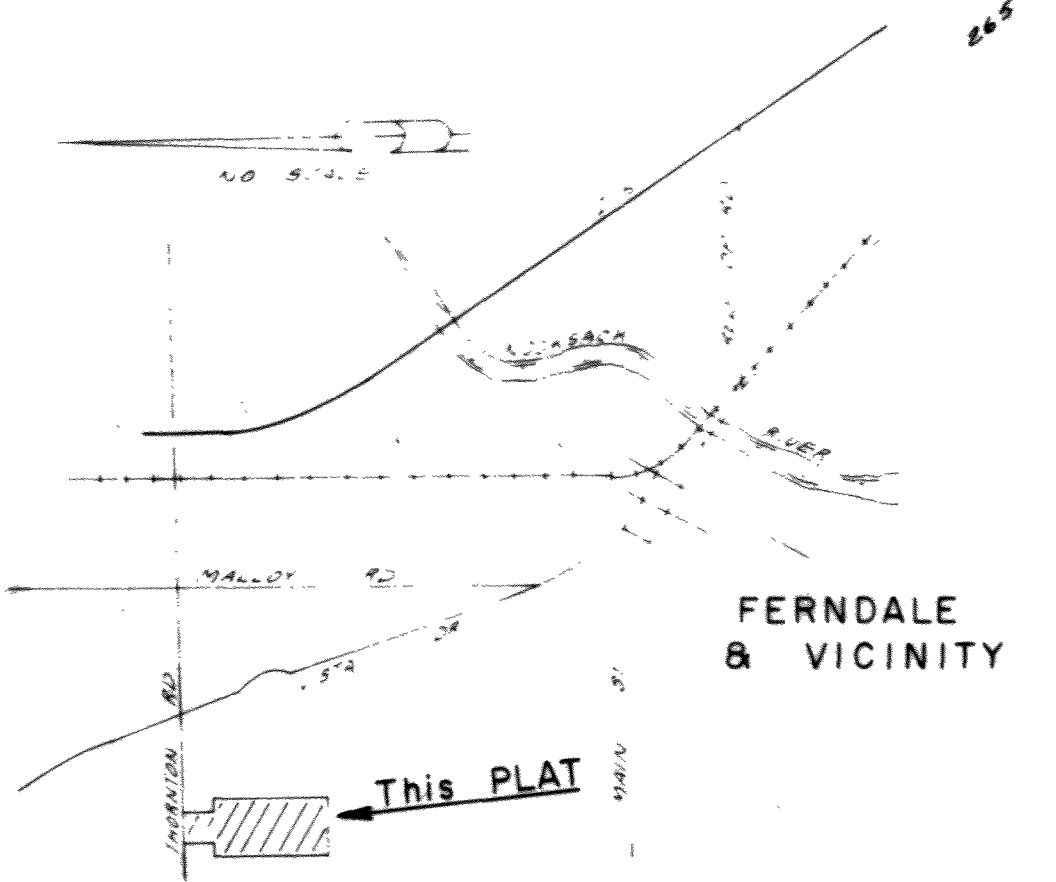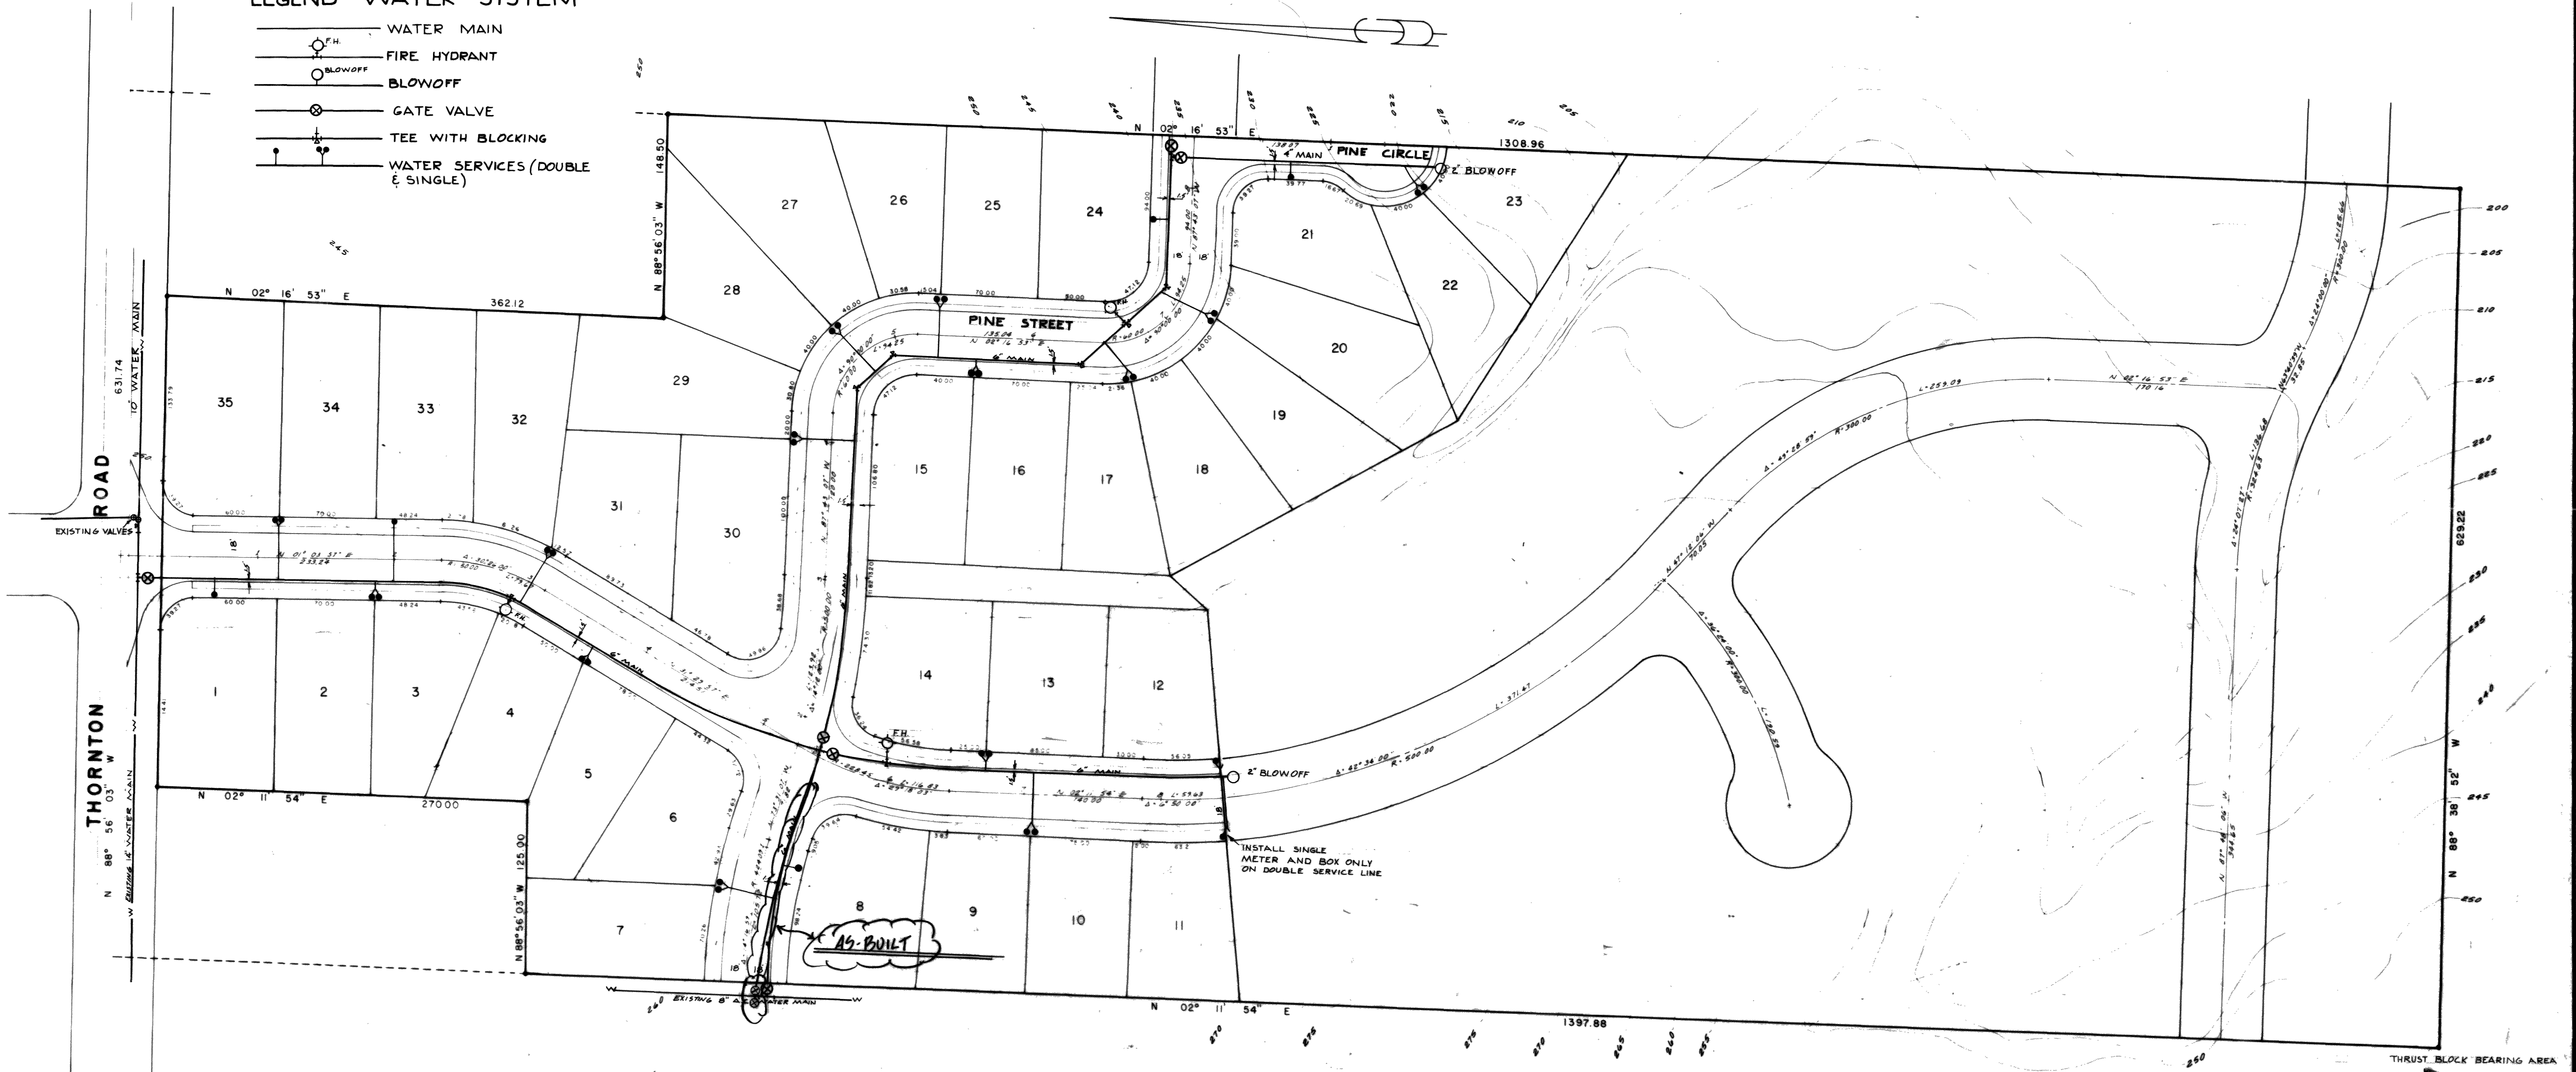

NORTHWEST CONSULTANTS
1310 Broadway, Suite 2-B, Bellingham, Washington 98225 (206-676-9058)

FERDALE DEVELOPMENT INC.

Scale: 1"=50' Date: _____
Drawn By: _____
Checked By: _____
Approved: _____

AS-BUILT 11/1/76

SUNSHINE HEIGHTS DIV. I

WATER DISTRIBUTION SYSTEM

