

TOWN OF FERNDALE, WASHINGTON

WPC - WN-264

RECEIVED

APR 15 1969

SEWAGE SYSTEM IMPROVEMENTS
INTERCEPTOR SEWERS
SCHEDULE II

APPROVED
John L. Anguish
WASHINGTON WATER
POLLUTION
CONTROL COMMISSION
5/6/69

U. S. DEPARTMENT OF THE INTERIOR
FEDERAL WATER POLLUTION
CONTROL ADMINISTRATION
APPROVED
Ray Ellman MAY 14 1969
CHIEF, CONSTRUCTION GRANTS PROGRAM

STEVENS, THOMPSON & RUNYAN, INC.


Engineers / Planners

SEATTLE, WASHINGTON

PORTLAND, OREGON

RECEIVED
MAY 16 1969
FWPCA

00211.001 2-7-05 R2

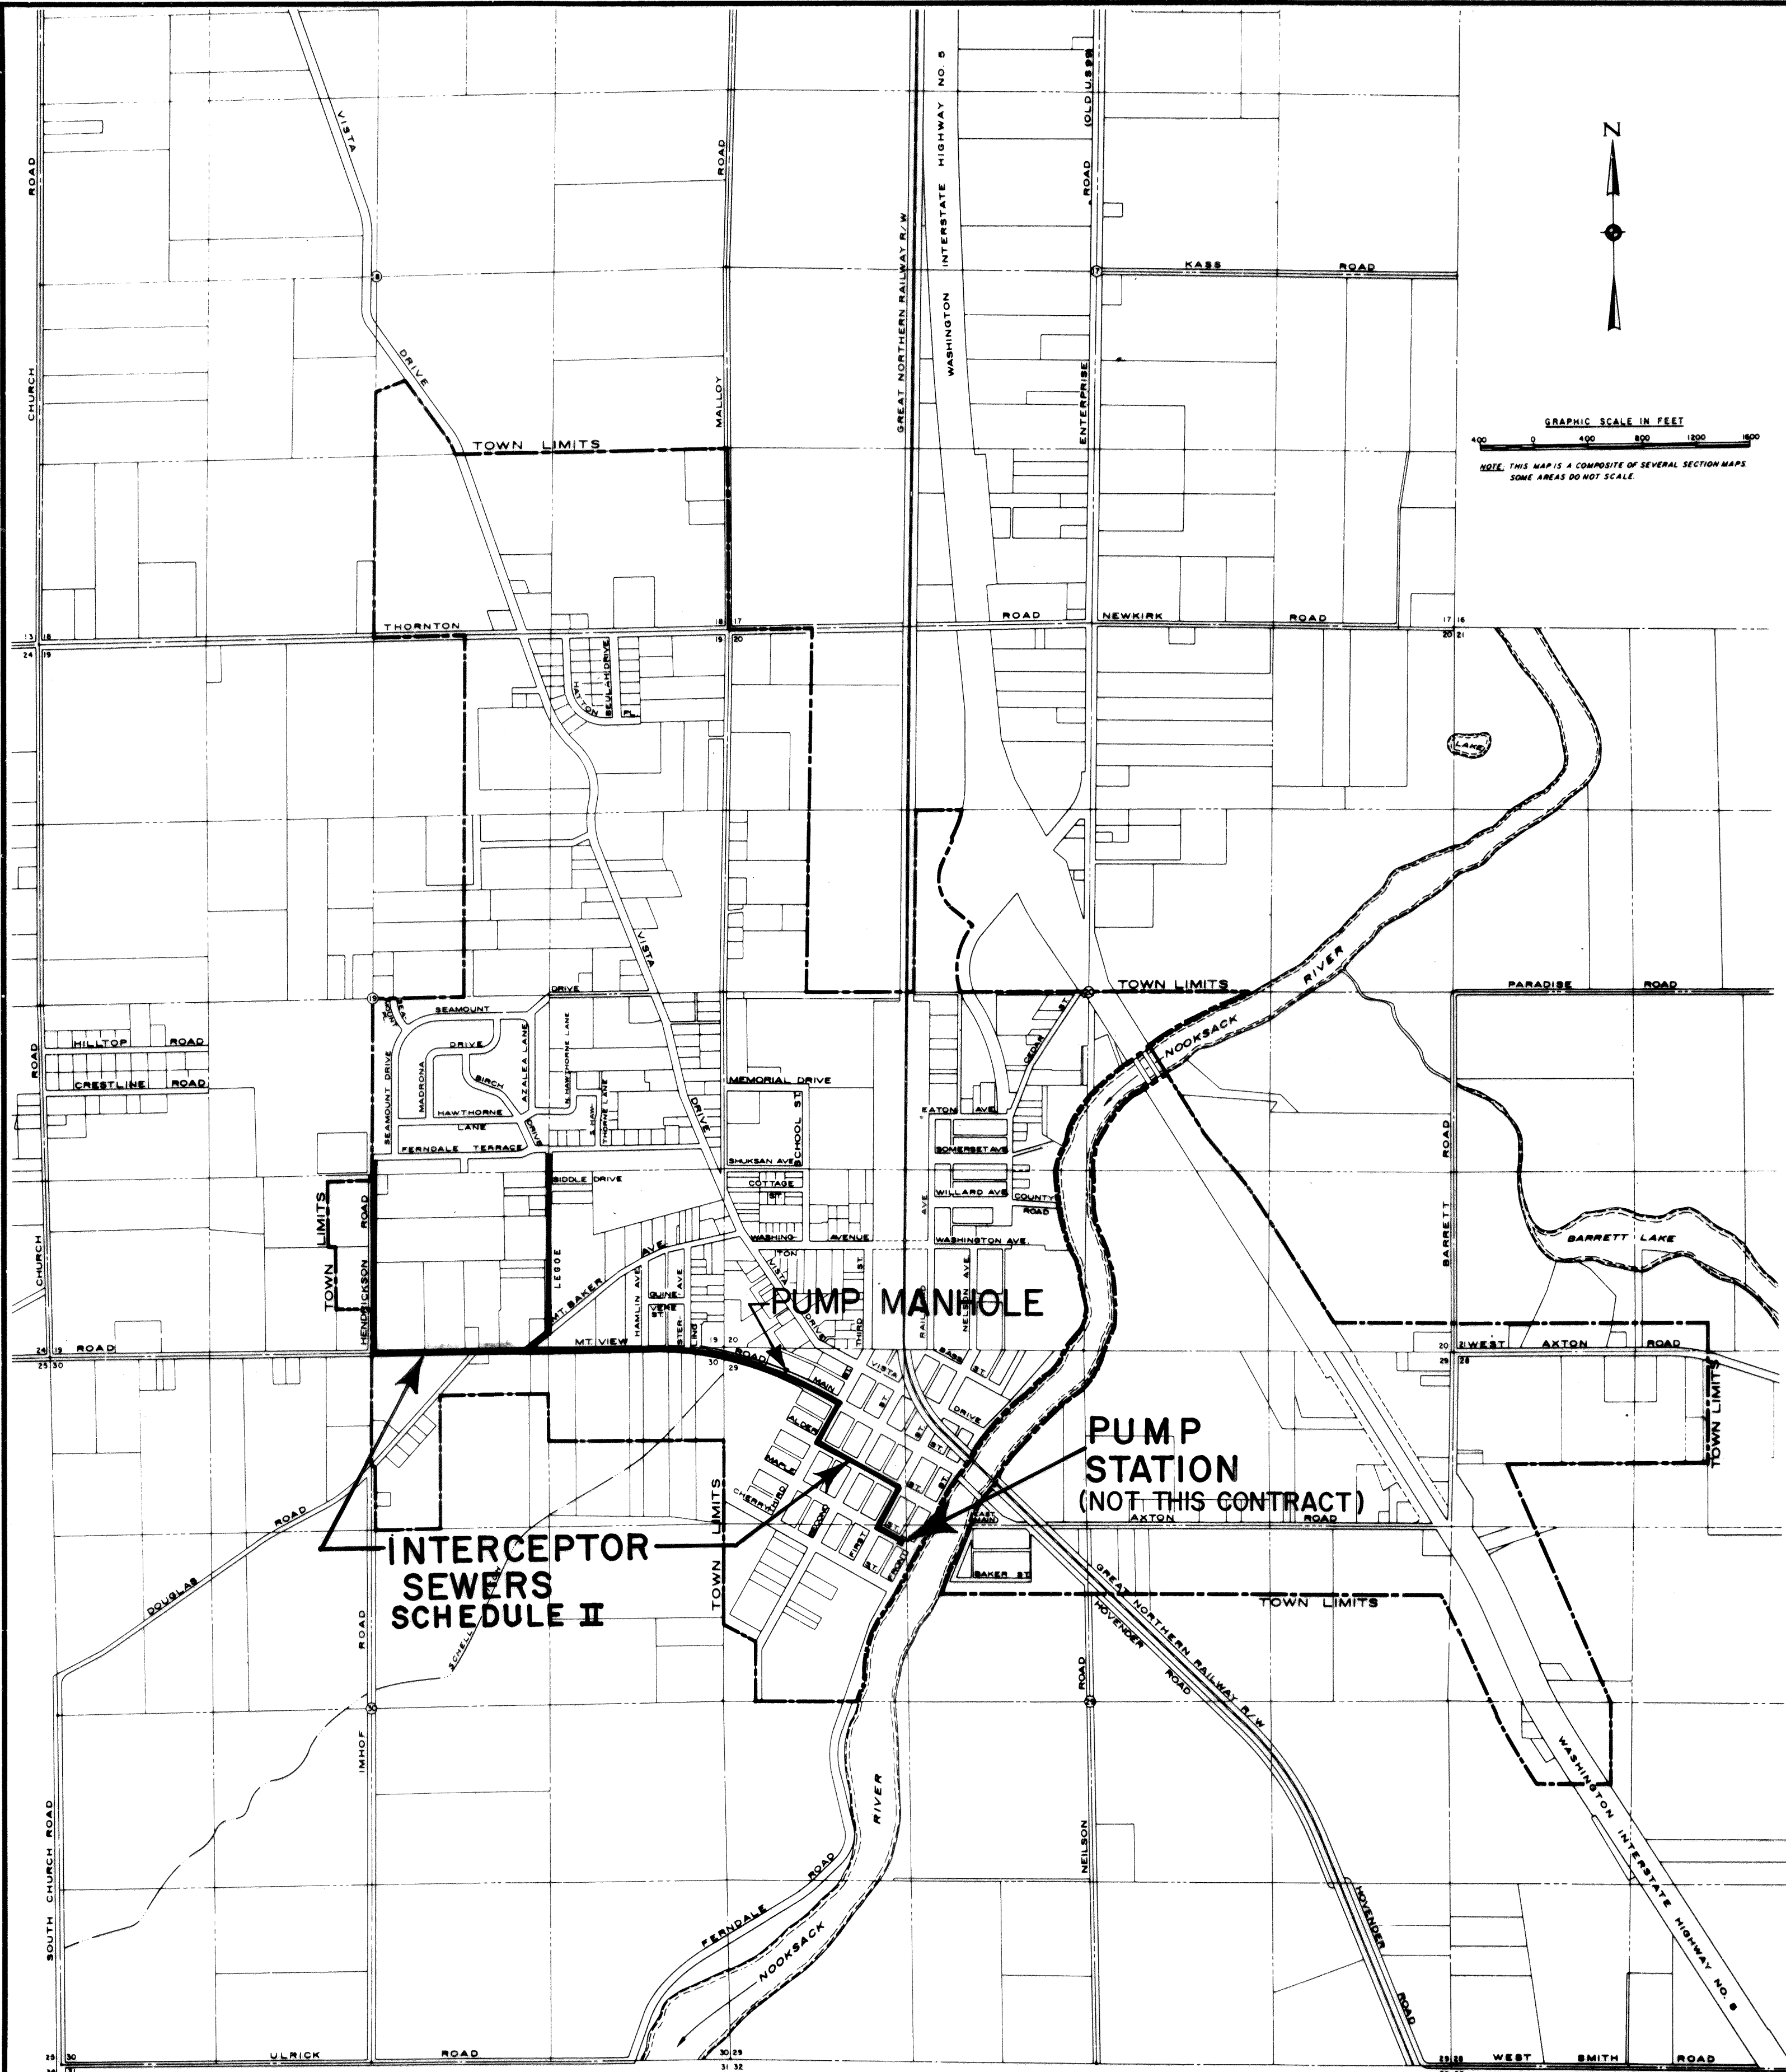


INDEX TO DRAWINGS

SHEET NO.	TITLE
1	LOCATION MAP AND INDEX
2	PLAN AND PROFILE - 15-INCH INTERCEPTOR
3	PLAN AND PROFILE - 15-INCH INTERCEPTOR
4	PLAN AND PROFILE - 10-INCH INTERCEPTOR-DETAILS SIPHON INLET MANHOLE
5	PLAN AND PROFILE - 8-INCH COLLECTOR
6	PLAN AND PROFILE - 8-INCH COLLECTOR AND PUMP MANHOLE
7	SEWER DETAILS

LEGEND

EXISTING	NEW
4" W	WATER LINE W/SIZE & VALVE
	WATER METER
	FIRE HYDRANT
S 8"	SANITARY SEWER W/SIZE & MANHOLE
	CATCH BASIN
	CULVERT
2" G	GAS LINE W/SIZE & VALVE
	TELEPHONE OR POWER POLE
	GUY POLE
	GUYED POLE
X X X X	FENCE
	TREES
	SIDEWALK
	EXISTING ROAD SURFACE

AS BUILT
DATE JAN. 1970

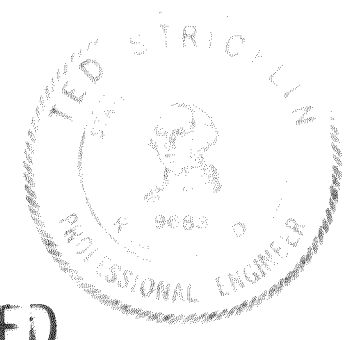

MICROFILMED

DESIGNED T. S.	APPROVED <i>L. J. M.</i>
DRAWN L. J. M.	SCALE AS SHOWN DATE JAN. 1969
CHECKED T. S.	FILE 67-S-168.002



ST
Stevens, Thompson & Runyan, Inc.
Engineers/Planners
PORTLAND, OREGON SEATTLE, WASHINGTON

TOWN OF FERNDAL, WASHINGTON
**INTERCEPTOR SEWERS
SCHEDULE II**

LOCATION MAP AND INDEX






1
7

Dwg # S-67-168.002-26

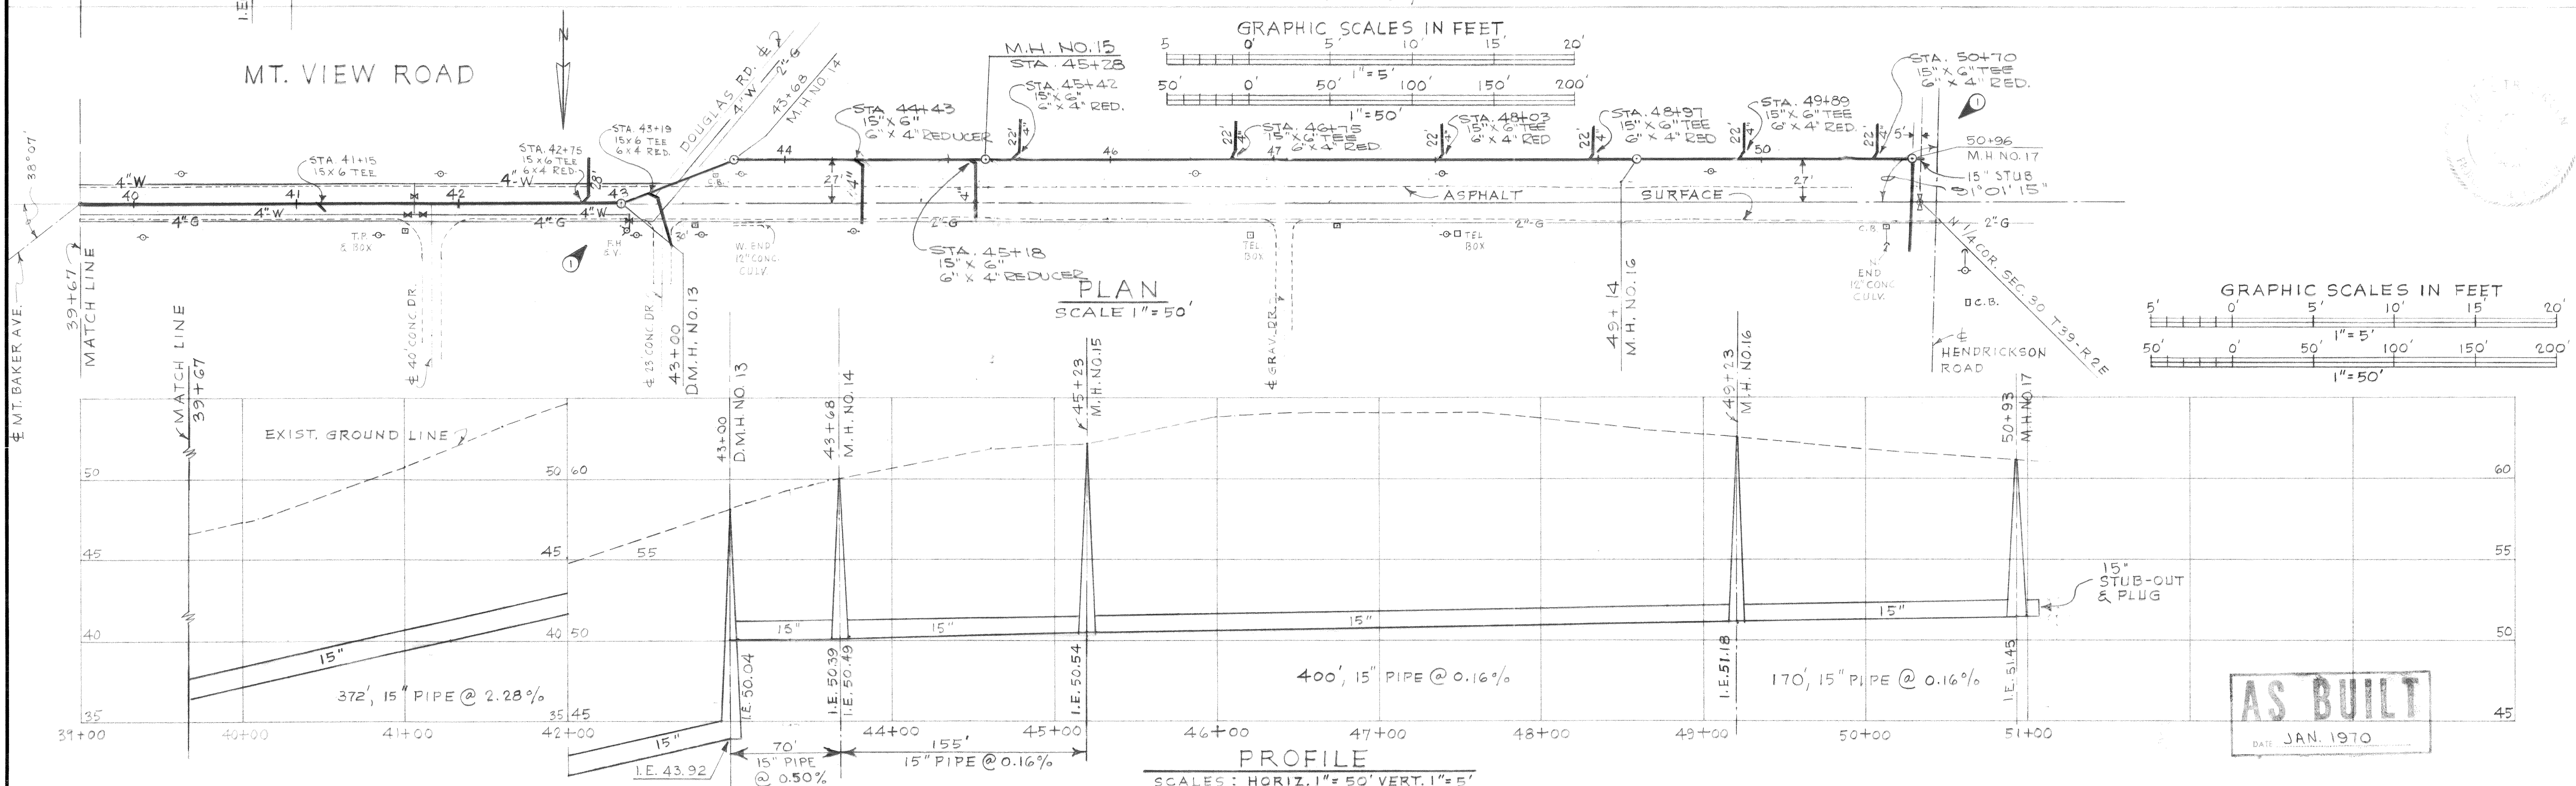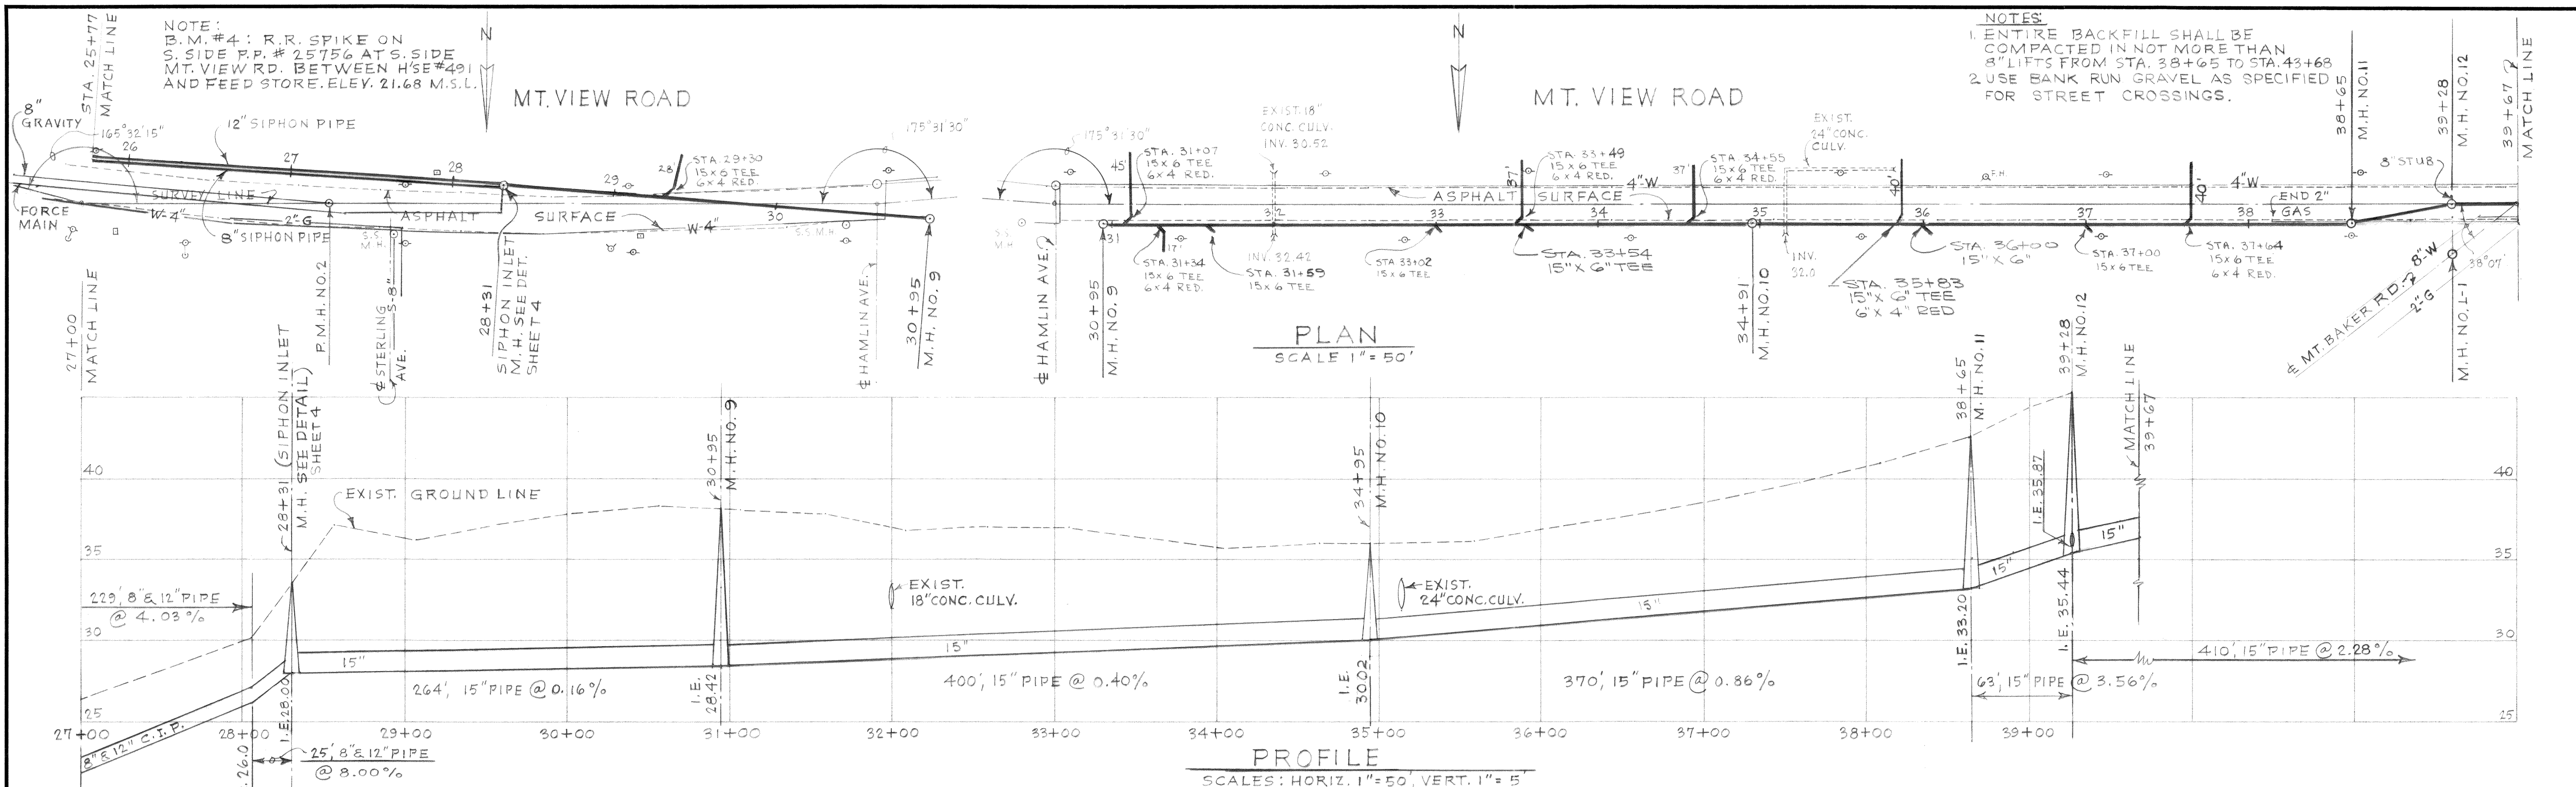

1/13/70	3	LOCATE TEES & STUBS	RHP	DESIGNED T. S.	APPROVED <i>H.R. Murray</i>	 Stevens, Thompson & Runyan, Inc. Engineers/Planners PORTLAND, OREGON SEATTLE, WASHINGTON	TOWN OF FERNDAL, WASHINGTON INTERCEPTOR SEWERS SCHEDULE II	PLAN AND PROFILE 15 INCH INTERCEPTOR MICROFILMED	3 7	
1/13/70	2	RELOCATE PIPE BTWN M.H. NO. 13 & 17	RHP	DRAWN L. J. M.	SCALE AS SHOWN					DATE JAN. 1969
1/13/70	1	RELOCATE M.H. NO. 13 & NO. 17	RHP	CHECKED T. S.	FILE 67-S-168-002					
DATE	NO.	REVISION	BY							

Dwg # S-67-168.002-28

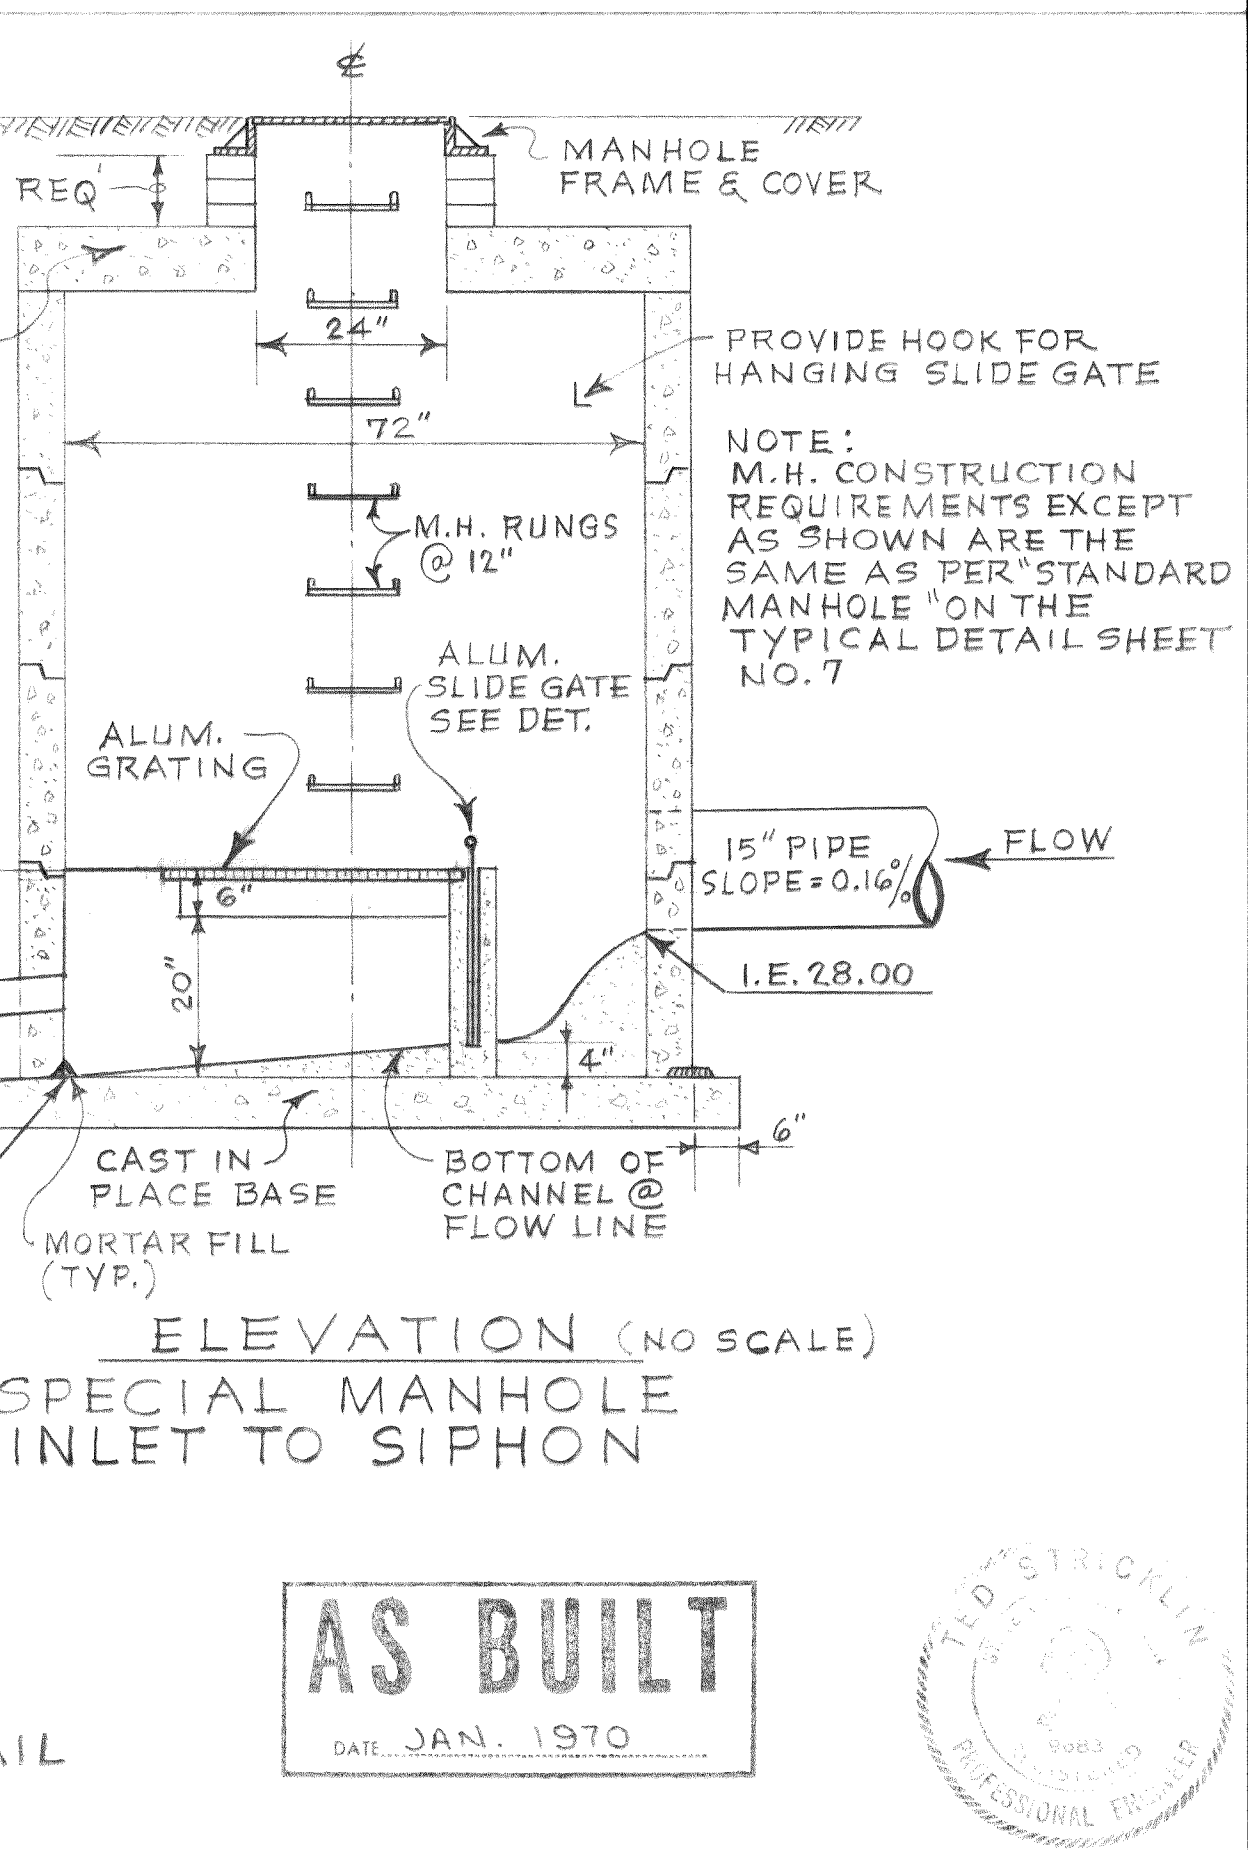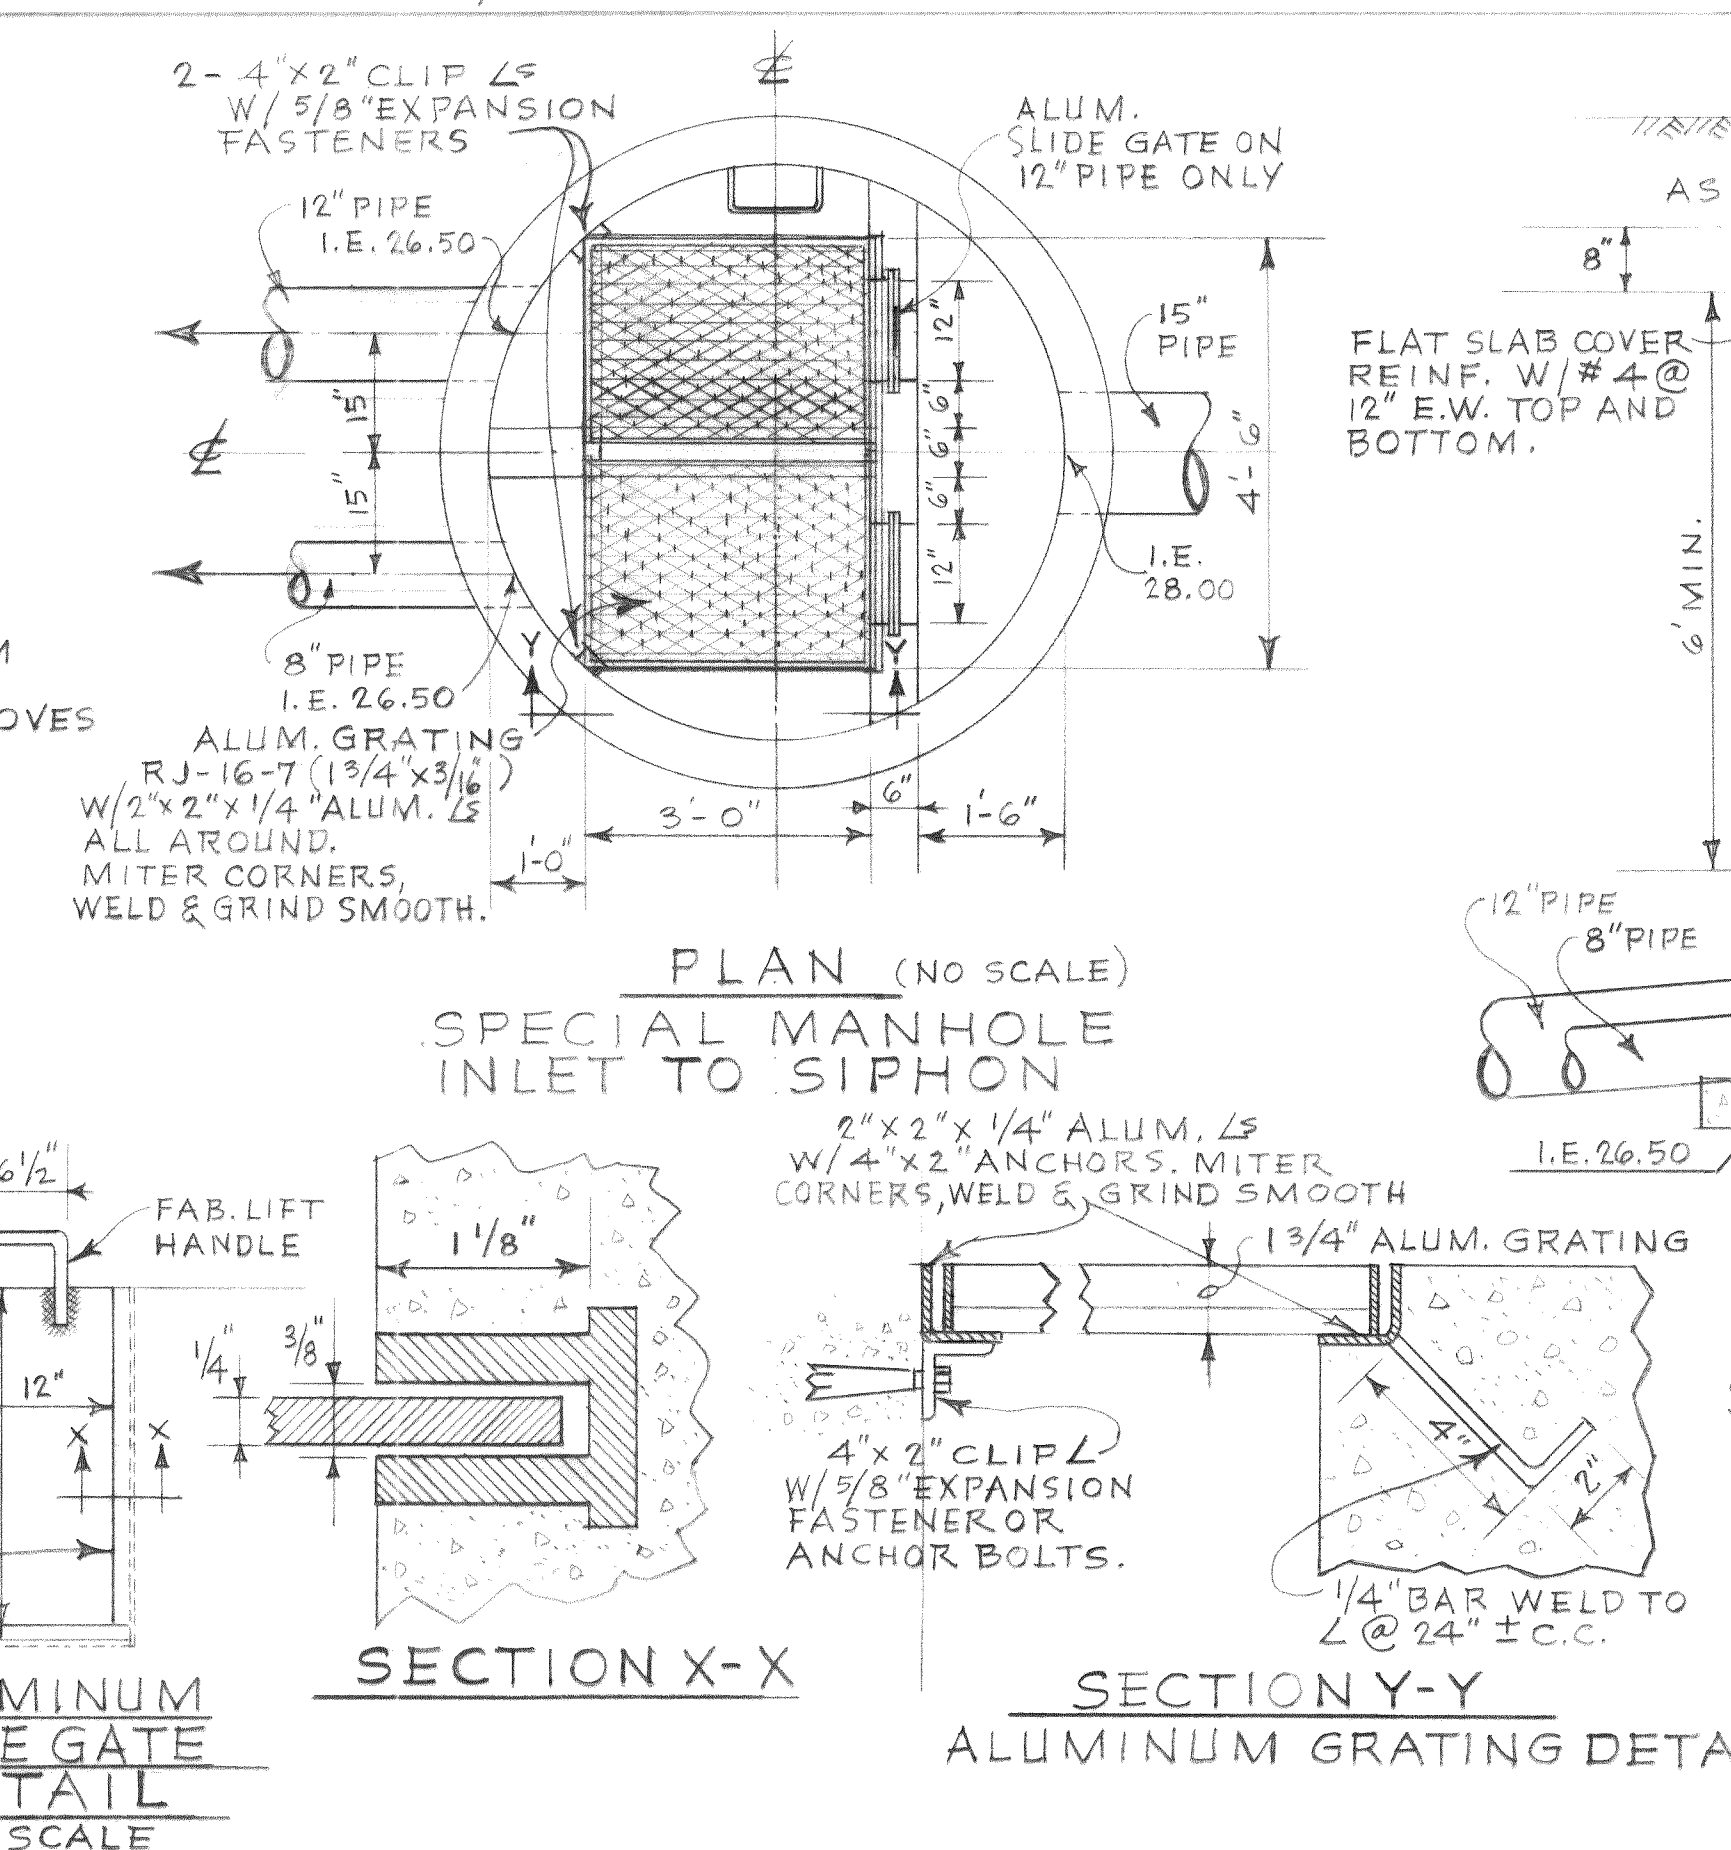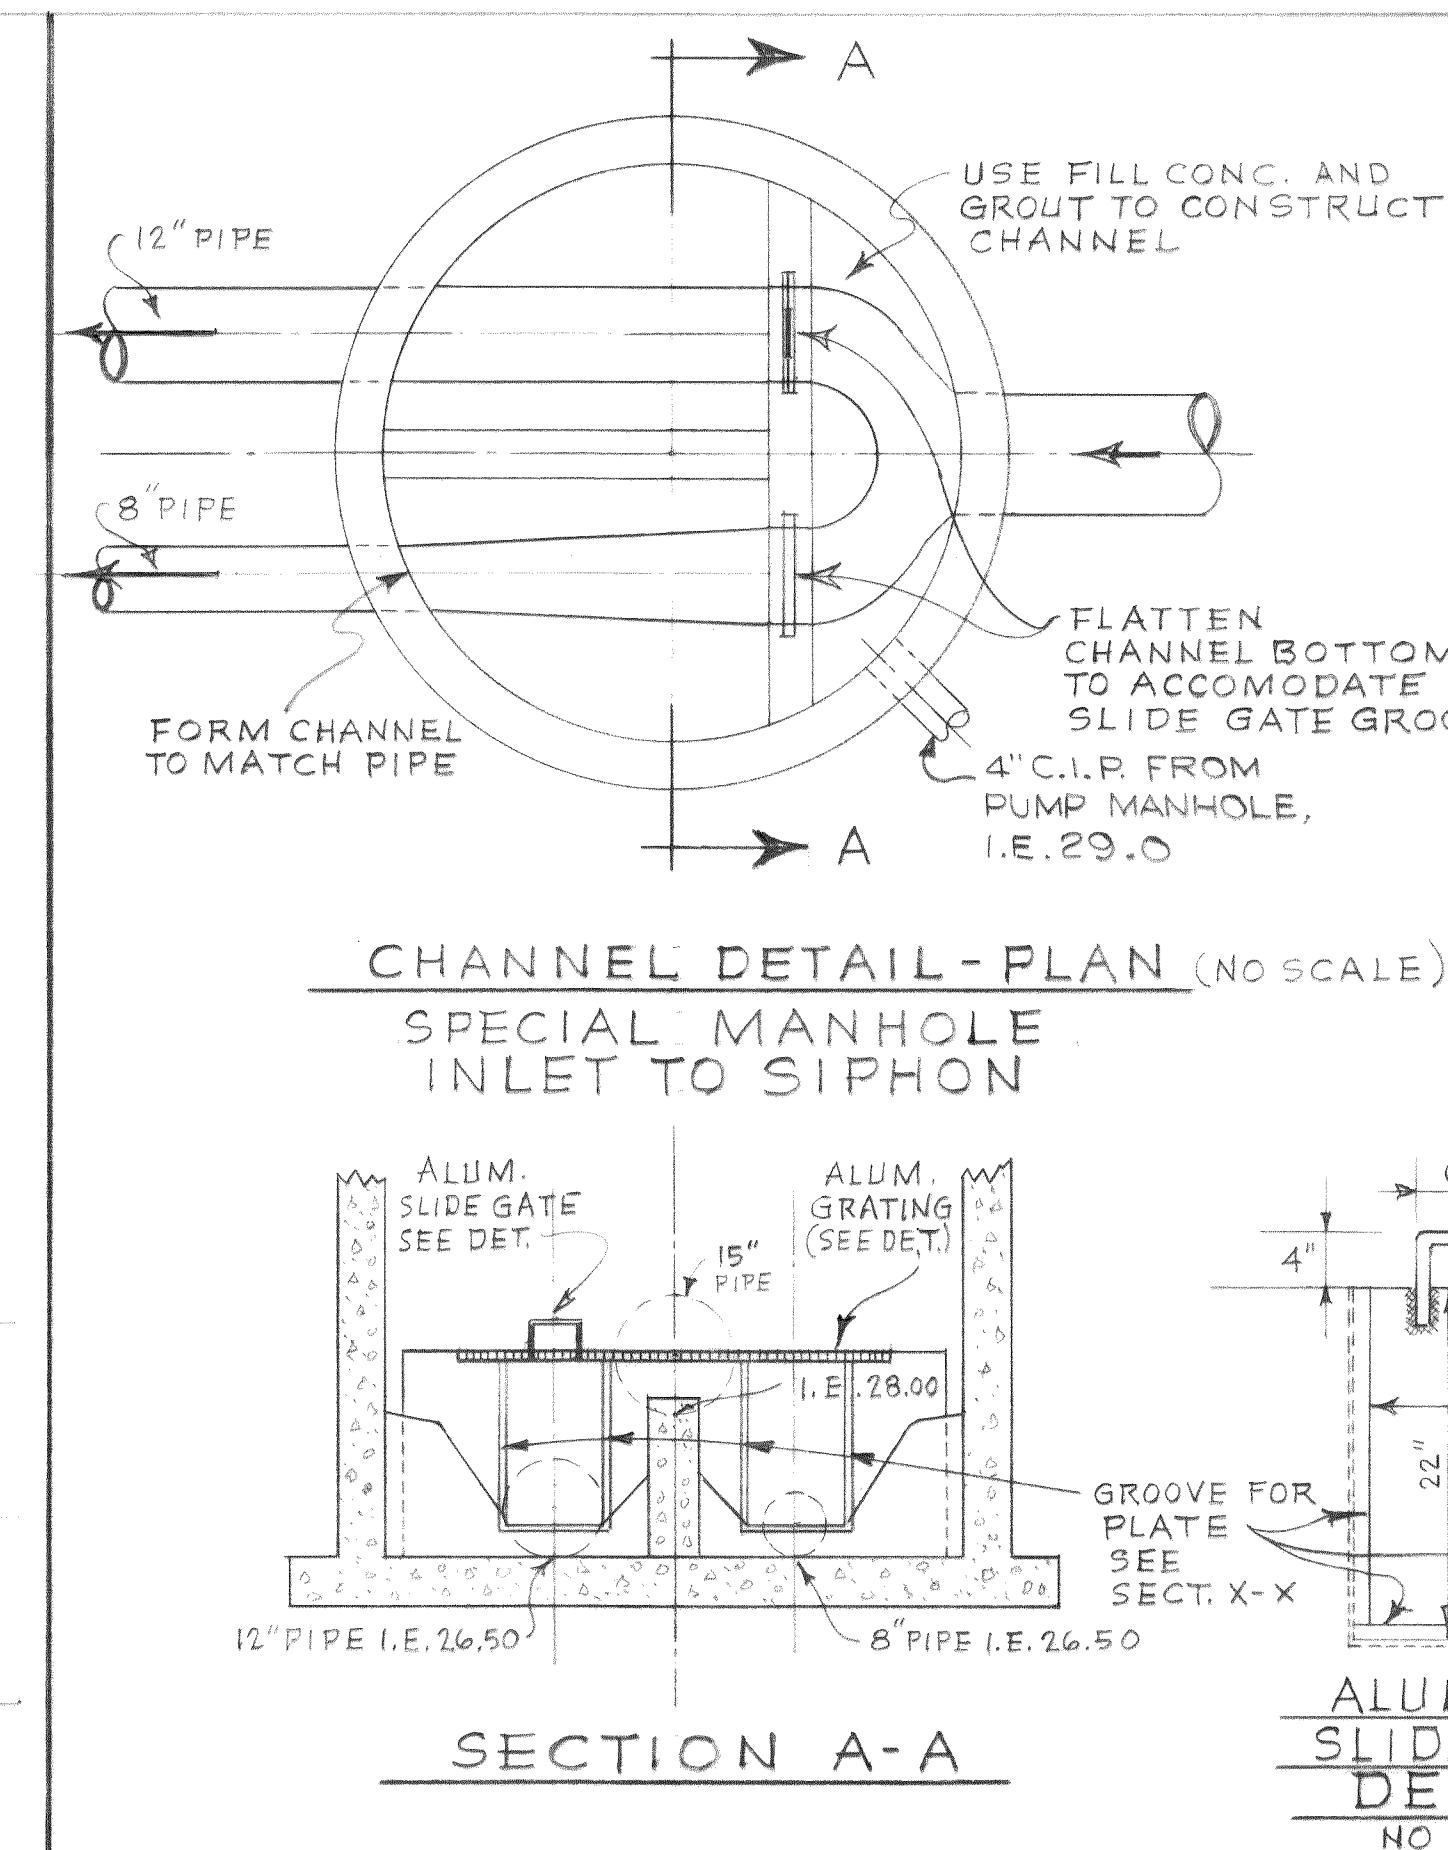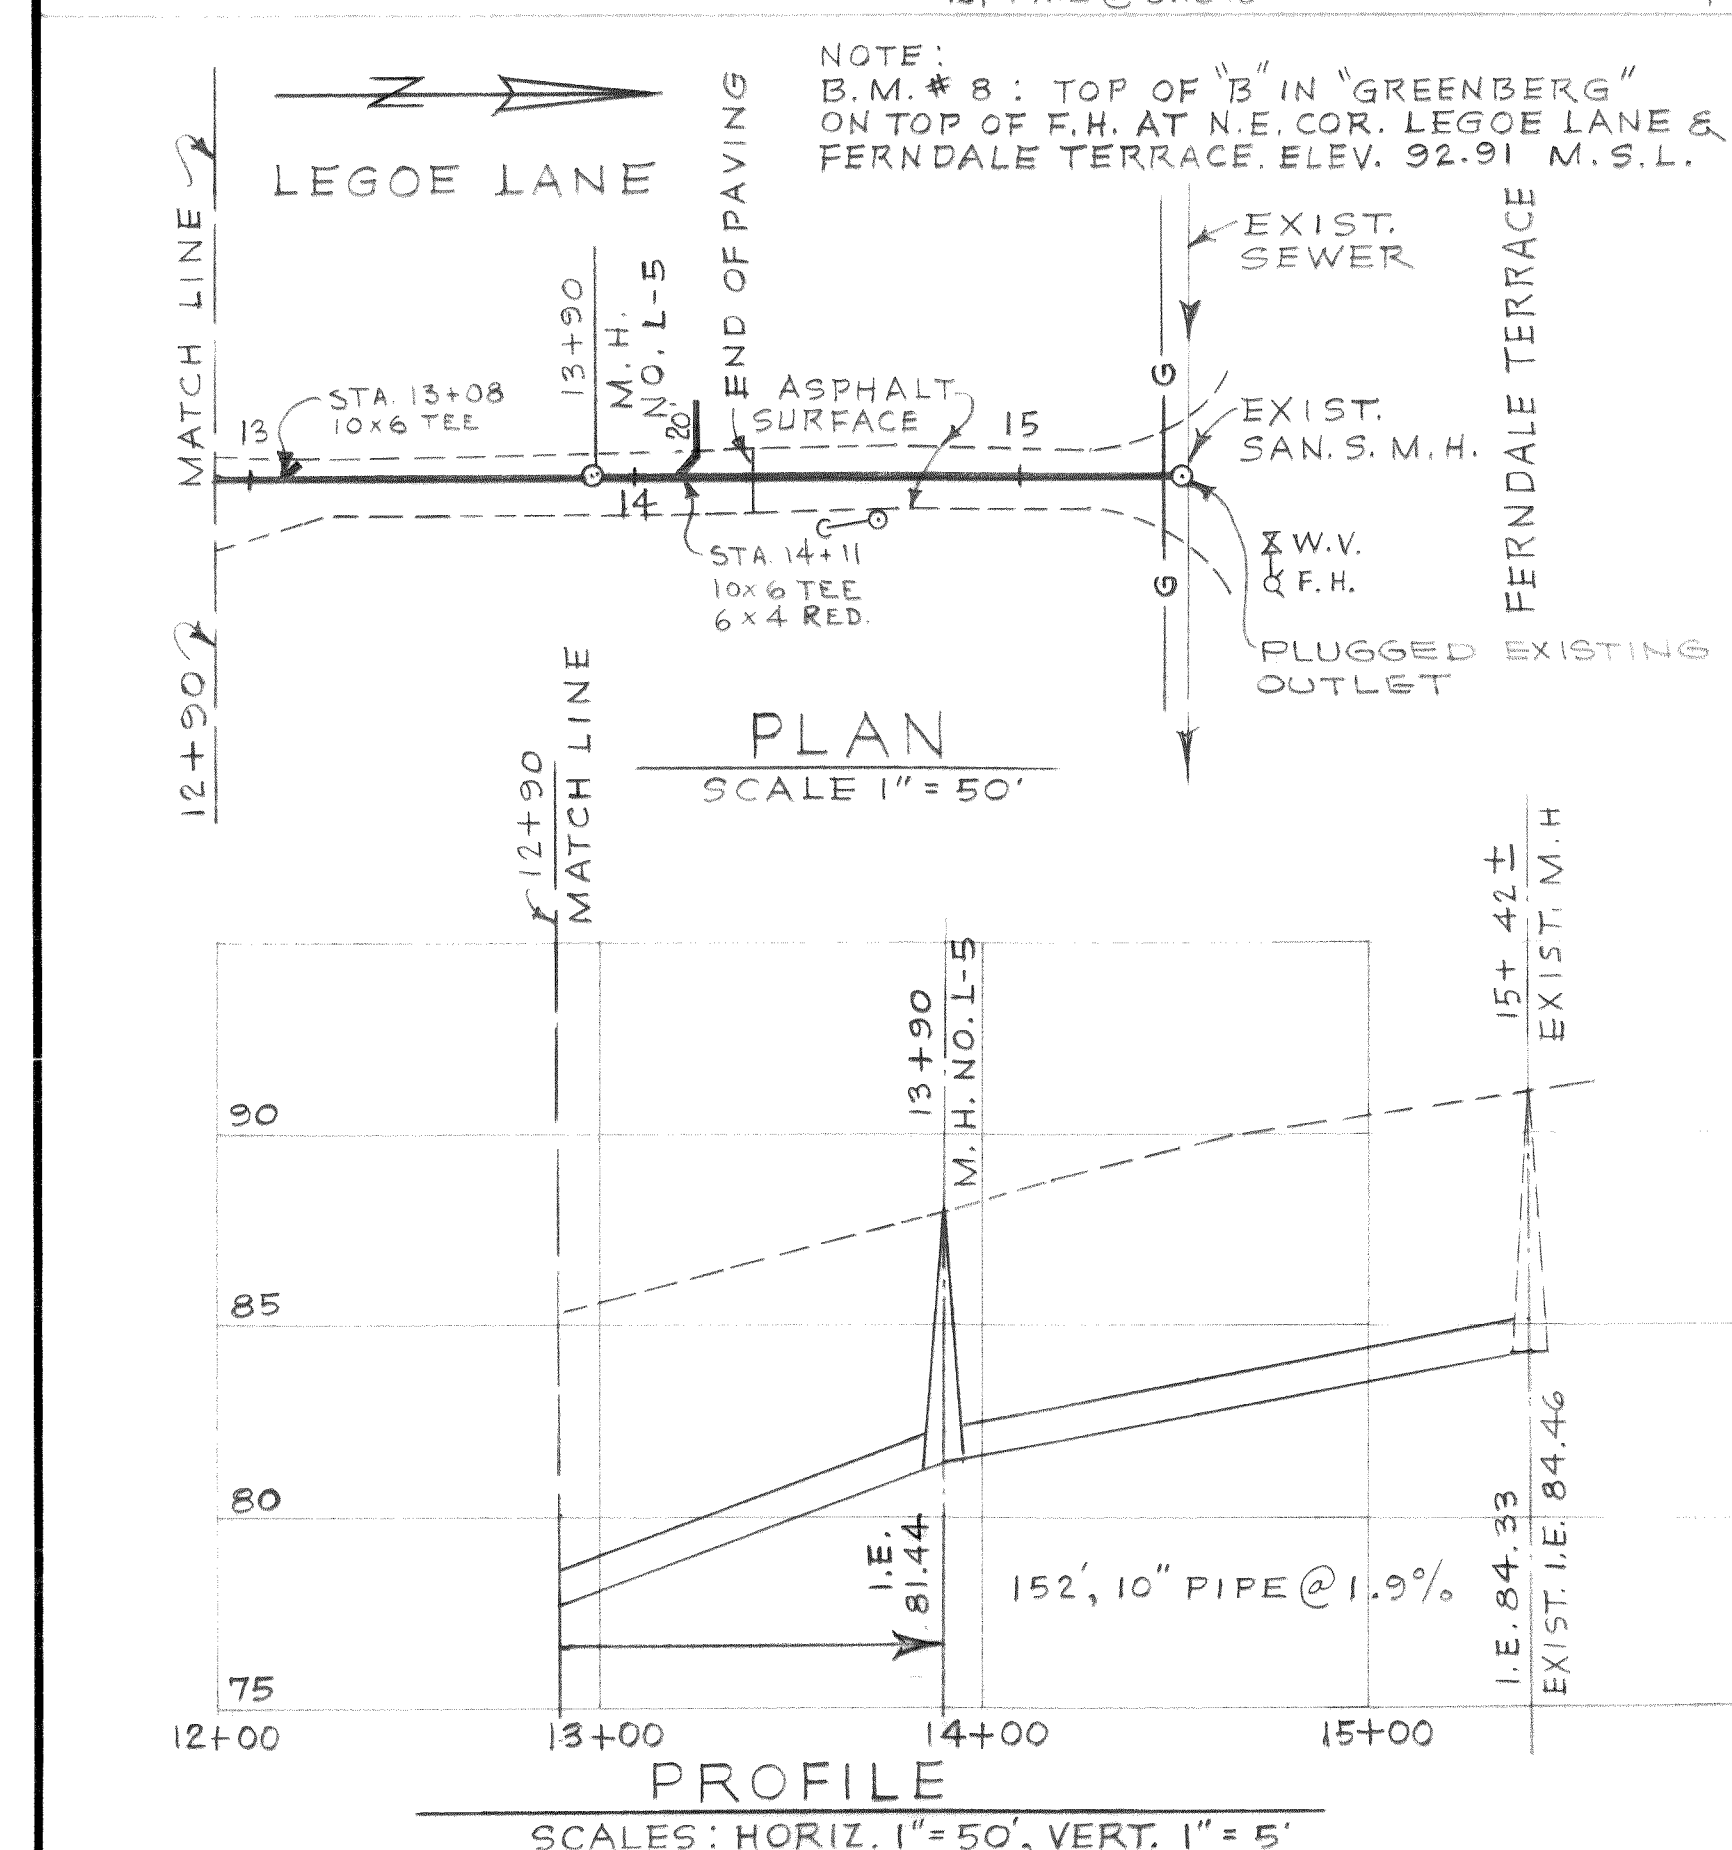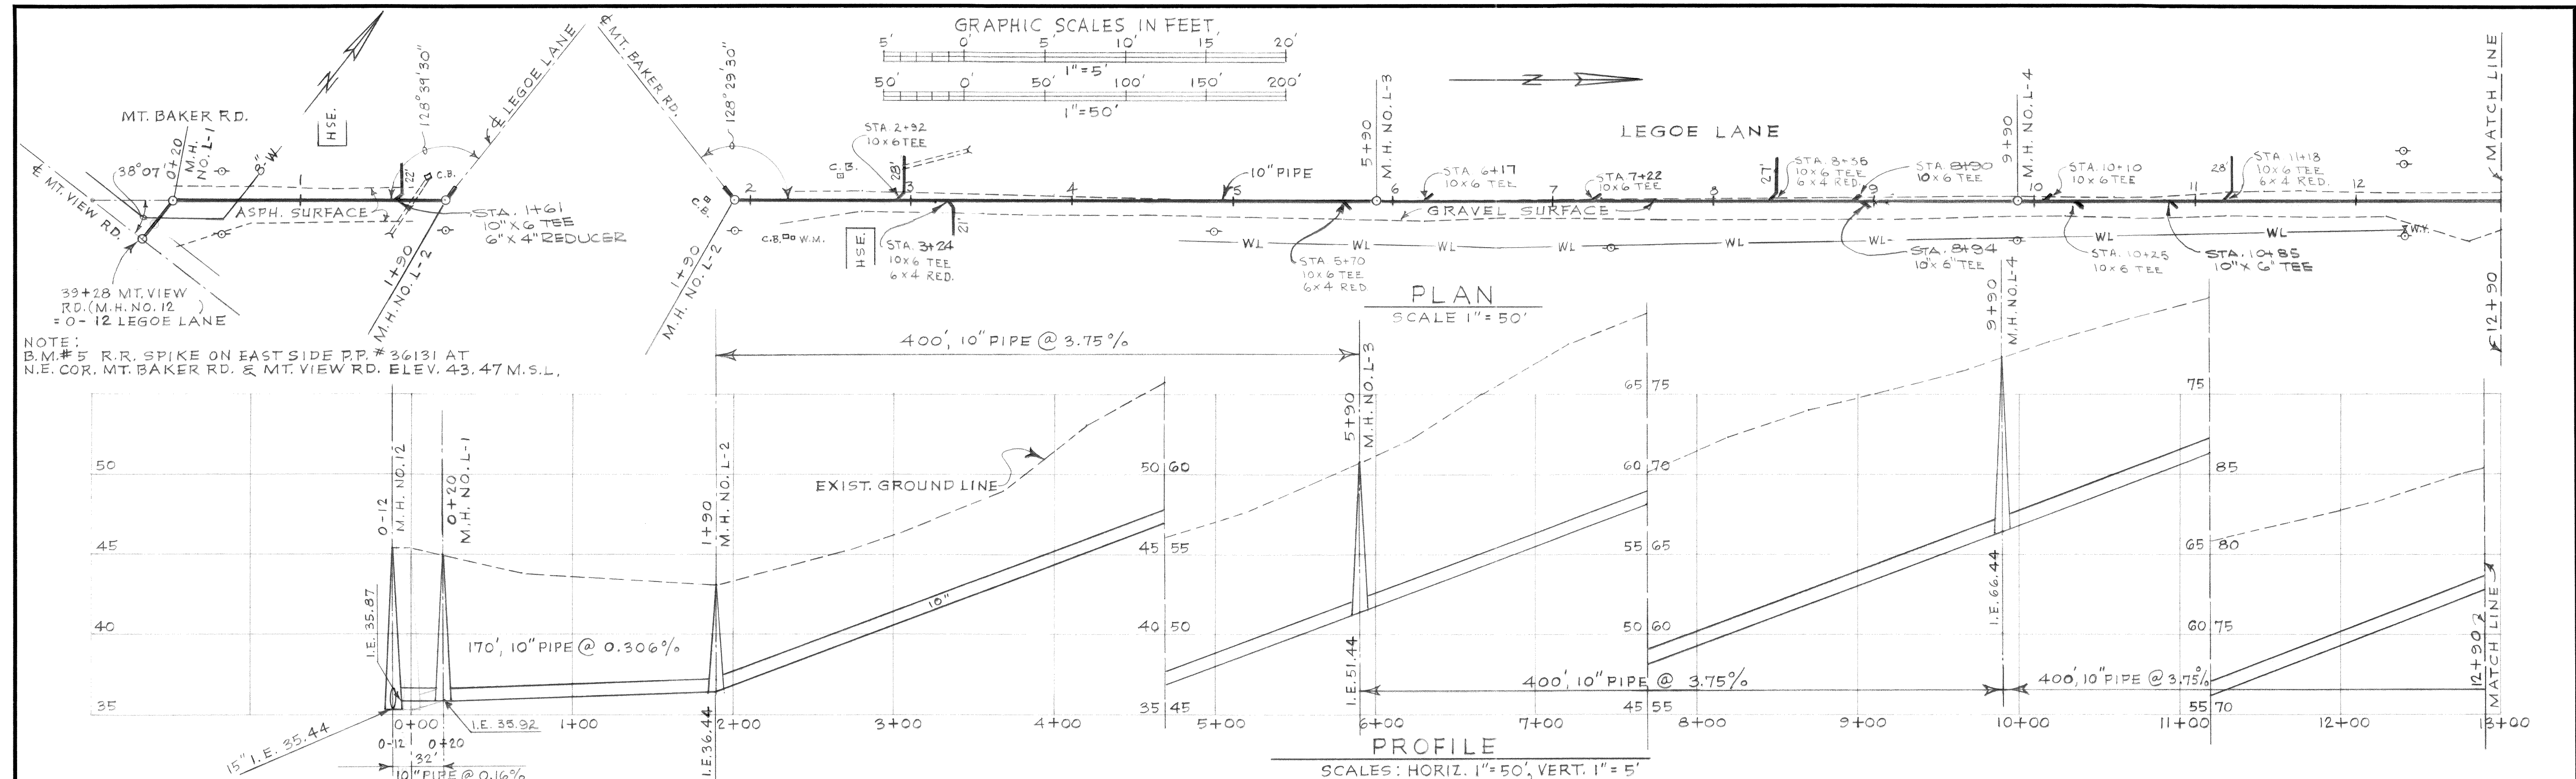

DESIGNED T.S.	APPROVED <i>L.R. Murray</i>
DRAWN L.J.M.	SCALE AS SHOWN
CHECKED T.S.	DATE JAN. 1969
FILE 67-S-168.002	


Stevens, Thompson & Runyan, Inc.
 Engineers/Planners
 PORTLAND, OREGON SEATTLE, WASHINGTON

TOWN OF FERDALE, WASHINGTON
INTERCEPTOR SEWERS
 SCHEDULE II

PLAN AND PROFILE
10 INCH INTERCEPTOR
DETAILS-SIPHON INLET MANHOLE

4
 7

Dwg # 67-S-168.002-29

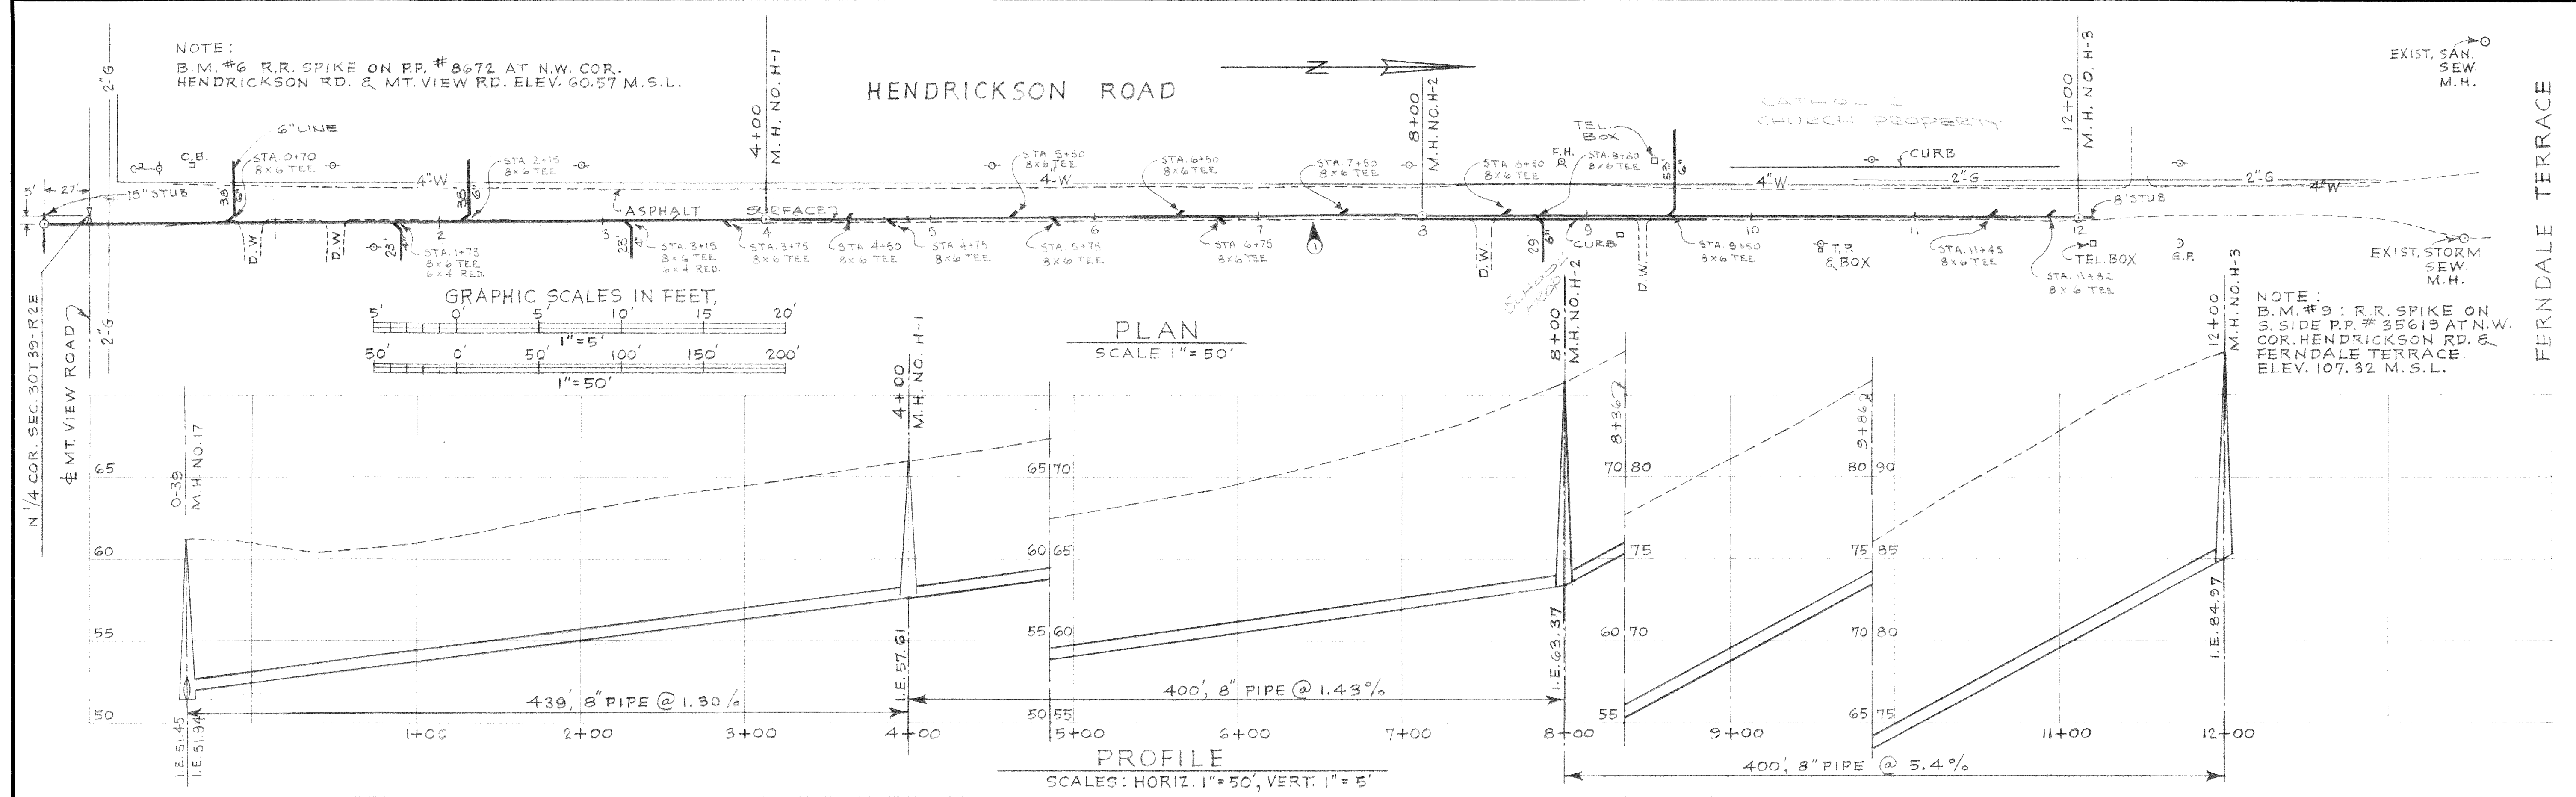

AS BUILT
DATE JAN. 1970



DESIGNED	T.S.	APPROVED	<i>A.R. Murray</i>
1/13/70	2	LOCATE TEES & STUBS	RHP
1/13/70	1	RELOCATE PIPELINE	RHP
DATE	NO.	REVISION	BY
CHECKED	T.S.	FILE	67-S-168,002

ST
Stevens, Thompson & Runyan, Inc.
Engineers/Planners
PORTLAND, OREGON SEATTLE, WASHINGTON








TOWN OF FERNDAL, WASHINGTON
INTERCEPTOR SEWERS
SCHEDULE II

PLAN AND PROFILE
8 INCH COLLECTOR

MICROFILMED

5
7

Dwg # 67-S-168,002-30

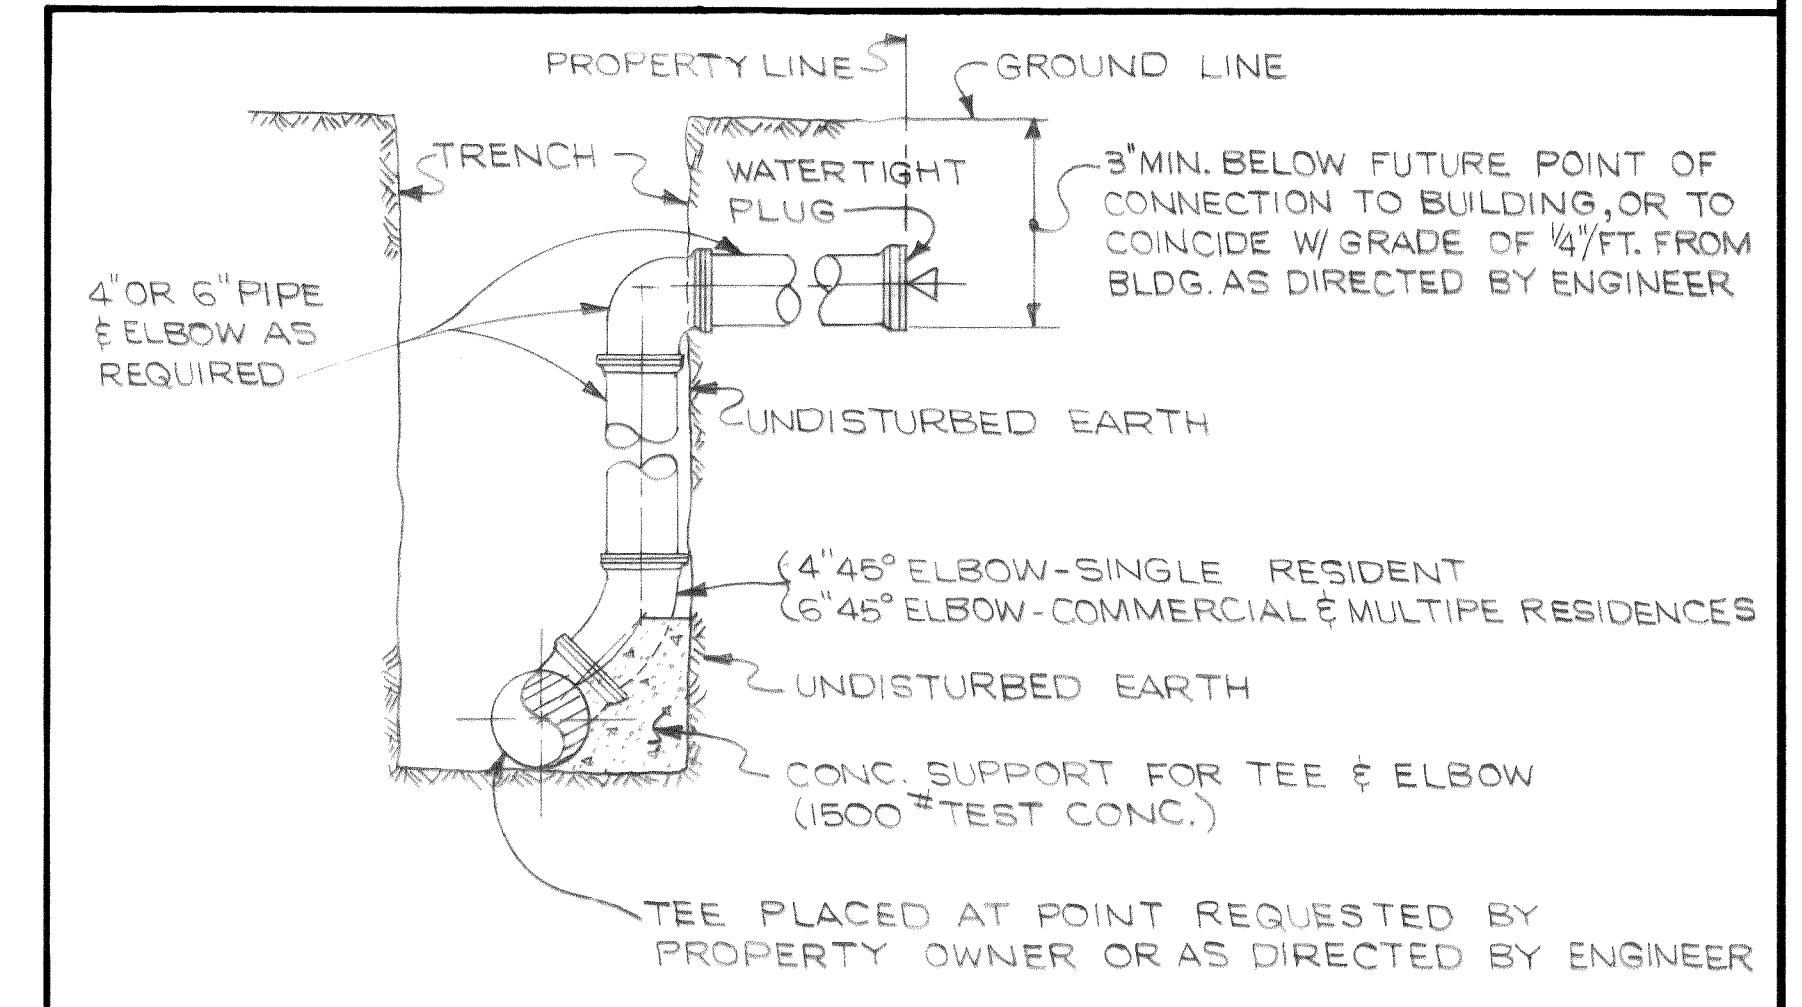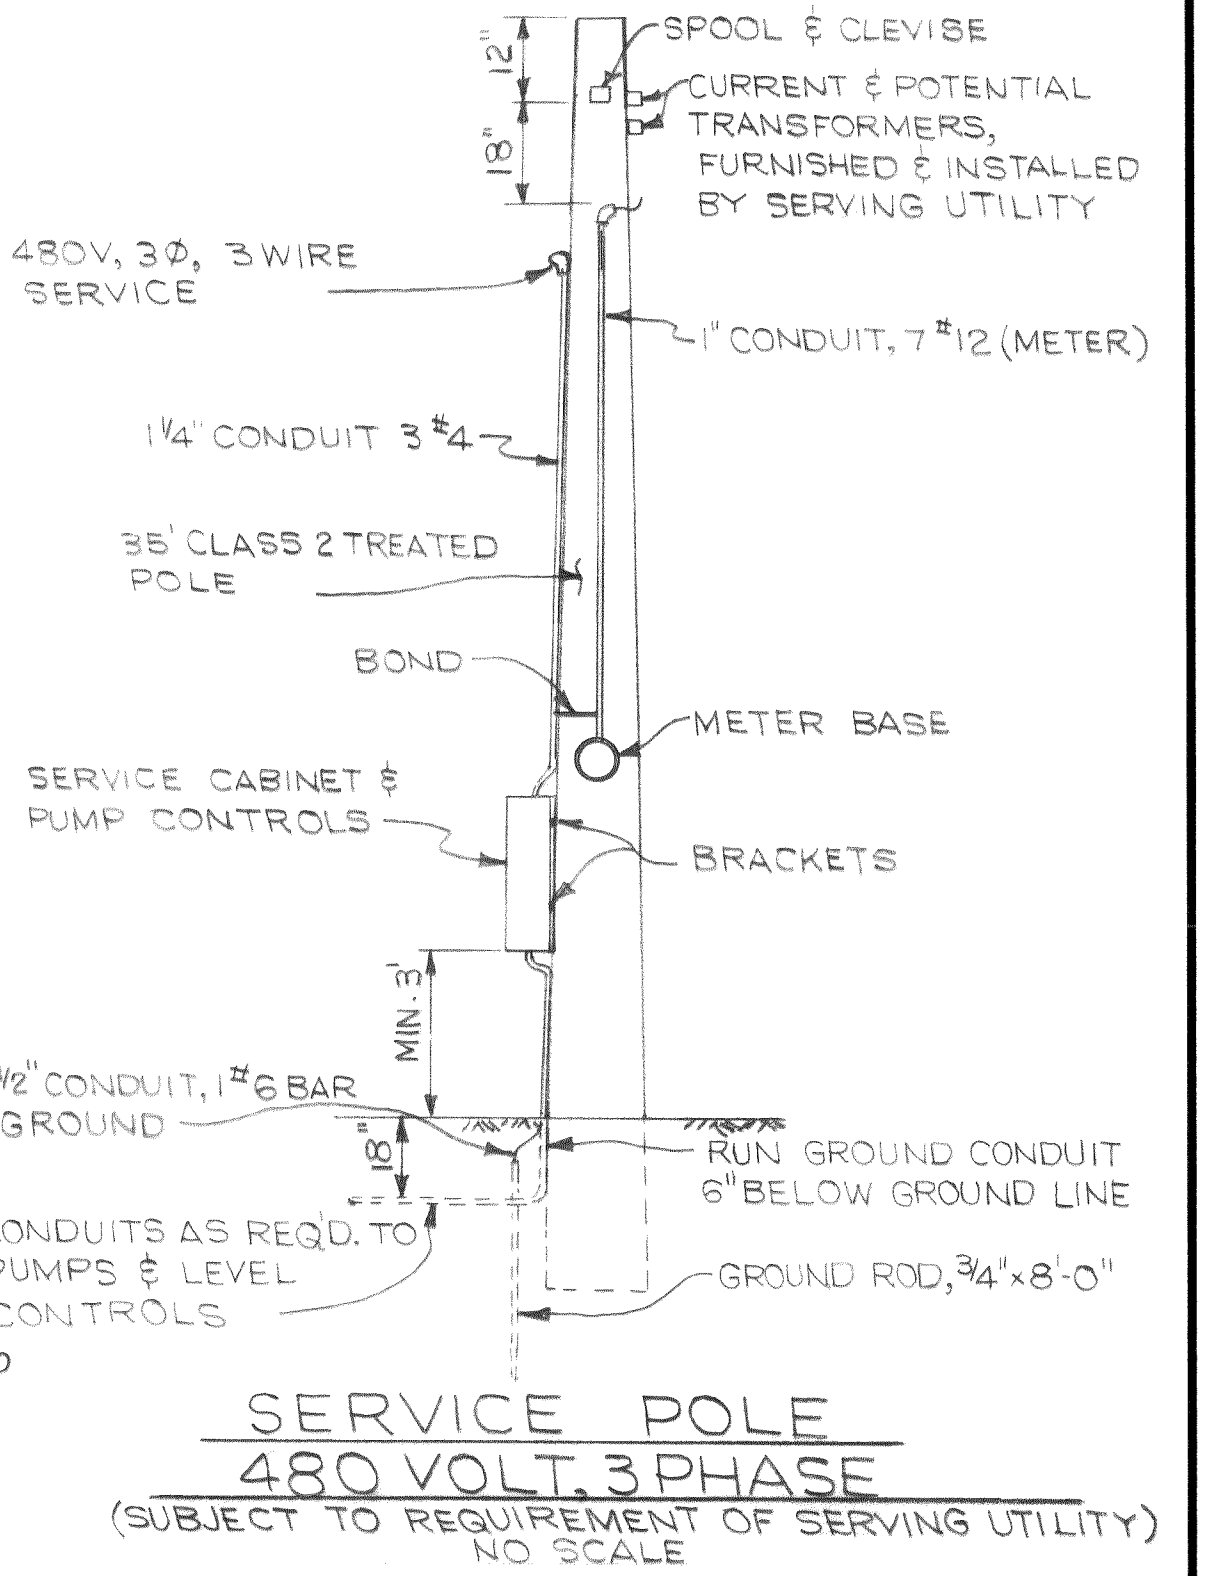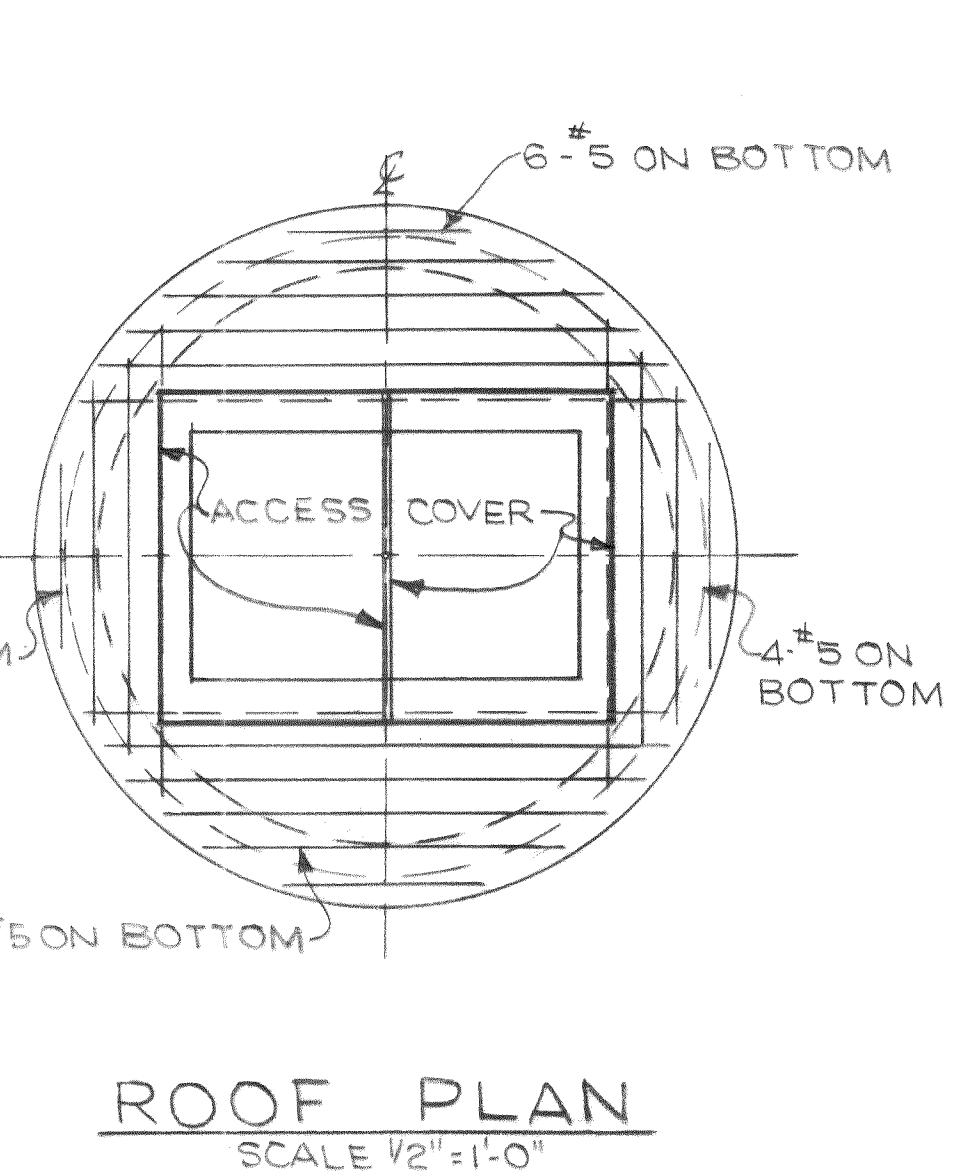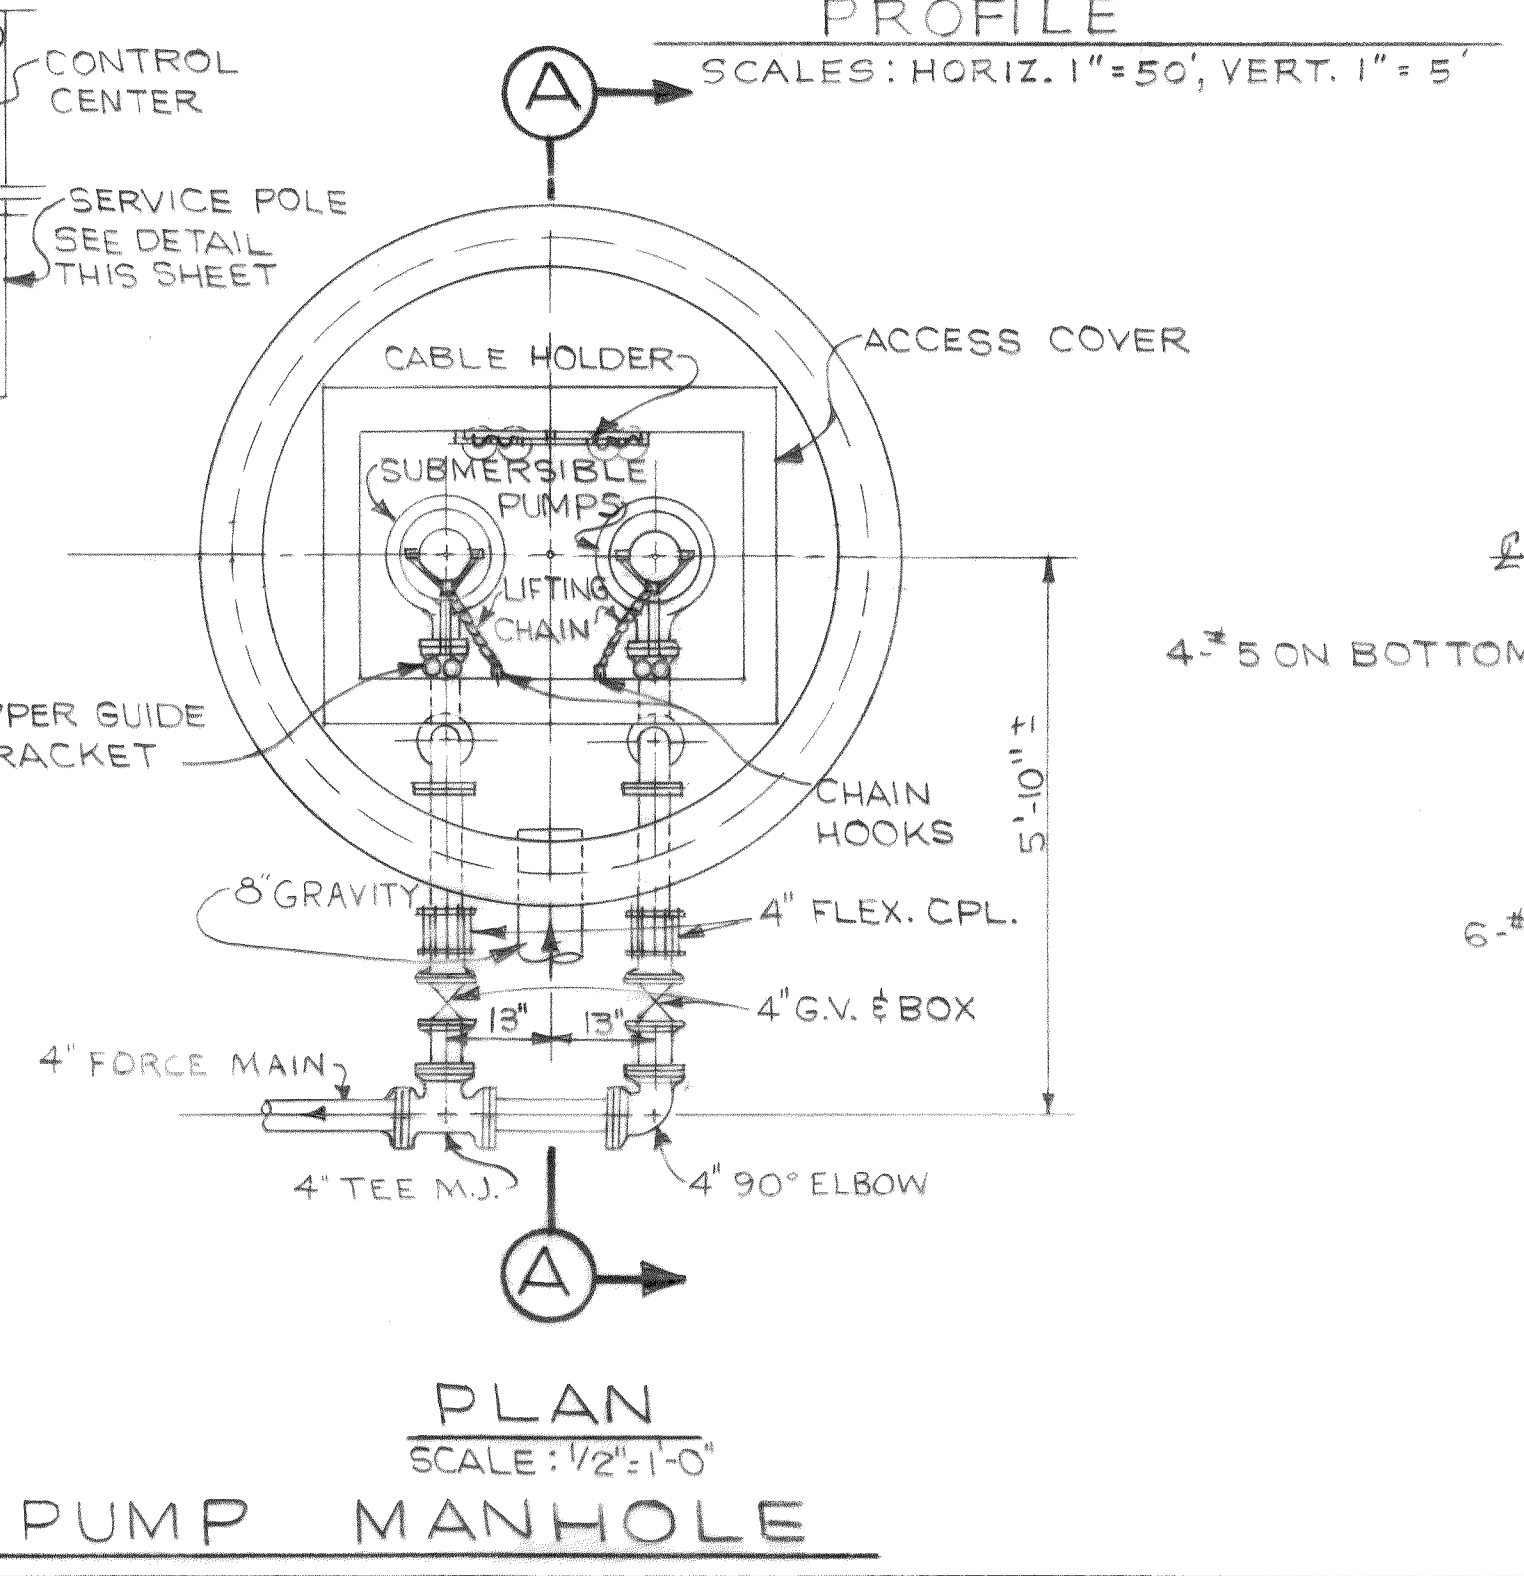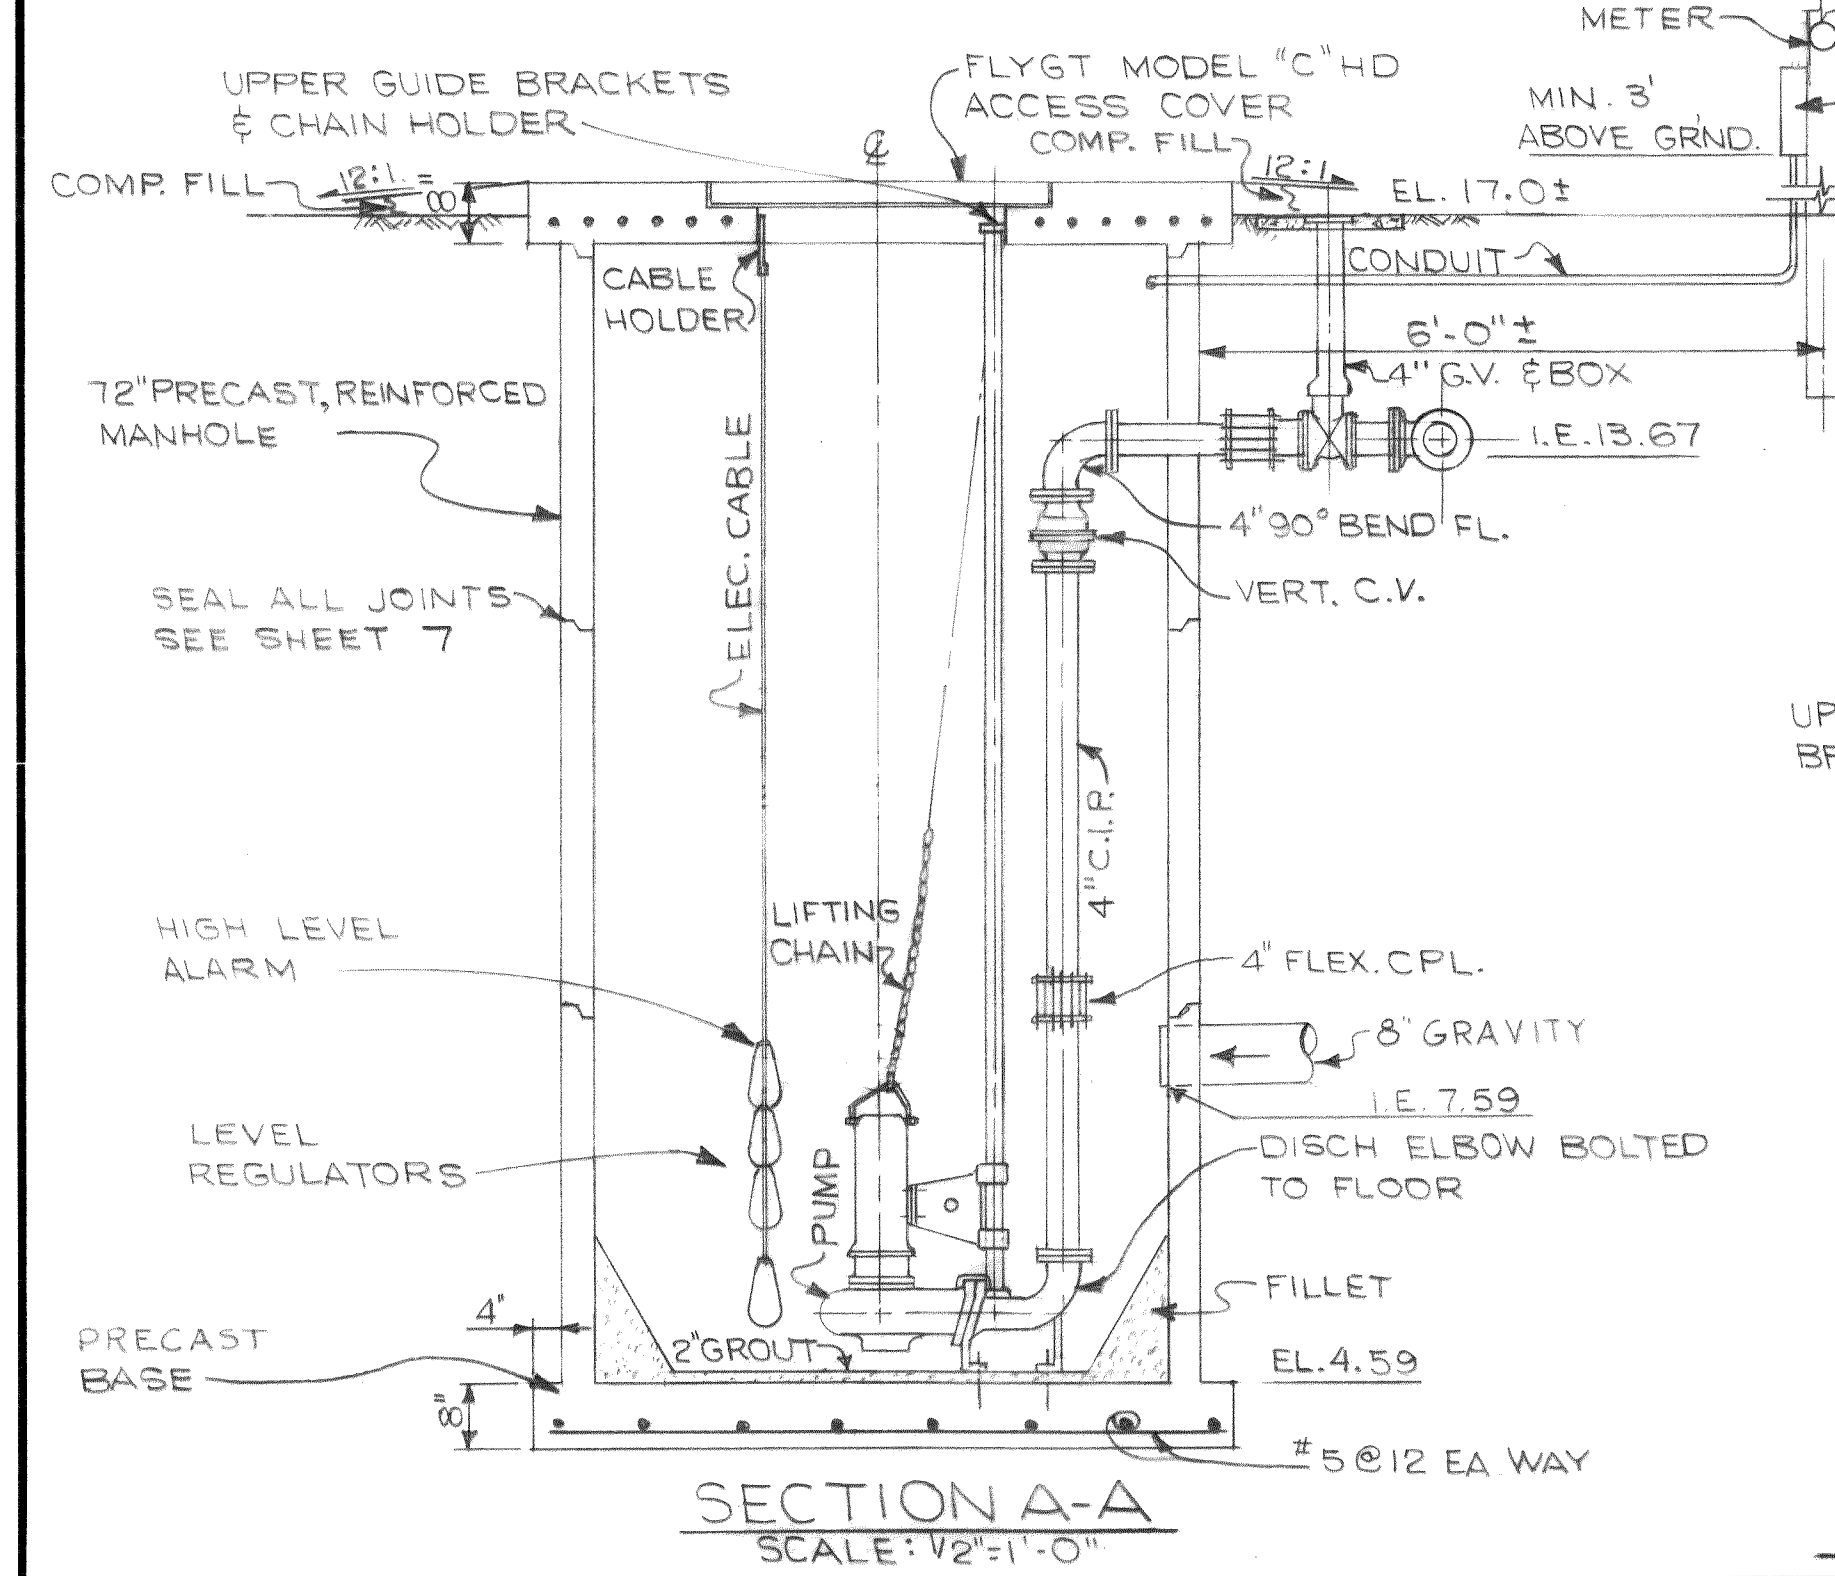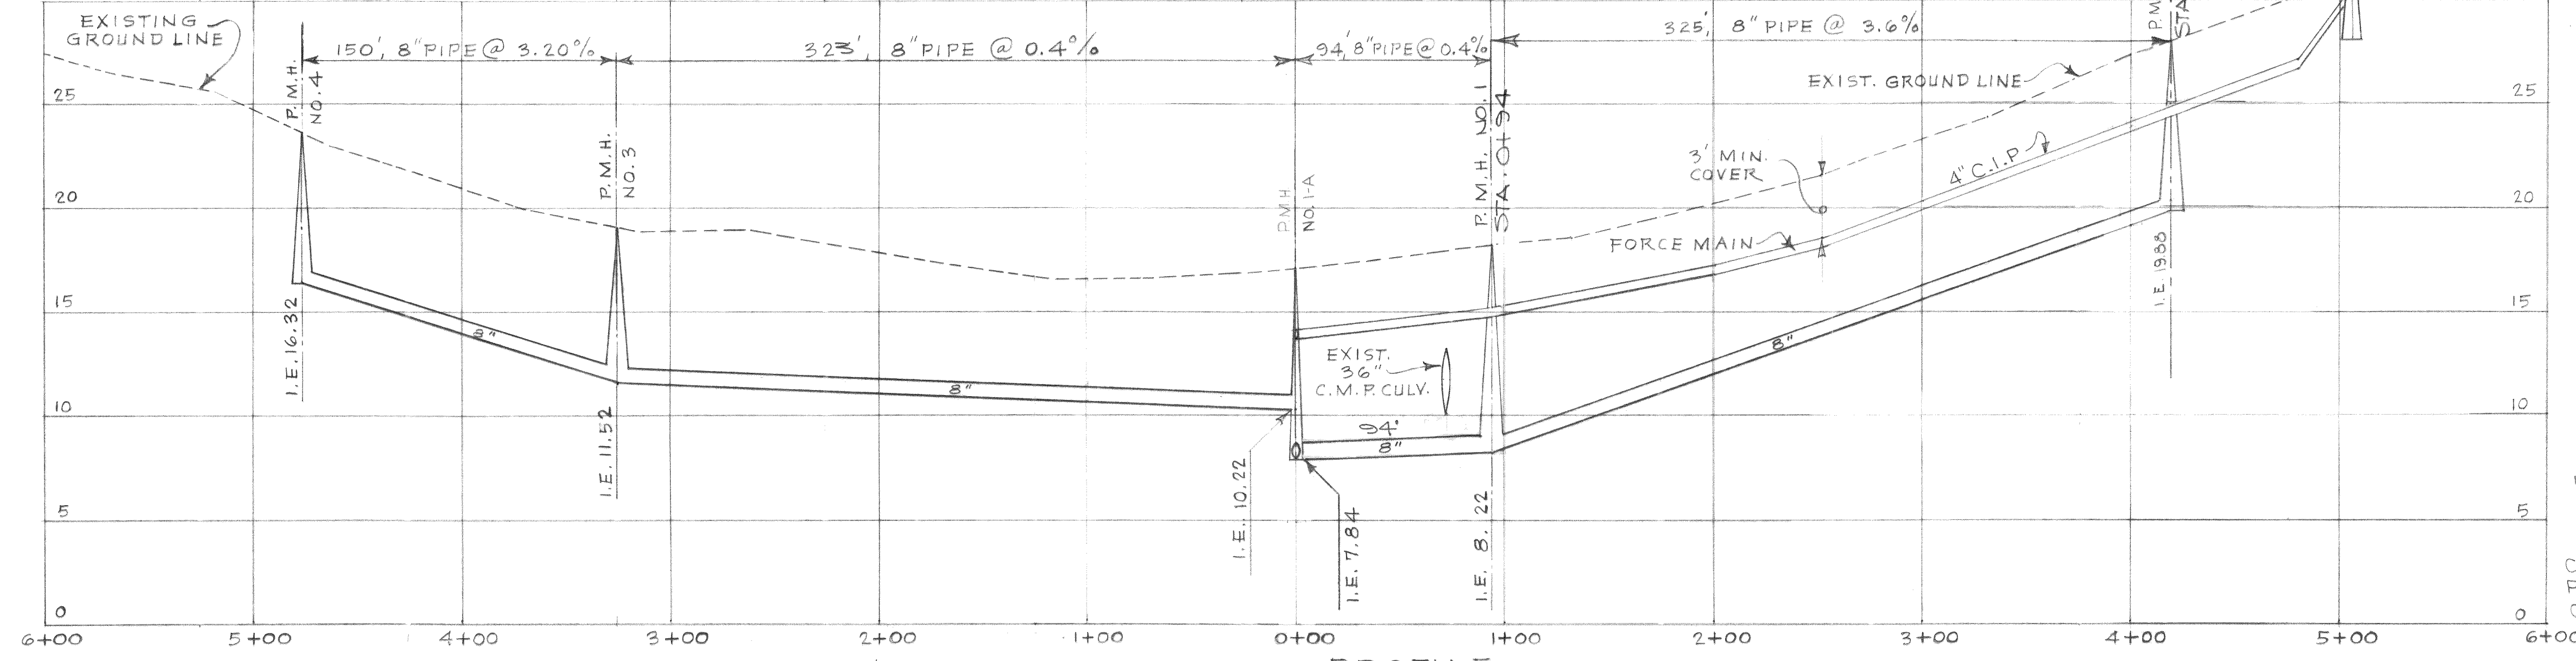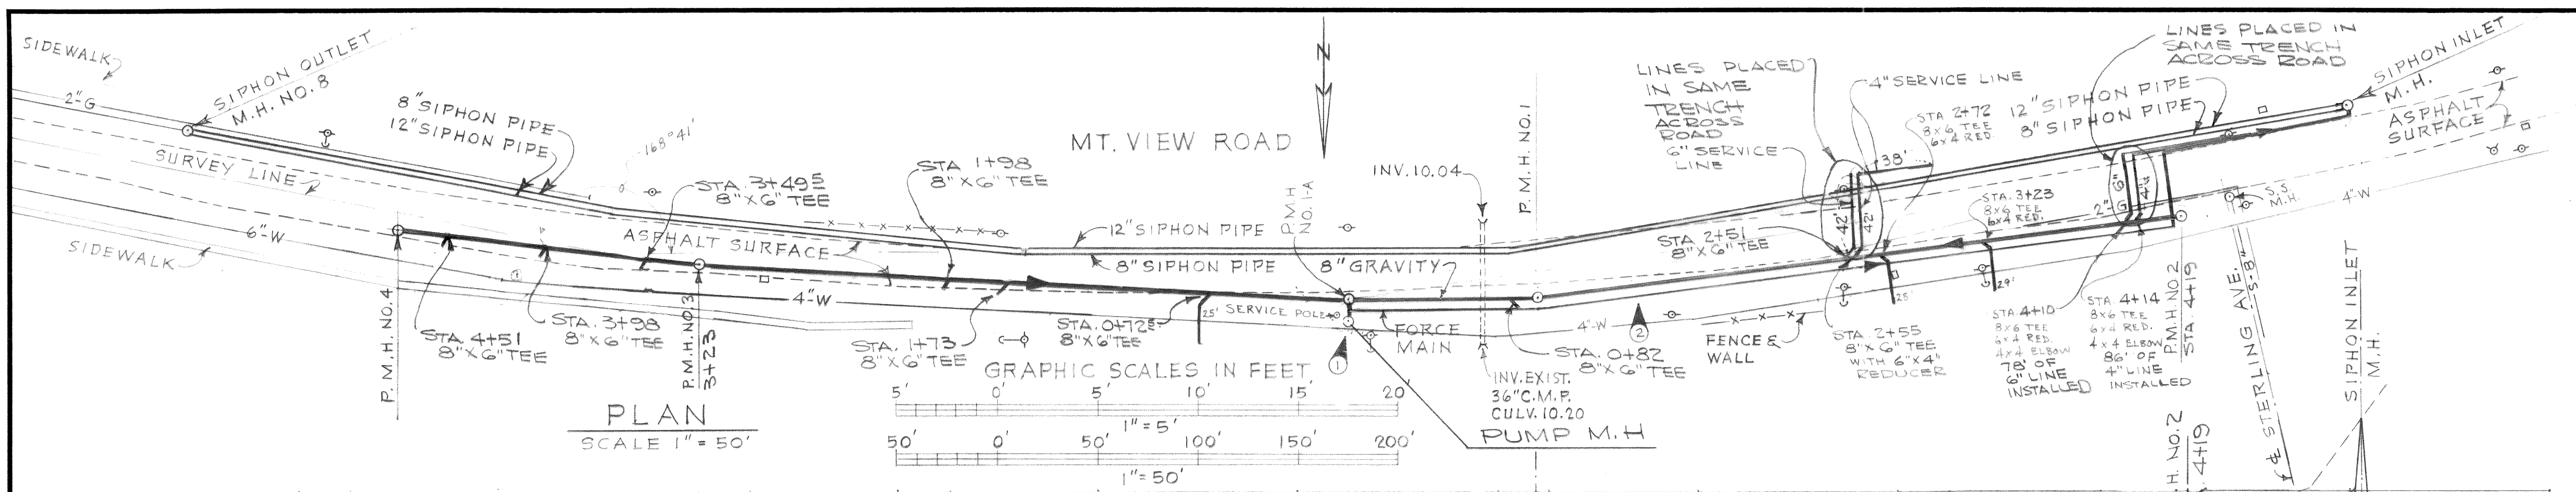

DATE	NO.	REVISION	BY	CHECKED T.S.
1/13/70	3	LOCATE TEES	RHP	DESIGNED T.S.
1/13/70	2	RELOCATE 8" GRAVITY & 4" FORCE MAIN	RHP	DRAWN L.J.M.
1/13/70	1	RELOCATE & RECONSTRUCT PUMP M.H.	RHP	

APPROVED *H.R. Murray*
SCALE AS SHOWN DATE JAN. 1969
FILE 67-S-168.002

ST
Stevens, Thompson & Runyan, Inc.
Engineers/Planners
PORTLAND, OREGON SEATTLE, WASHINGTON

TOWN OF FERNDAL, WASHINGTON
INTERCEPTOR SEWERS
SCHEDULE II









PLAN AND PROFILE
8" COLLECTOR AND PUMP MANHOLE

AS BUILT
JAN 1970

MICROFILMED


6
7

00211.000 2-7-06 22

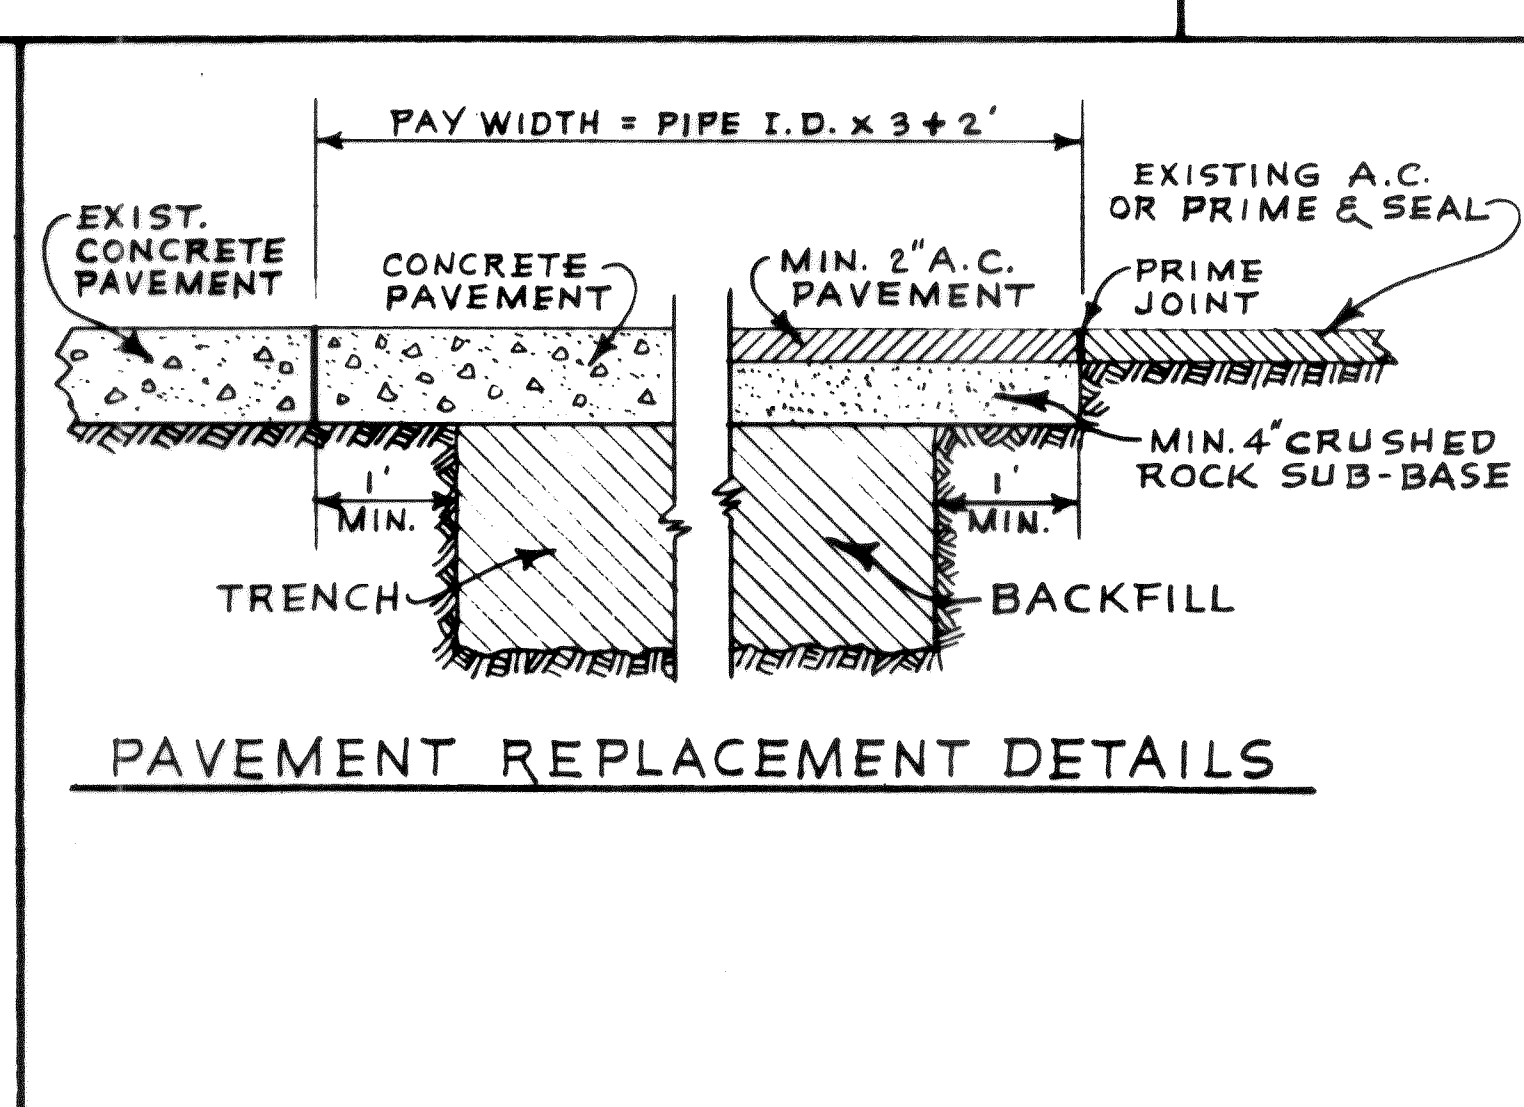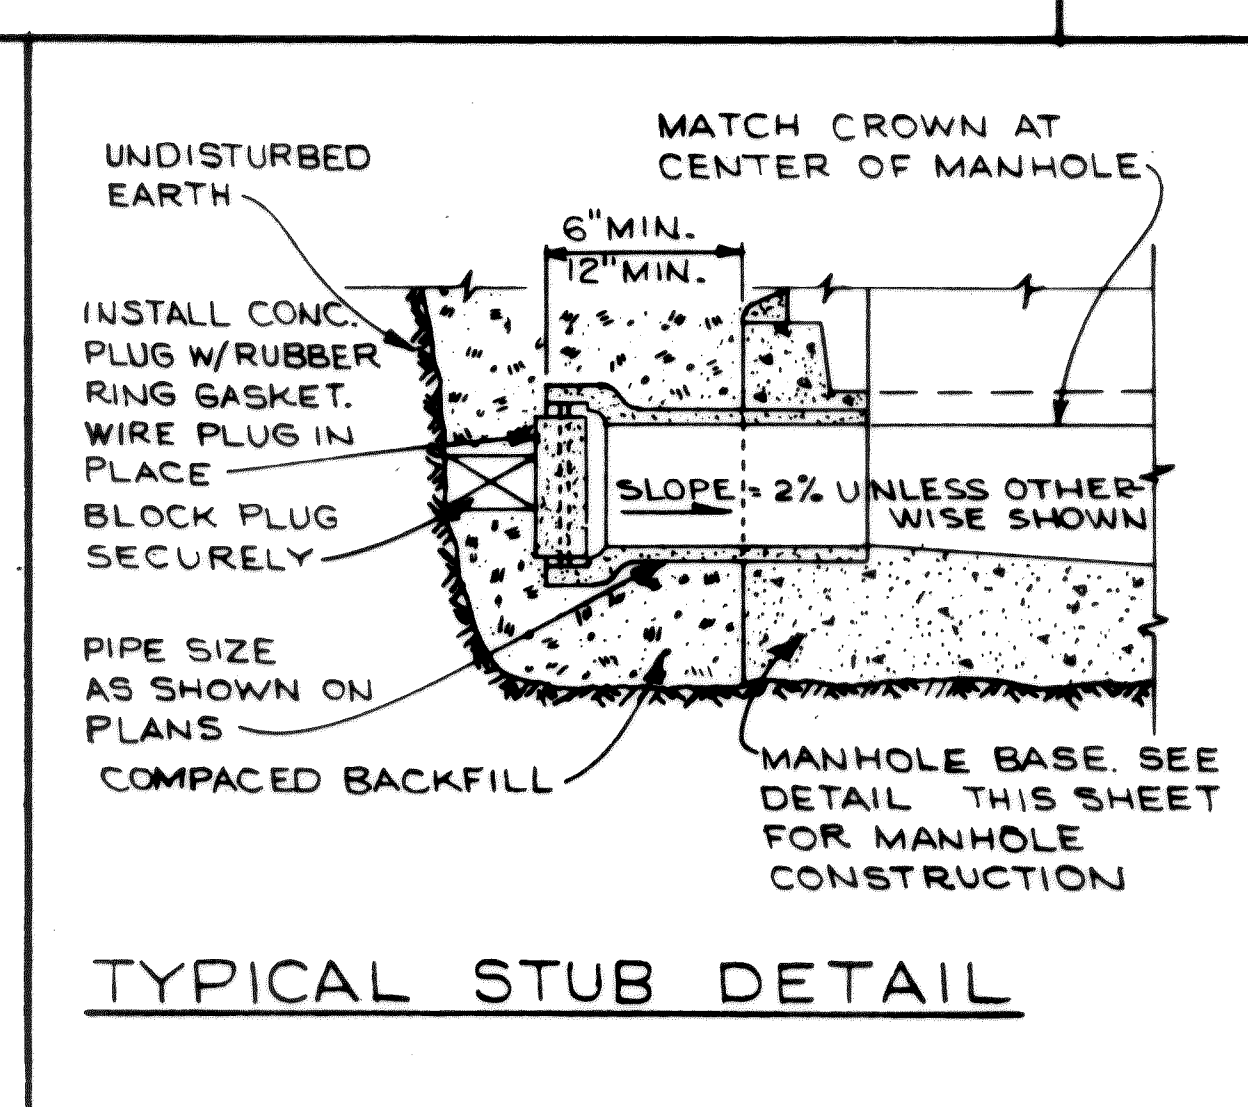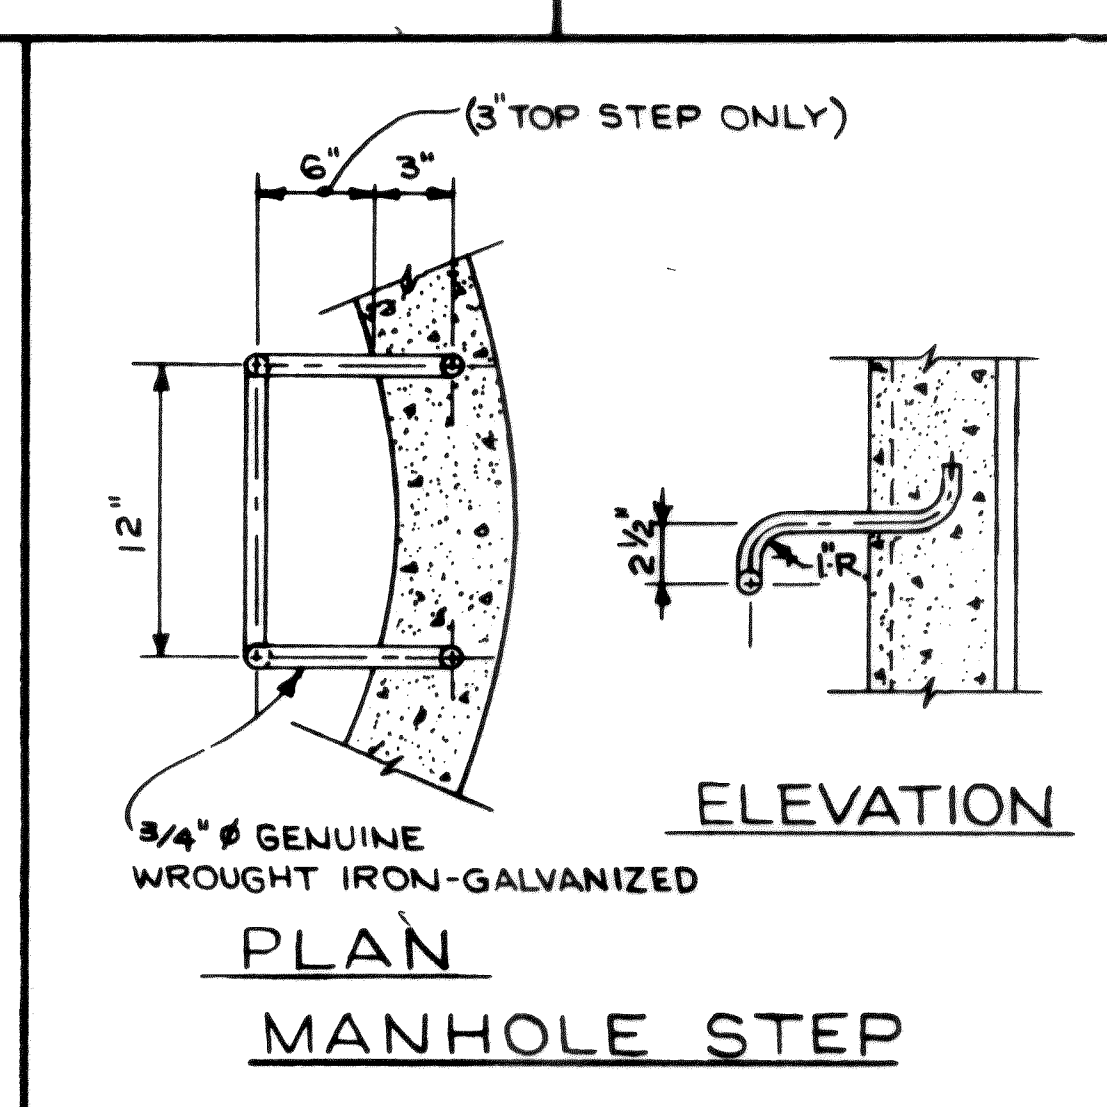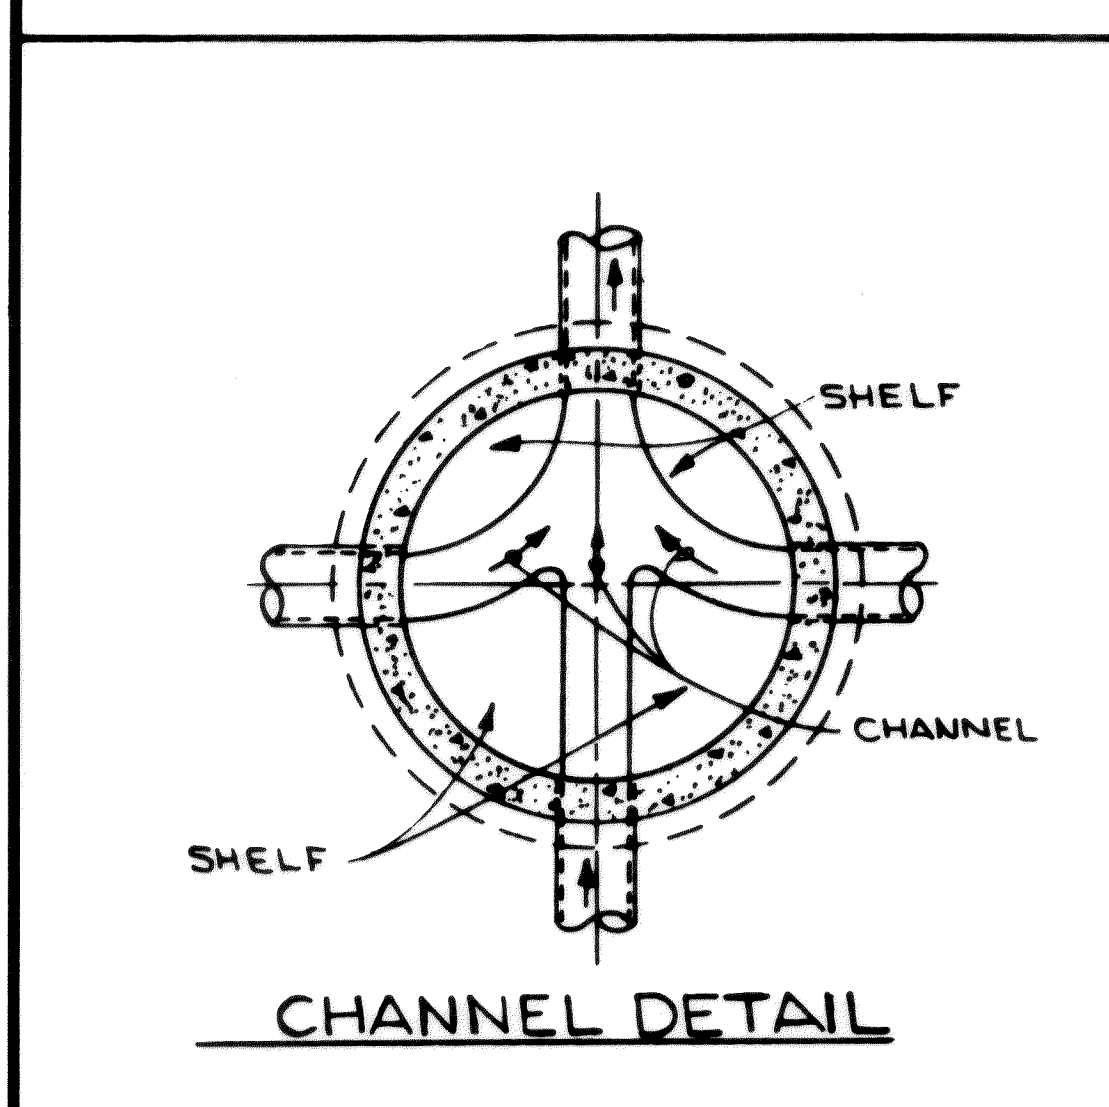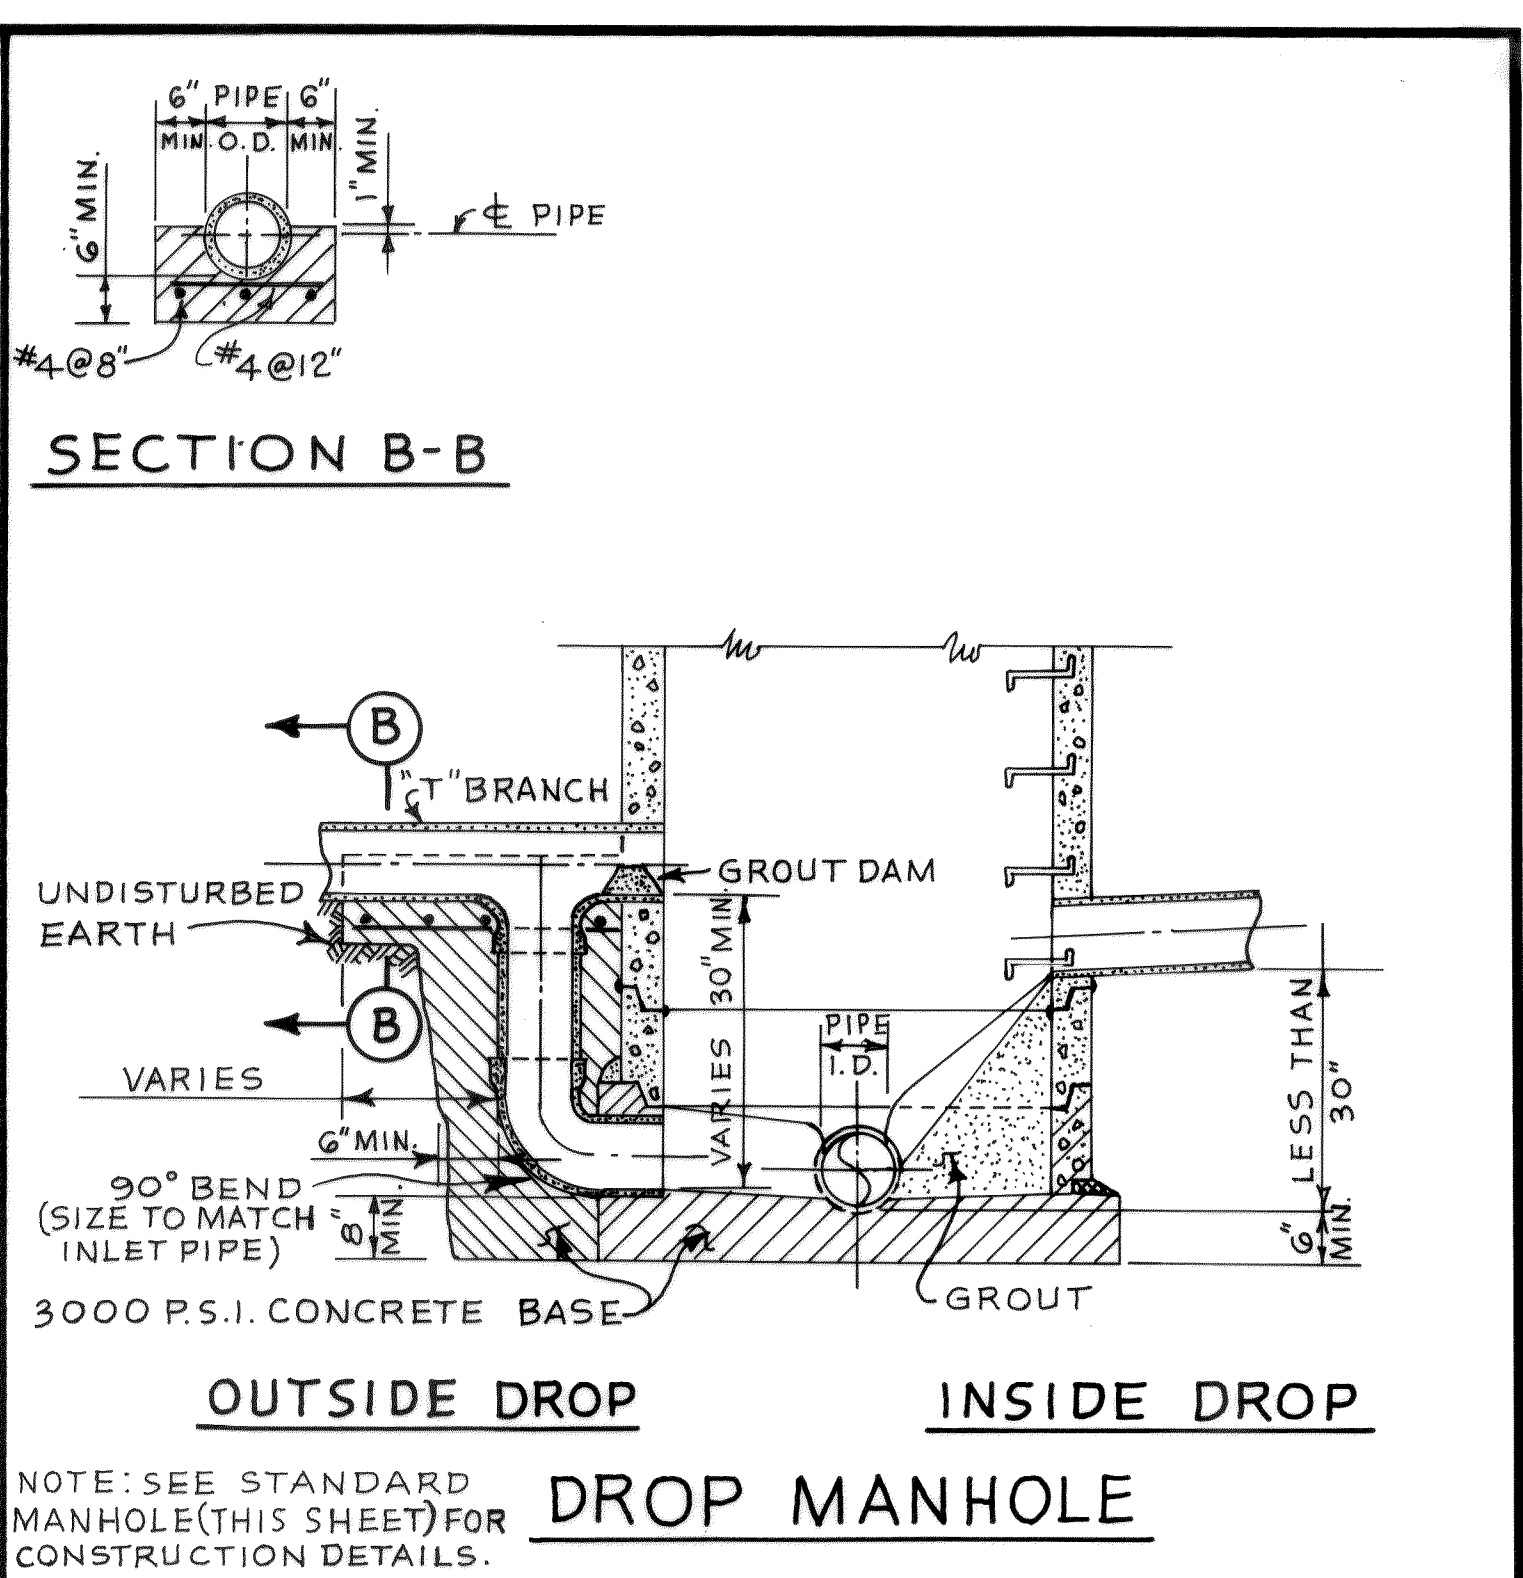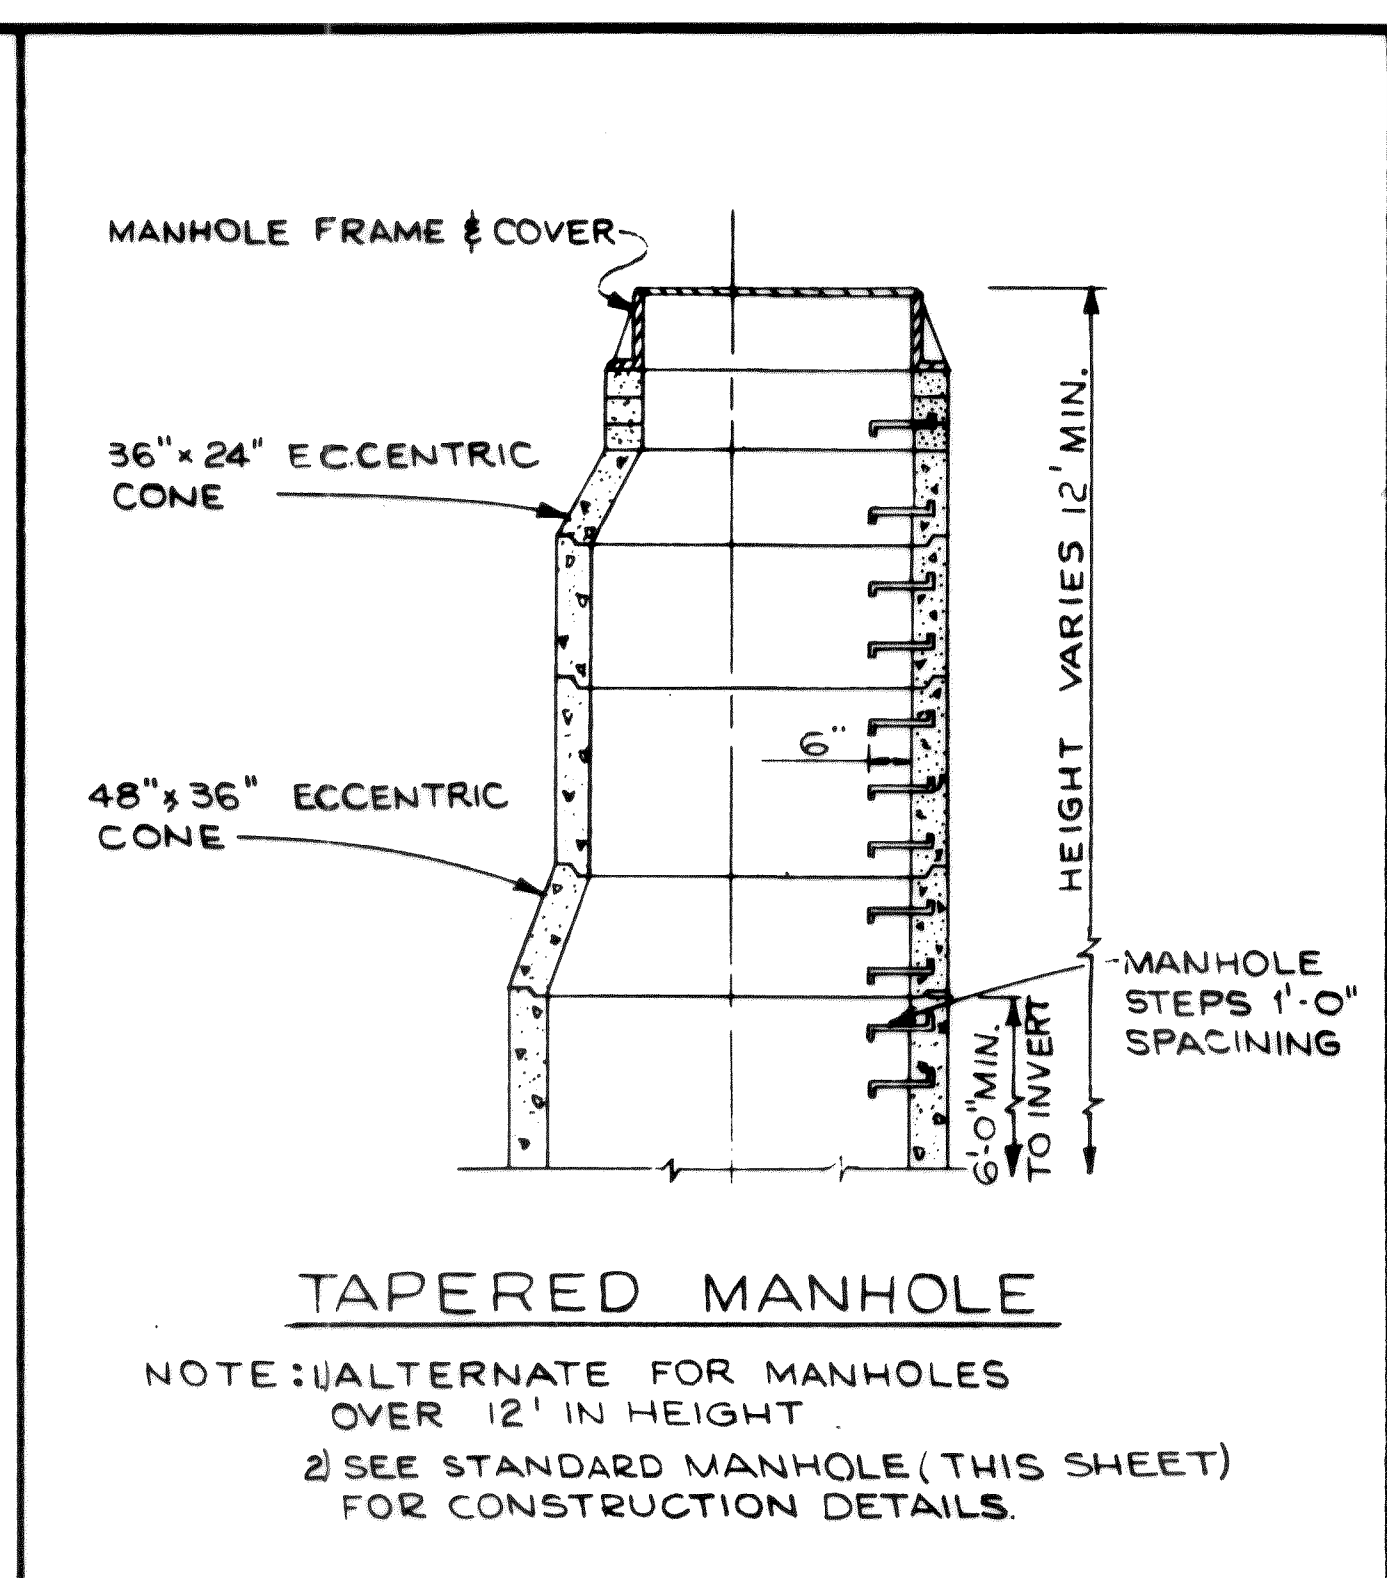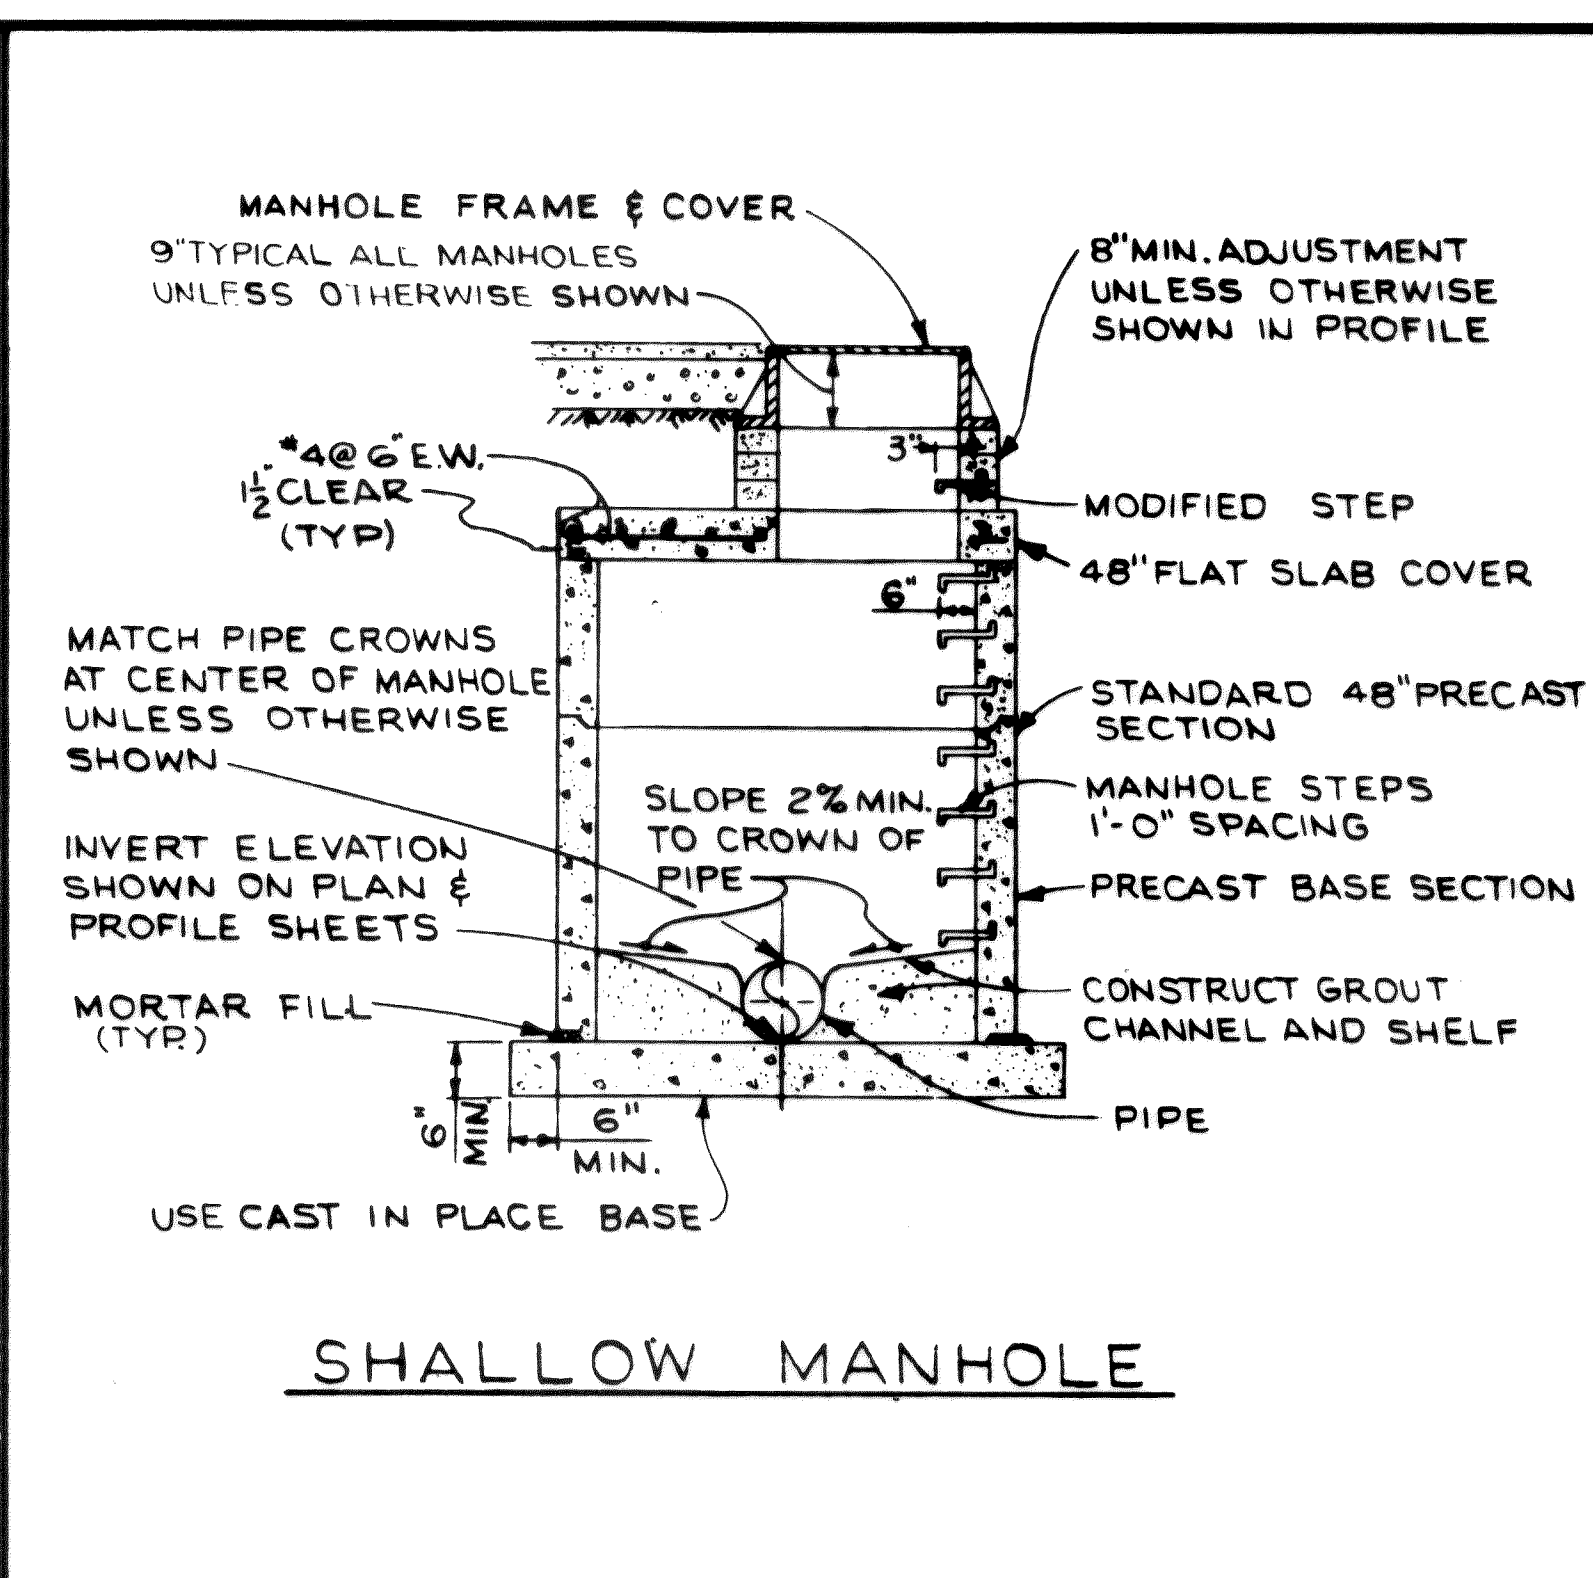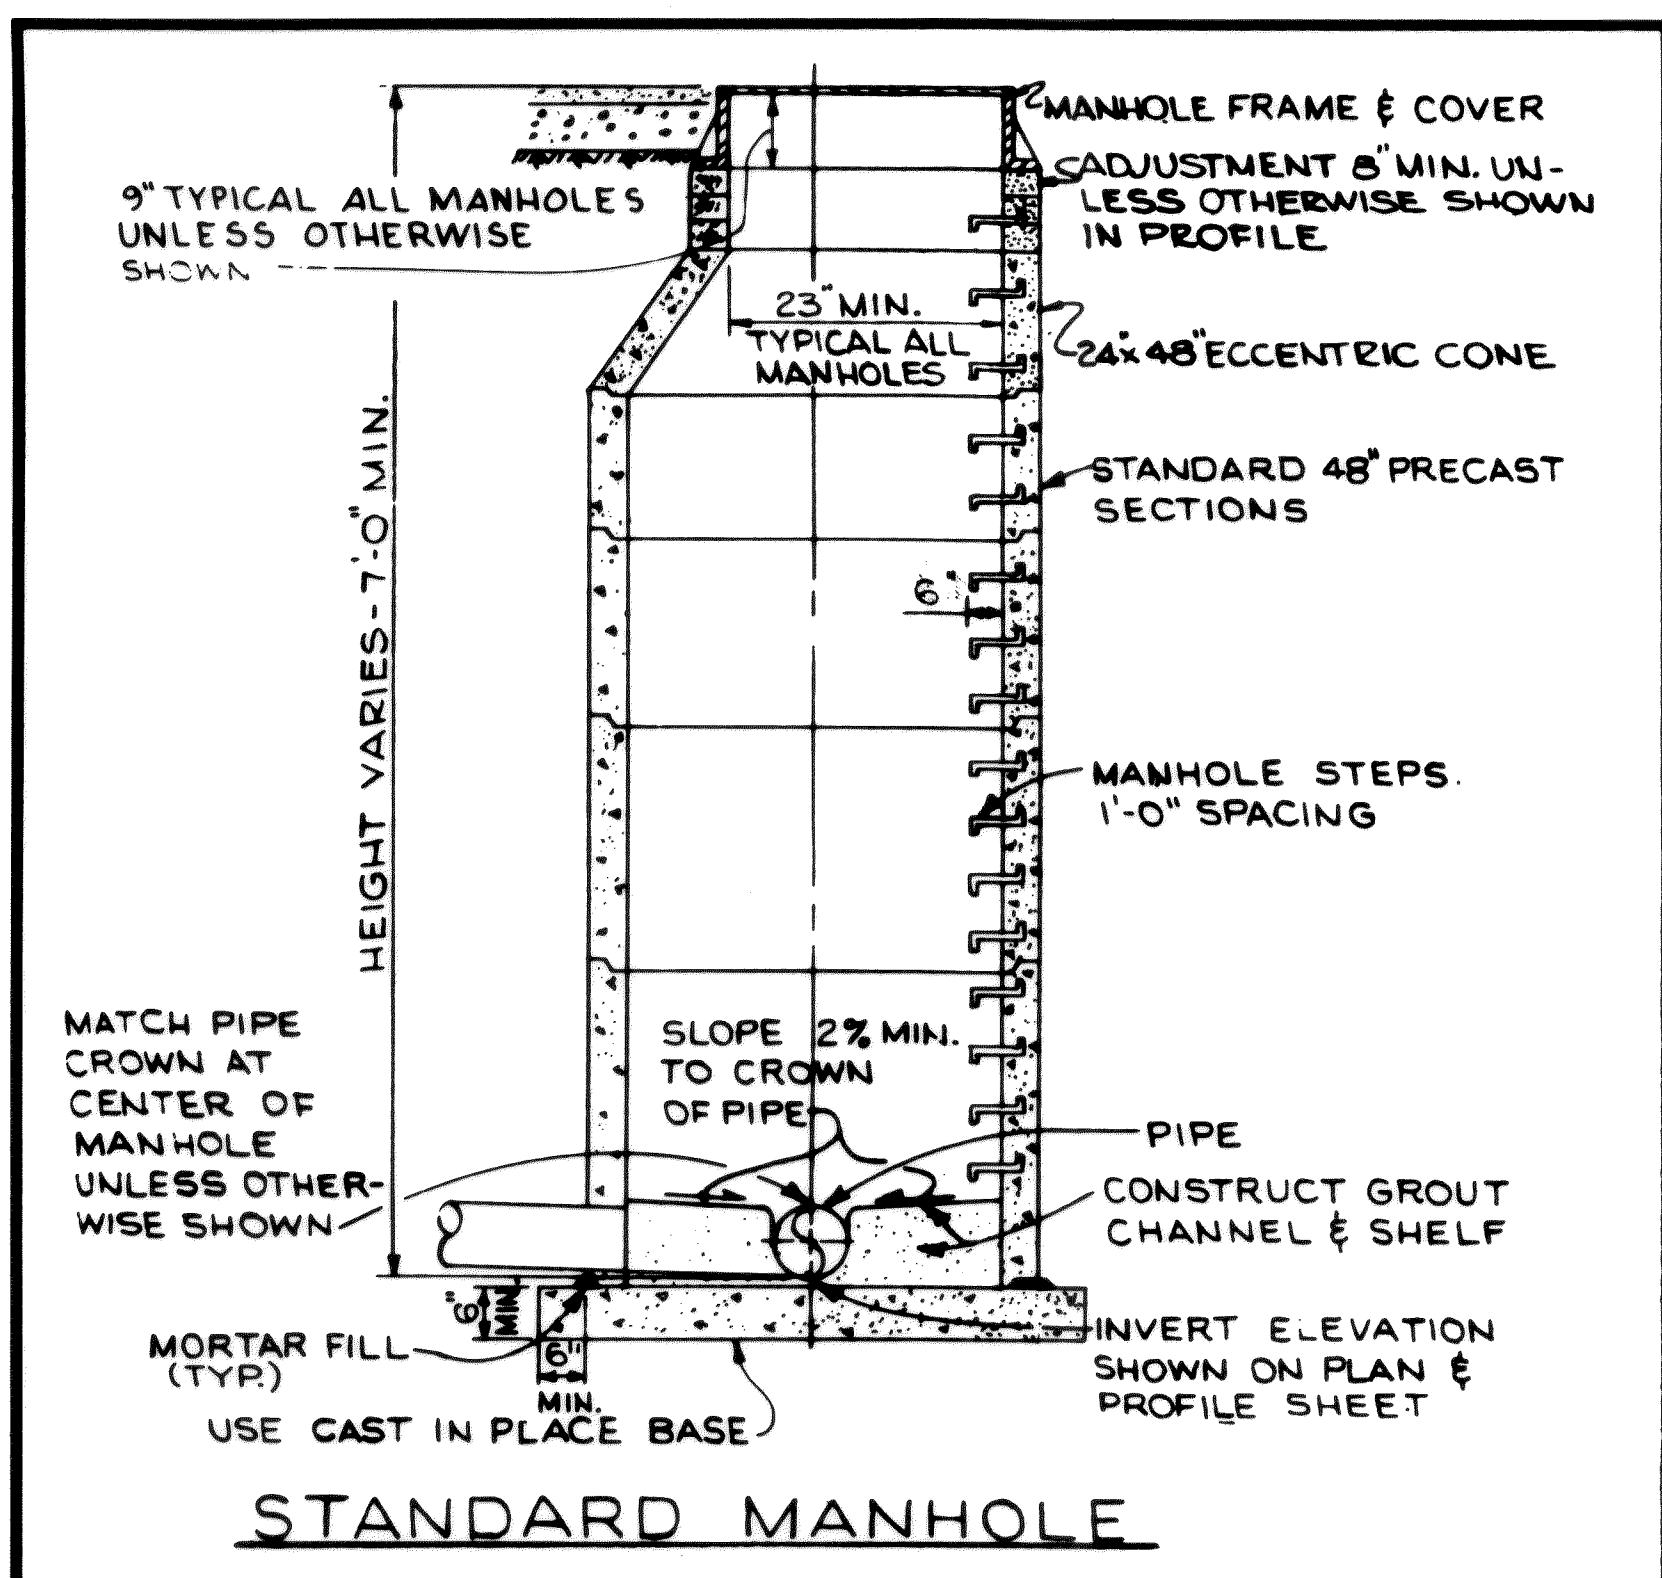

PAVEMENT REPLACEMENT NOTES

1. CONCRETE SURFACE TO BE REPLACED WITH 3000 P.S.I. CONCRETE TO SAME THICKNESS AS EXISTING PAVEMENT.
2. ASPHALT PRIME & SEAL AND ASPHALTIC CONCRETE SURFACES TO BE REPLACED WITH NOT LESS THAN 2\"/>

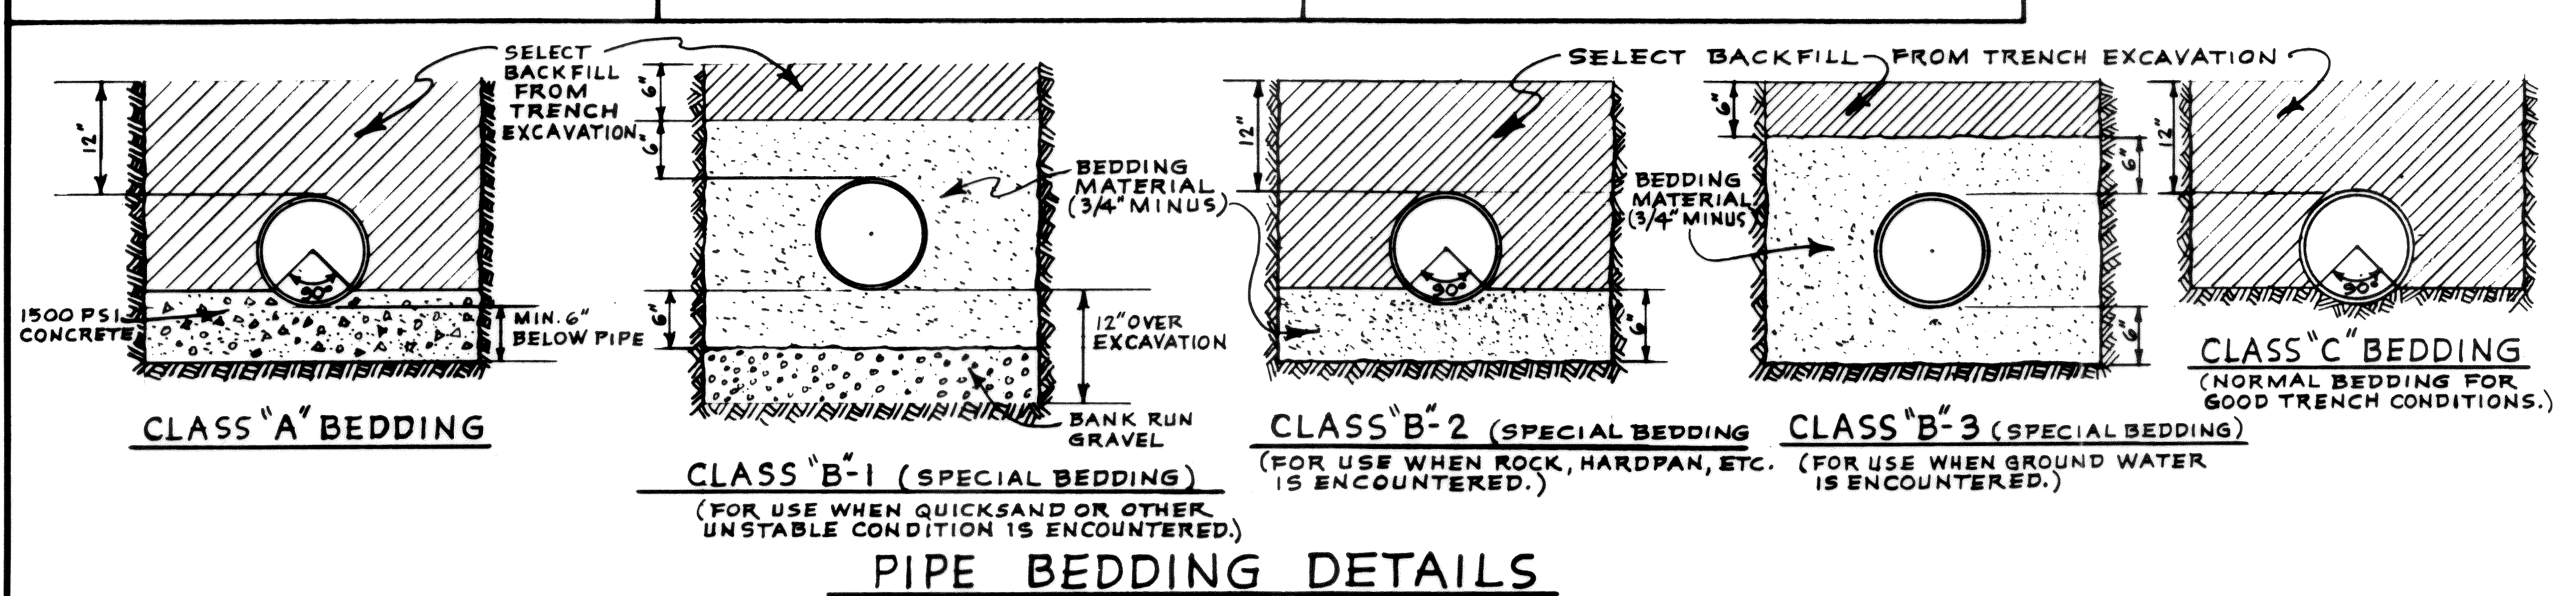

PIPE BEDDING NOTES

1. MAXIMUM TRENCH WIDTH AT TOP OF PIPE SHALL NOT EXCEED THREE TIMES THE PIPE I.D.
2. TRENCH BEDDING AND BACKFILL SHALL BE THOROUGHLY COMPACTED TO A PLANE ONE FOOT ABOVE THE TOP OF THE PIPE. SEE SPECS. FOR REMAINDER OF BACKFILL.
3. PAY WIDTH FOR BEDDING MATERIAL SHALL BE THREE TIMES THE PIPE I.D.