




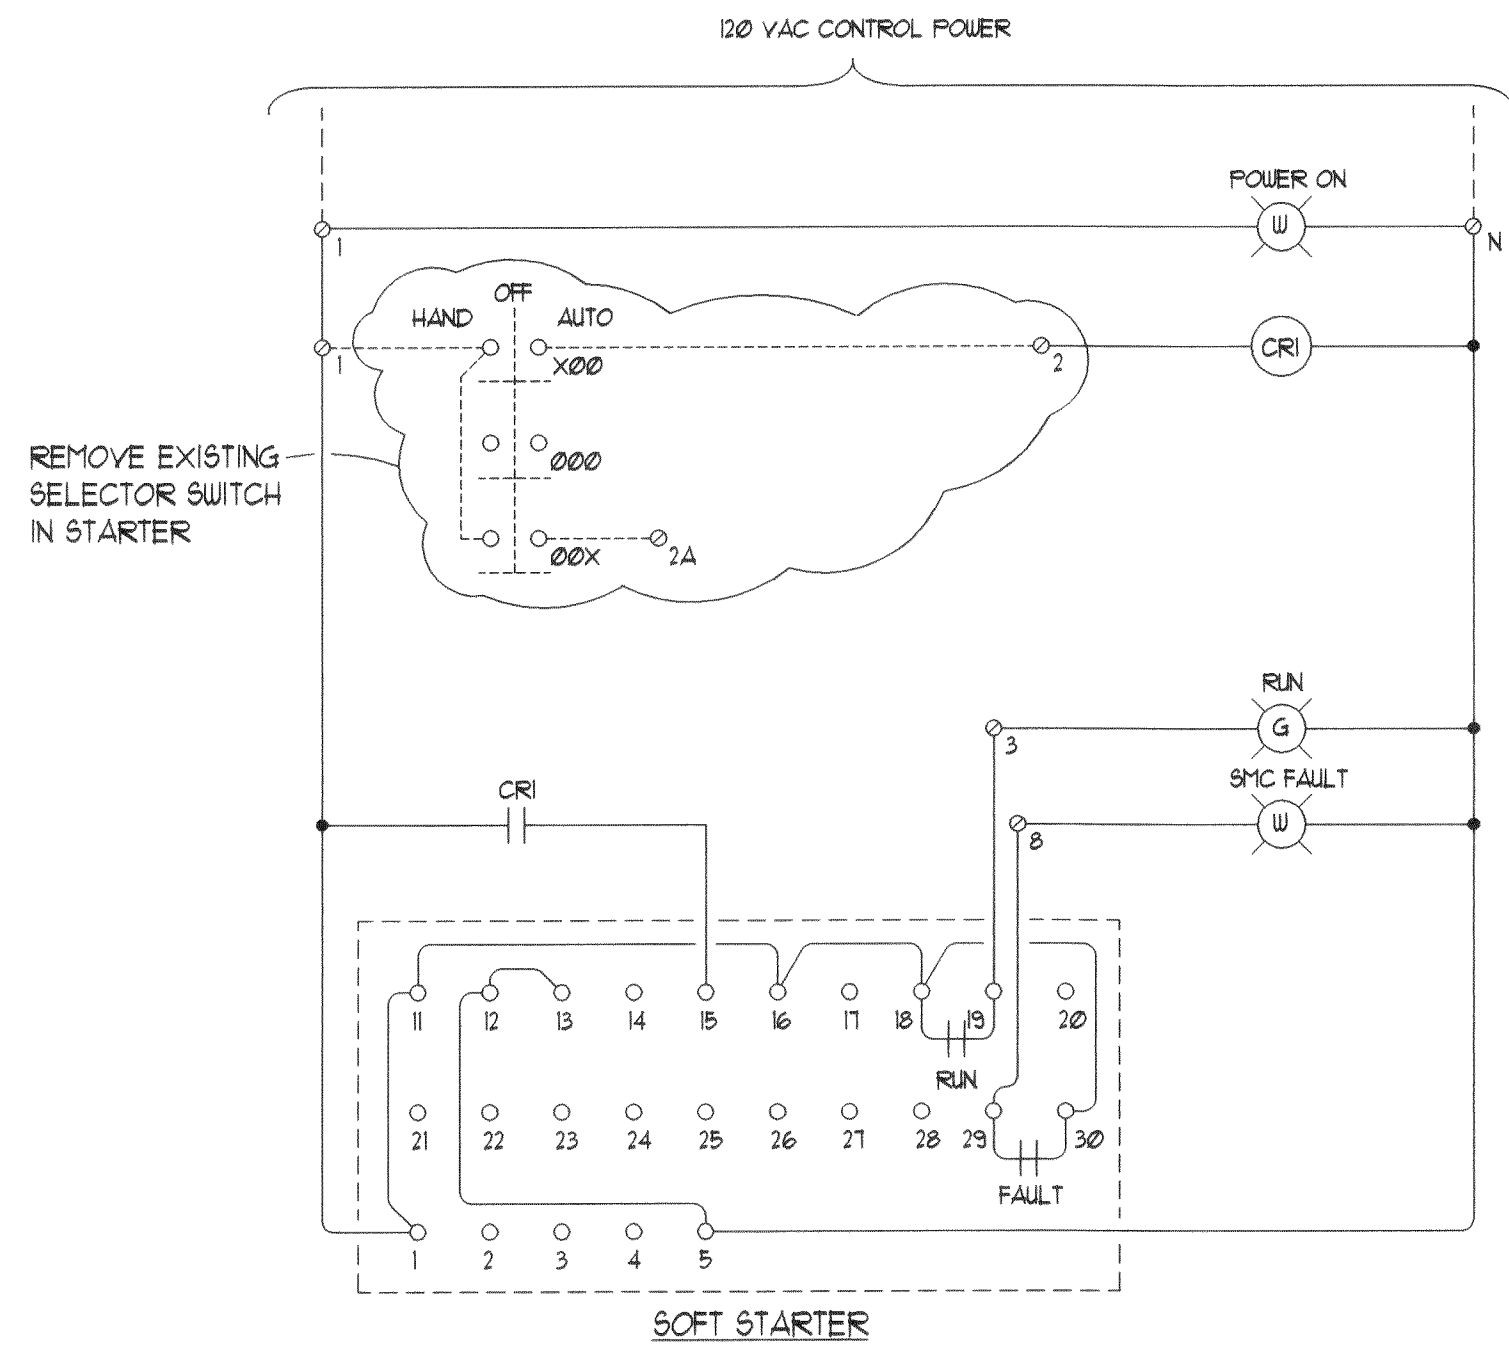

CONTROL SCHEMATIC DIAGRAM
BOOSTER PUMP # 3

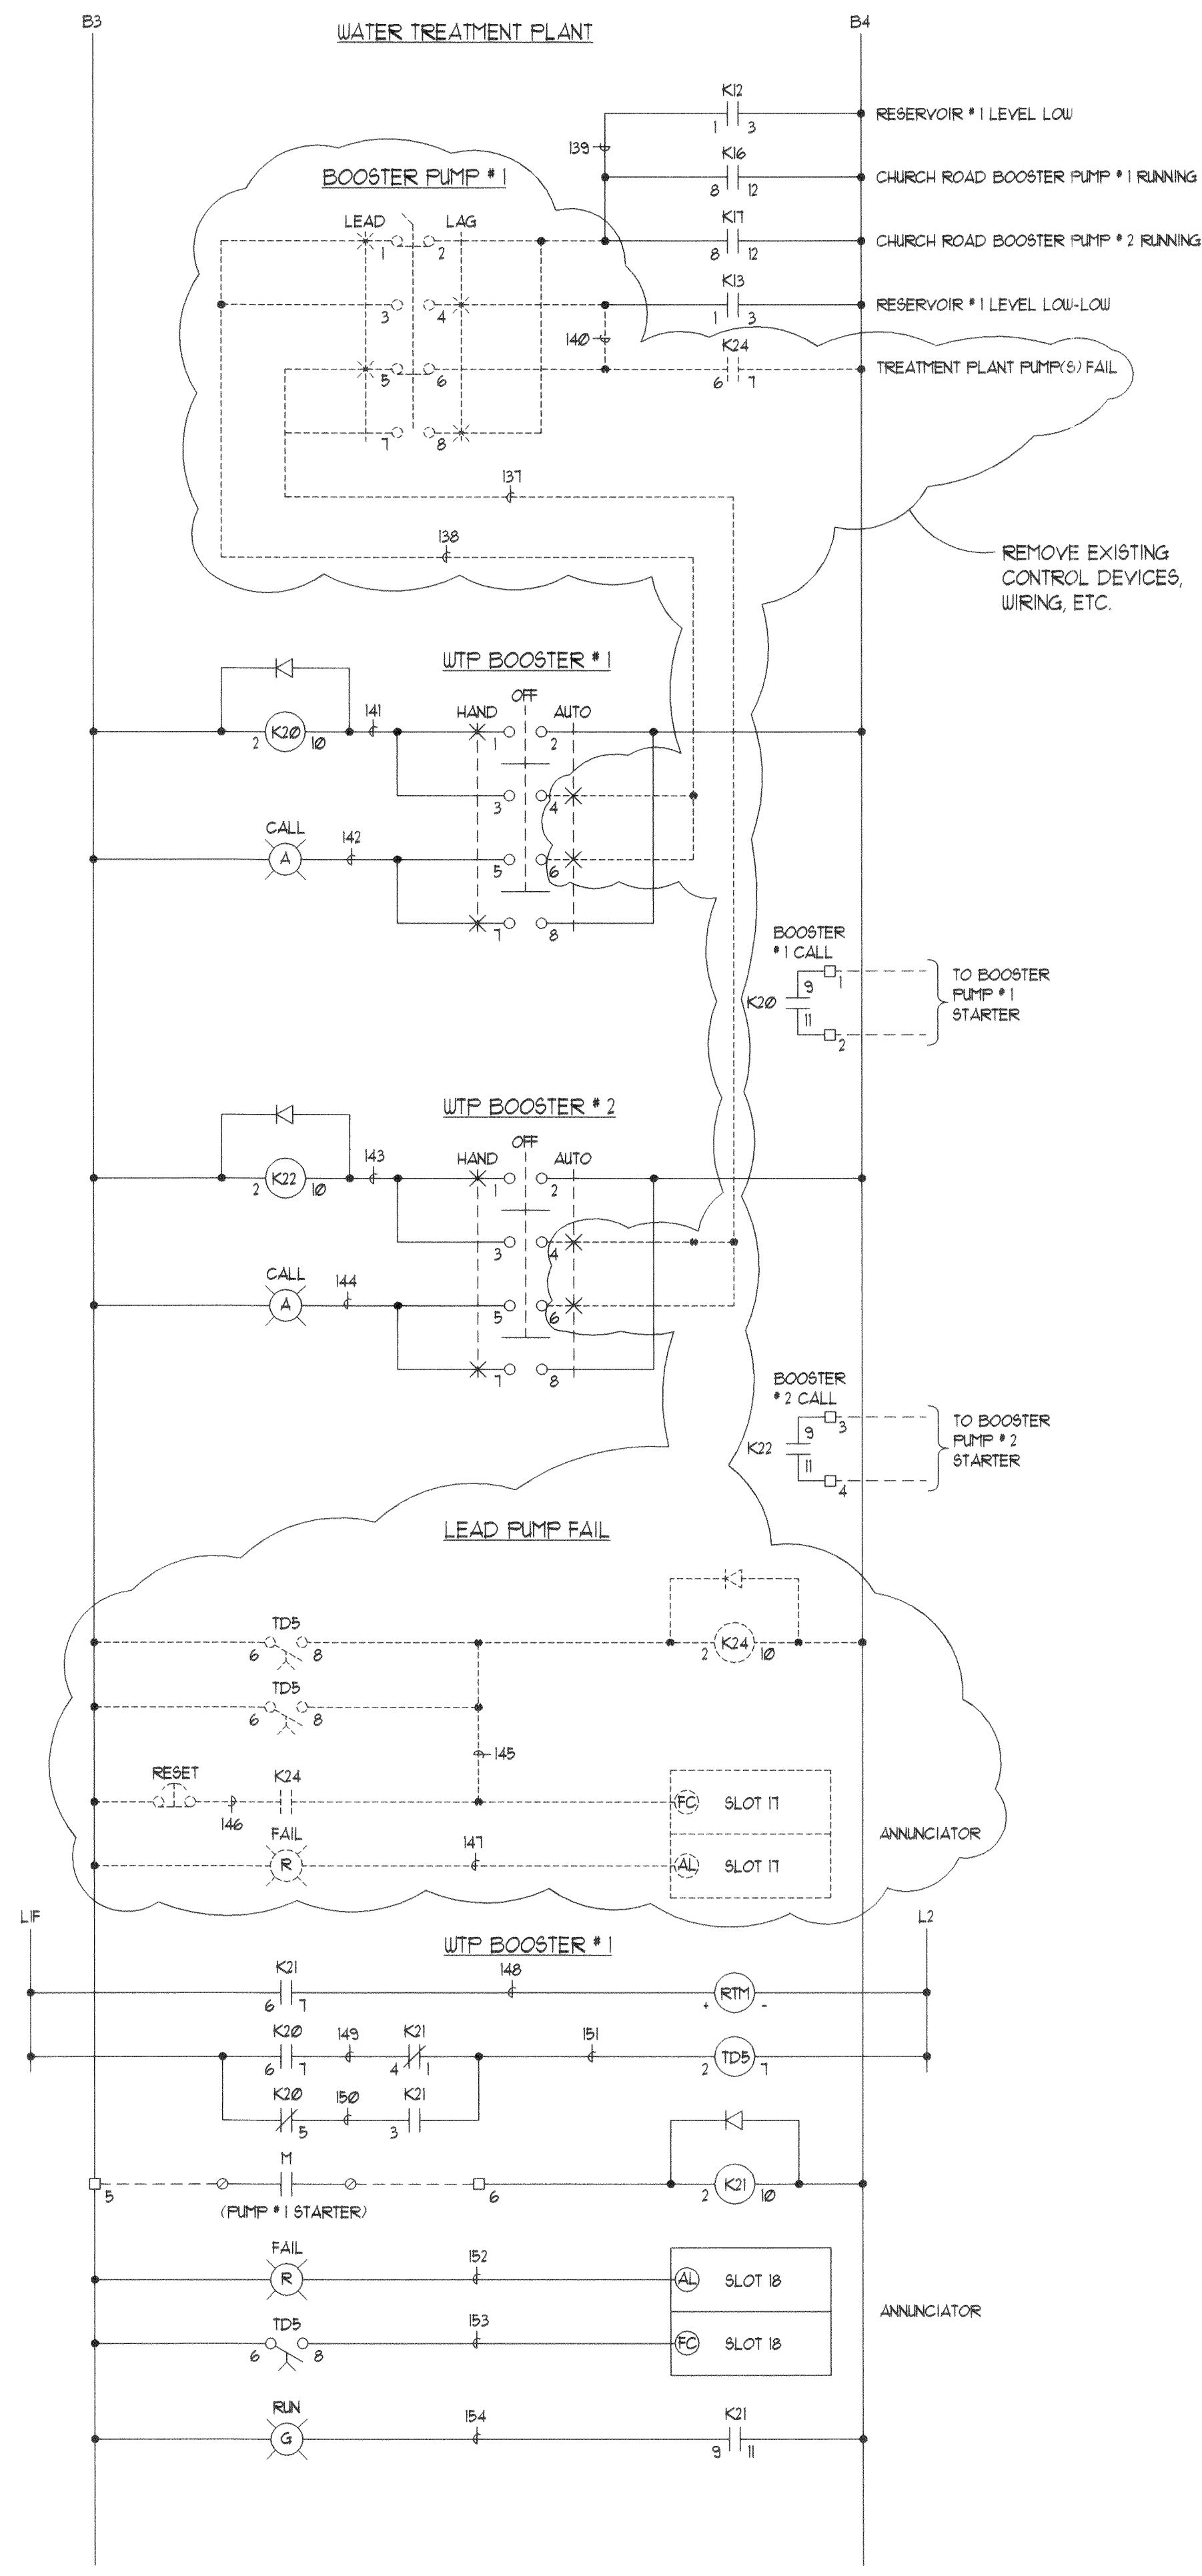

PARTIAL CONTROL PANEL SCHEMATIC DIAGRAM -
WATER TREATMENT PLANT BOOSTER PUMPS

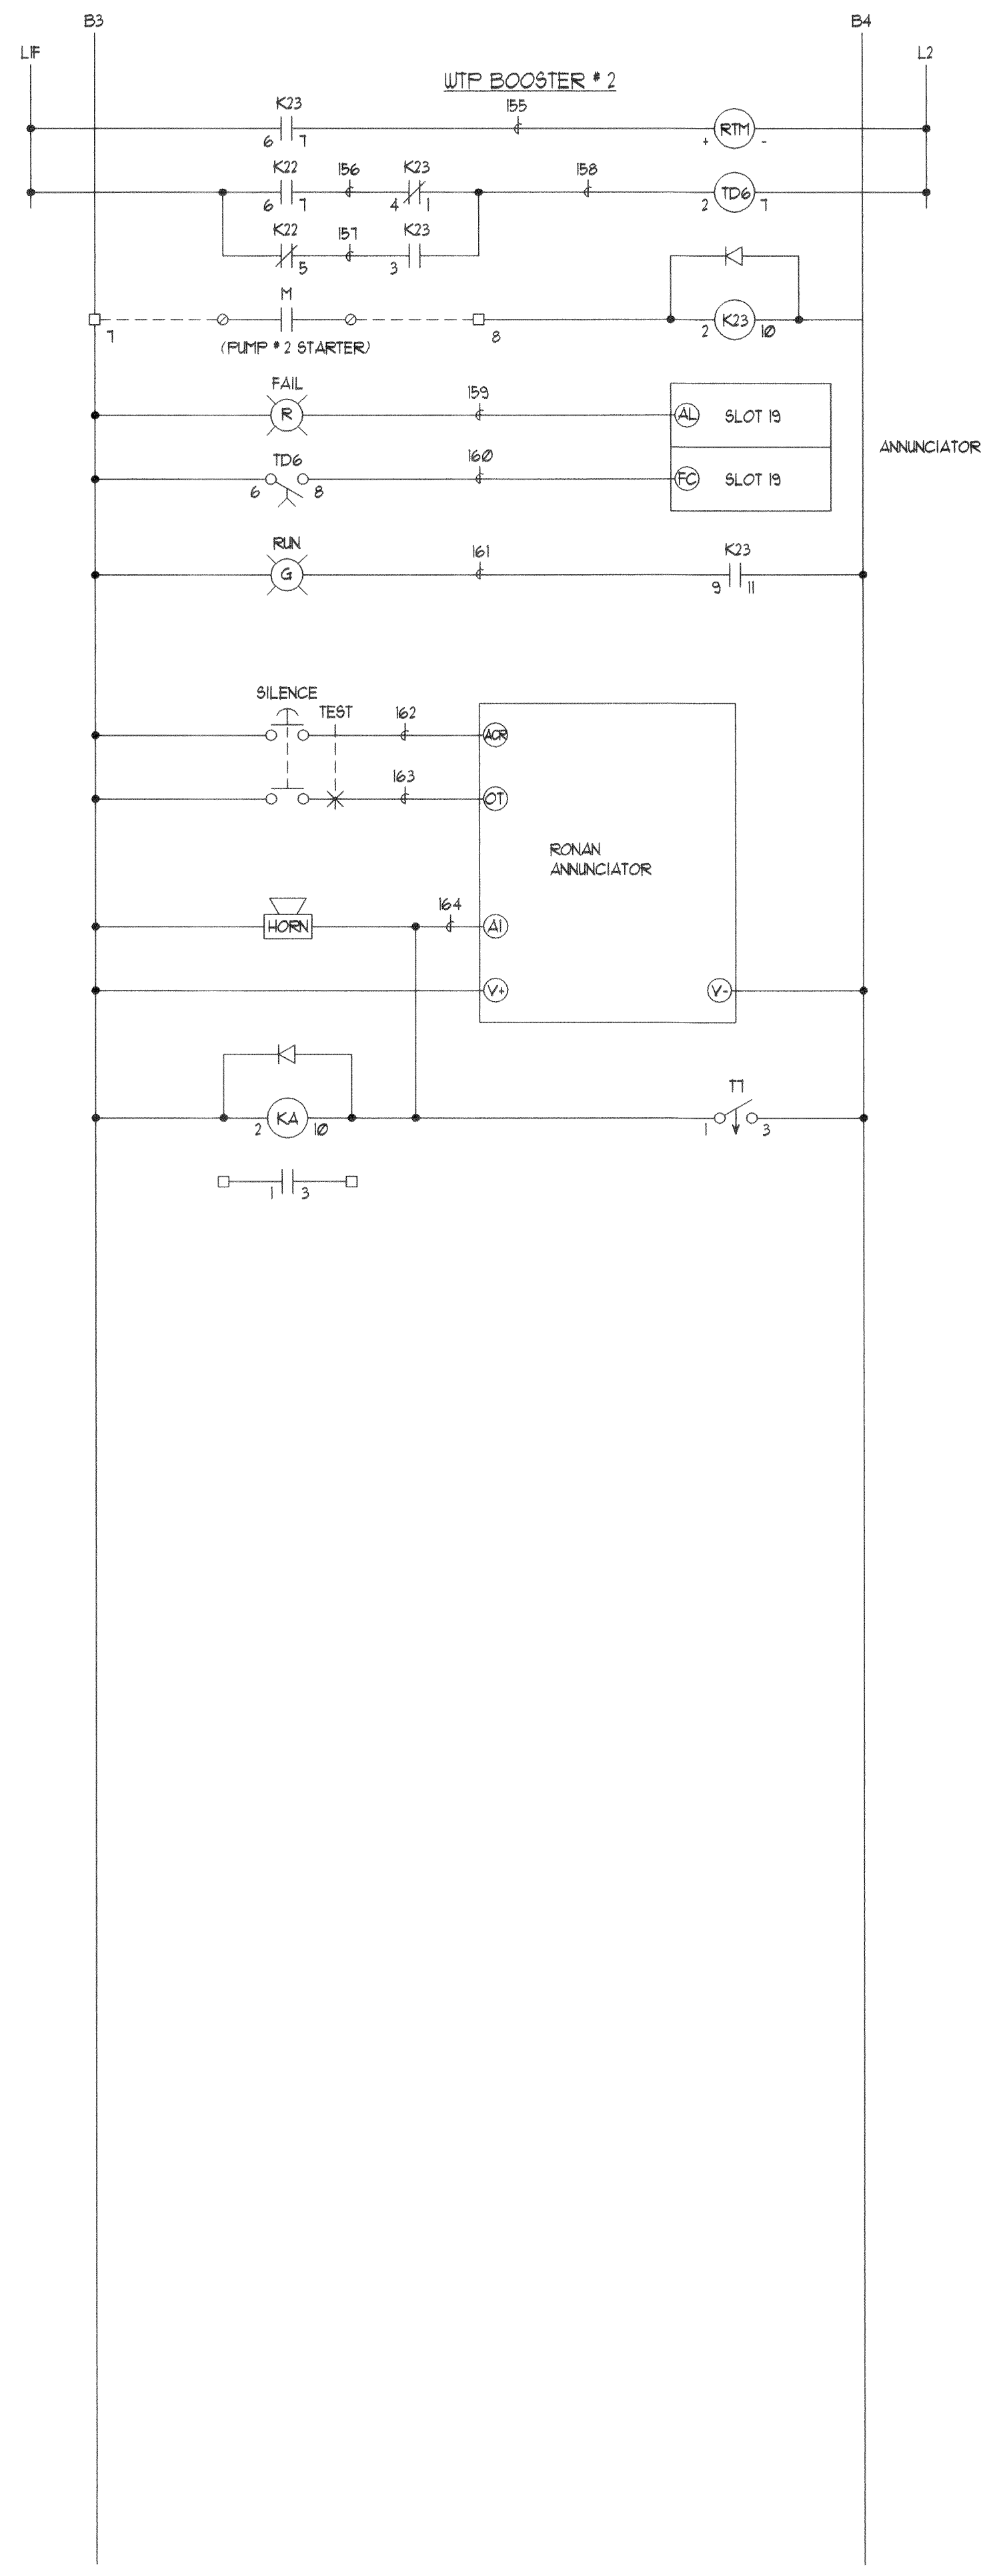

REVISIONS	BY

EXP. 2/23/02

KENNETH KOK, P.E.
ELECTRICAL ENGINEER
208 THIRD STREET
LYNDEN, WA. 98044
TEL. (360) 354-4151
FAX (360) 354-6194


FERNDAL
WATER TREATMENT PLANT

ELECTRICAL
SCHEMATIC DIAGRAM - EXISTING


DATE: 23 OCTOBER 2000
SCALE: NONE
DRAWN: KL
DESIGNED: KK
SHEET
OF x SHEETS

00047.001 2-2-06 KR

City Project No. WA2000-01 High Head Booster Pump

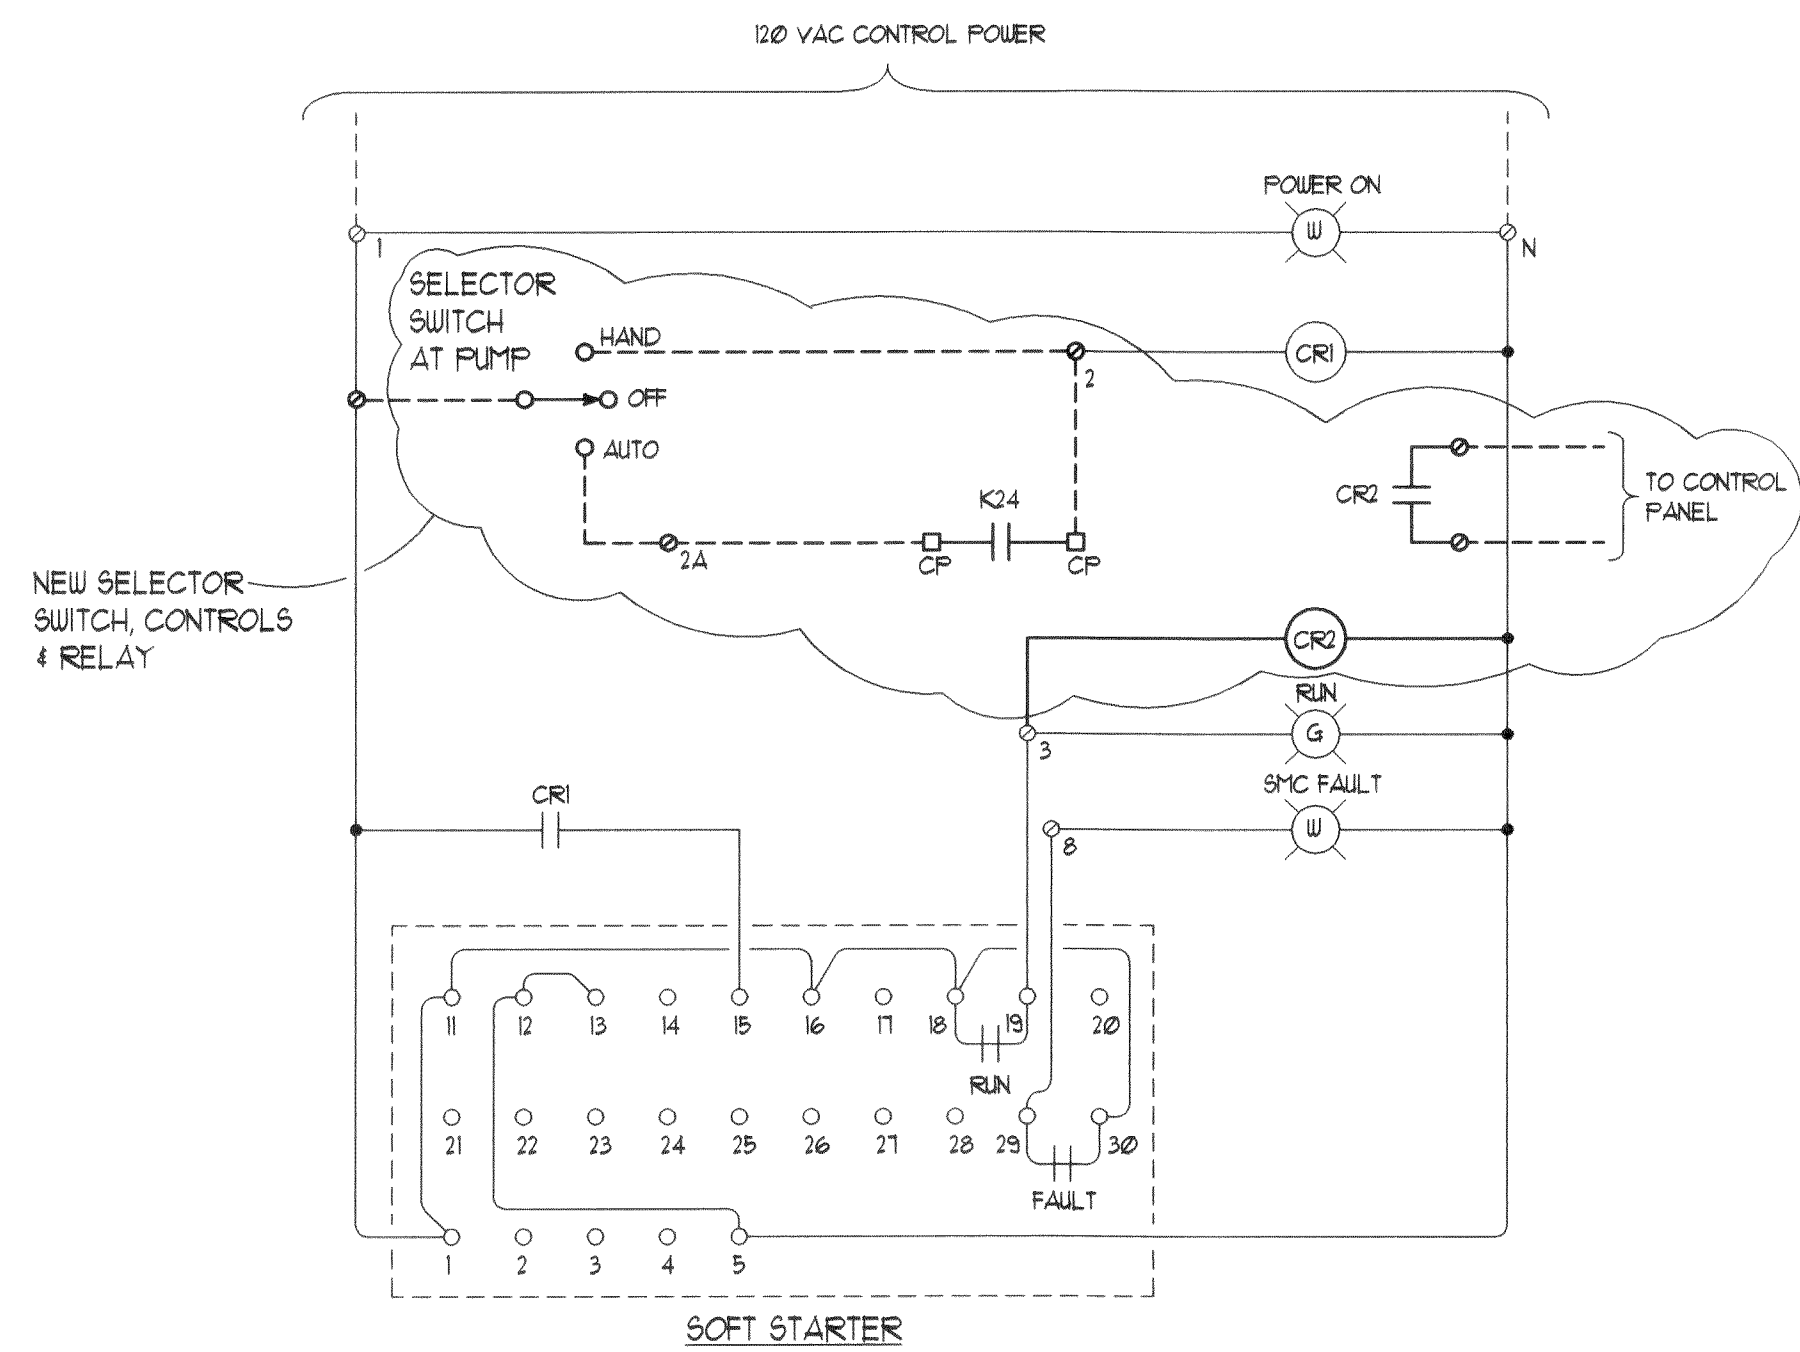

CONTROL SCHEMATIC DIAGRAM
BOOSTER PUMP # 3

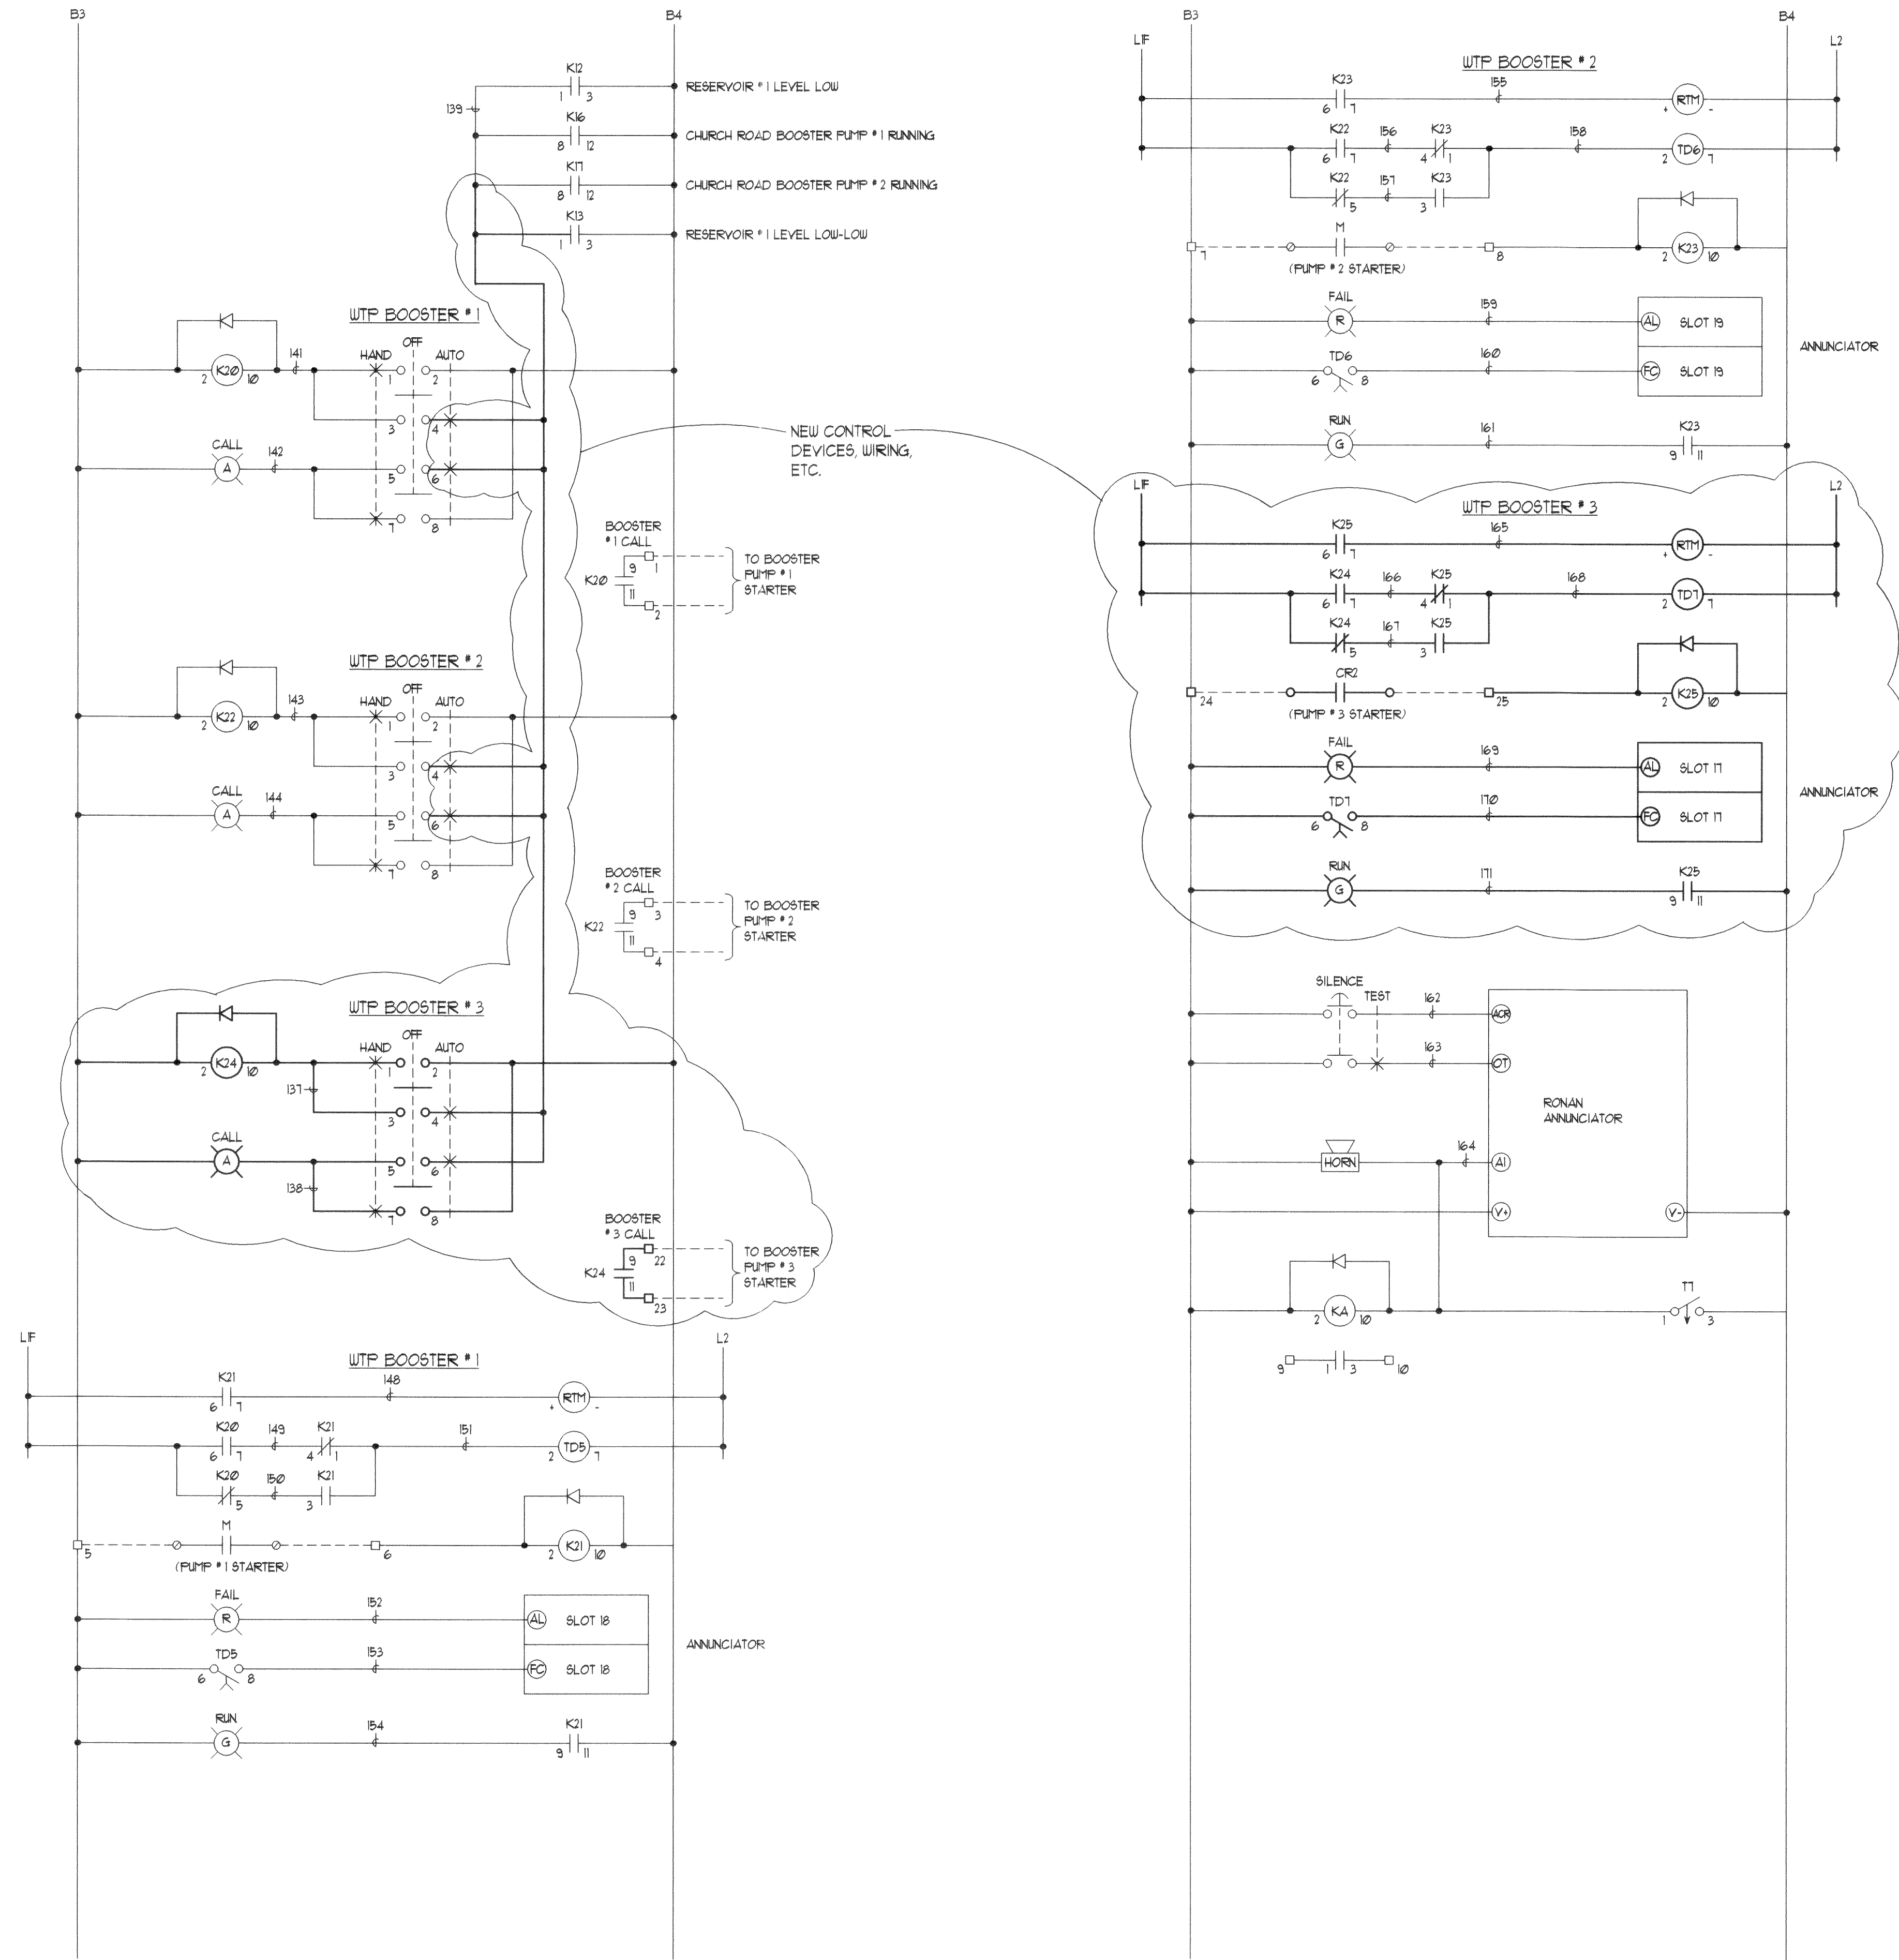

PARTIAL CONTROL PANEL SCHEMATIC DIAGRAM -
WATER TREATMENT PLANT BOOSTER PUMPS

REVISIONS	BY

KENNETH KOK, P.E.
ELECTRICAL ENGINEER
208 THIRD STREET
LYNDEN, WA 98264
TEL. (360) 354-4151
FAX (360) 354-6194

FERNDALE
WATER TREATMENT PLANT

ELECTRICAL
SCHEMATIC DIAGRAM - NEW

DATE: 23 OCTOBER 2000
SCALE: NONE
DRAWN: KL
DESIGNED: KK
SHEET E2
OF X SHEETS

City Project No. WA2000-01 Ferndale Booster Pump

00047.002. 2.2.06 RL