
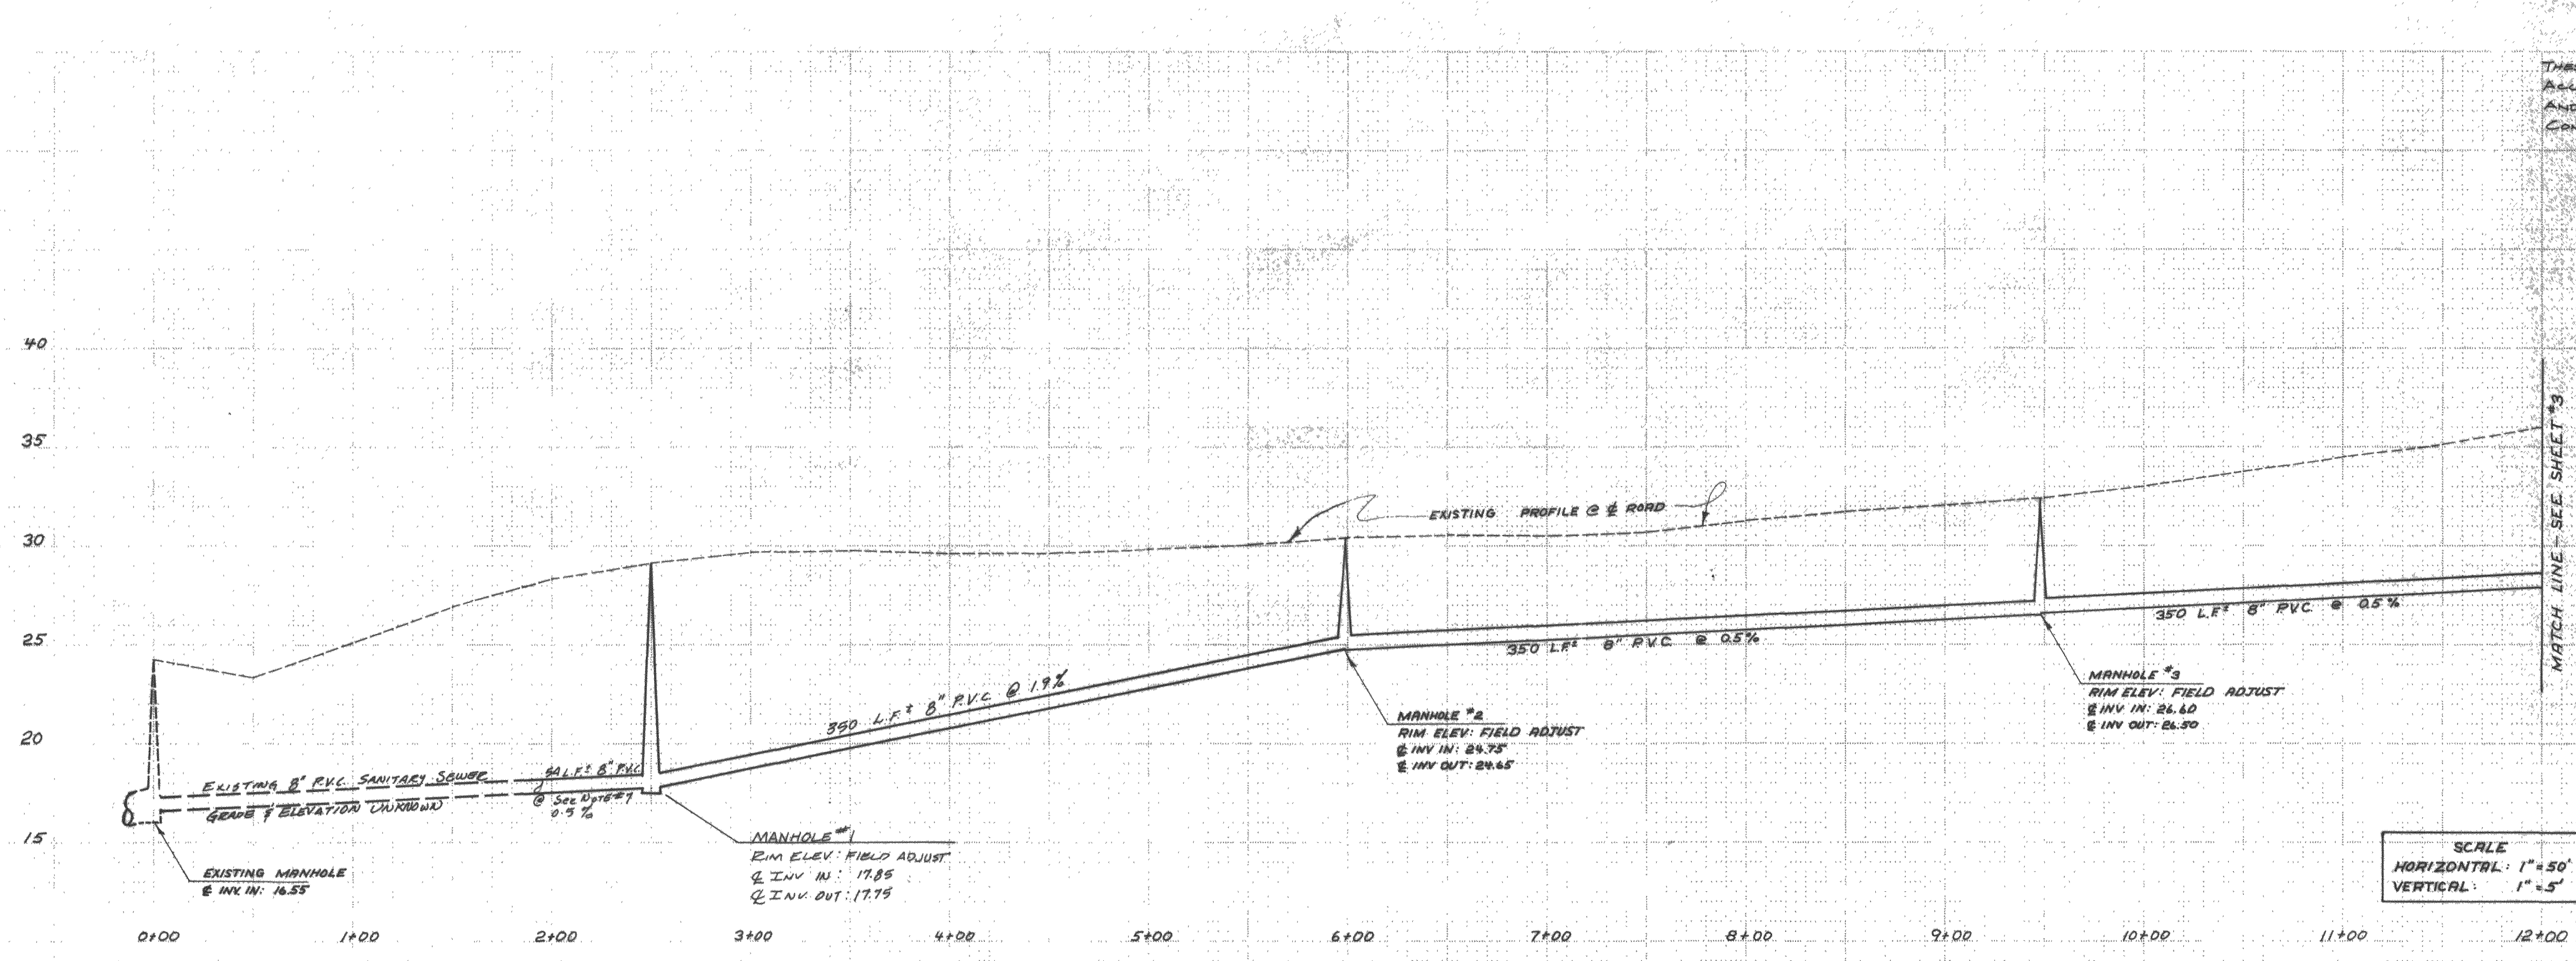


20207.00 2:14:06 100.0000

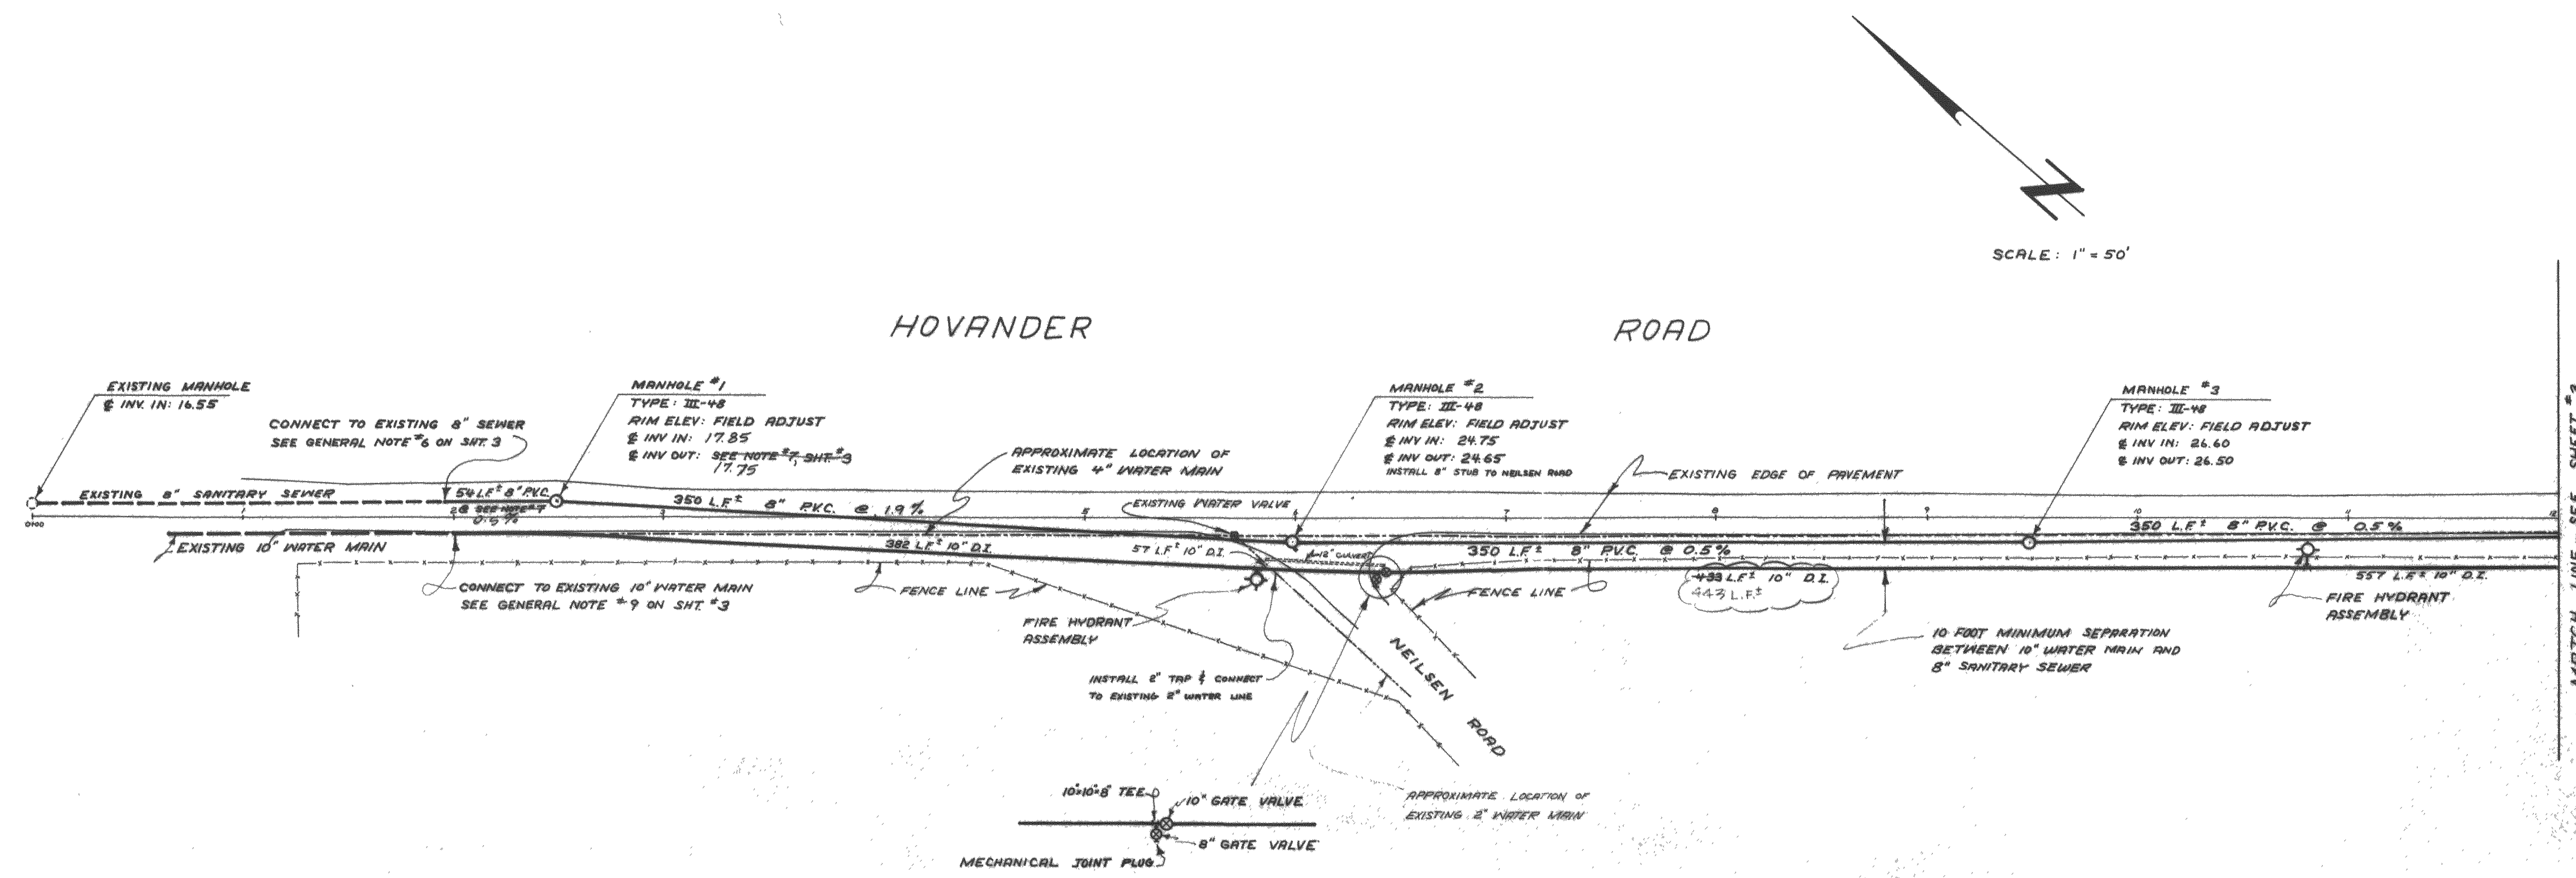

AS-BUILT 4/27/83
THESE AS-BUILTS ARE CERTIFIED TO BE
ALGEBRAICALLY PLOTTED FROM INFORMATION
AND FIELD NOTES OBTAINED FROM
CONSTRUCTION SURVEYORS.
JAMES R. FRANK
JAMES R. FRANK

NORTHWEST CONSULTANTS
CIVIL & STRUCTURAL ENGINEERING
1401 ASTOR, BELLINGHAM, WA. (206) 676-9058

HOVANDER ROAD U.I.D.
FERNDLE CITY HALL
FERNDLE, WA. 98248

SCALE: HORIZONTAL: 1"=50' VERTICAL: 1"=5'
DATE: 25 AUGUST 1988
DRAWN BY: J.R.F.
CHECKED BY: J.R.F.
JOB NO. 81-971

REVISIONS
MARK DESCRIPTION DATE BY
As-Built 4/27/83



HOVANDER ROAD

SANITARY SEWER & WATER DISTRIBUTION SYSTEM
PLAN AND PROFILE



SHEET 1 OF 3

00807.002 2.14.06 KR

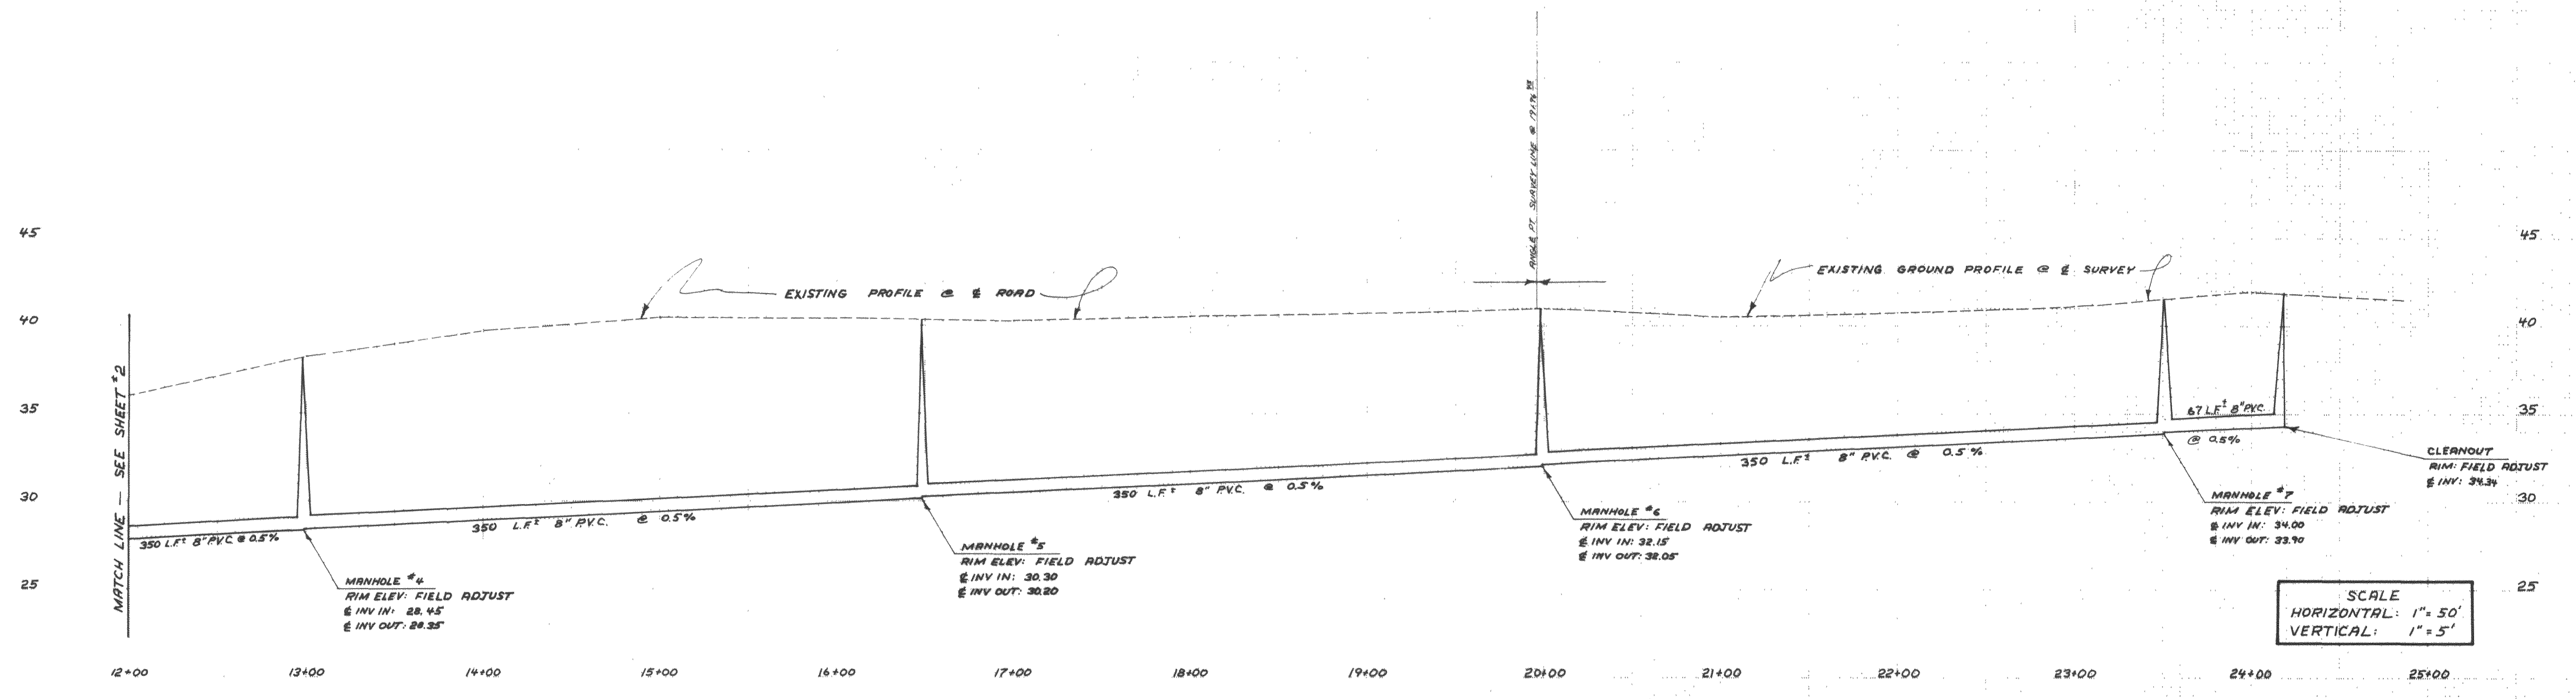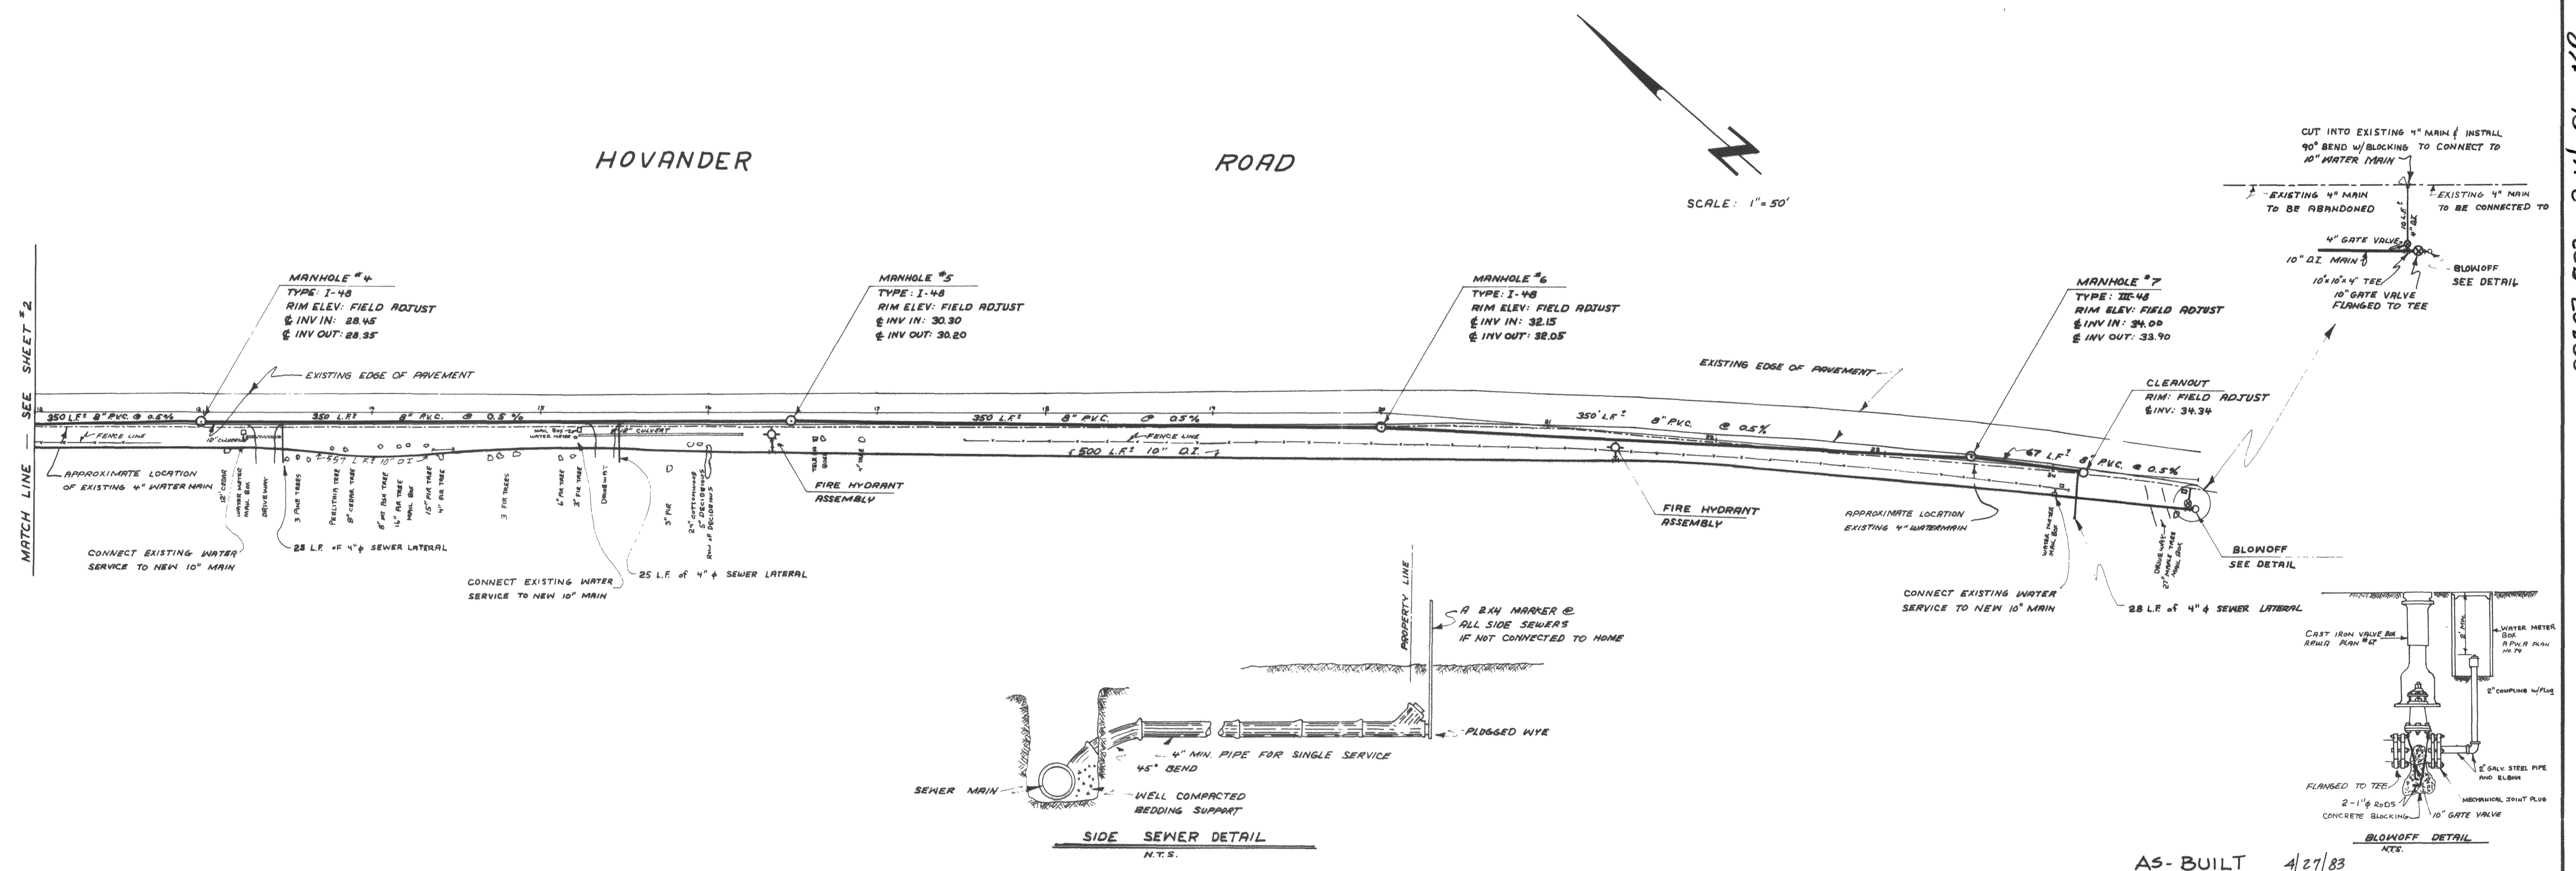

AS-BUILT 4/27/83
THESE AS-BUILTS ARE CERTIFIED TO BE
ACCURATELY PLOTTED FROM INFORMATION
AND FIELD NOTES OBTAINED FROM
CONSTRUCTION SURVEYORS.
James E. Fendick
James E. Fendick

NORTHWEST CONSULTANTS
CIVIL & STRUCTURAL ENGINEERING
1401 ASTOR, BELLINGHAM, WA.
(206) 676-9058


HOVANDER ROAD U.I.D.
FERDALE CITY HALL
FERDALE, WA 98248

SCALE: HORIZ. 1"=50' VERT. 1"=5'
DATE: 26 AUGUST 1982
DRAWN BY: J.E.F.
CHECKED BY: J.E.F.
JOB NO: 81-971

REVISIONS
MARK DESCRIPTION DATE BY
As-Built 4/27/83

HOVANDER ROAD

SANITARY SEWER & WATER DISTRIBUTION SYSTEM
PLAN AND PROFILE

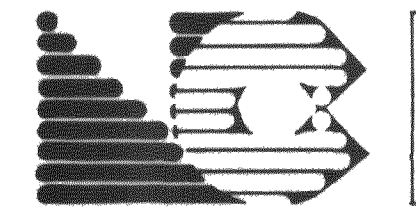

SHEET
2
OF
3