
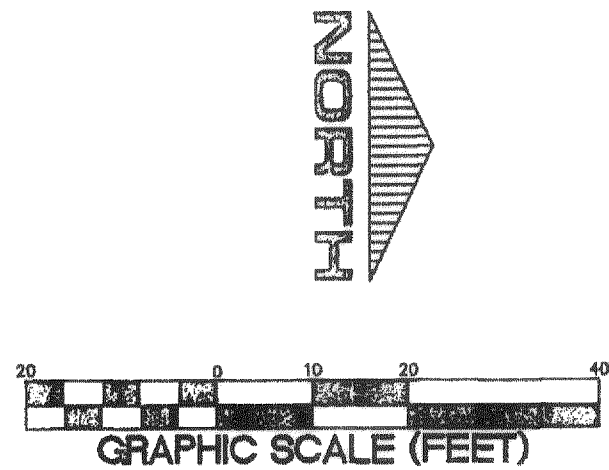
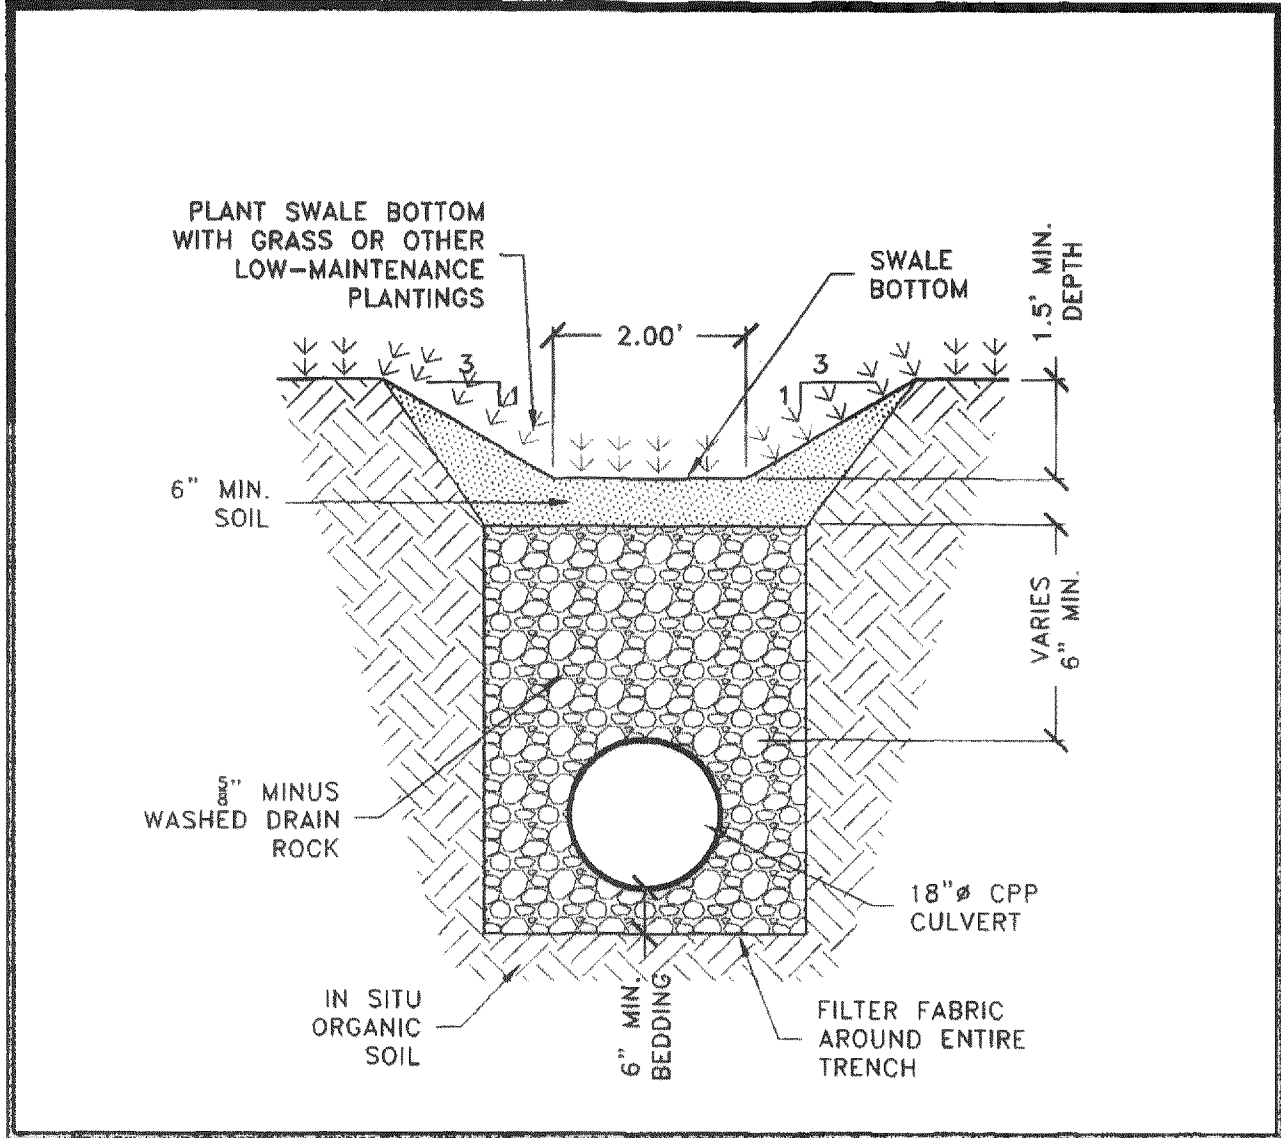


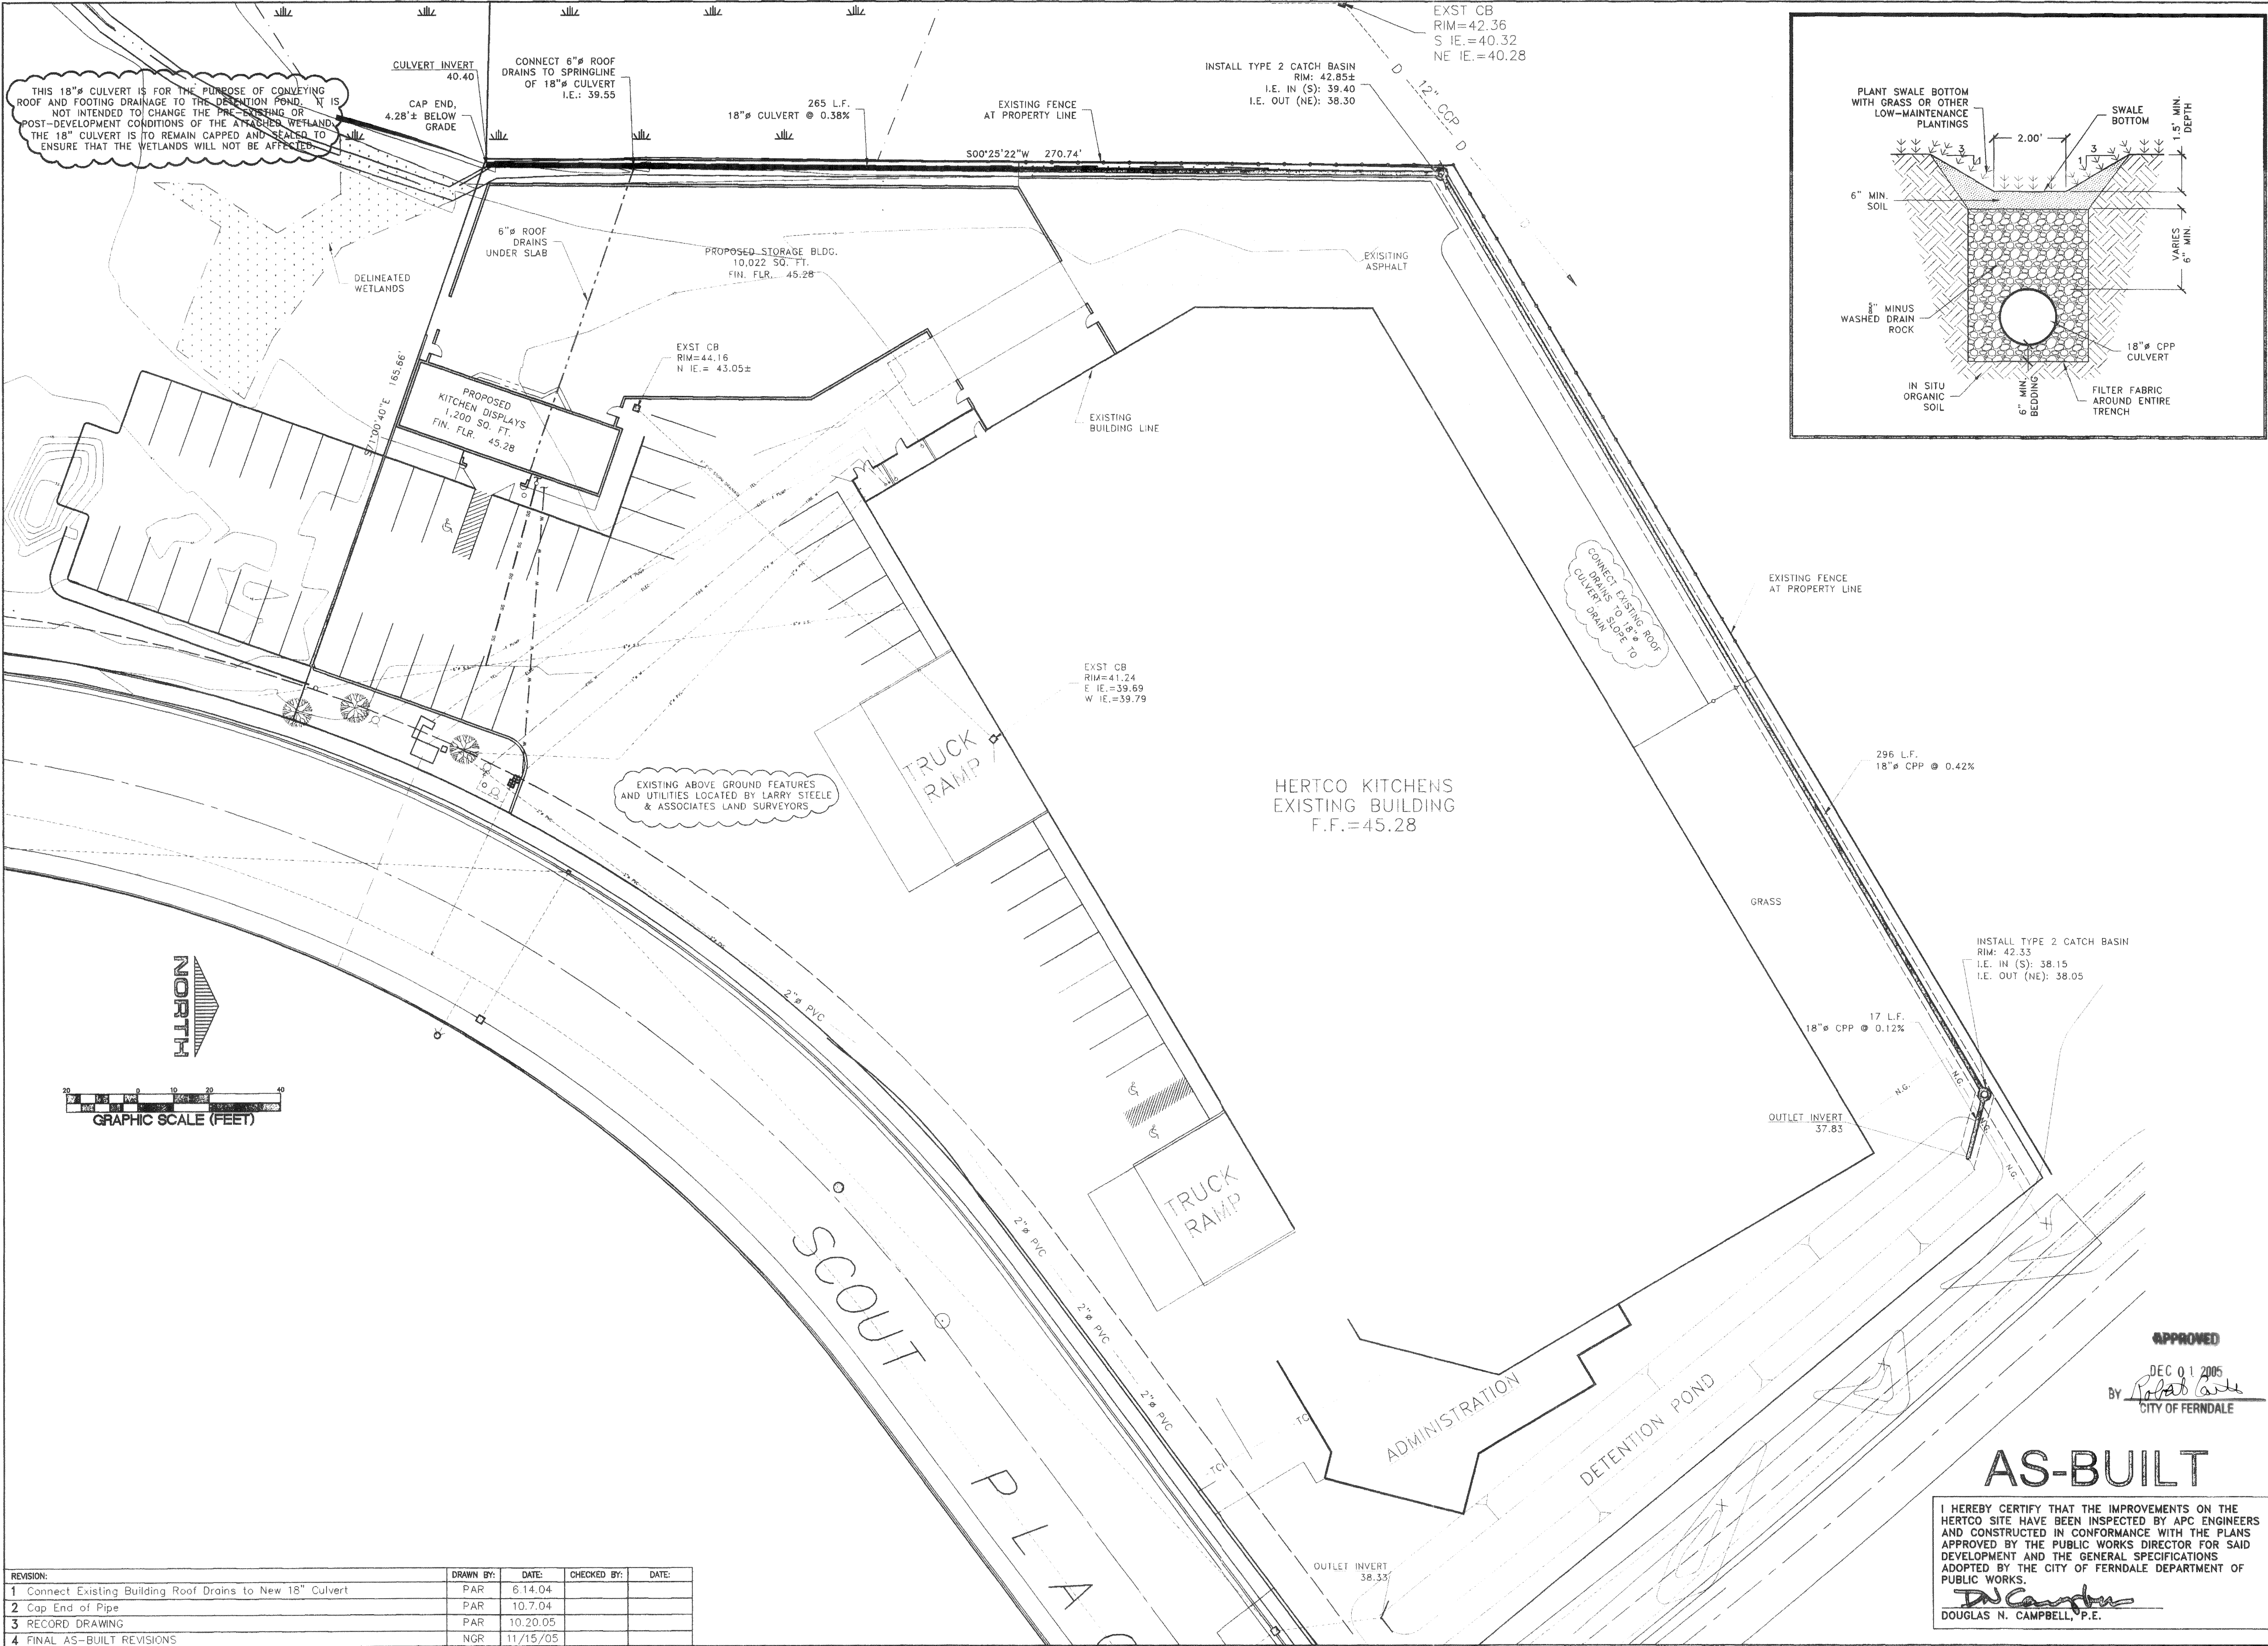


REVISION:	DRAWN BY:	DATE:	CHECKED BY:	DATE:
1 Connect Existing Building Roof Drains to New 18" Culvert	PAR	6.14.04		
2 Cap End of Pipe	PAR	10.7.04		
3 RECORD DRAWING	PAR	10.20.05		
4 FINAL AS-BUILT REVISIONS	NGR	11/15/05		

I HEREBY CERTIFY THAT THE IMPROVEMENTS ON THE HERTCO SITE HAVE BEEN INSPECTED BY APC ENGINEERS AND CONSTRUCTED IN CONFORMANCE WITH THE PLANS APPROVED BY THE PUBLIC WORKS DIRECTOR FOR SAID DEVELOPMENT AND THE GENERAL SPECIFICATIONS ADOPTED BY THE CITY OF FERNDALE DEPARTMENT OF PUBLIC WORKS.

Douglas N. Campbell
DOUGLAS N. CAMPBELL, P.E.

ASSOCIATED PROJECT CONSULTANTS, INC., P.S.
CIVIL ENGINEERS, PROJECT AND LAND USE MANAGEMENT,
BUILDING, STRUCTURAL, AND ENVIRONMENTAL SERVICES
1401 ASTOR STREET, BELLINGHAM, WA. 98225
PHONE (360) 671-1146 FAX (360) 671-1169

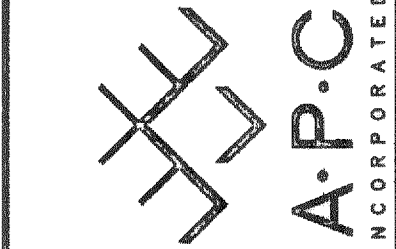

HORIZONTAL SCALE: 1" = 20'	DRAWN BY: PAR	APPROVED BY: 4.9.04
VERTICAL SCALE: NONE	DATE: 4.9.04	NORTH ROTATION: & BASE POINT:

CLIENT: CONAC, INC.	PROJECT: 18" STORM DRAIN	TITLE: SITE PLAN with SWALE
JOB NO.: 03-135	ACAD FILE: Site Plan As-Built	SHEET: C2a
OF: 2		

11-15-05
DOUGLAS N. CAMPBELL, P.E.
EXPIRES 10/19/06

00315.001 2.22.06 KR