
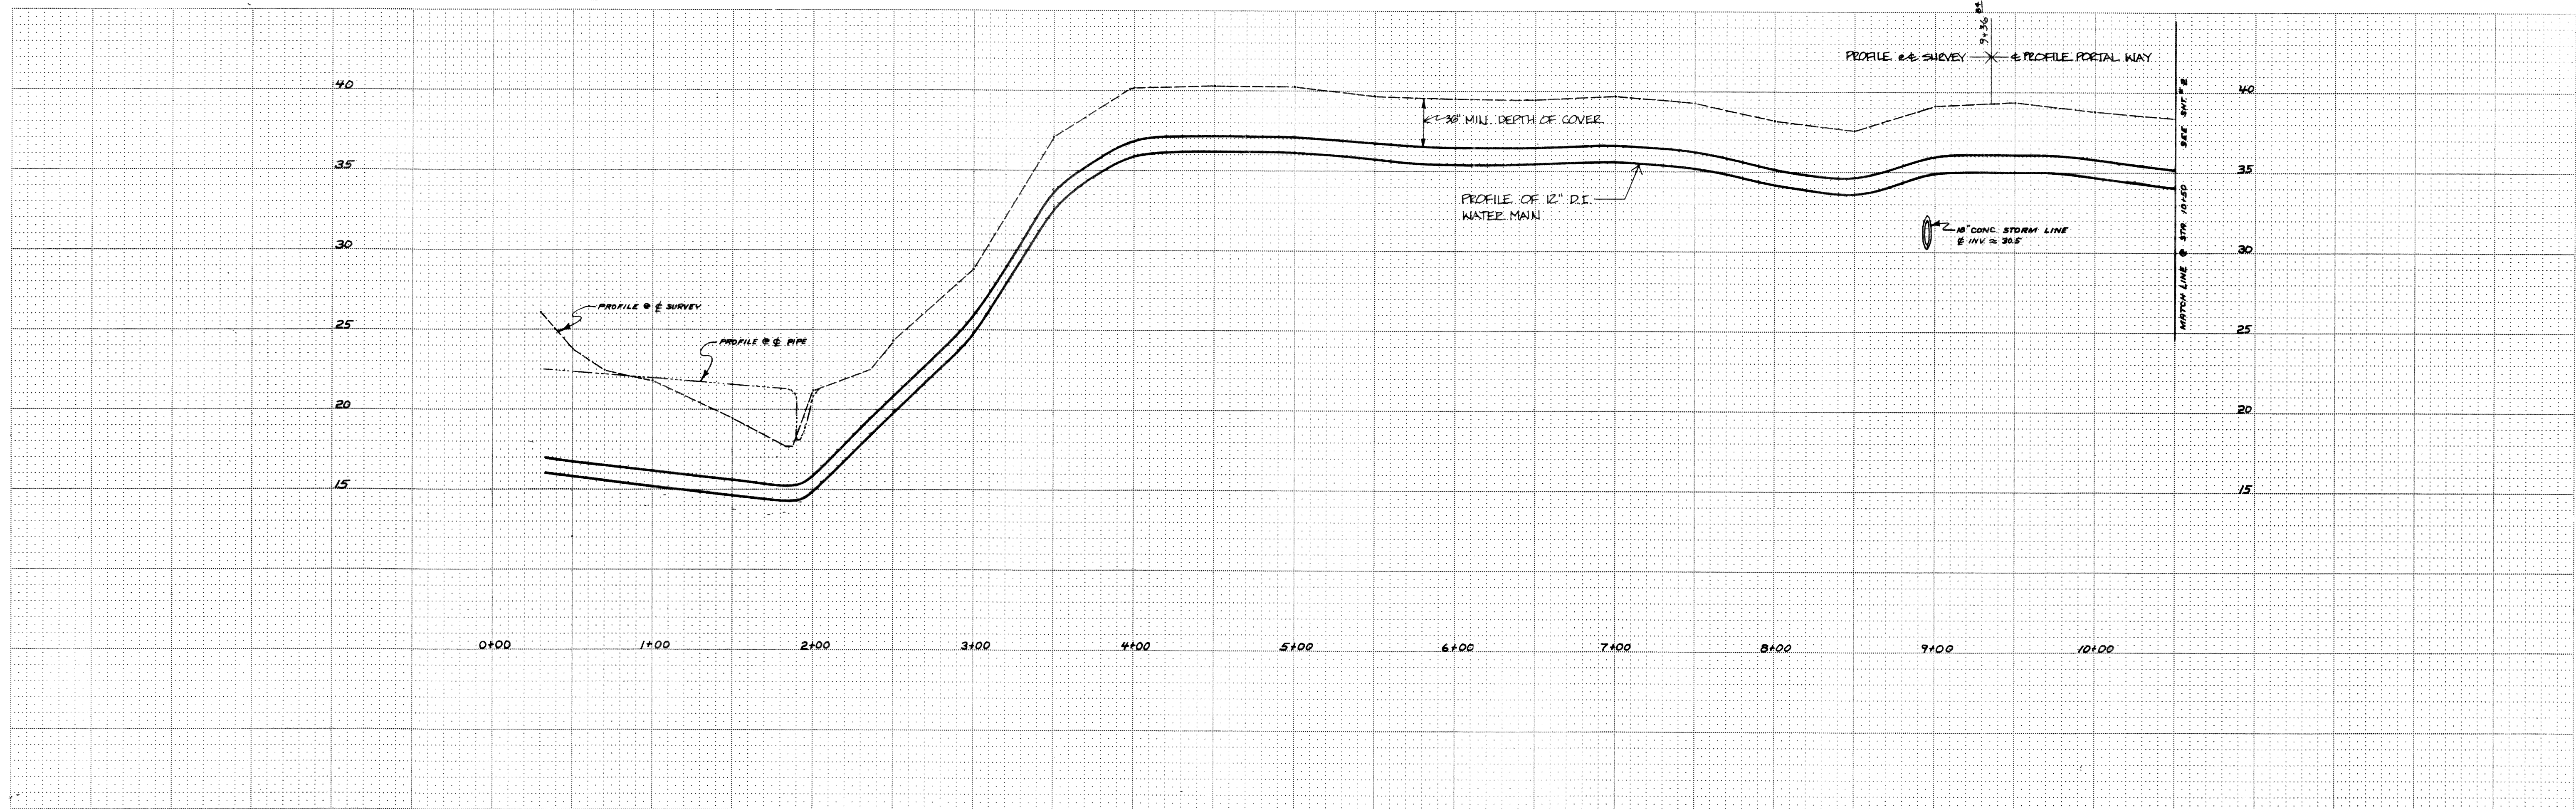
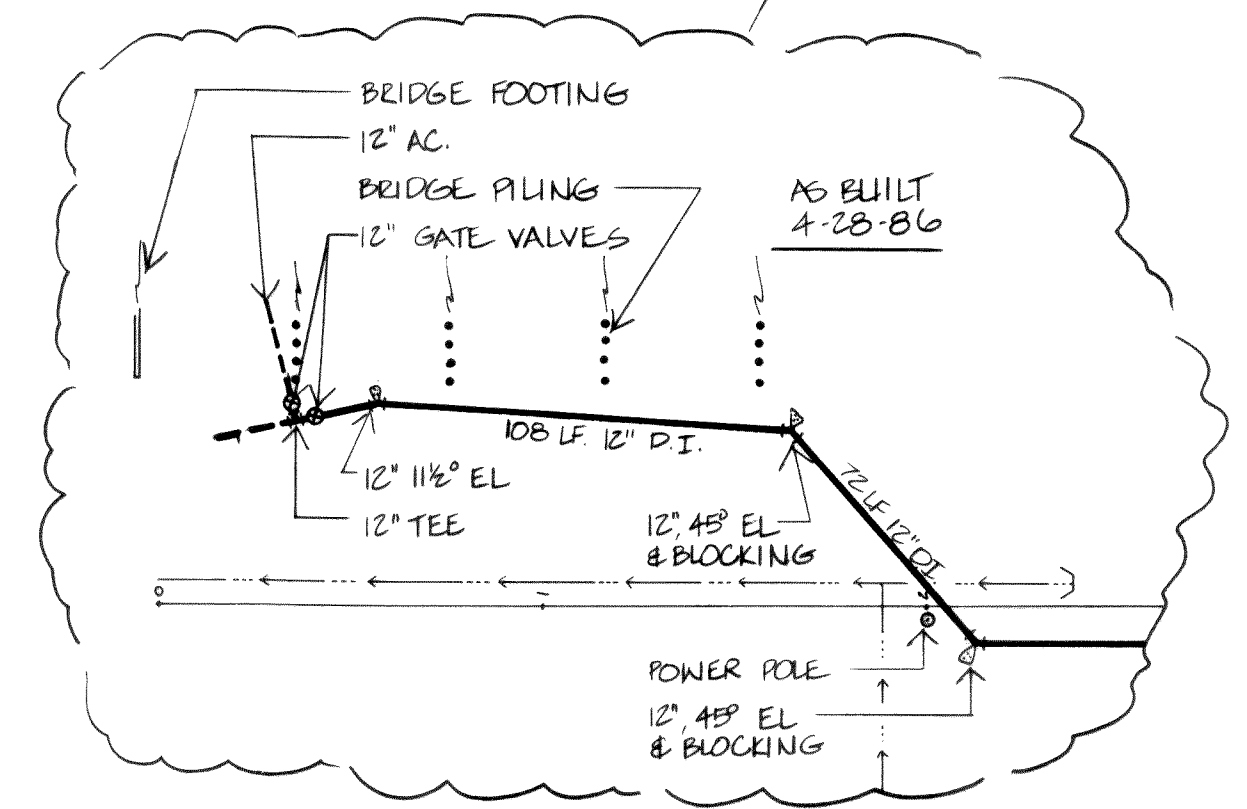


00272.001 2.2.06

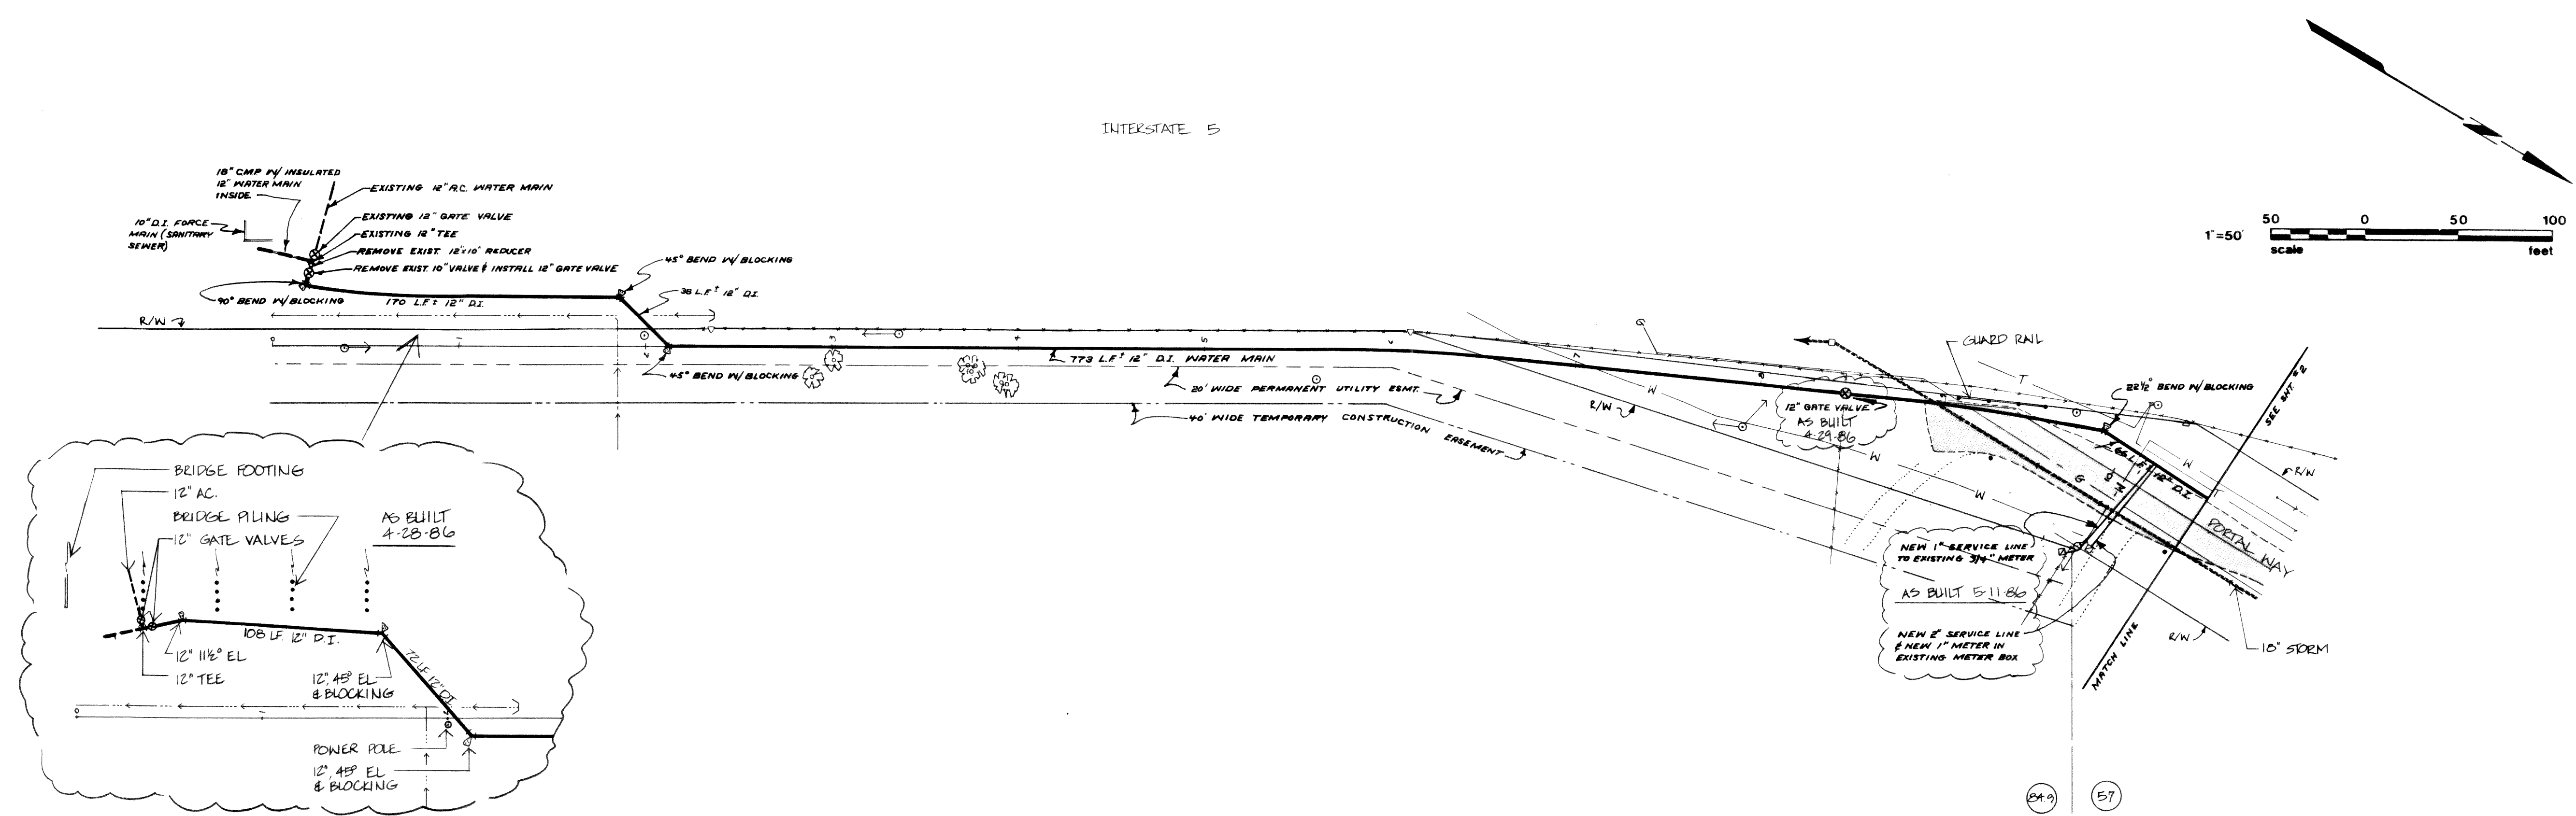

**NORTHWEST CONSULTANTS**  
CIVIL & STRUCTURAL ENGINEERING  
1401 ASTOR, BELLINGHAM, WA. (206) 676-9058

**CITY OF FERDALE**  
P.O. BOX 936  
FERDALE, WA. 98248 PH. 384-4302

SCALE AS SHOWN  
DATE 2-10-86  
DRAWN BY J.S. & E.F.  
CHECKED BY E.F.  
JOB NO. 86-1431

REVISIONS  
MARK DESCRIPTION DATE BY



**PORTAL WAY IMPROVEMENTS**

**WATER DISTRIBUTION SYSTEM**  
PLAN AND PROFILE

**10**  
SHEET 1 OF 10

JOB NUMBER: 86-1431



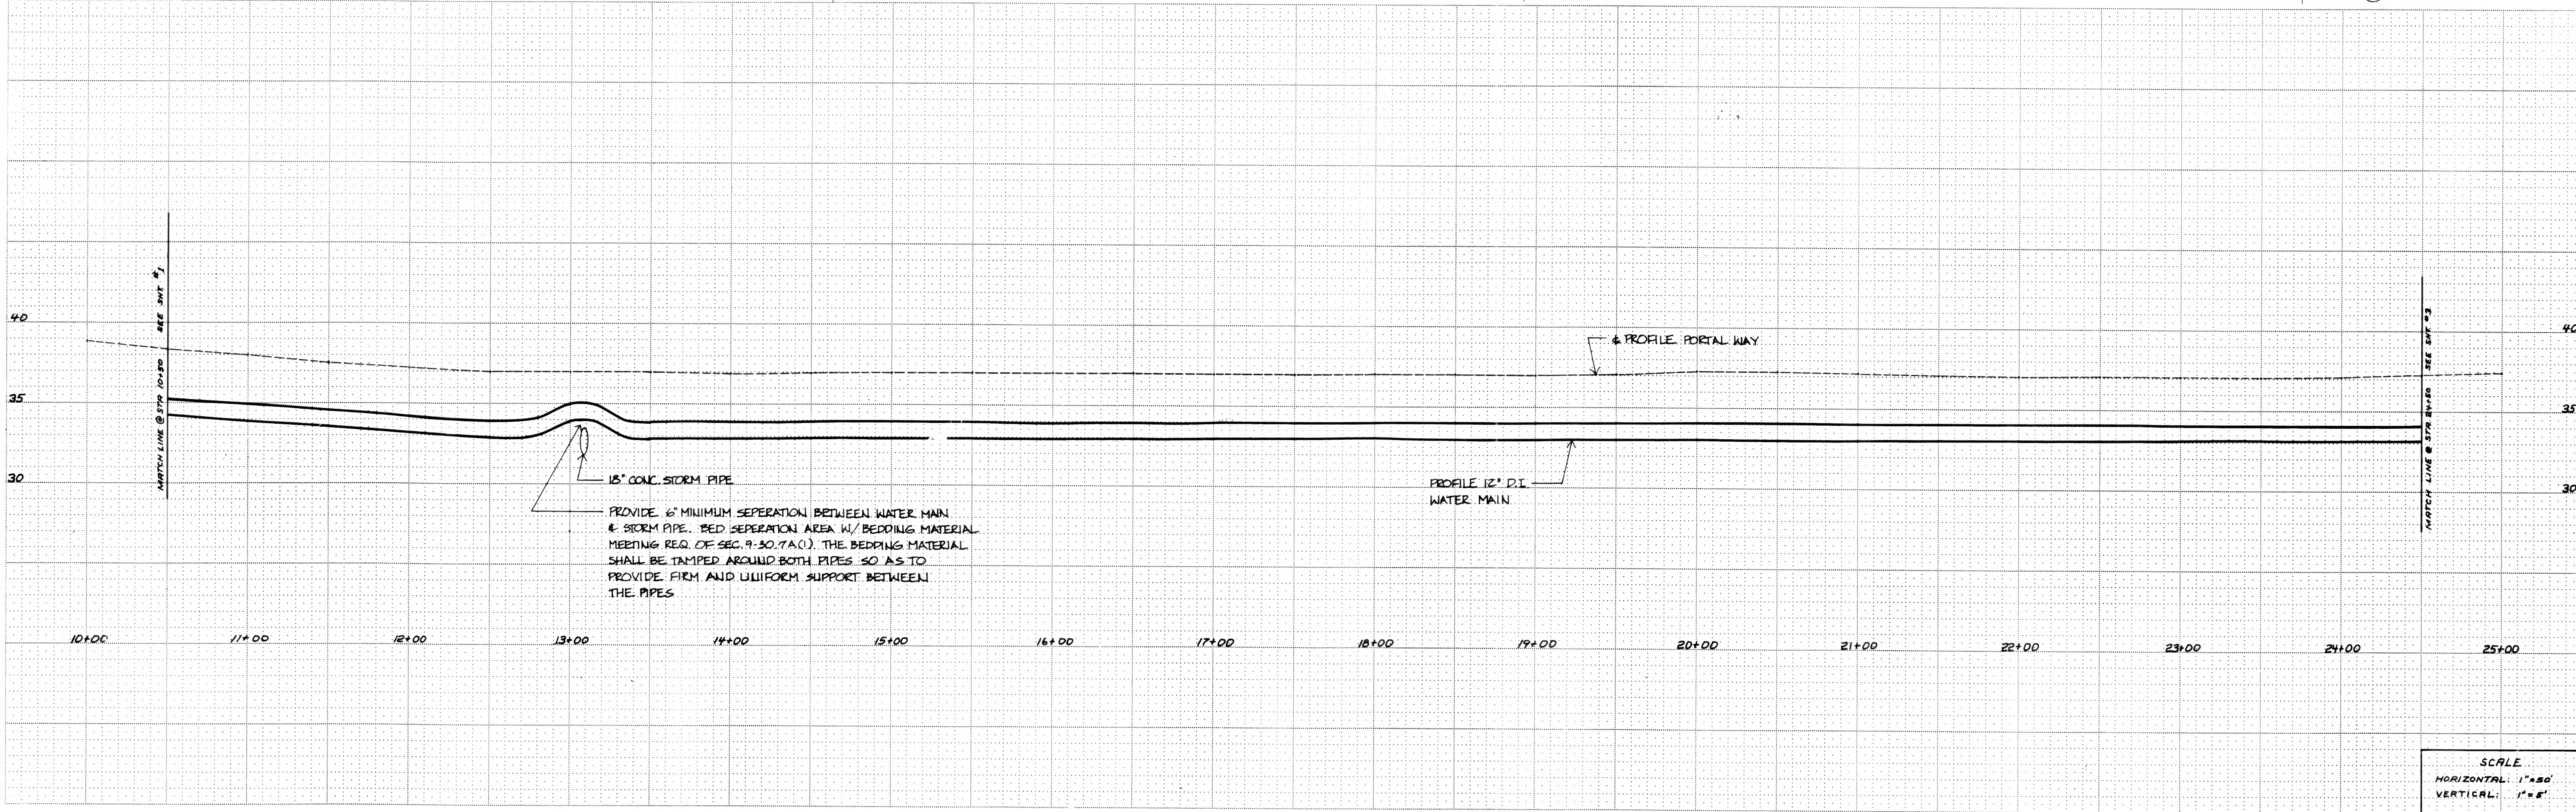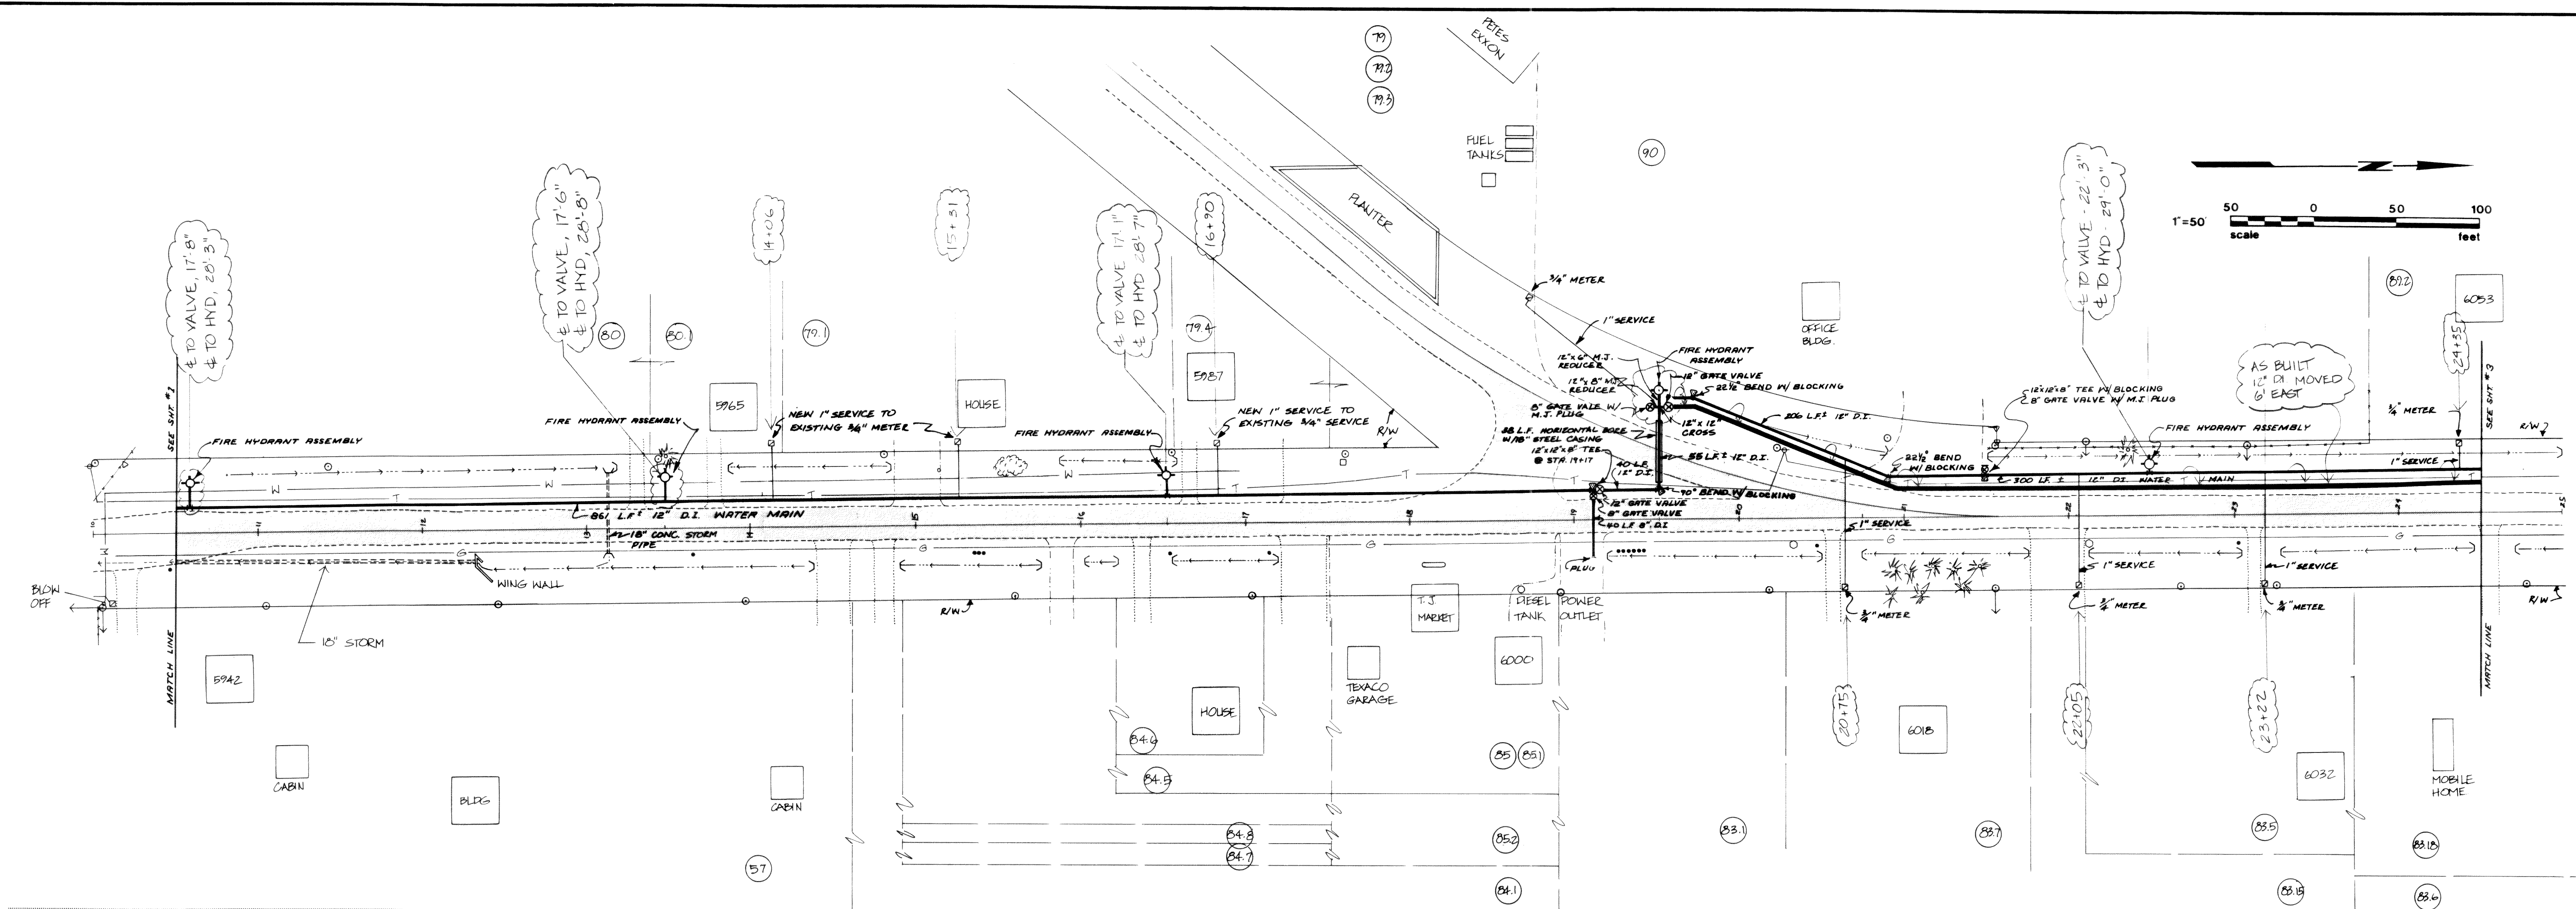

**NORTHWEST CONSULTANTS**  
CIVIL & STRUCTURAL ENGINEERING  
1401 ASTOR, BELLINGHAM, WA. (206) 676-9058


**CITY OF FERNDAL**  
P.O. BOX 936  
FERNDAL, WA. 98248 PH. 384-4302

SCALE AS SHOWN  
DATE 3-18-86  
DRAWN BY ZKN & EF  
CHECKED BY FE  
JOB NO. 86-1431

| REVISIONS | MARK | DESCRIPTION | DATE | BY |
|-----------|------|-------------|------|----|
|           |      |             |      |    |
|           |      |             |      |    |

**PORTAL WAY IMPROVEMENTS**

**WATER DISTRIBUTION SYSTEM  
PLAN AND PROFILE**


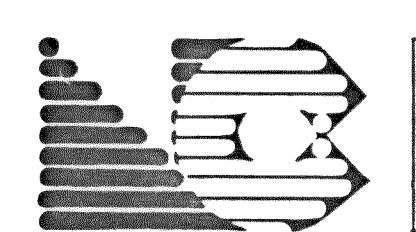


SHEET  
2  
10



JOB NUMBER: 86-1431

00272.002 2-2-06 KR






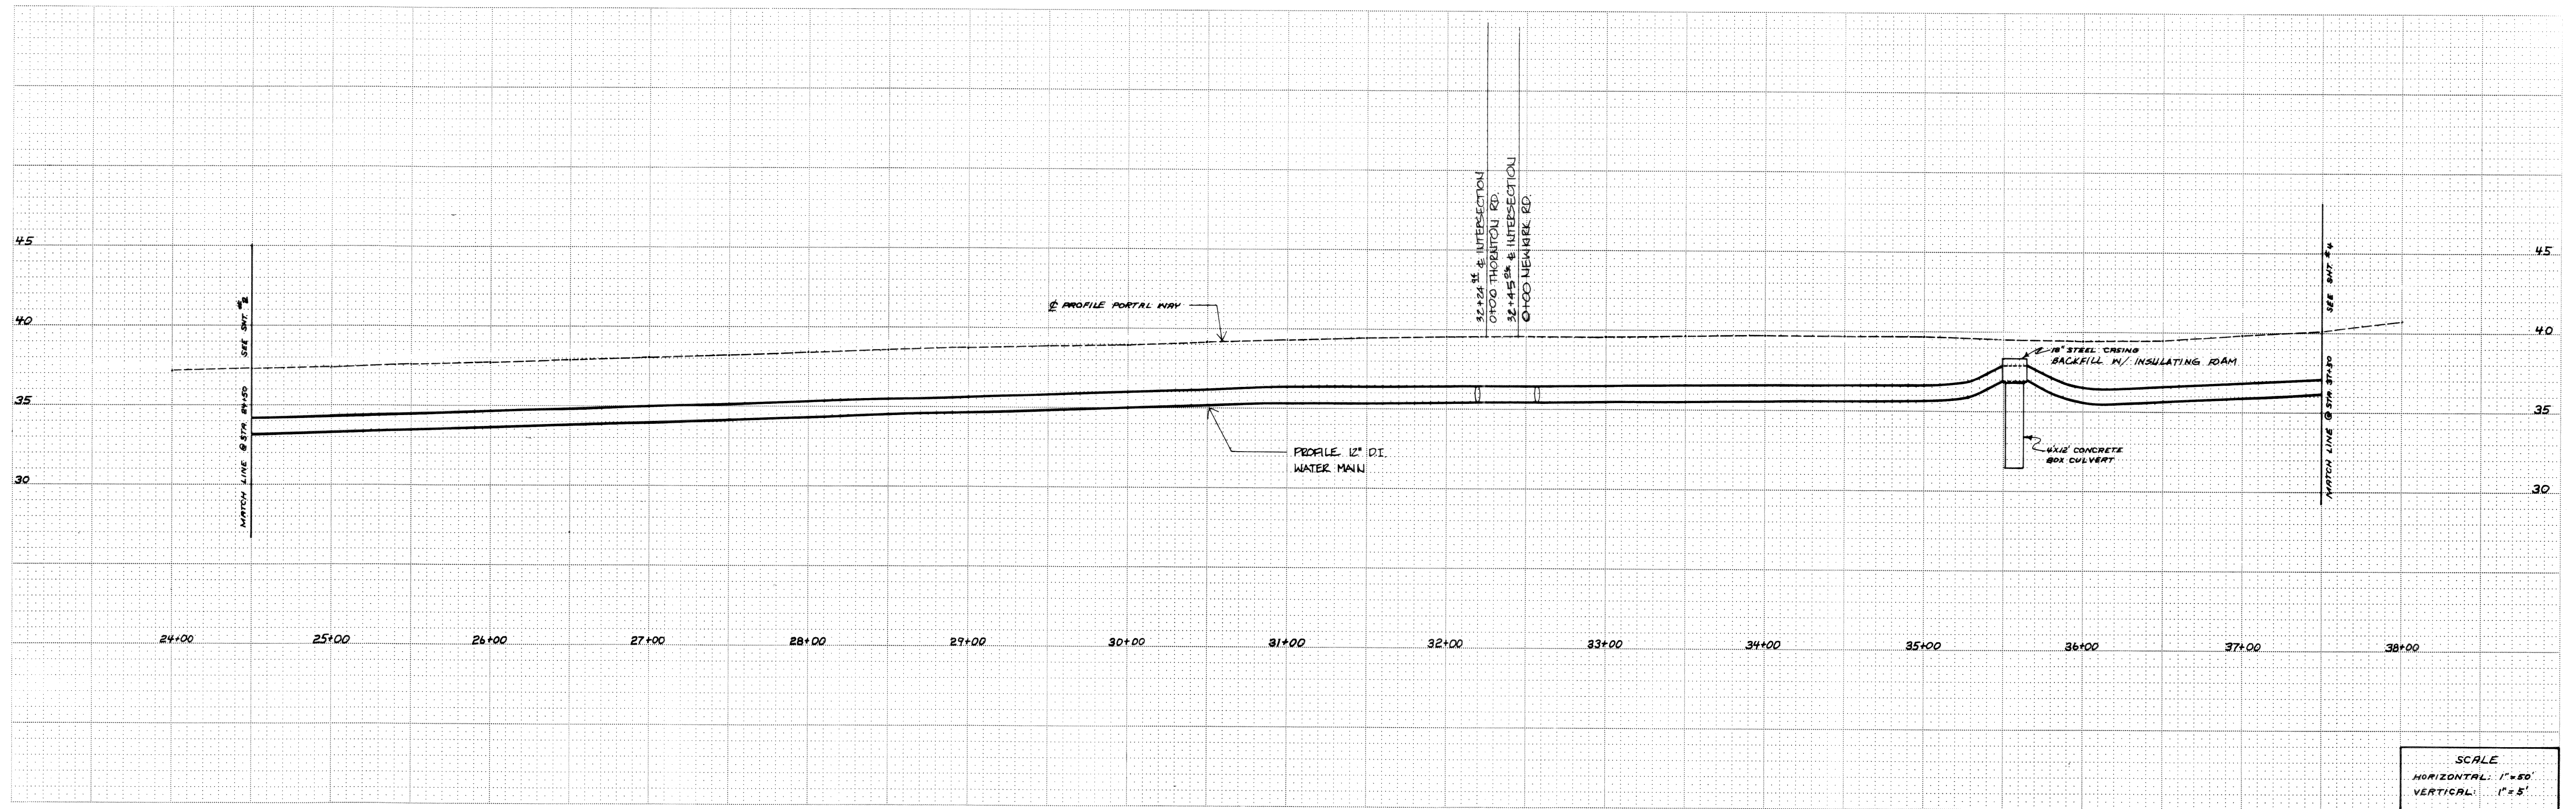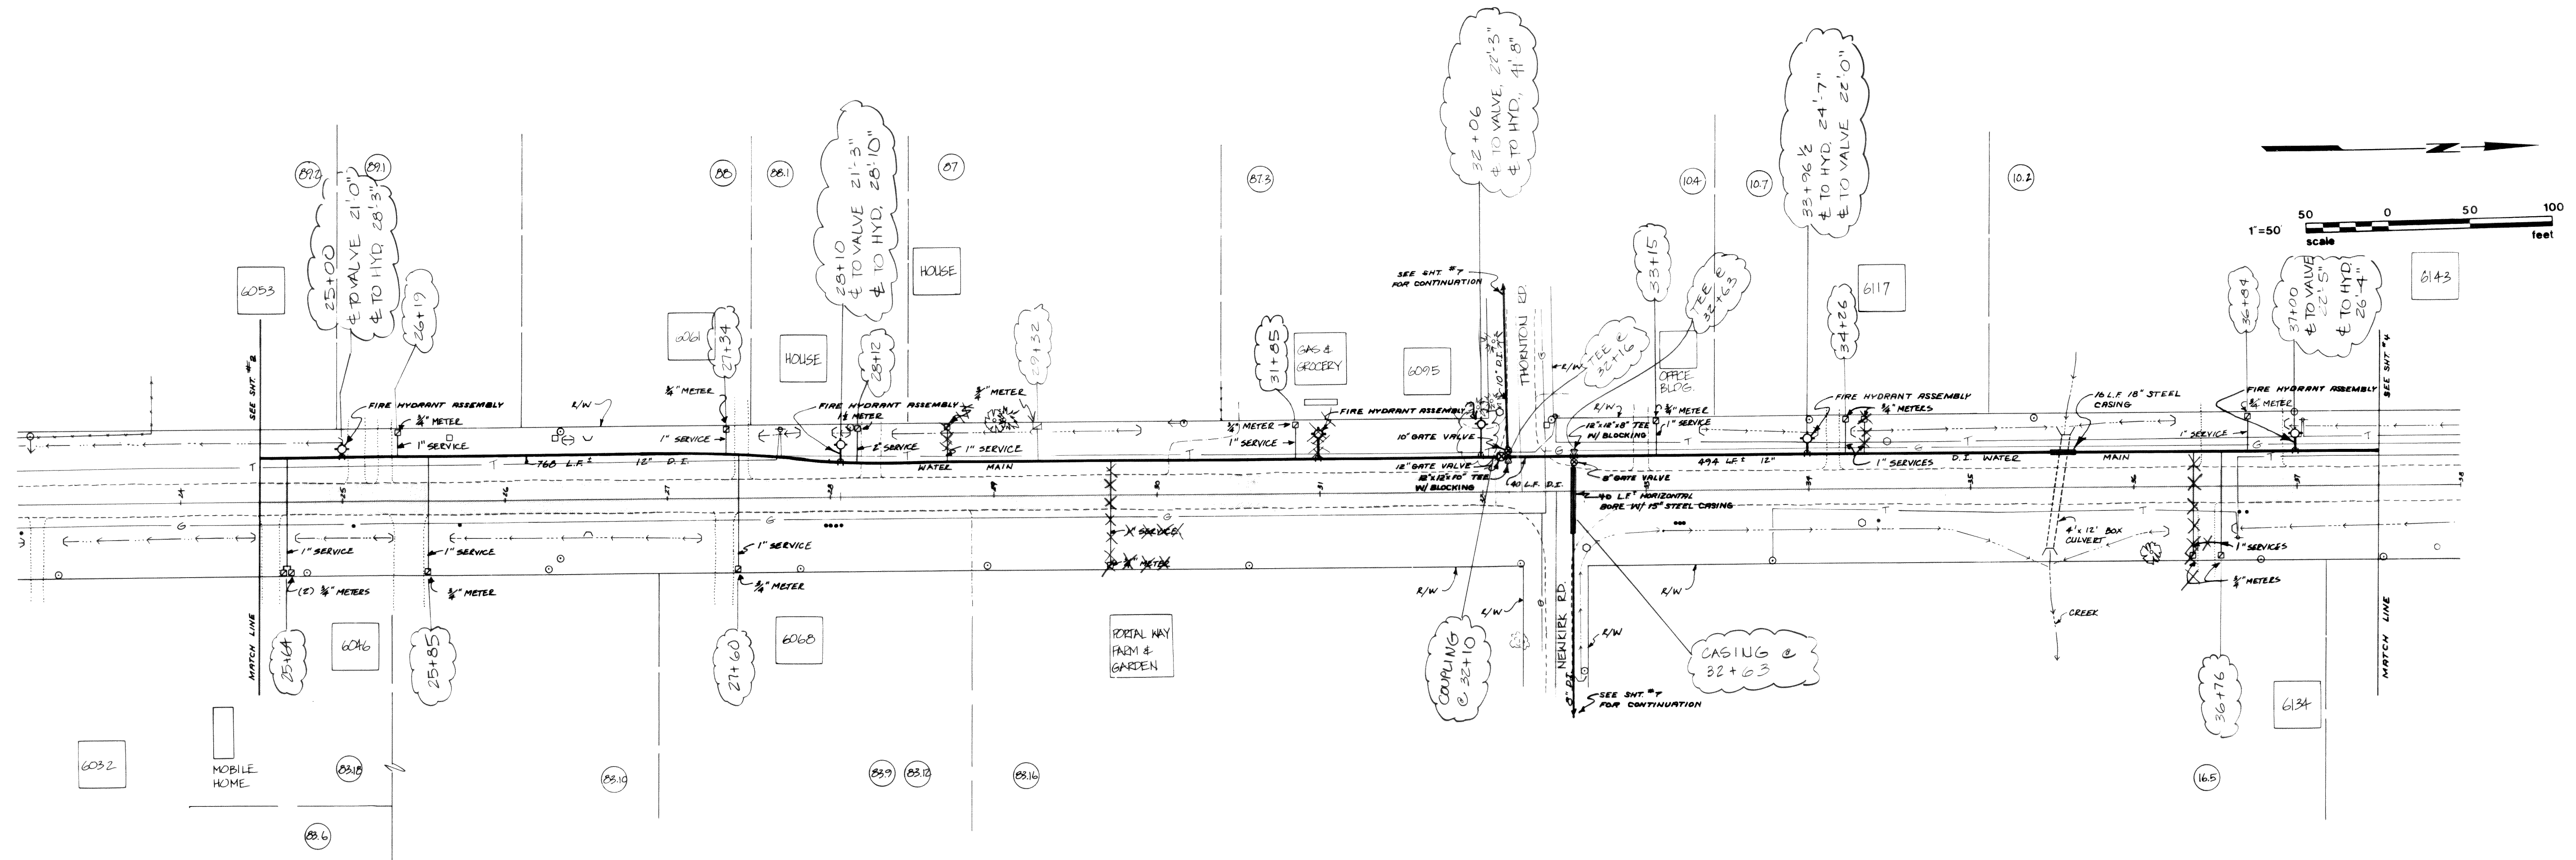



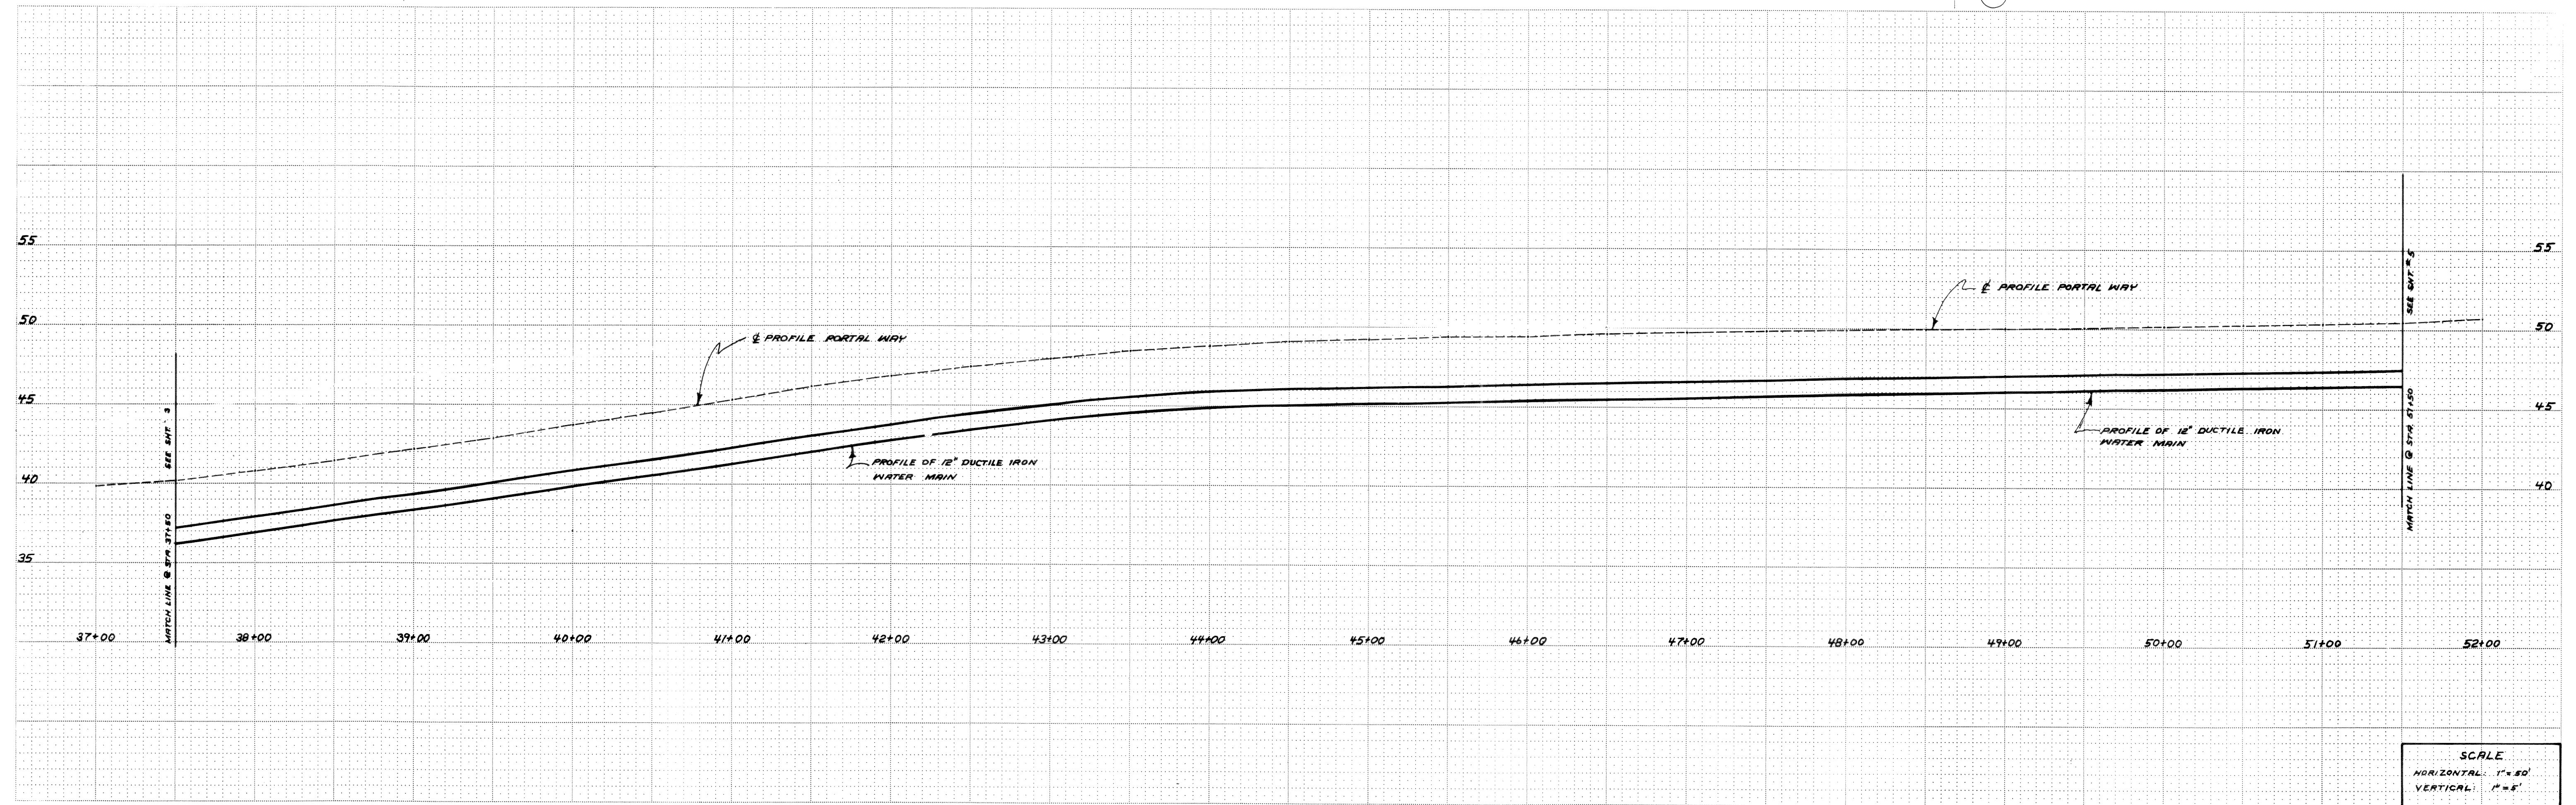
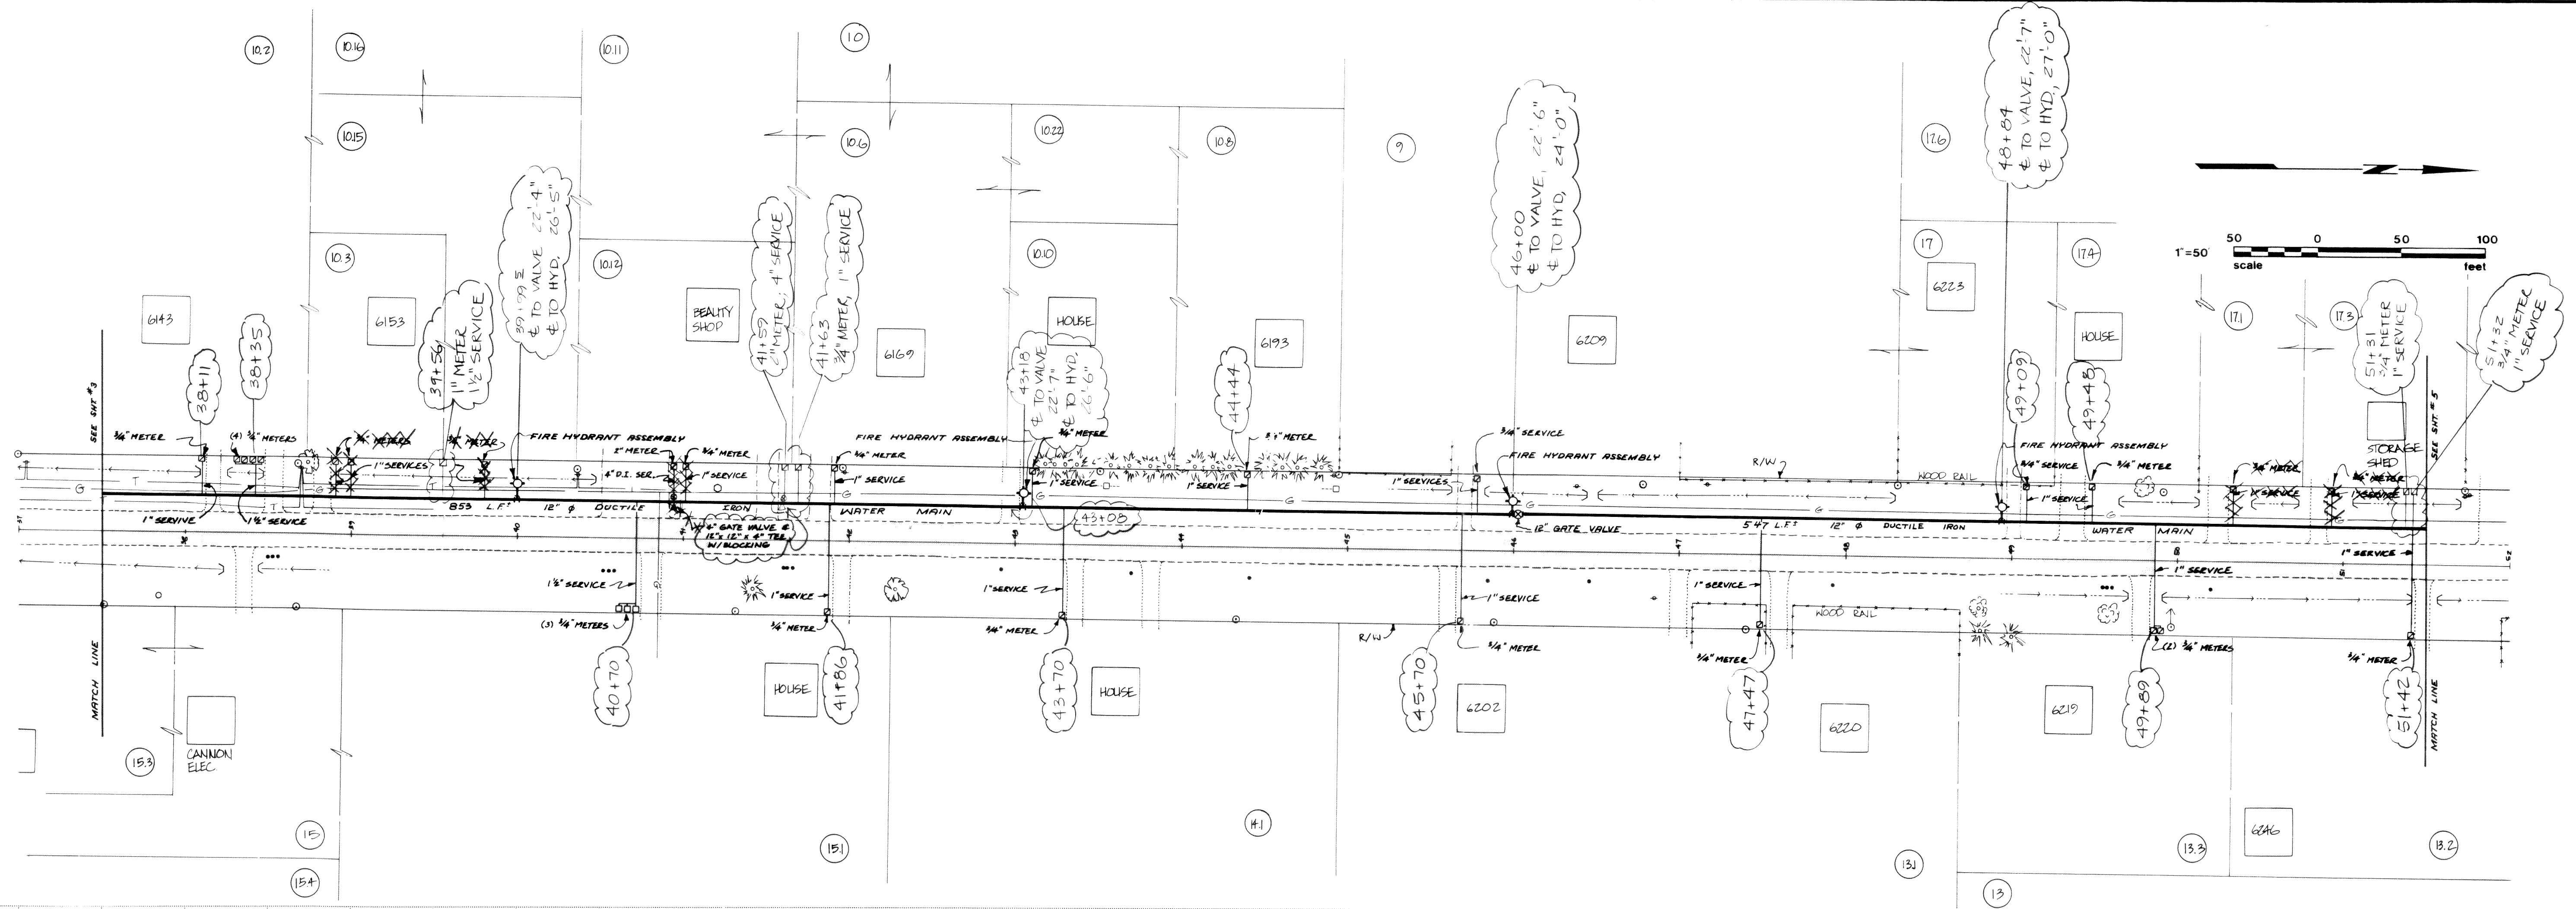




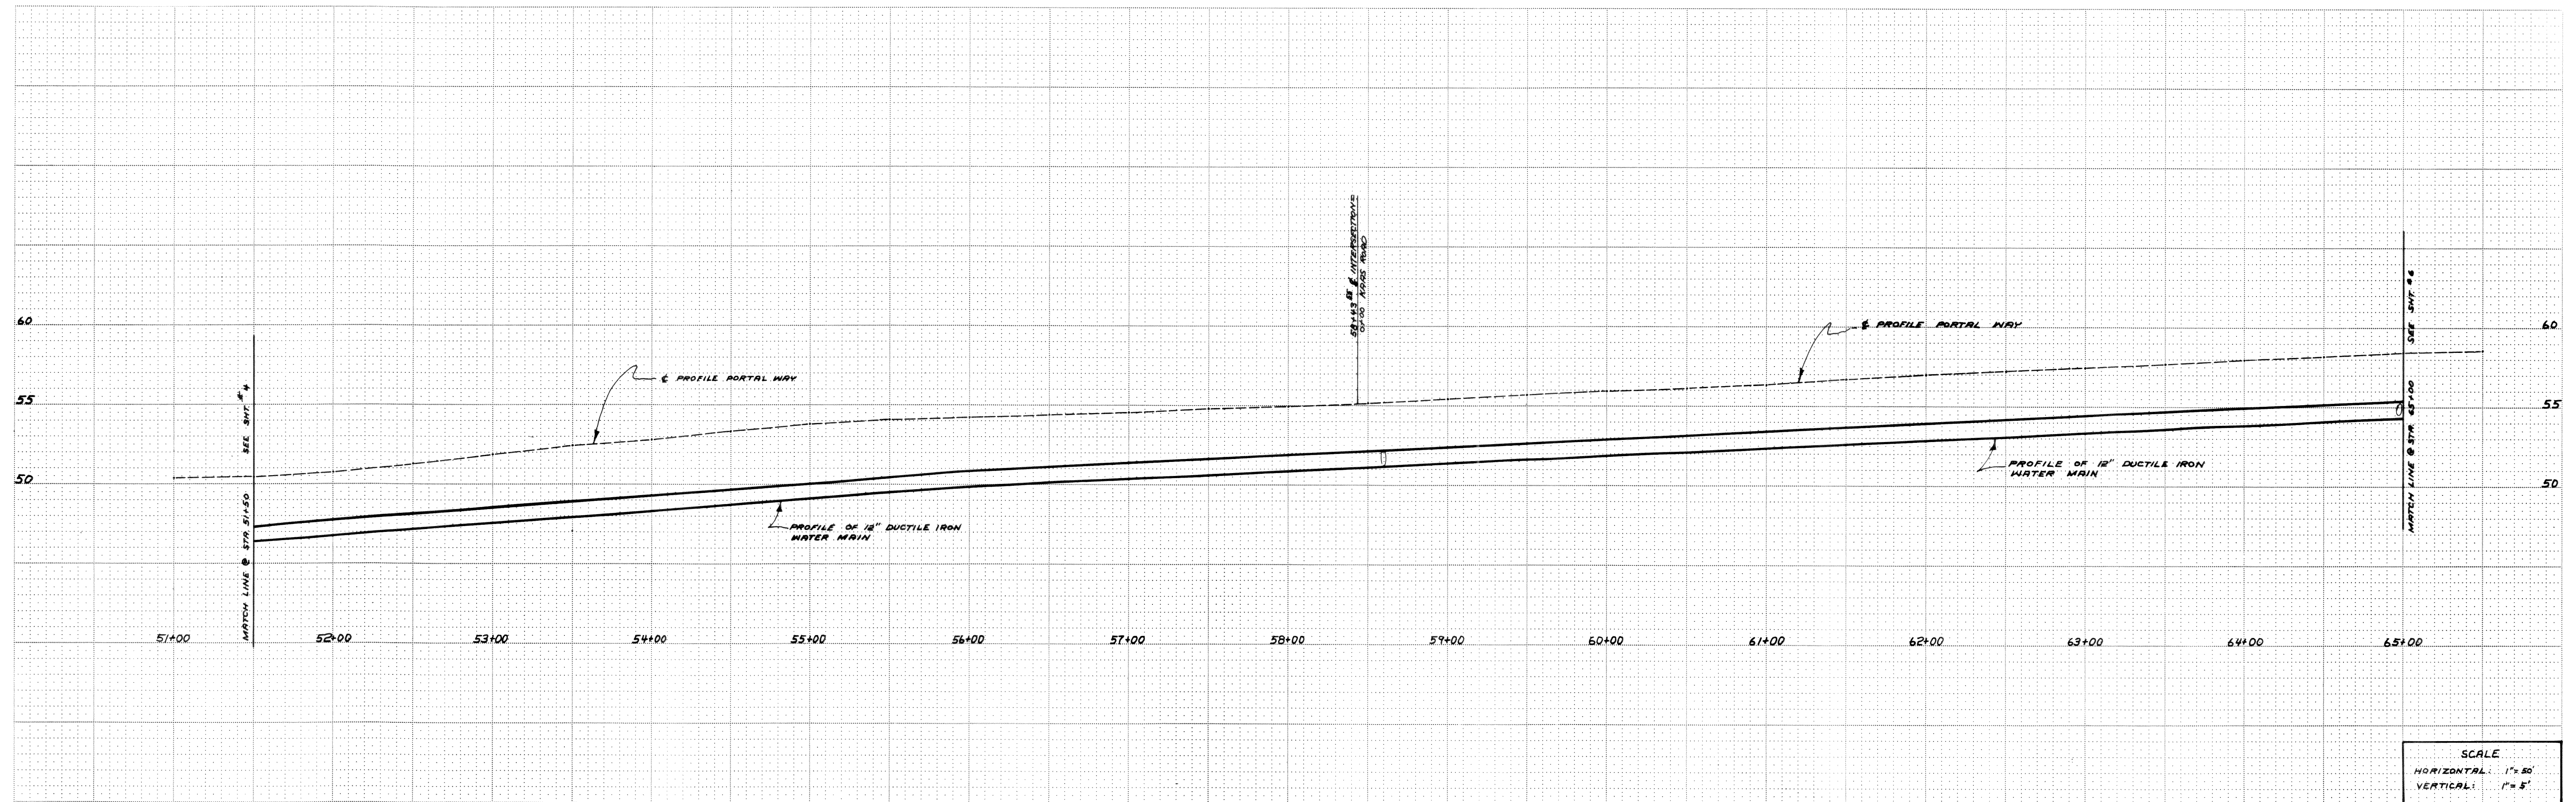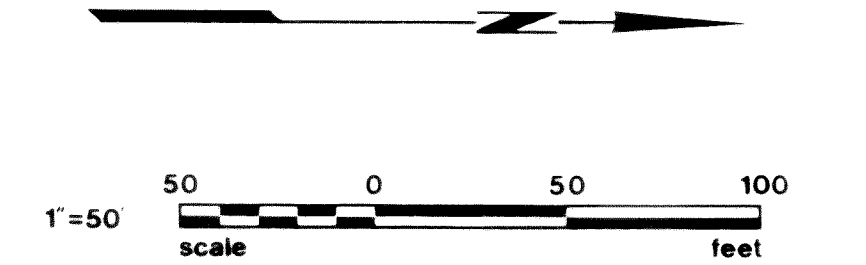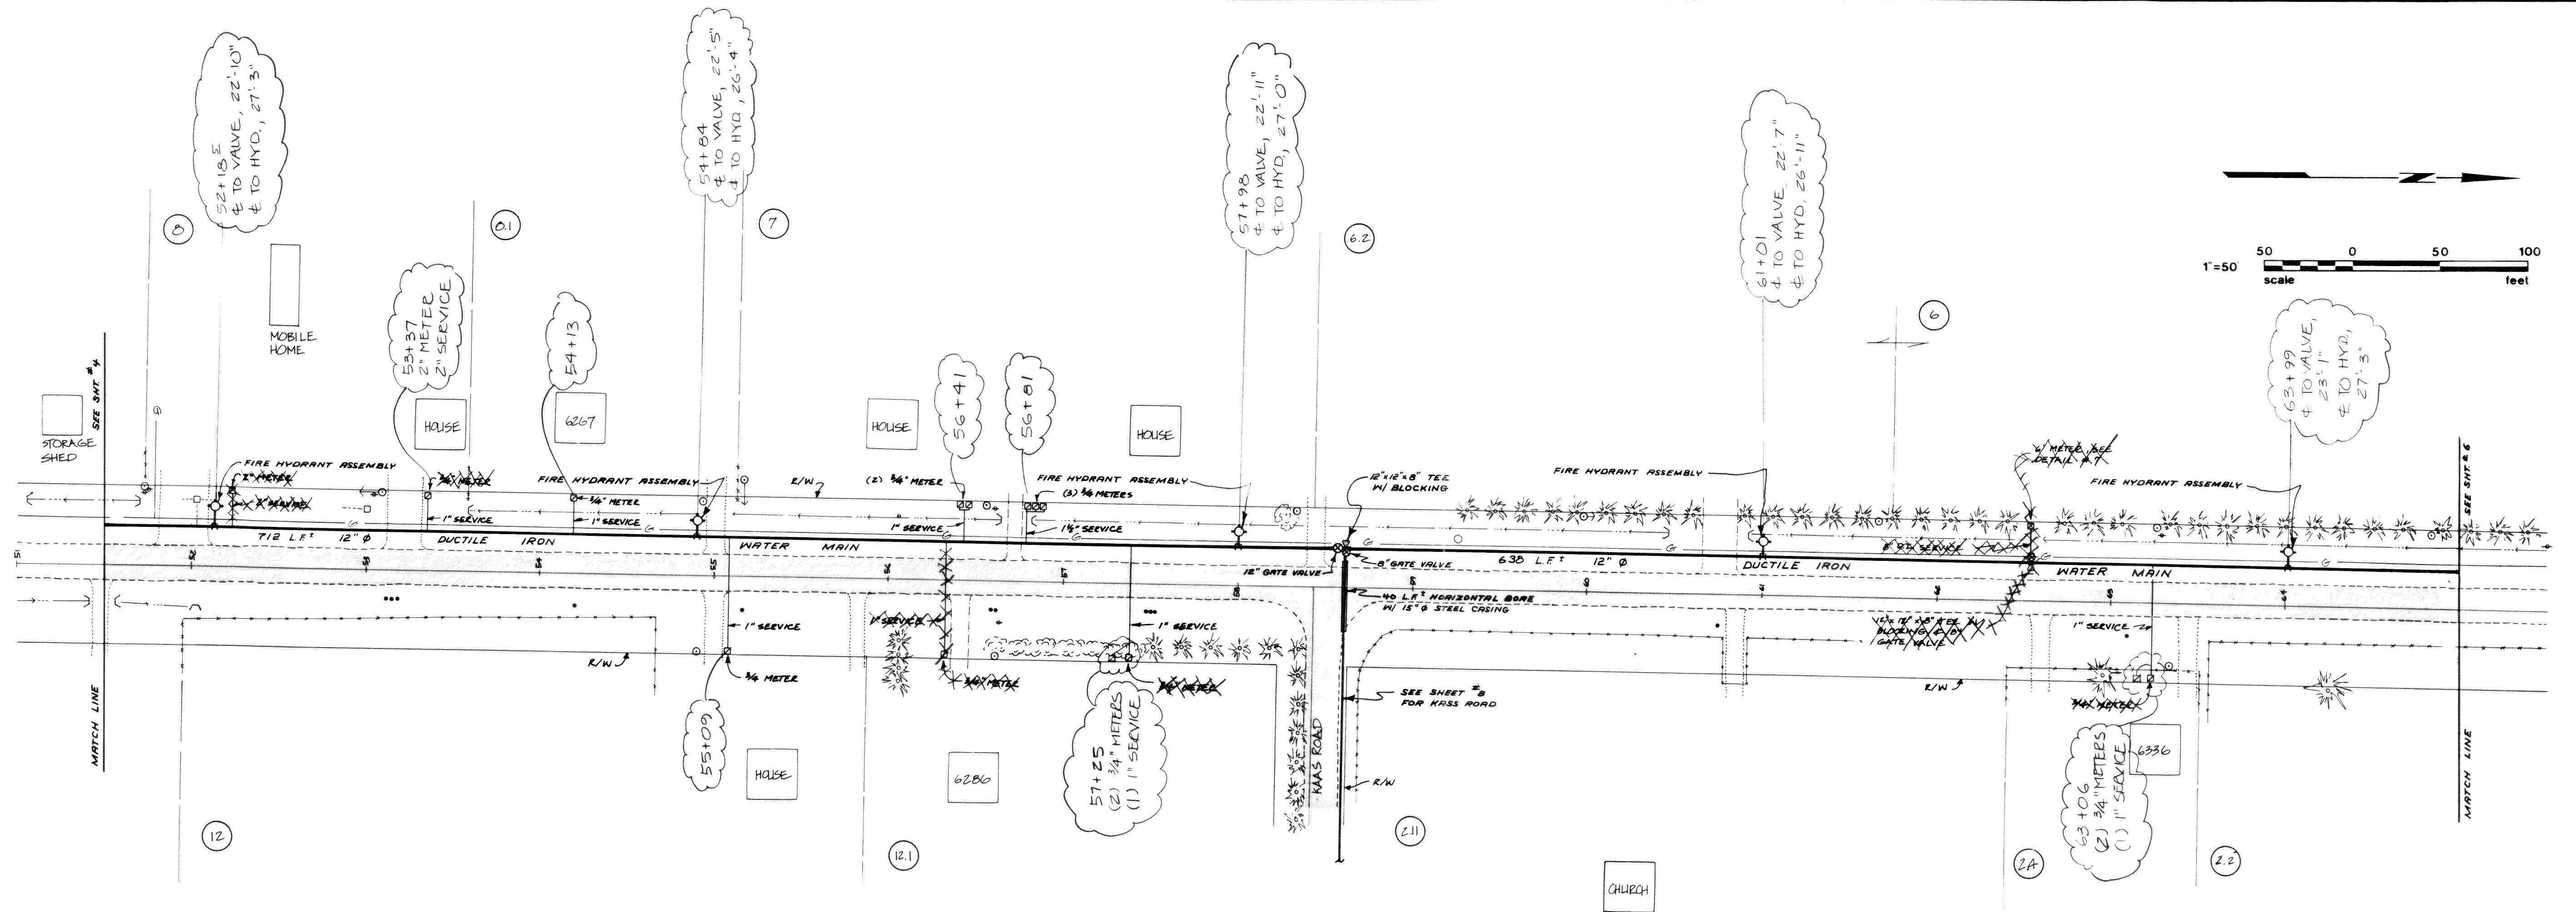



00272.006 2.2.06 KR

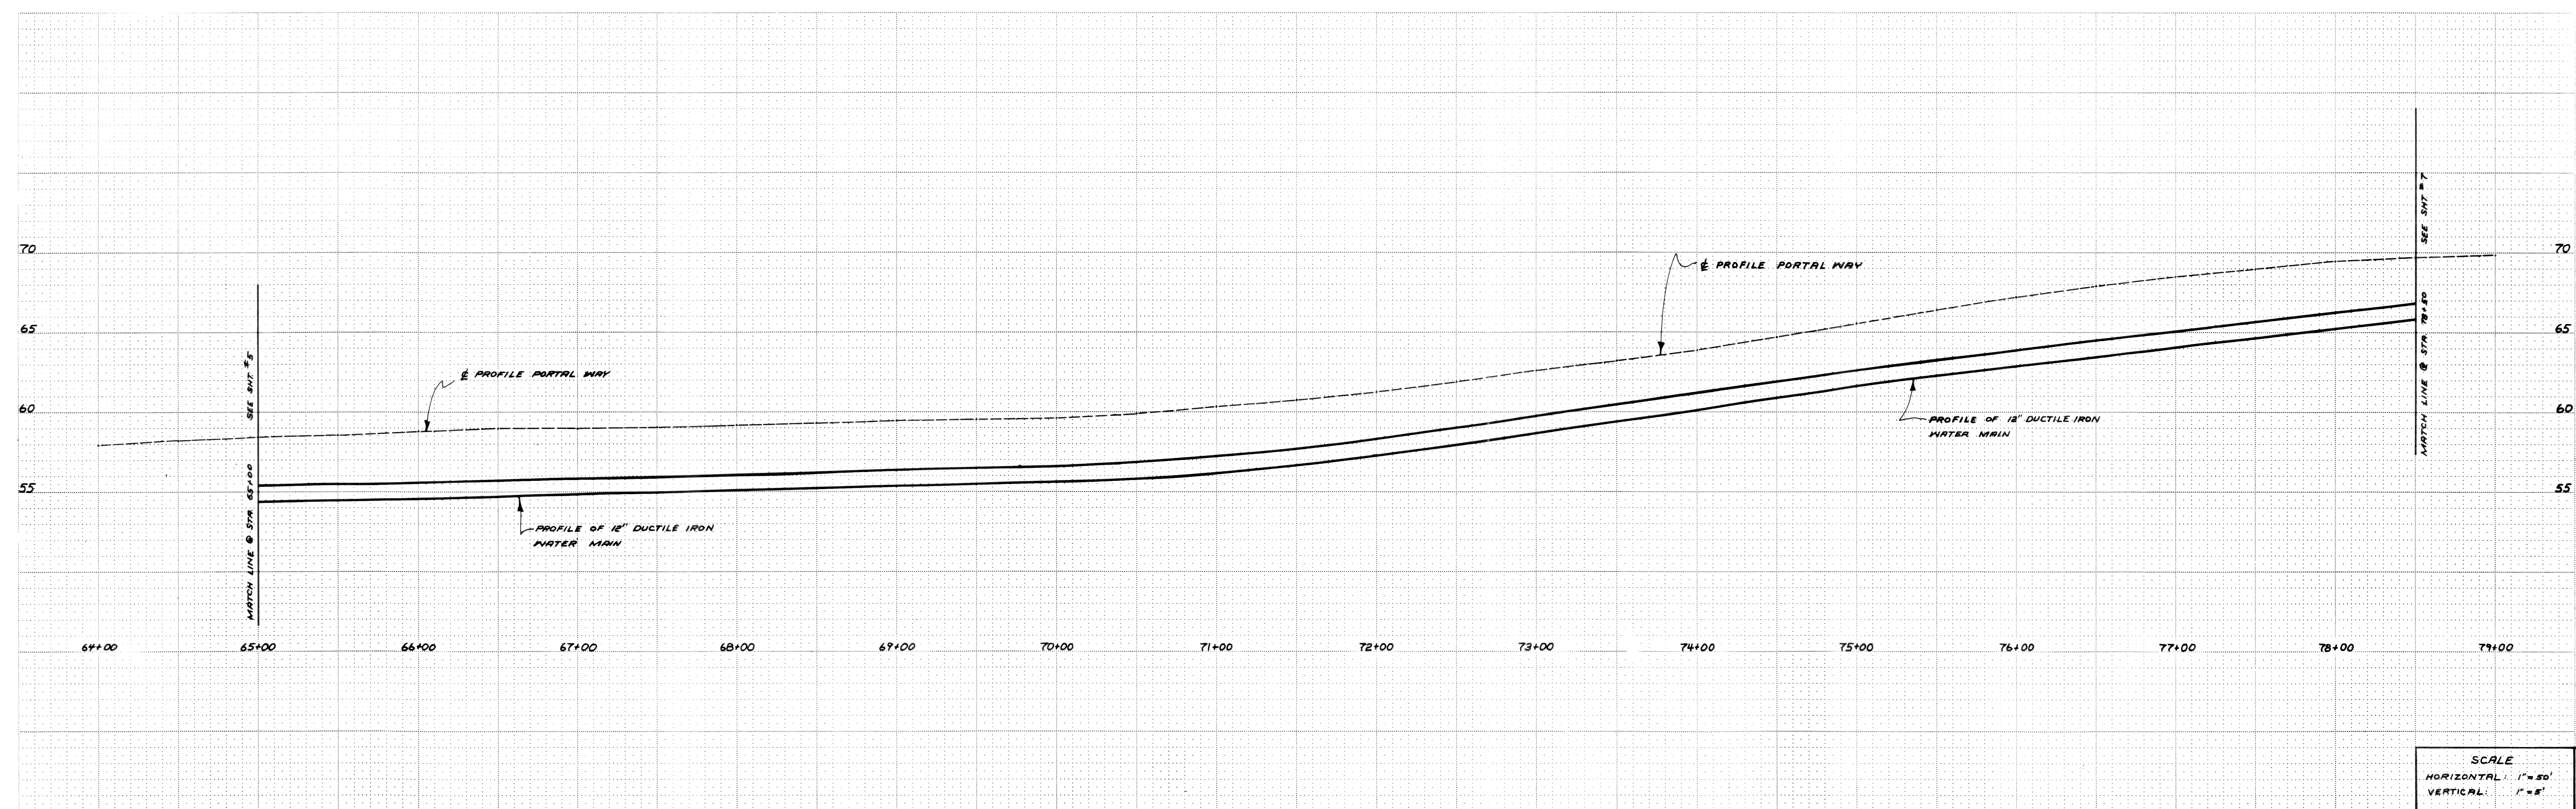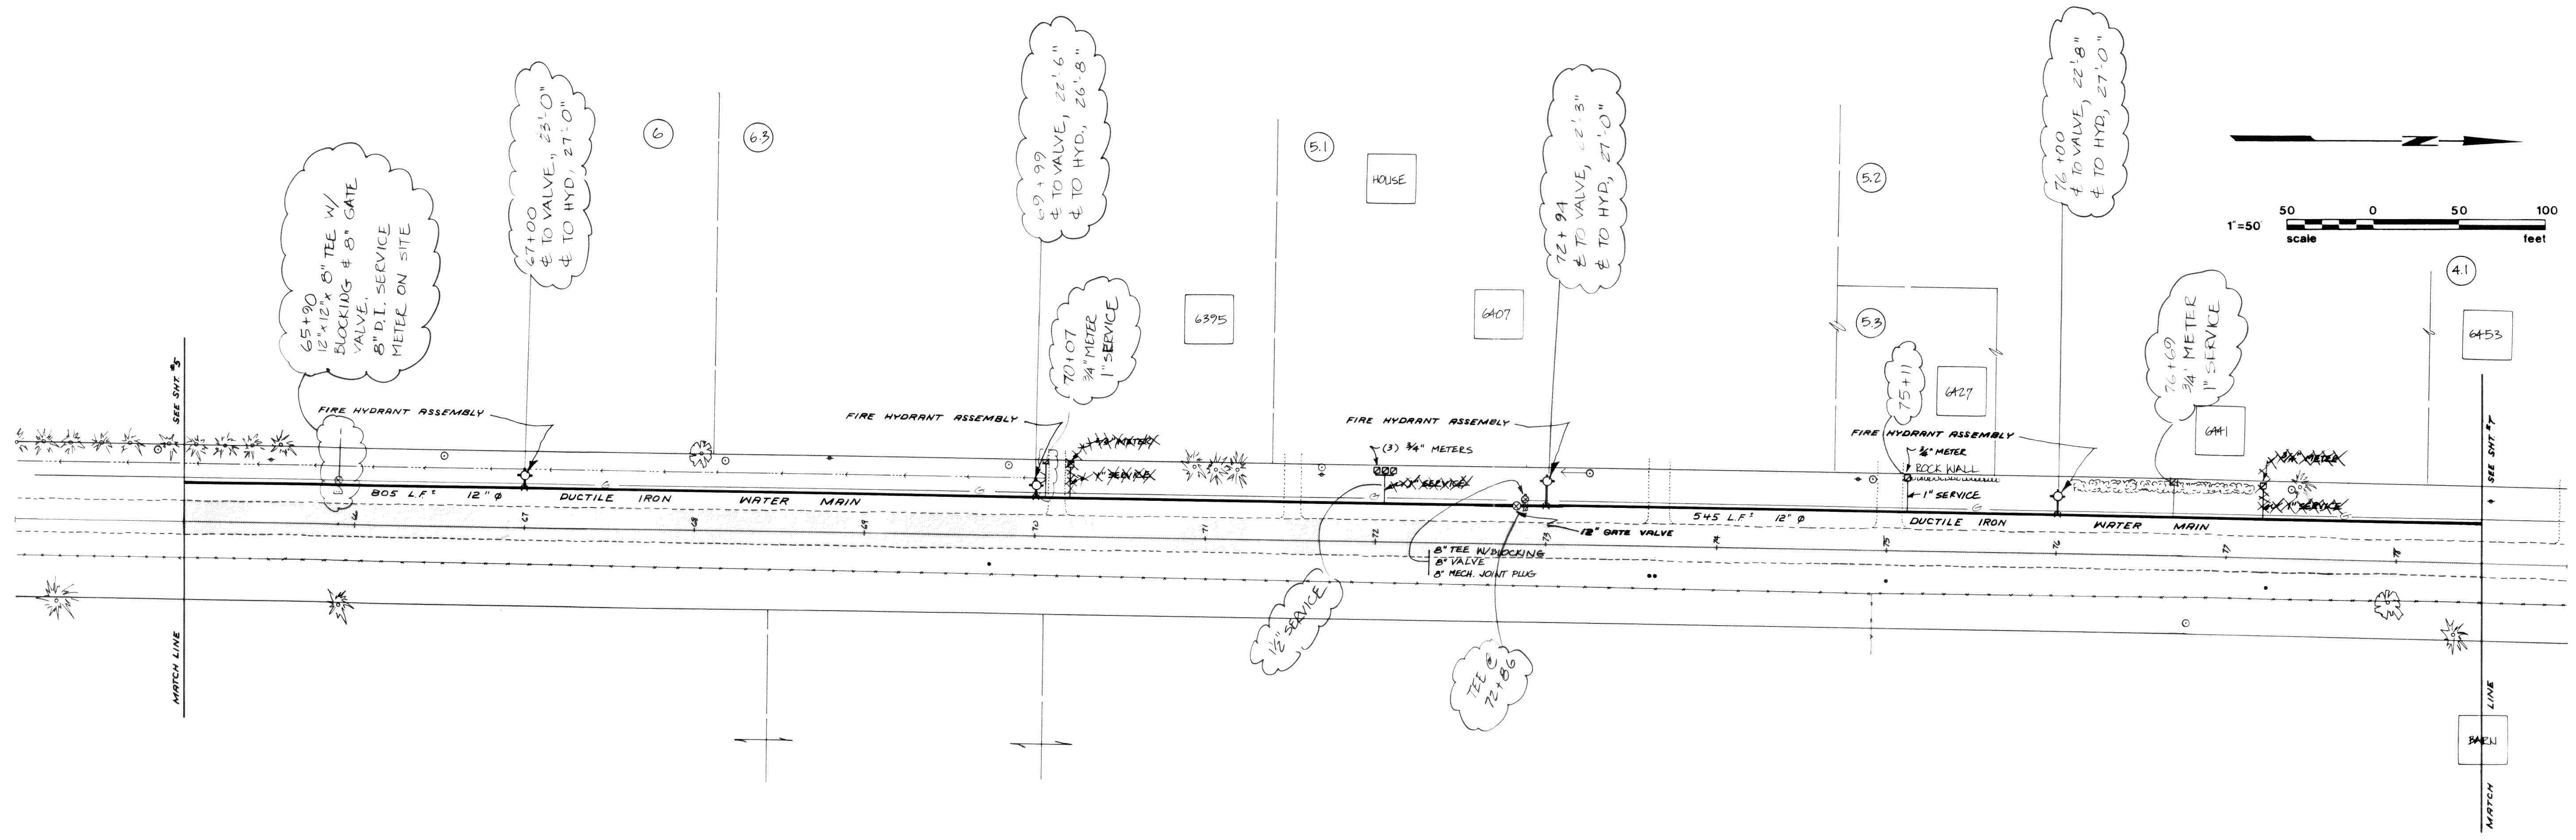

**NORTHWEST CONSULTANTS**  
CIVIL & STRUCTURAL ENGINEERING  
1401 ASTOR, BELLINGHAM, WA. (206) 676 9058

**CITY OF FERNDALE**  
P.O. BOX 936  
FERNDALE, WA. 98248 PH. 384-4302

SCALE AS SHOWN  
DATE 3/10/06  
DRAWN BY SPK/EEF  
CHECKED BY EE  
JOB NO. 80-1431

REVISIONS  
MARK DESCRIPTION DATE BY  
STD 8" VALVE @ 72+00 4-27-06 SPK

**PORTAL WAY IMPROVEMENTS**




**WATER DISTRIBUTION SYSTEM  
PLAN AND PROFILE**

**SCALE**  
HORIZONTAL: 1"=50'  
VERTICAL: 1"=5'

**SHEET**  
6  
OF  
10

JOB NUMBER: 86-1431



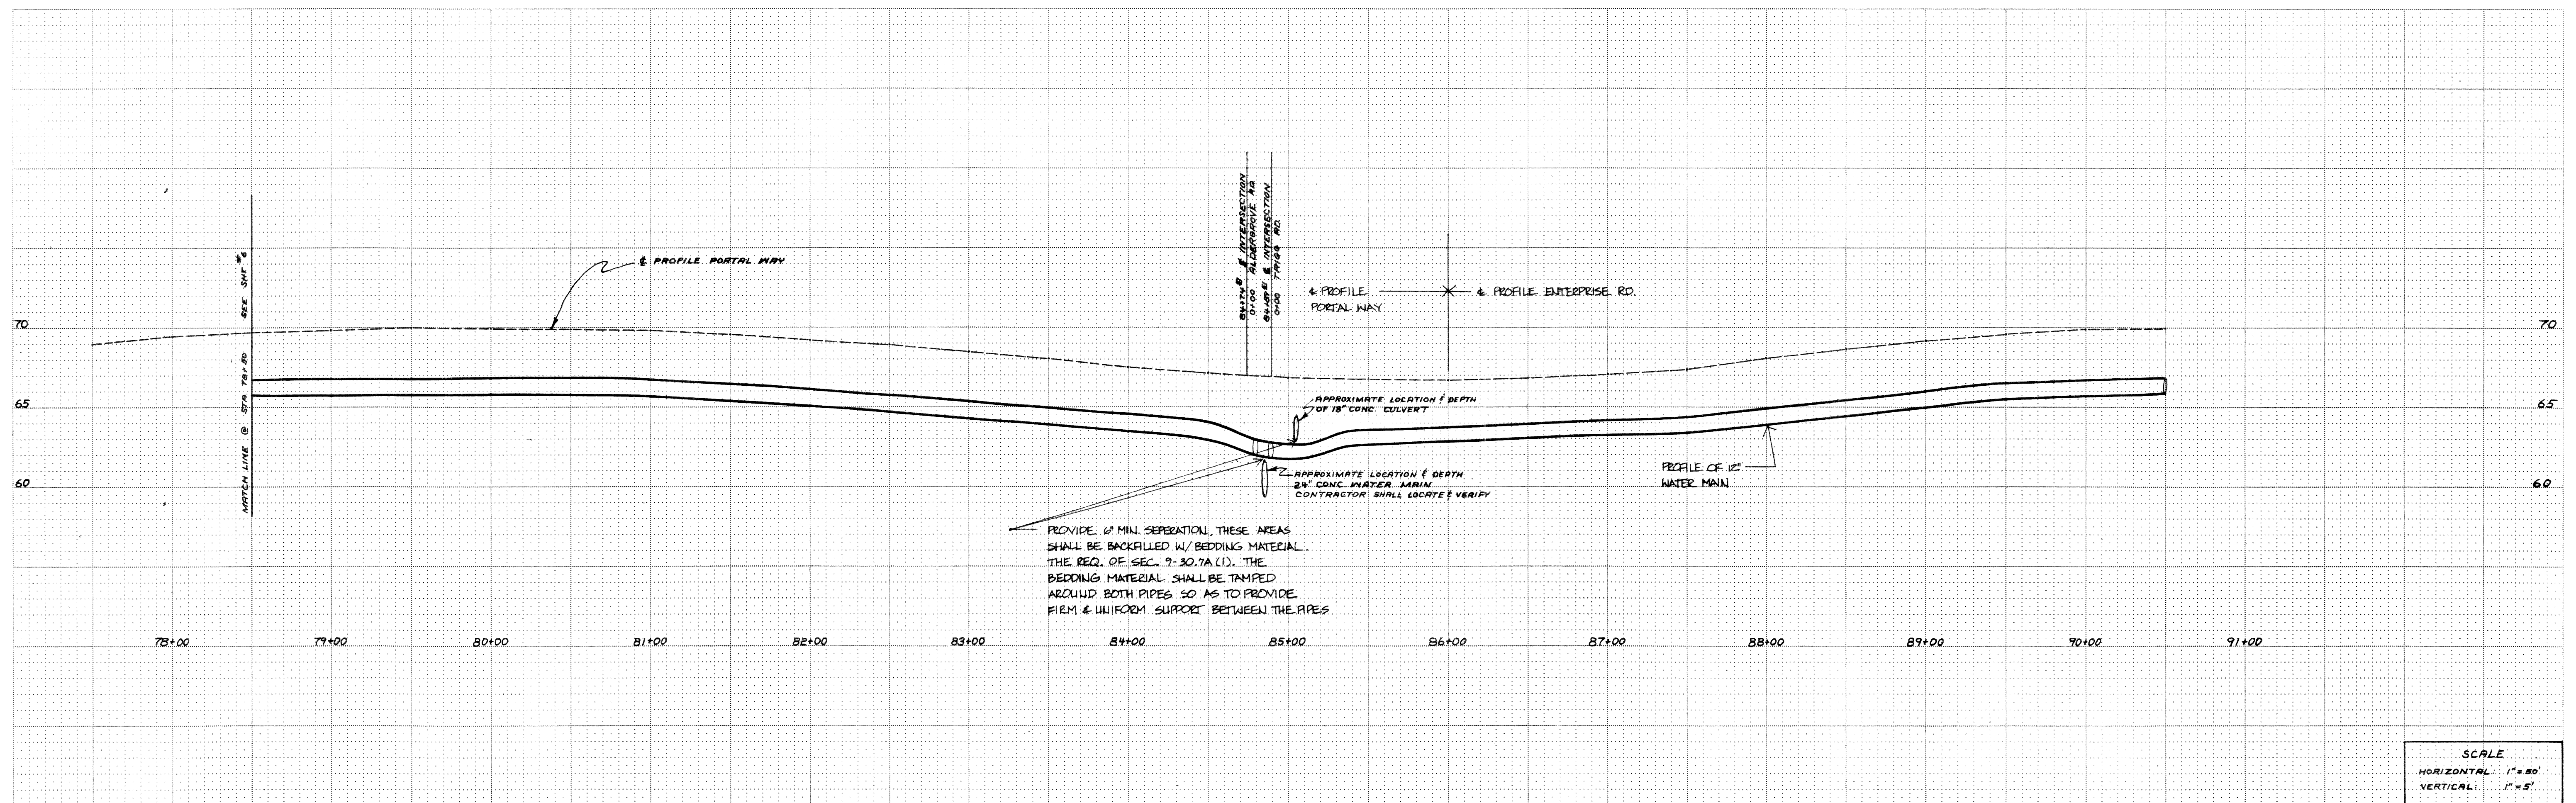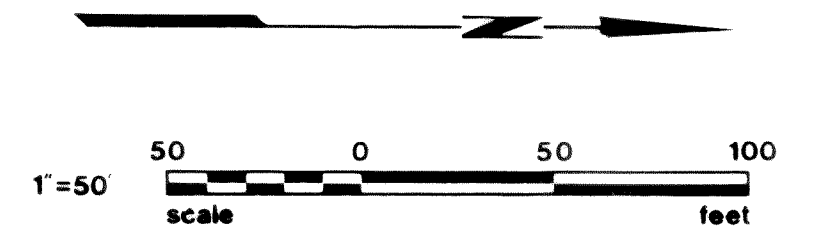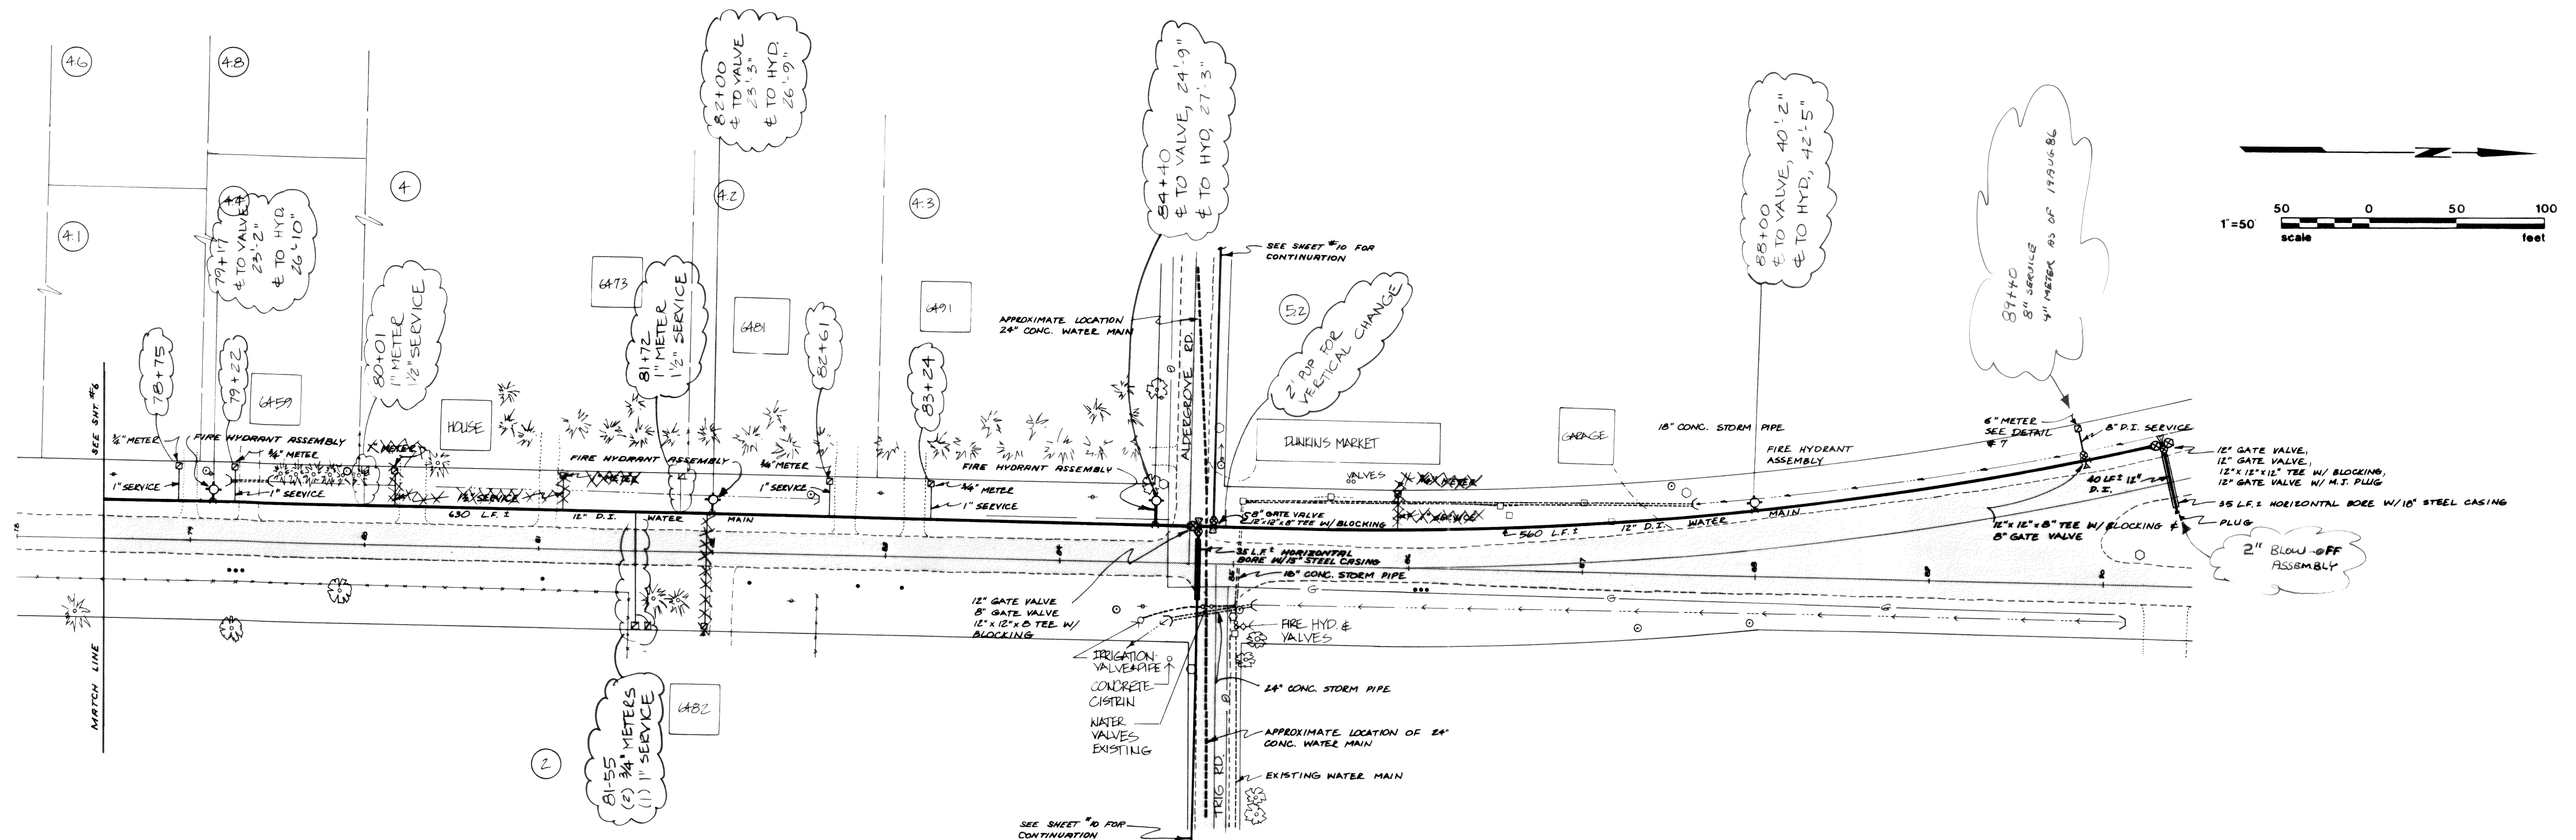

SCALE  
HORIZONTAL: 1" = 50'  
VERTICAL: 1" = 5'

**NORTHWEST CONSULTANTS**  
CIVIL & STRUCTURAL ENGINEERING  
1401 ASTOR, BELLINGHAM, WA. (206) 676-9058


**CITY OF FERDALE**  
P.O. BOX 936  
FERDALE, WA. 98248 PH. 384-4302

SCALE: AS SHOWN  
DATE: 3-10-86  
DRAWN BY: PSW & FF  
CHECKED BY: E.F.  
JOB NO: 20-1431

REVISIONS  
MARK DESCRIPTION DATE BY  
CHANGE DPE 2-7-90 4:23 PM PSW

**PORTAL WAY IMPROVEMENTS**

**WATER DISTRIBUTION SYSTEM  
PLAN AND PROFILE**

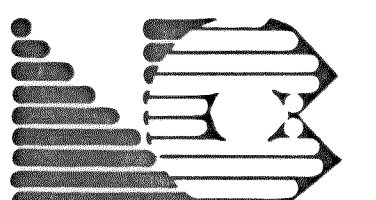



SHEET  
7  
OF  
10

JOB NUMBER: 86-1431

002712-007 2-2-06 KR



00272.008 220642

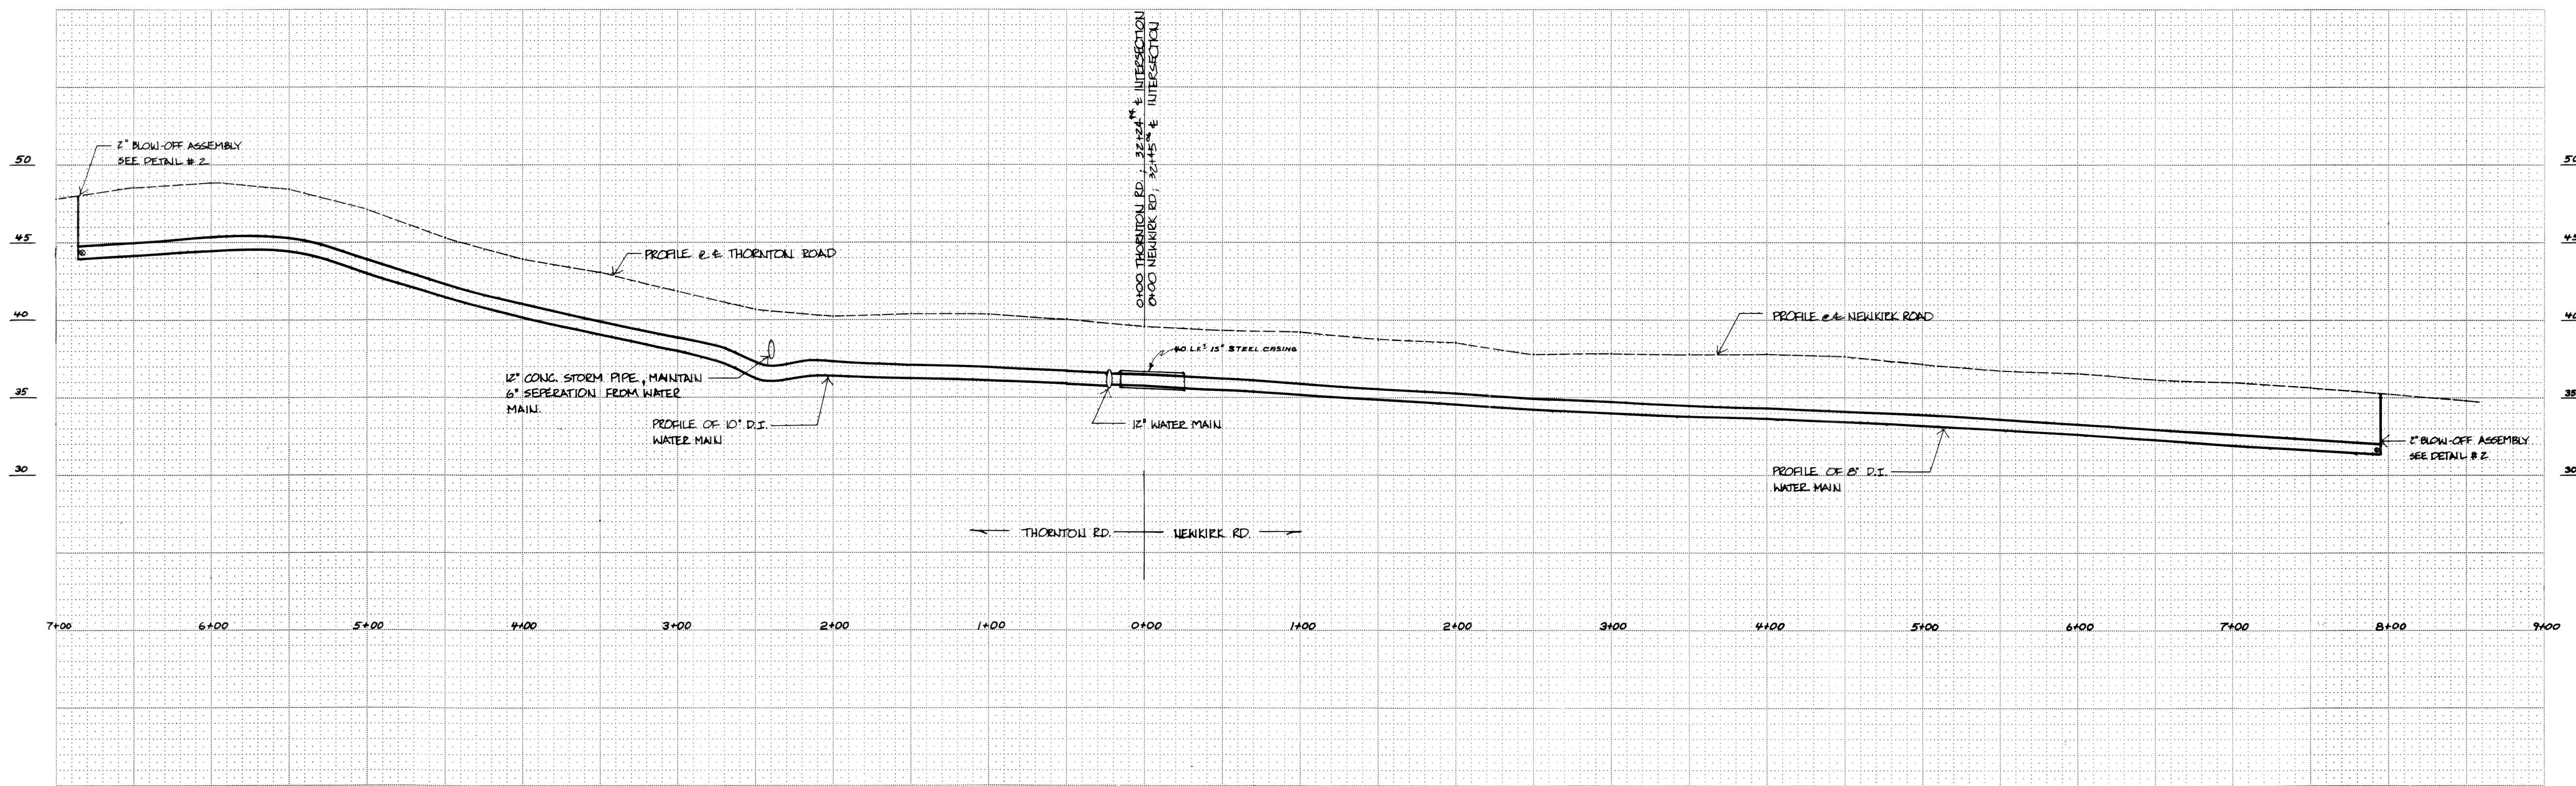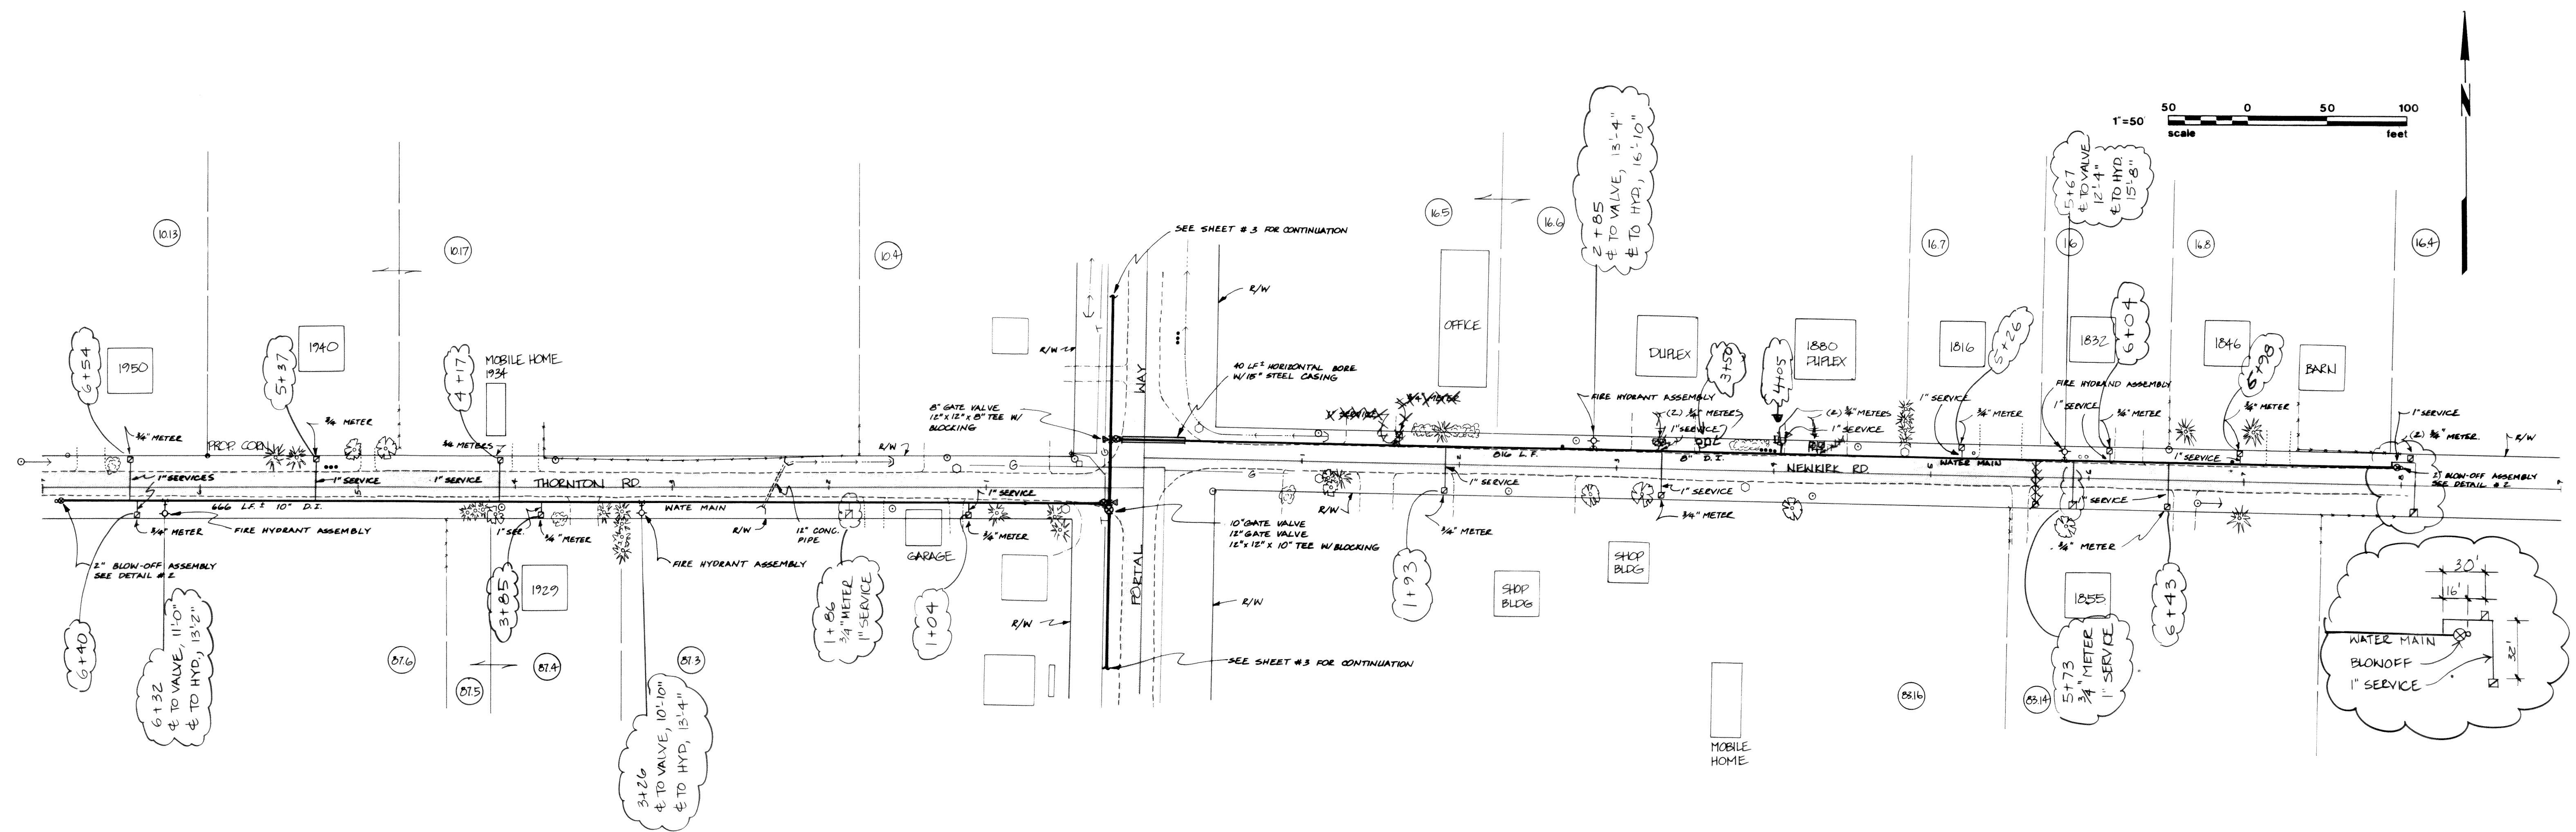

**NORTHWEST CONSULTANTS**  
CIVIL & STRUCTURAL ENGINEERING  
1401 ASTOR, BELLINGHAM, WA. (206) 676-9058

**CITY OF FERDALE**  
P.O. BOX 936  
FERDALE, WA. 98248 PH. 384-4302

SCALE AS SHOWN  
DATE 2-18-80  
DRAWN BY BSW & EF  
CHECKED BY EF  
JOB NO. 86-1431

| REVISIONS |             |         |
|-----------|-------------|---------|
| MARK      | DESCRIPTION | DATE BY |
|           |             |         |
|           |             |         |
|           |             |         |

**NEWKIRK & THORNTON ROADS IMPROVEMENTS**



**WATER DISTRIBUTION SYSTEM**  
PLAN AND PROFILE



SHEET  
8  
OF  
10

JOB NUMBER: 86-1431





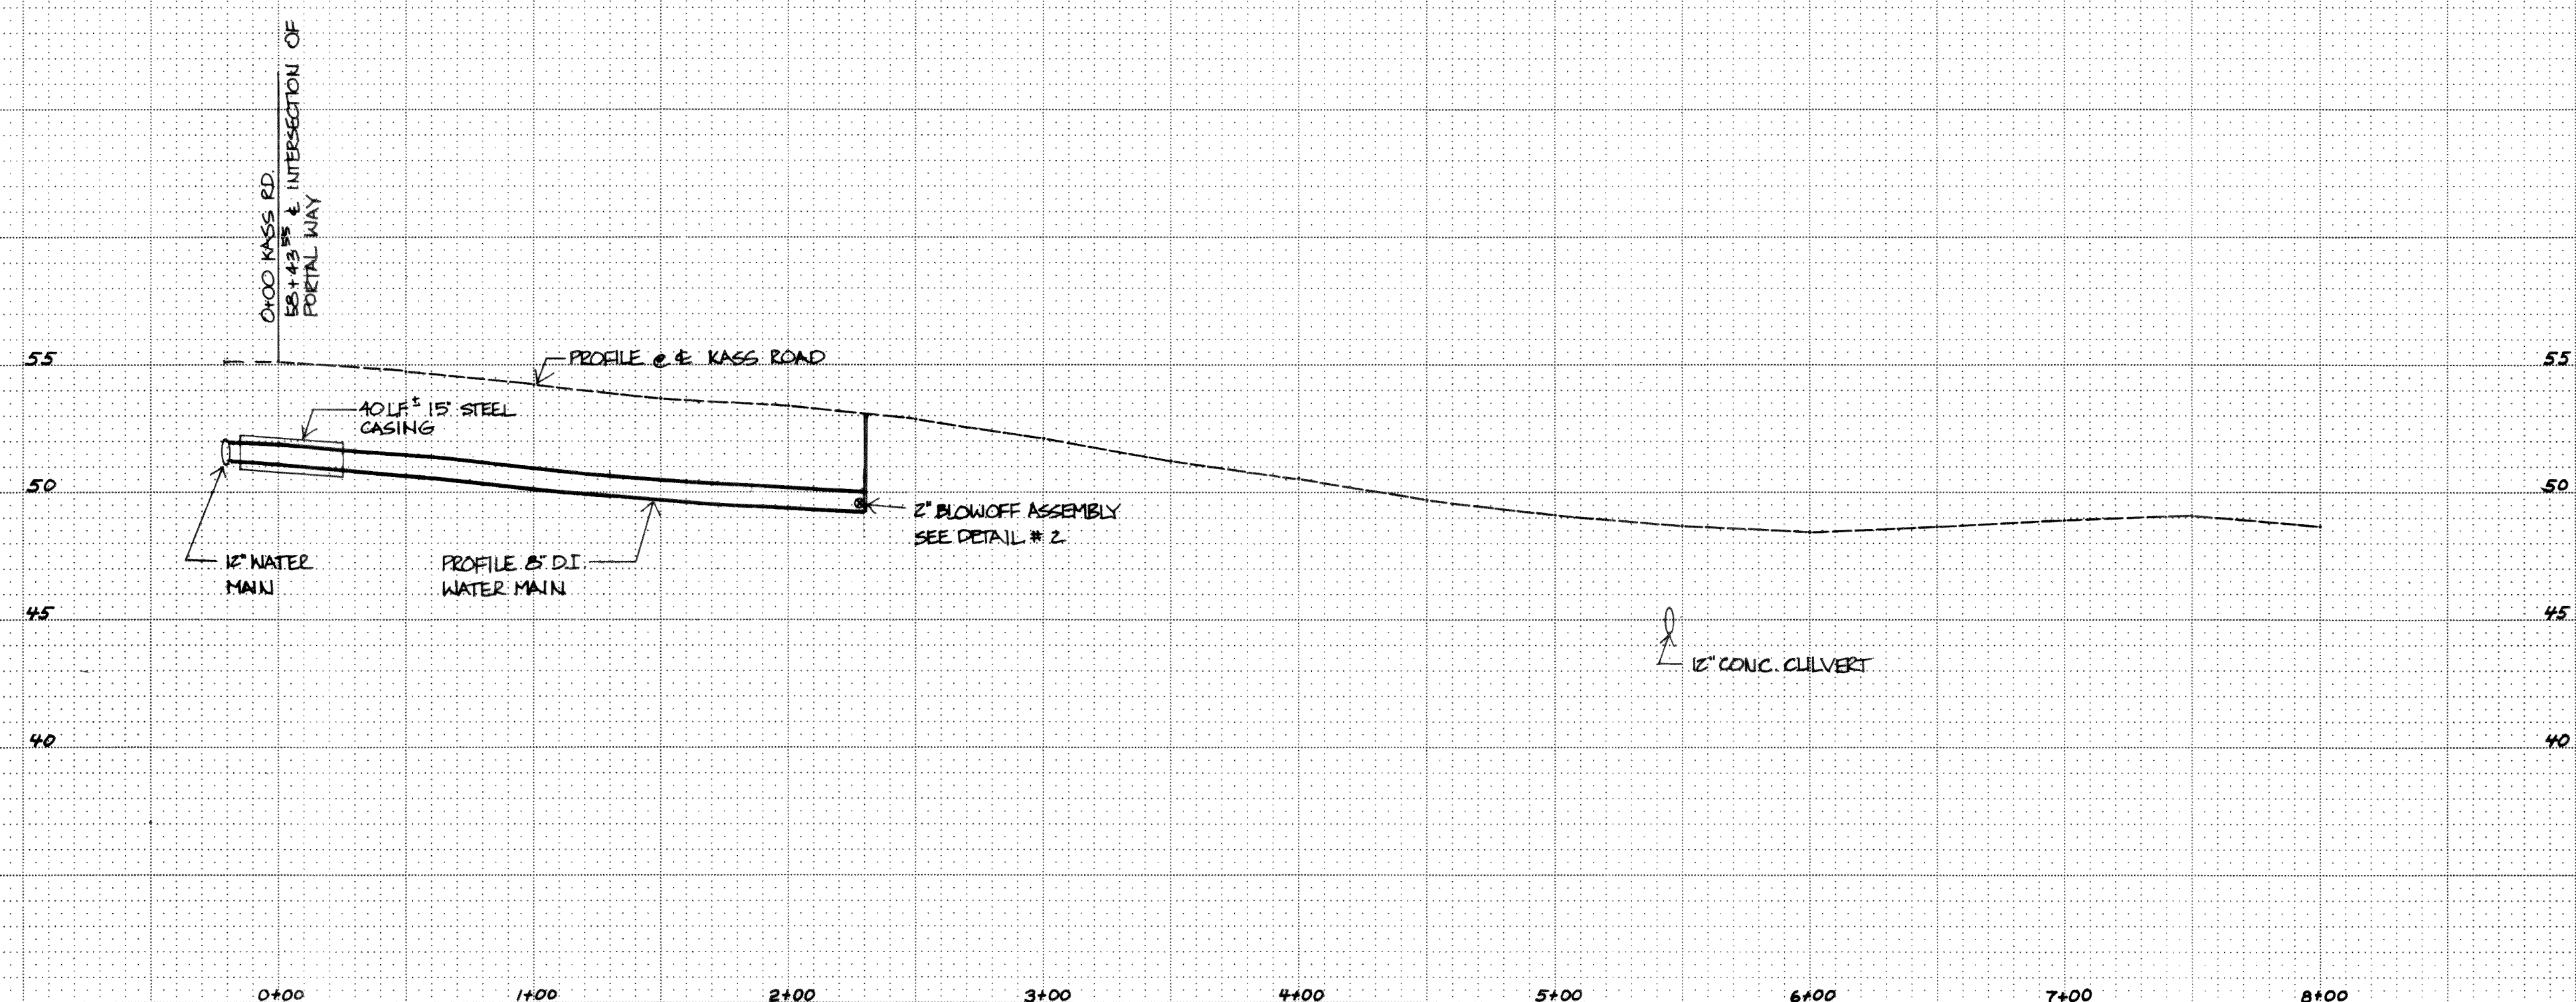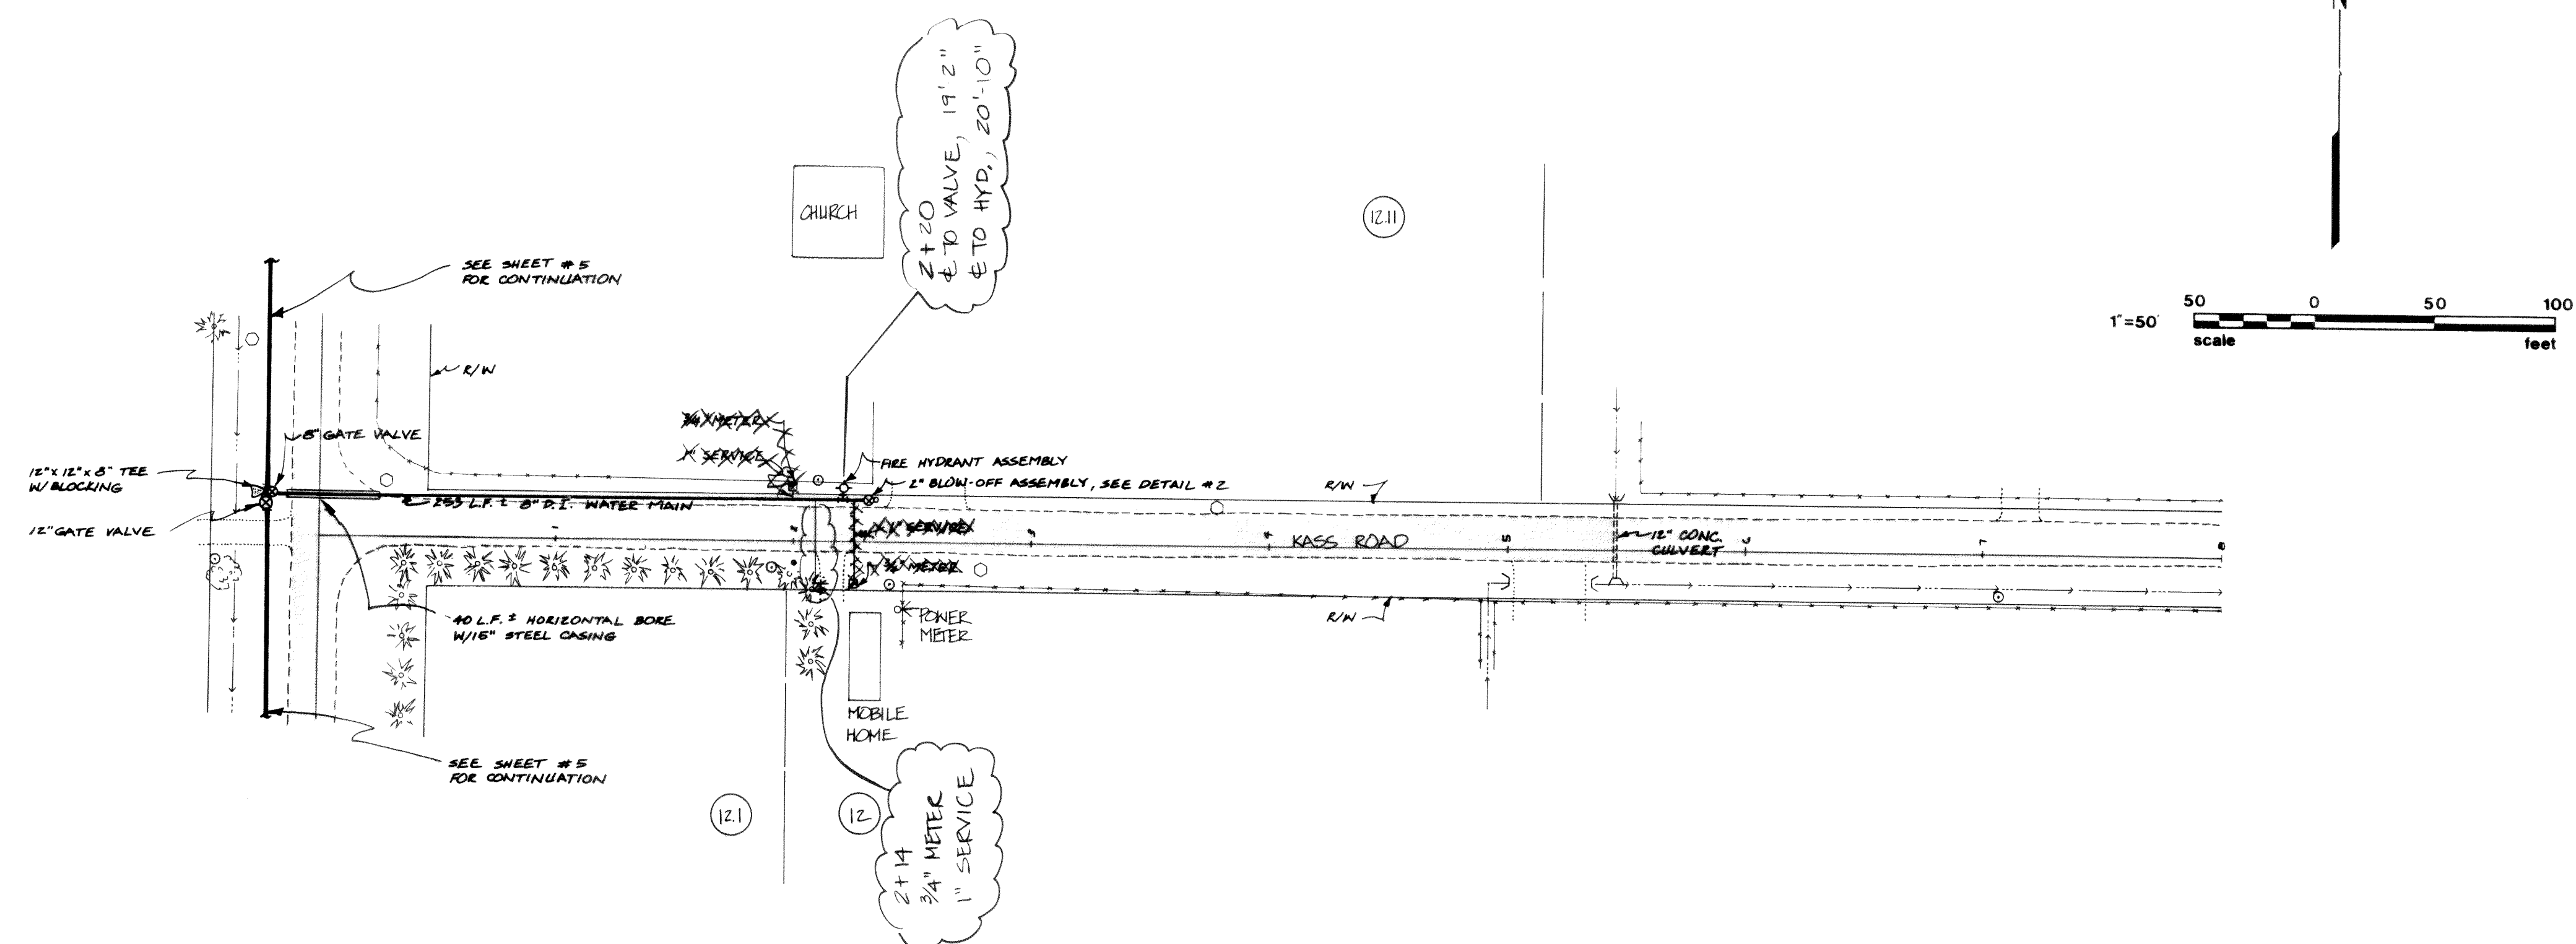

SCALE  
HORIZONTAL: 1" = 50'  
VERTICAL: 1" = 5'



00272.010 2-2-06

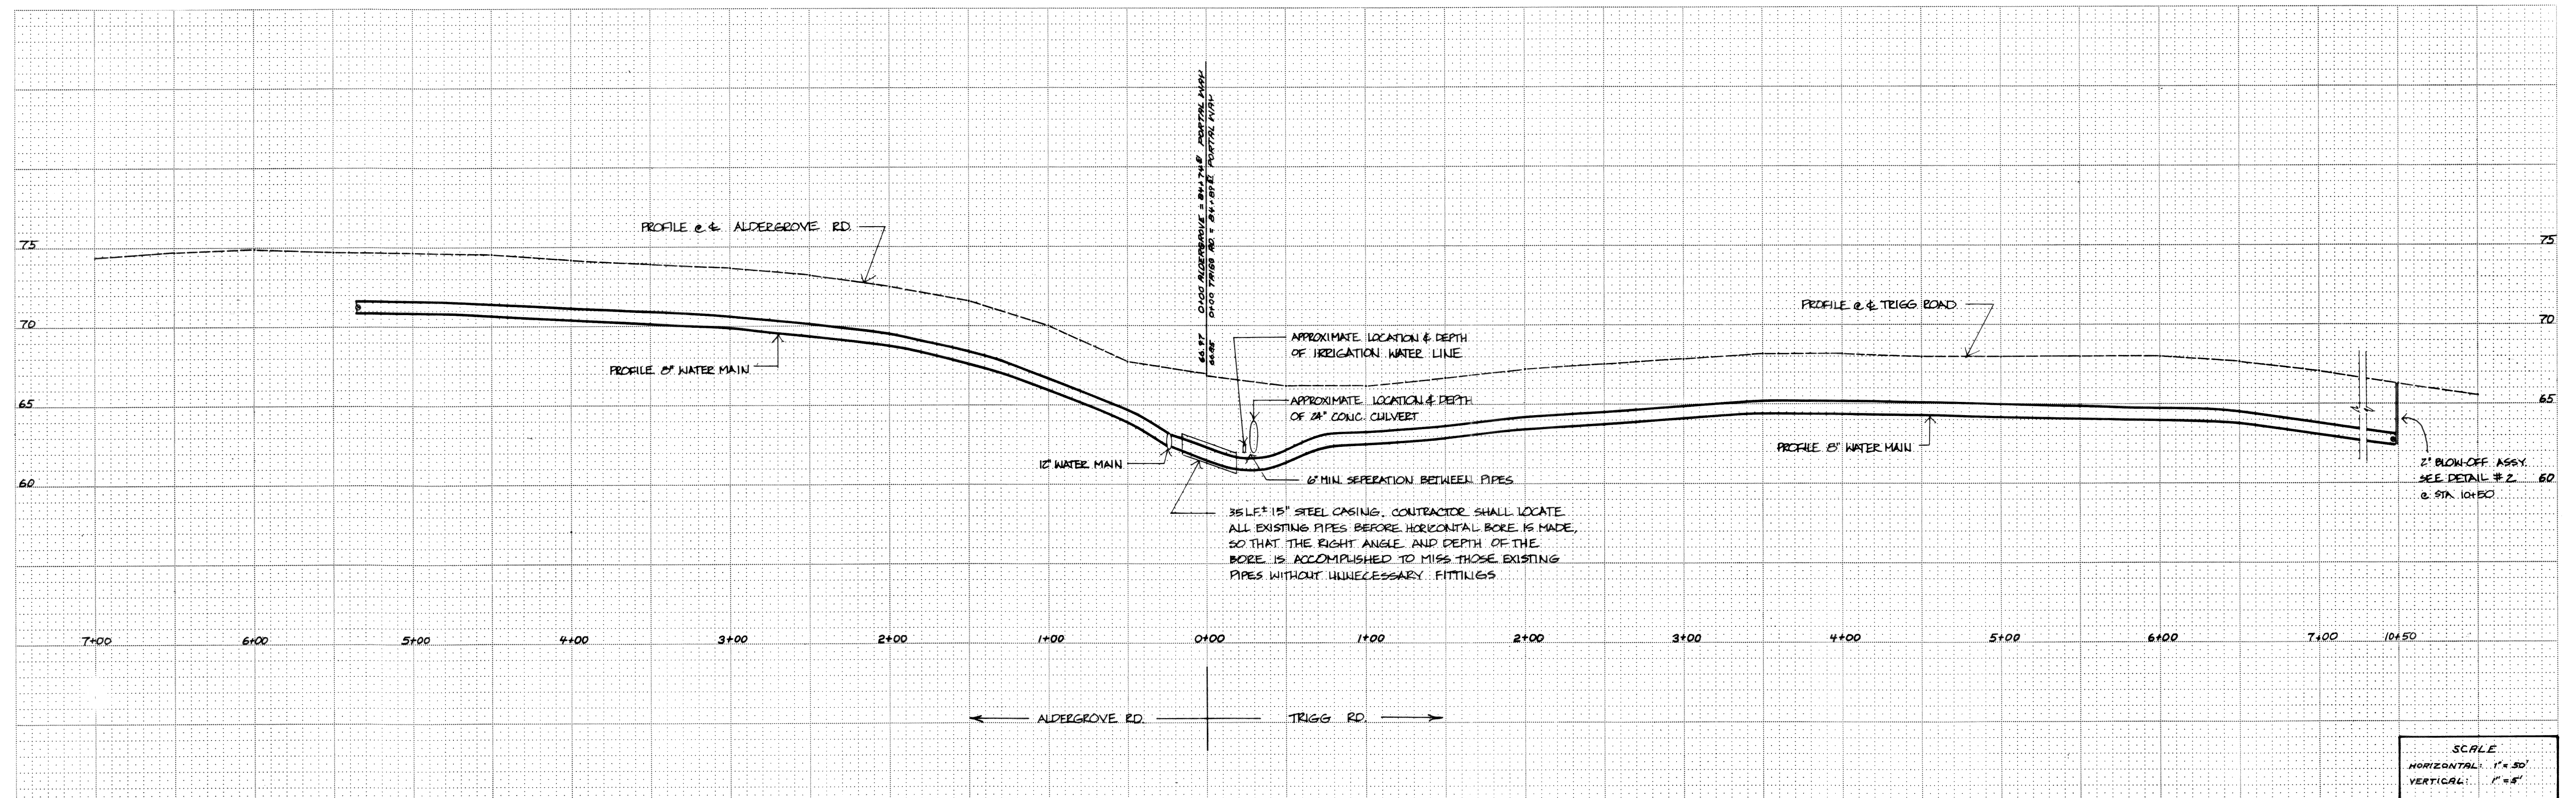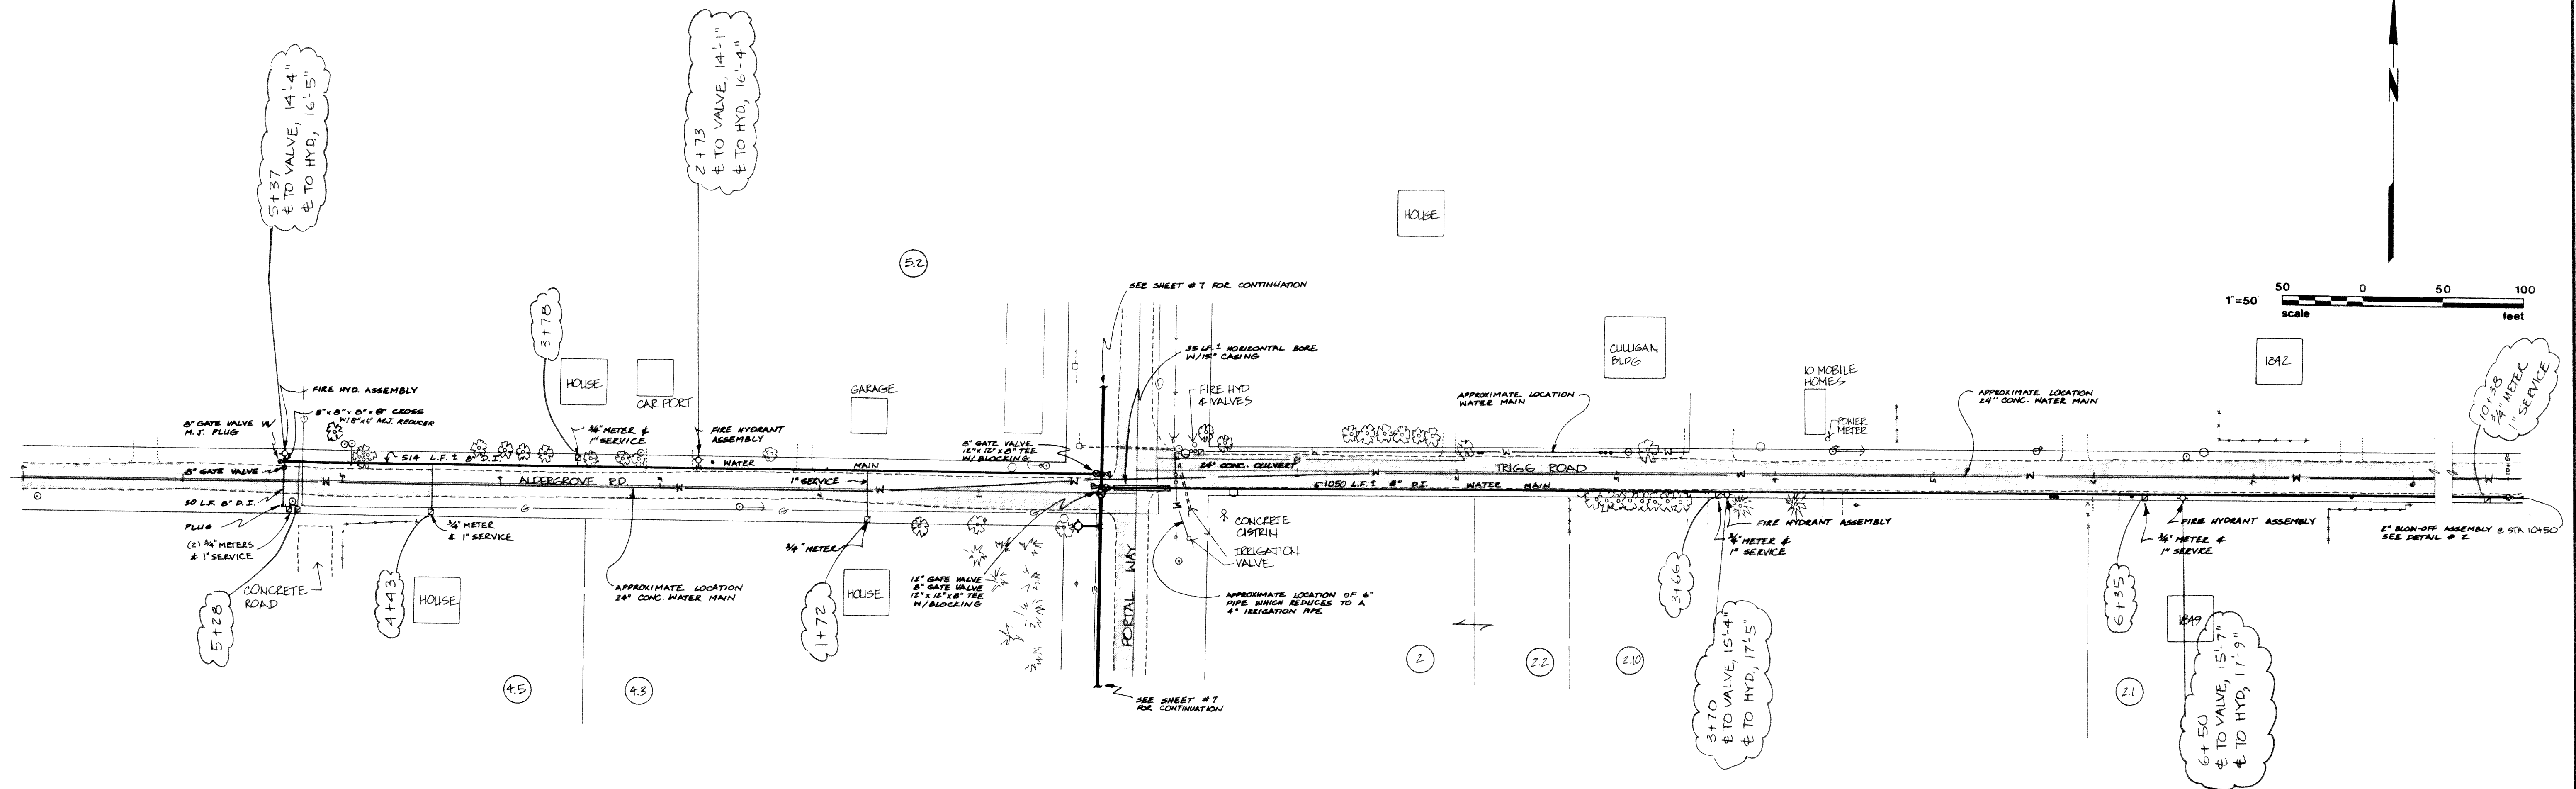

**NORTHWEST CONSULTANTS**  
CIVIL & STRUCTURAL ENGINEERING  
1401 ASTOR, BELLINGHAM, WA.  
(206) 676-9058

**CITY OF FERDALE**  
P.O. BOX 936  
FERDALE, WA. 98248  
P.O. BOX 936  
PH. 384-4302

SCALE: AS SHOWN  
DATE: 3-10-06  
DRAWN BY: JCH & EF  
CHECKED BY: JCH  
JOB NO: 86-1431

REVISIONS  
DATE BY  
1. 3-10-06 JCH & EF  
(S) SERVICES & OLD ALDERGROVE

**TRIGG ROAD & ALDERGROVE ROAD  
IMPROVEMENTS**

**WATER DISTRIBUTION SYSTEM  
PLAN AND PROFILE**



SHEET  
10  
OF  
10

JOB NUMBER: 86-1431