


# CITY OF FERNDALE WASHINGTON

## WATER DISTRIBUTION SYSTEM Portal Way, Thornton, Newkirk, Kass, Aldergrove and Trigg Roads

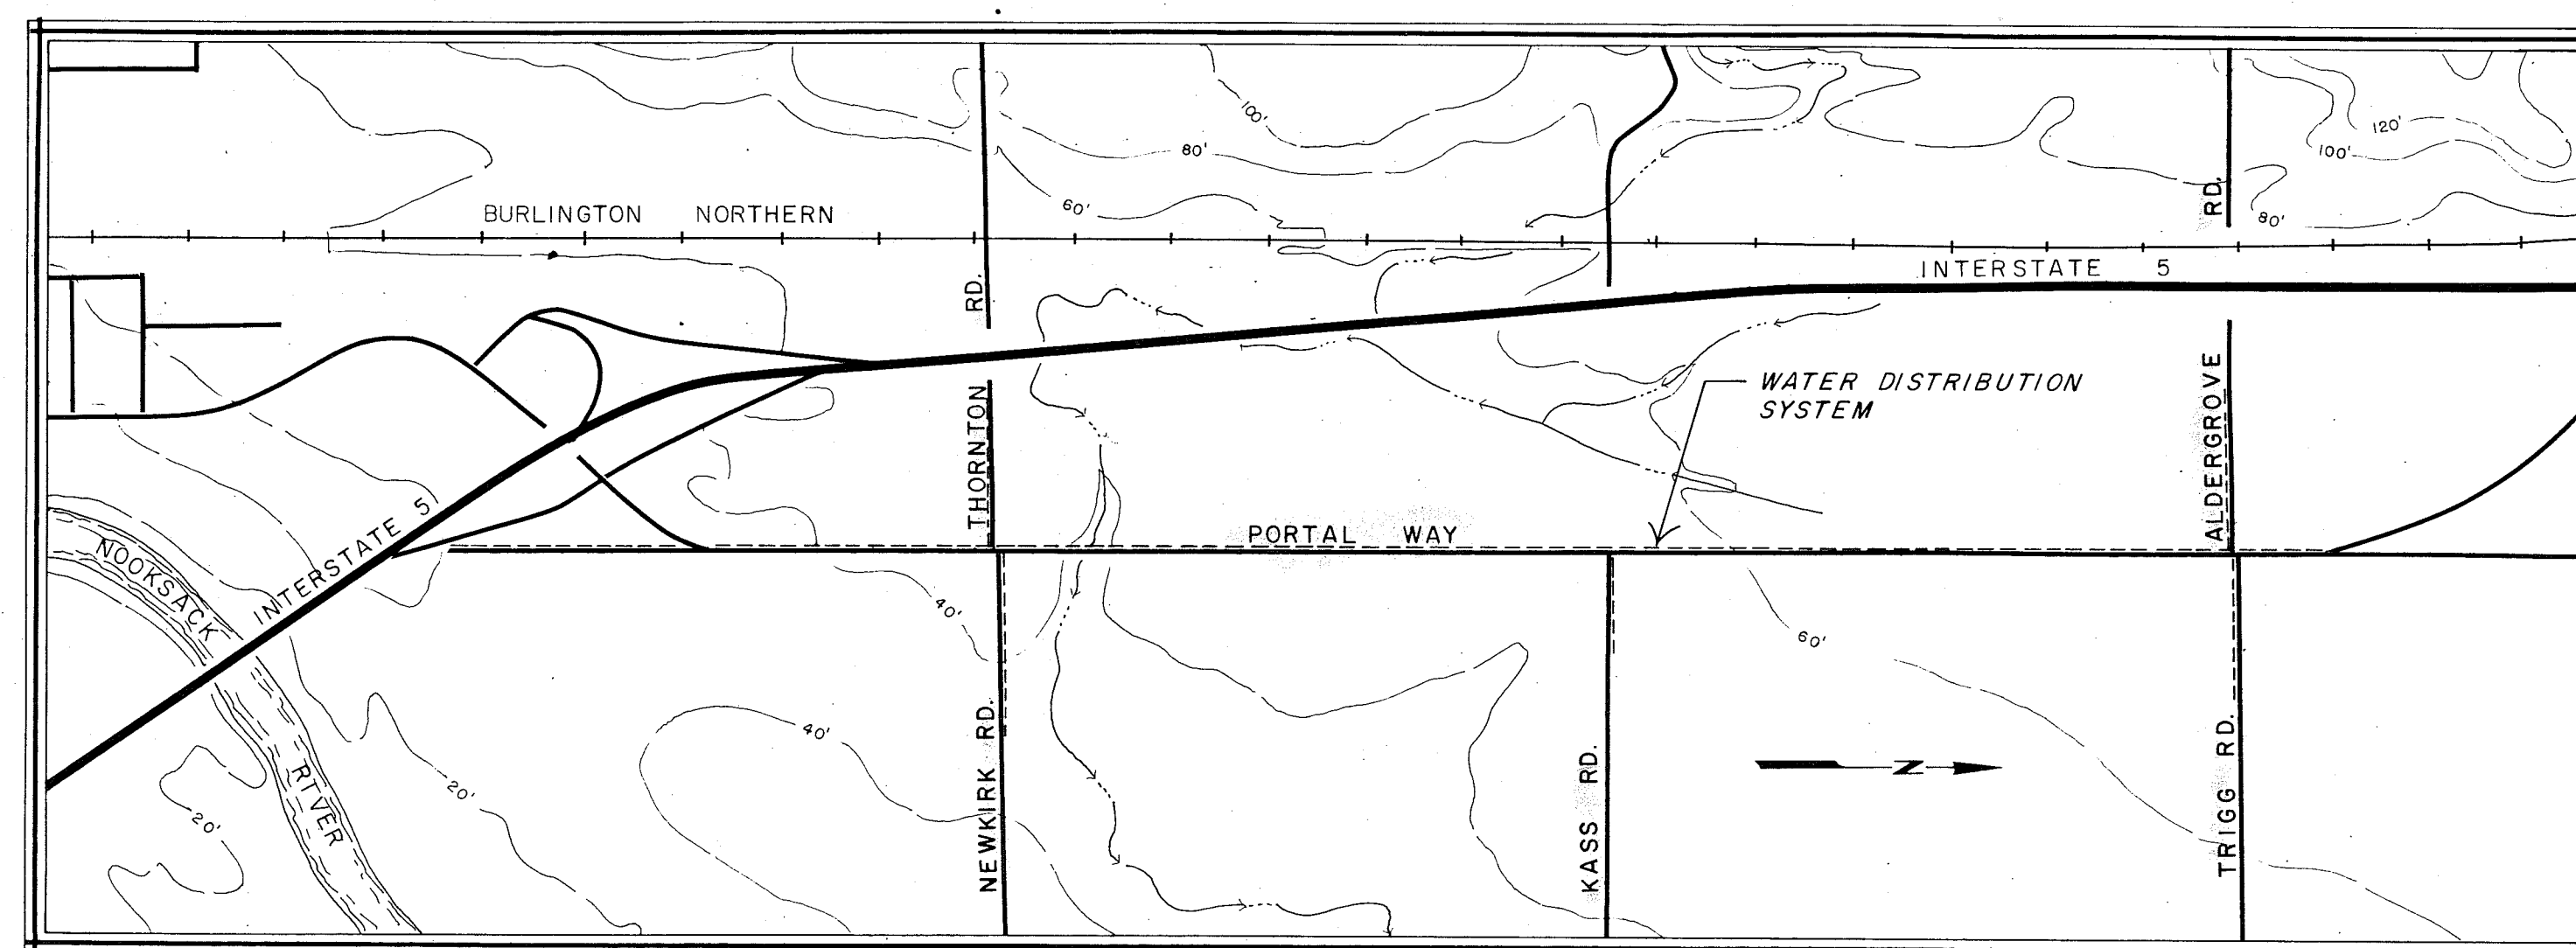

VICINITY MAP

### CITY OFFICIALS

#### CITY MANAGER

Ron Peterson

#### CITY COUNCIL

Alfred Schmidt - mayor; Madelyn Waslohn; Gary Gibbons; Jack Williams;  
Lorna Gemmell; D.P. 'Pat' Sizemore; Dennis Hawkinson

#### CLERK TREASURER



Roland Signett

#### DIRECTOR OF PUBLIC WORKS

John Eley

ENGINEER: NORTHWEST CONSULTANTS INC.



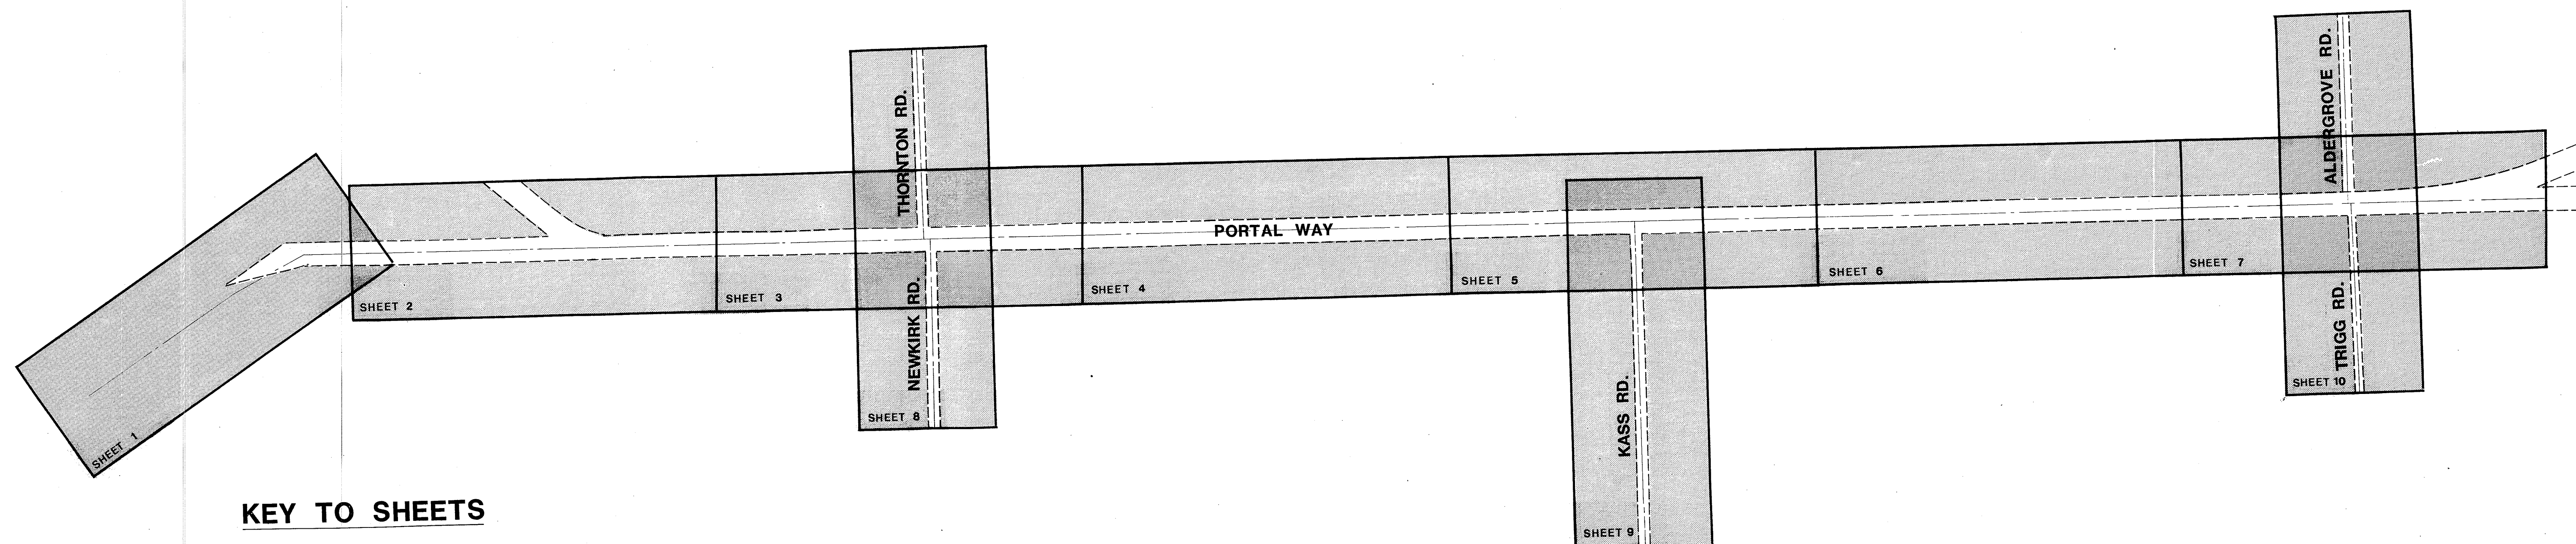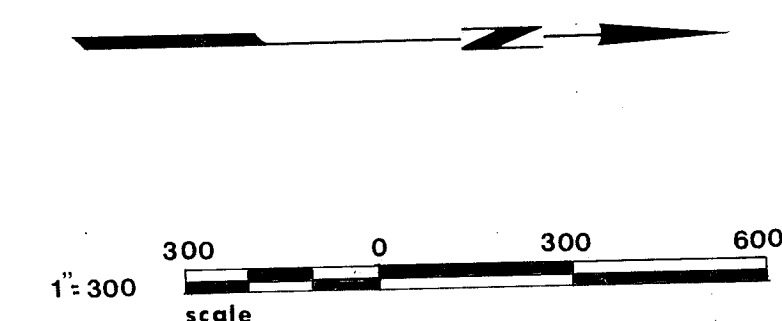

### KEY TO SHEETS

| SHEET | STATION |          | ROAD           |
|-------|---------|----------|----------------|
|       | FROM    | TO       |                |
| 1     | 0+00    | TO 10+50 | PORTAL WAY     |
| 2     | 10+50   | TO 24+50 | PORTAL WAY     |
| 3     | 24+50   | TO 37+50 | PORTAL WAY     |
| 4     | 37+50   | TO 51+50 | PORTAL WAY     |
| 5     | 51+50   | TO 65+00 | PORTAL WAY     |
| 6     | 65+00   | TO 78+50 | PORTAL WAY     |
| 7     | 78+50   | TO 90+50 | PORTAL WAY     |
| 8     | 0+00    | TO 7+00  | THORNTON RD.   |
| 8     | 0+00    | TO 8+60  | NEWKIRK RD.    |
| 9     | 0+00    | TO 8+00  | KASS RD.       |
| 10    | 0+00    | TO 8+00  | ALDERGROVE RD. |
| 10    | 0+00    | TO 7+50  | TRIGG RD.      |

### KEY TO STATIONING

|  |                                         |  |                 |
|--|-----------------------------------------|--|-----------------|
|  | EDGE OF PAVEMENT                        |  | WATER METER     |
|  | GRAVEL DRIVE                            |  | STORM PIPE      |
|  | ASPHALT OR CONCRETE DRIVE               |  | SIGN            |
|  | FENCE                                   |  | END OF CULVERT  |
|  | DITCH                                   |  | BLOW-OFF        |
|  | UTILITY POLE (arrow indicates guy wire) |  | FIRE HYDRANT    |
|  | GAS LINE                                |  | VALVE           |
|  | EXISTING WATER LINE                     |  | BLOCKING        |
|  | BURIED TELEPHONE CABLE                  |  | BROAD LEAF TREE |
|  | TELEPHONE JUNCTION PEDESTAL             |  | EVERGREEN TREE  |
|  | MAIL BOX                                |  | SHRUBS          |
|  | CATCH BASIN                             |  | PARCEL TAX No.  |

### LEGEND

**NORTHWEST CONSULTANTS**  
CIVIL & STRUCTURAL ENGINEERING  
1401 ASTOR BELLINGHAM, WA. (206) 676-9058

CITY OF FERDALE  
PO BOX 936  
FERDALE, WA. 98248 PHONE 384-4302

SCALE: AS SHOWN  
DATE: 3-20-86  
DRAWN BY: PBN  
CHECKED BY: EF  
JOB NO.: 86-1431

REVISIONS  
MARK DESCRIPTION DATE BY

PORTAL WAY IMPROVEMENTS

KEYS AND LEGEND FOR  
WATER DISTRIBUTION SYSTEM PLANS




SHEET  
OF




108 No. 001431

00457.002 CL 6/19/12





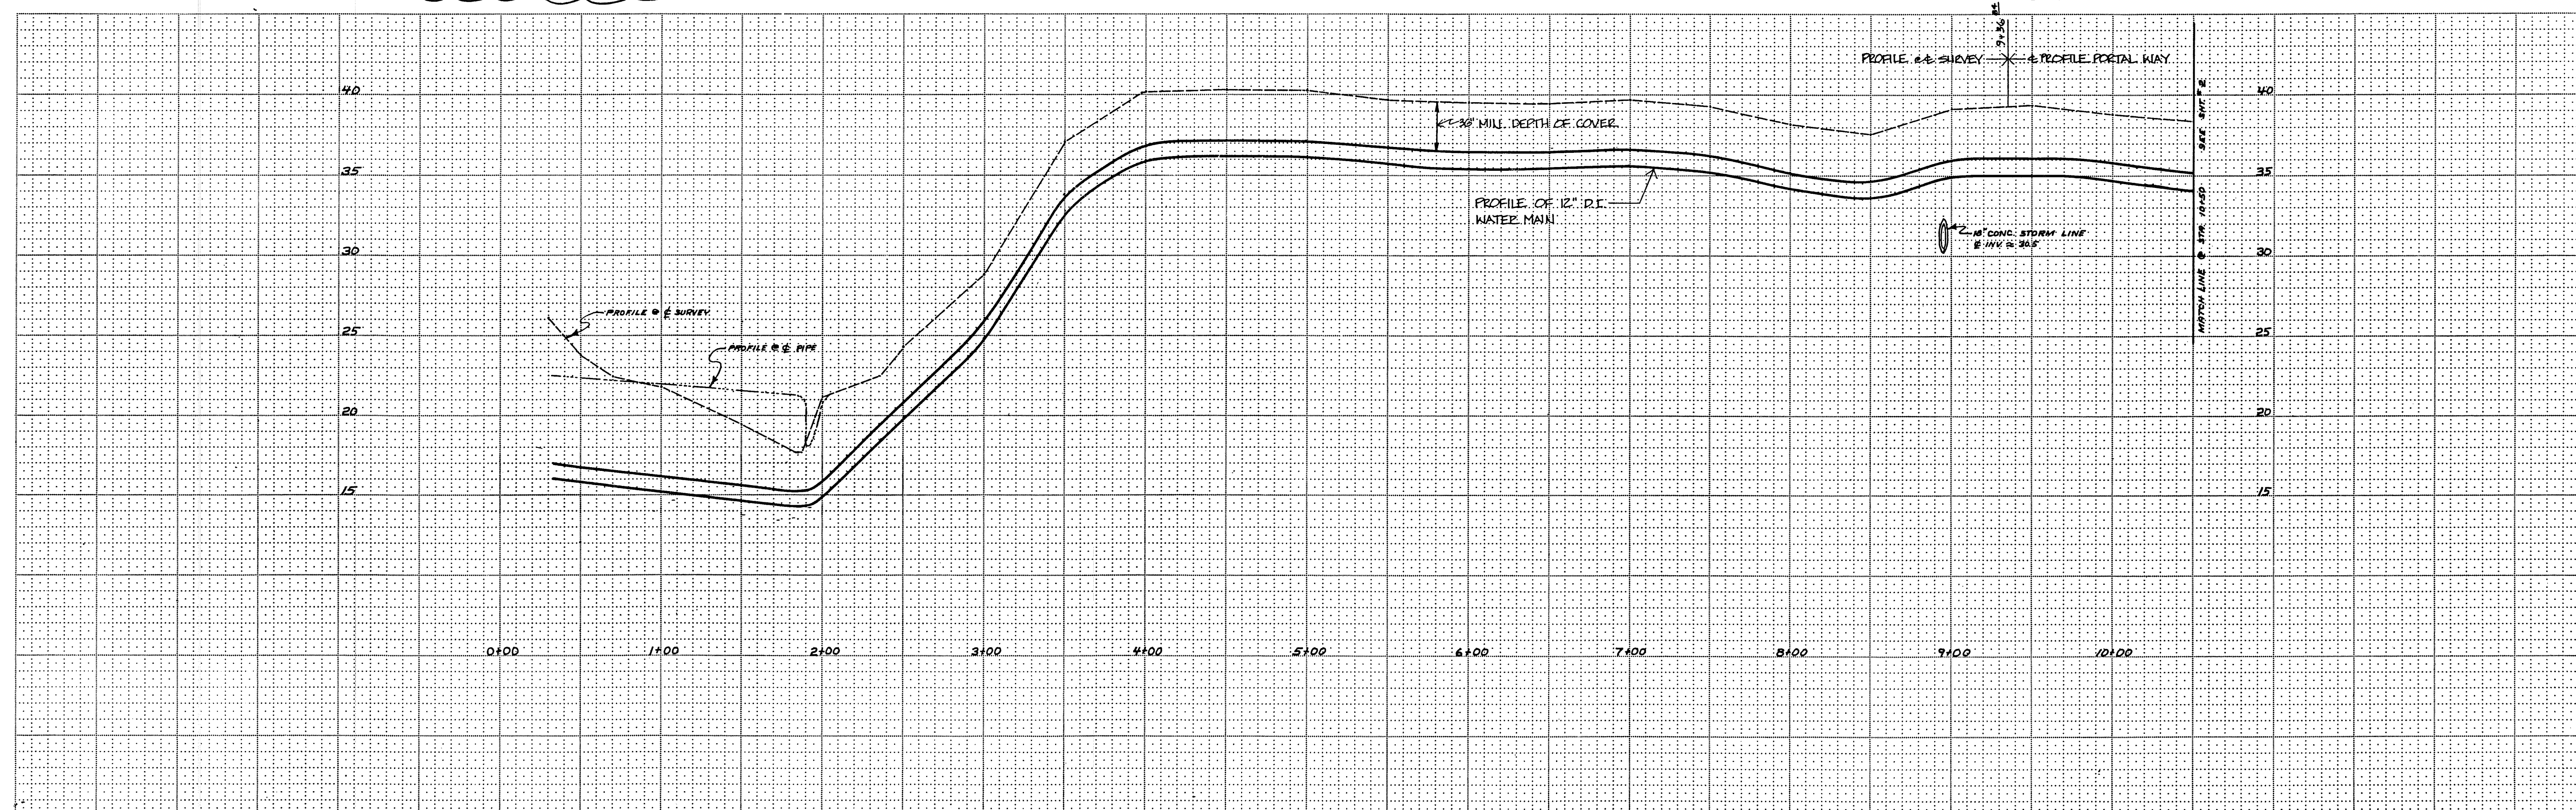



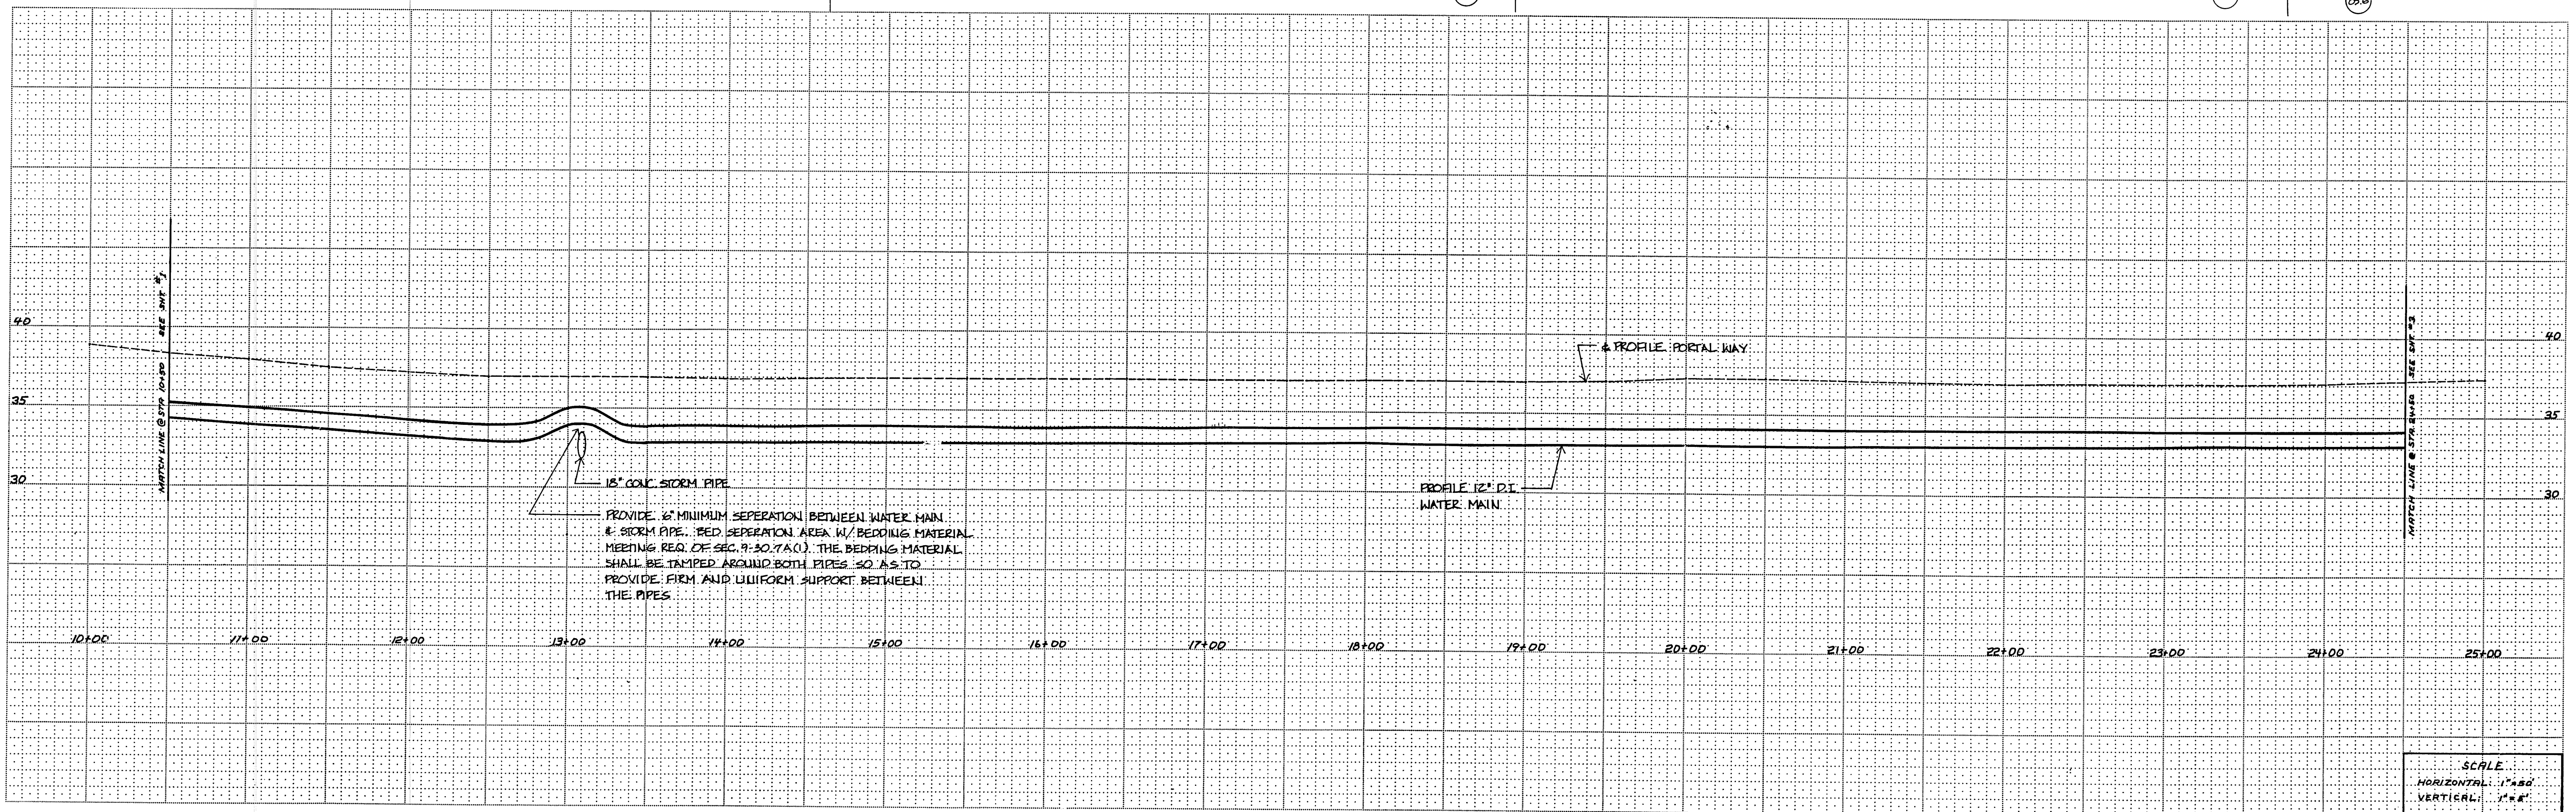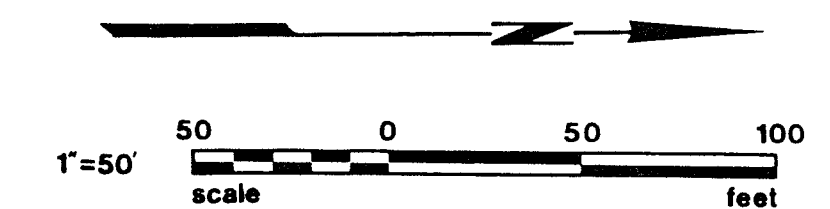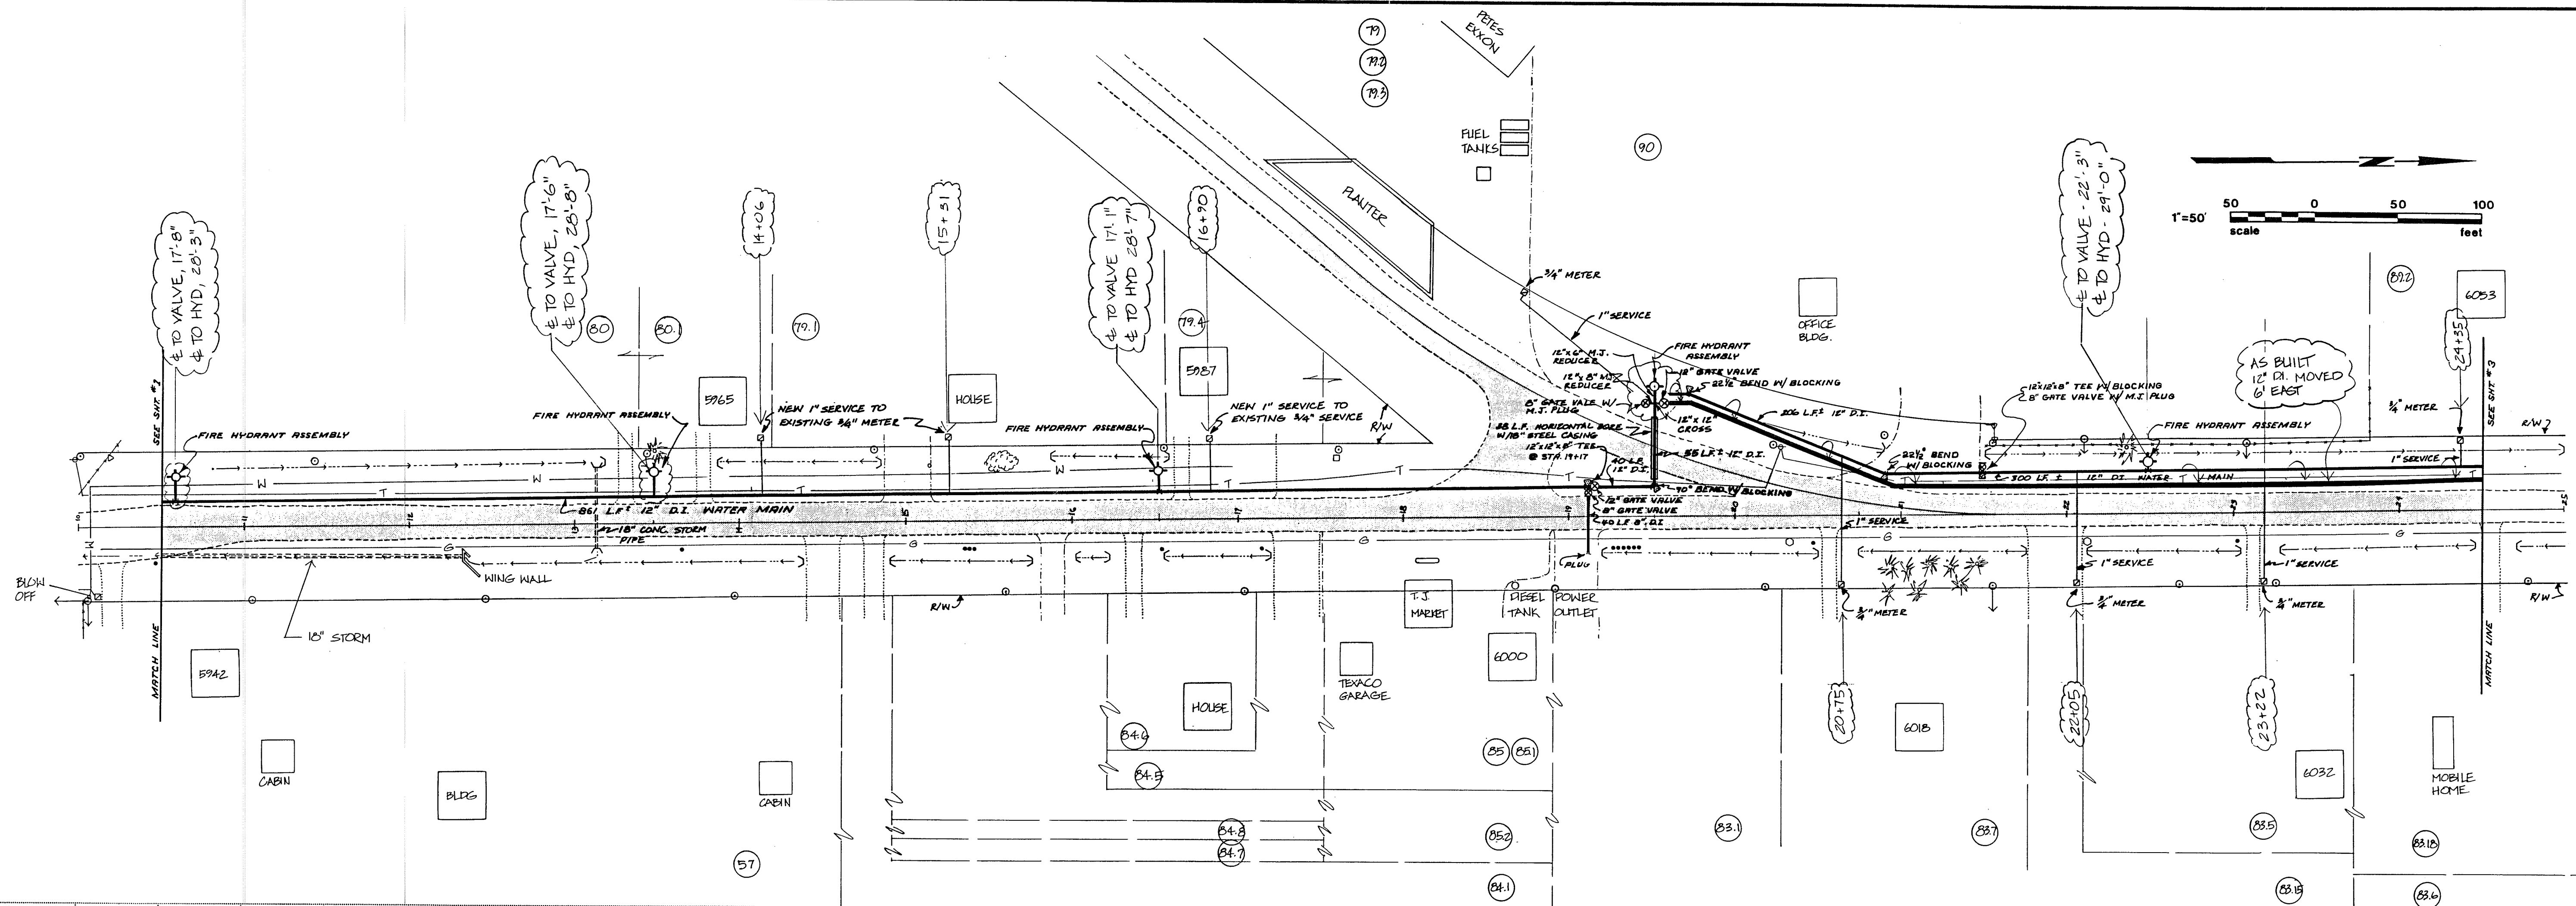



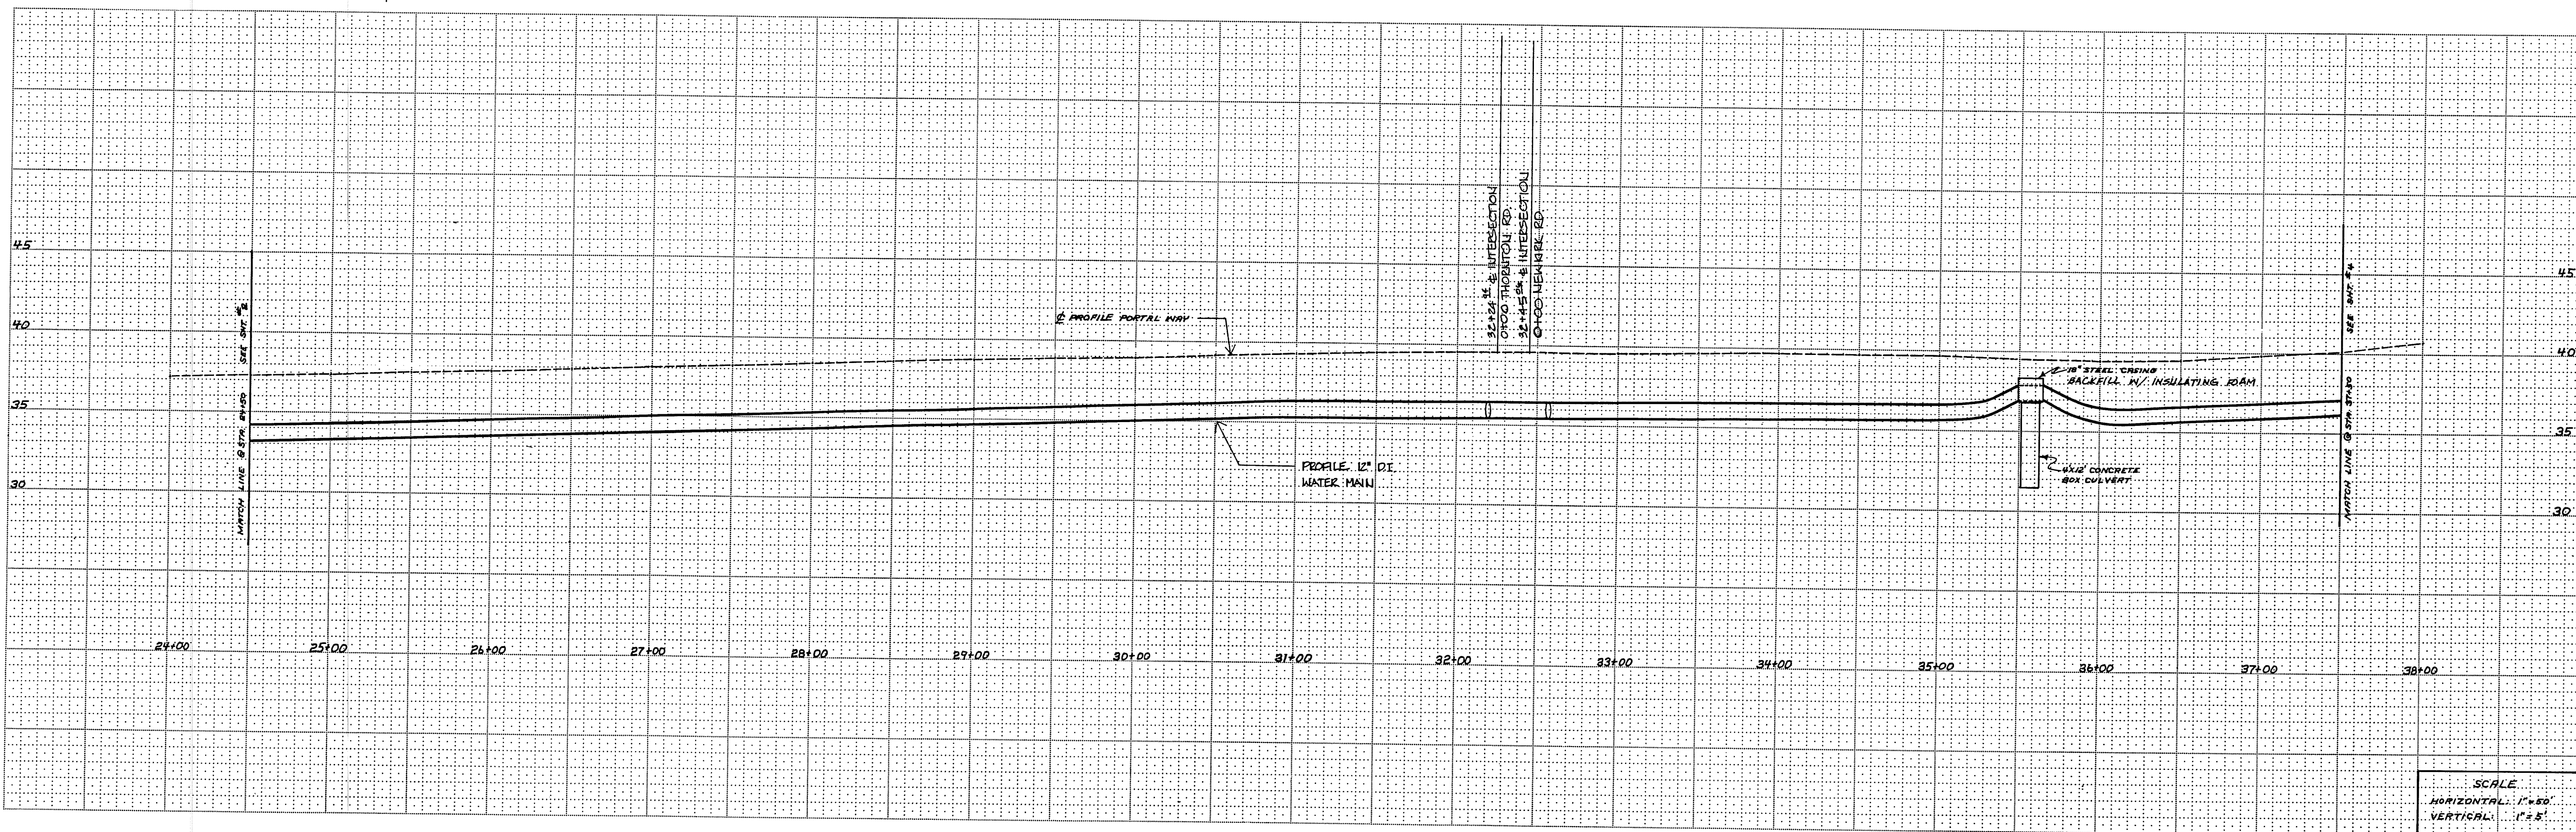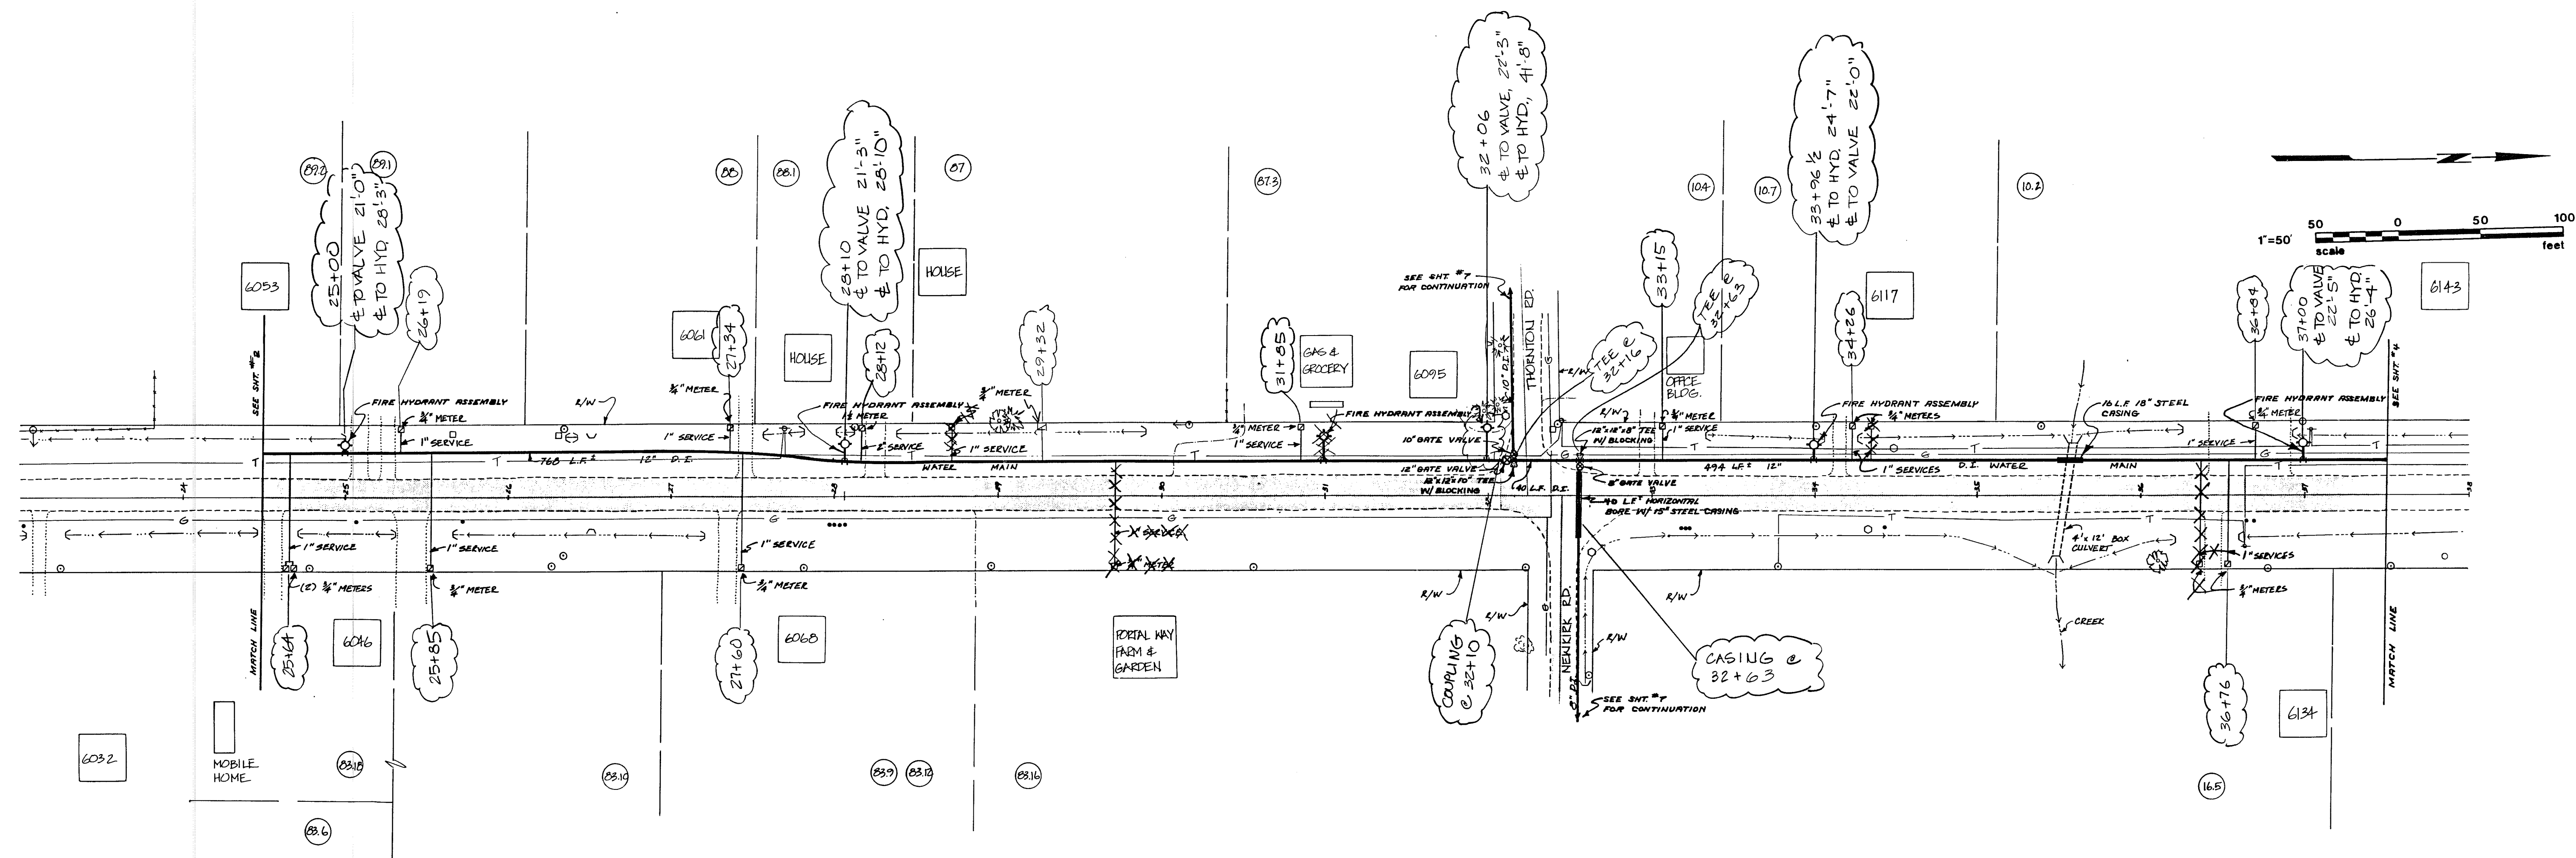

**NORTHWEST CONSULTANTS**  
 CIVIL & STRUCTURAL ENGINEERING  
 1401 ASTOR, BELLINGHAM, WA. 12061676-9058

**CITY OF FERDALE**  
 P.O. BOX 936  
 FERDALE, WA. 98248 PH. 384-4302

SCALE: AS SHOWN  
 DATE: 2-18-20  
 DRAWN BY: BEN & EF  
 CHECKED BY: EF  
 JOB NO.: 86-1431

REVISIONS  
 MARK DESCRIPTION DATE BY

**PORTAL WAY IMPROVEMENTS**

**WATER DISTRIBUTION SYSTEM**  
 PLAN AND PROFILE





SHEET  
 3  
 OF  
 10



JOB NUMBER: 86-1431

00457, 00 S 6019/12 CL



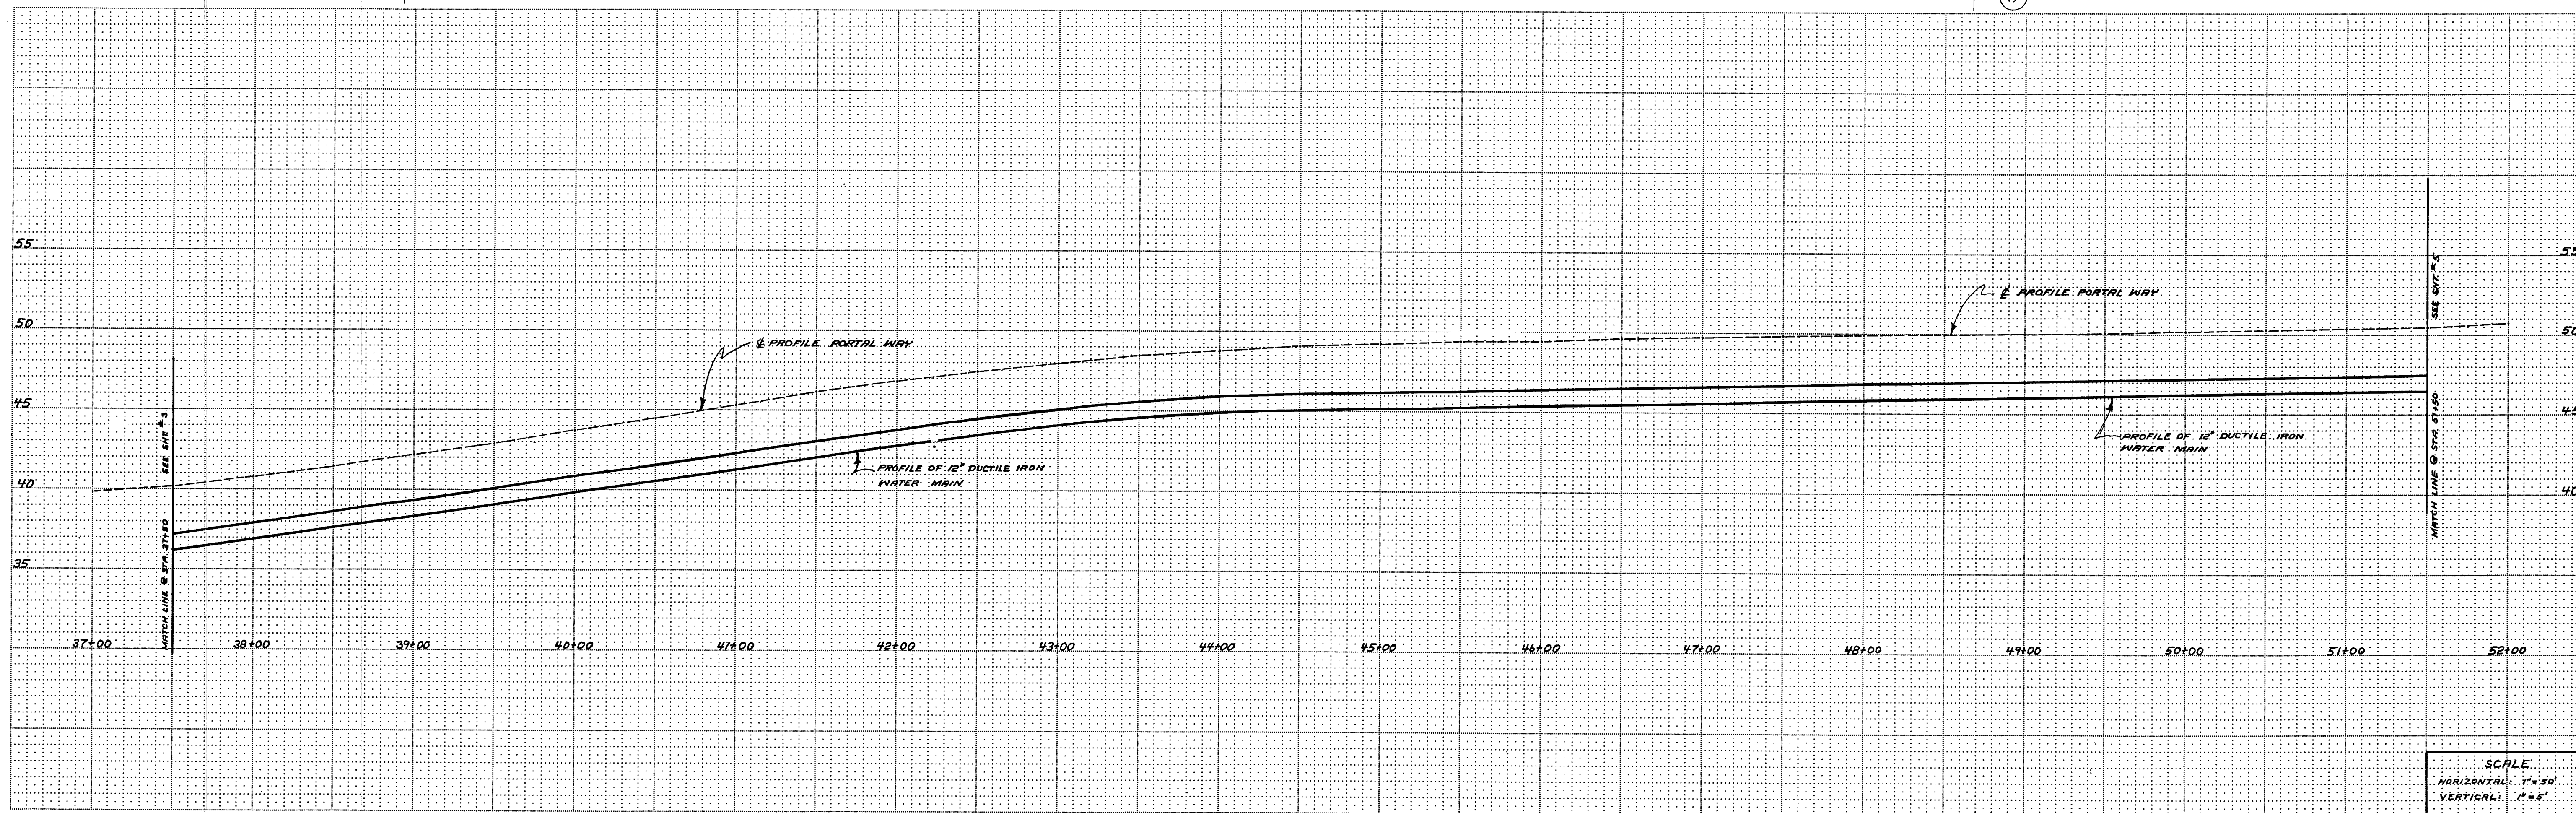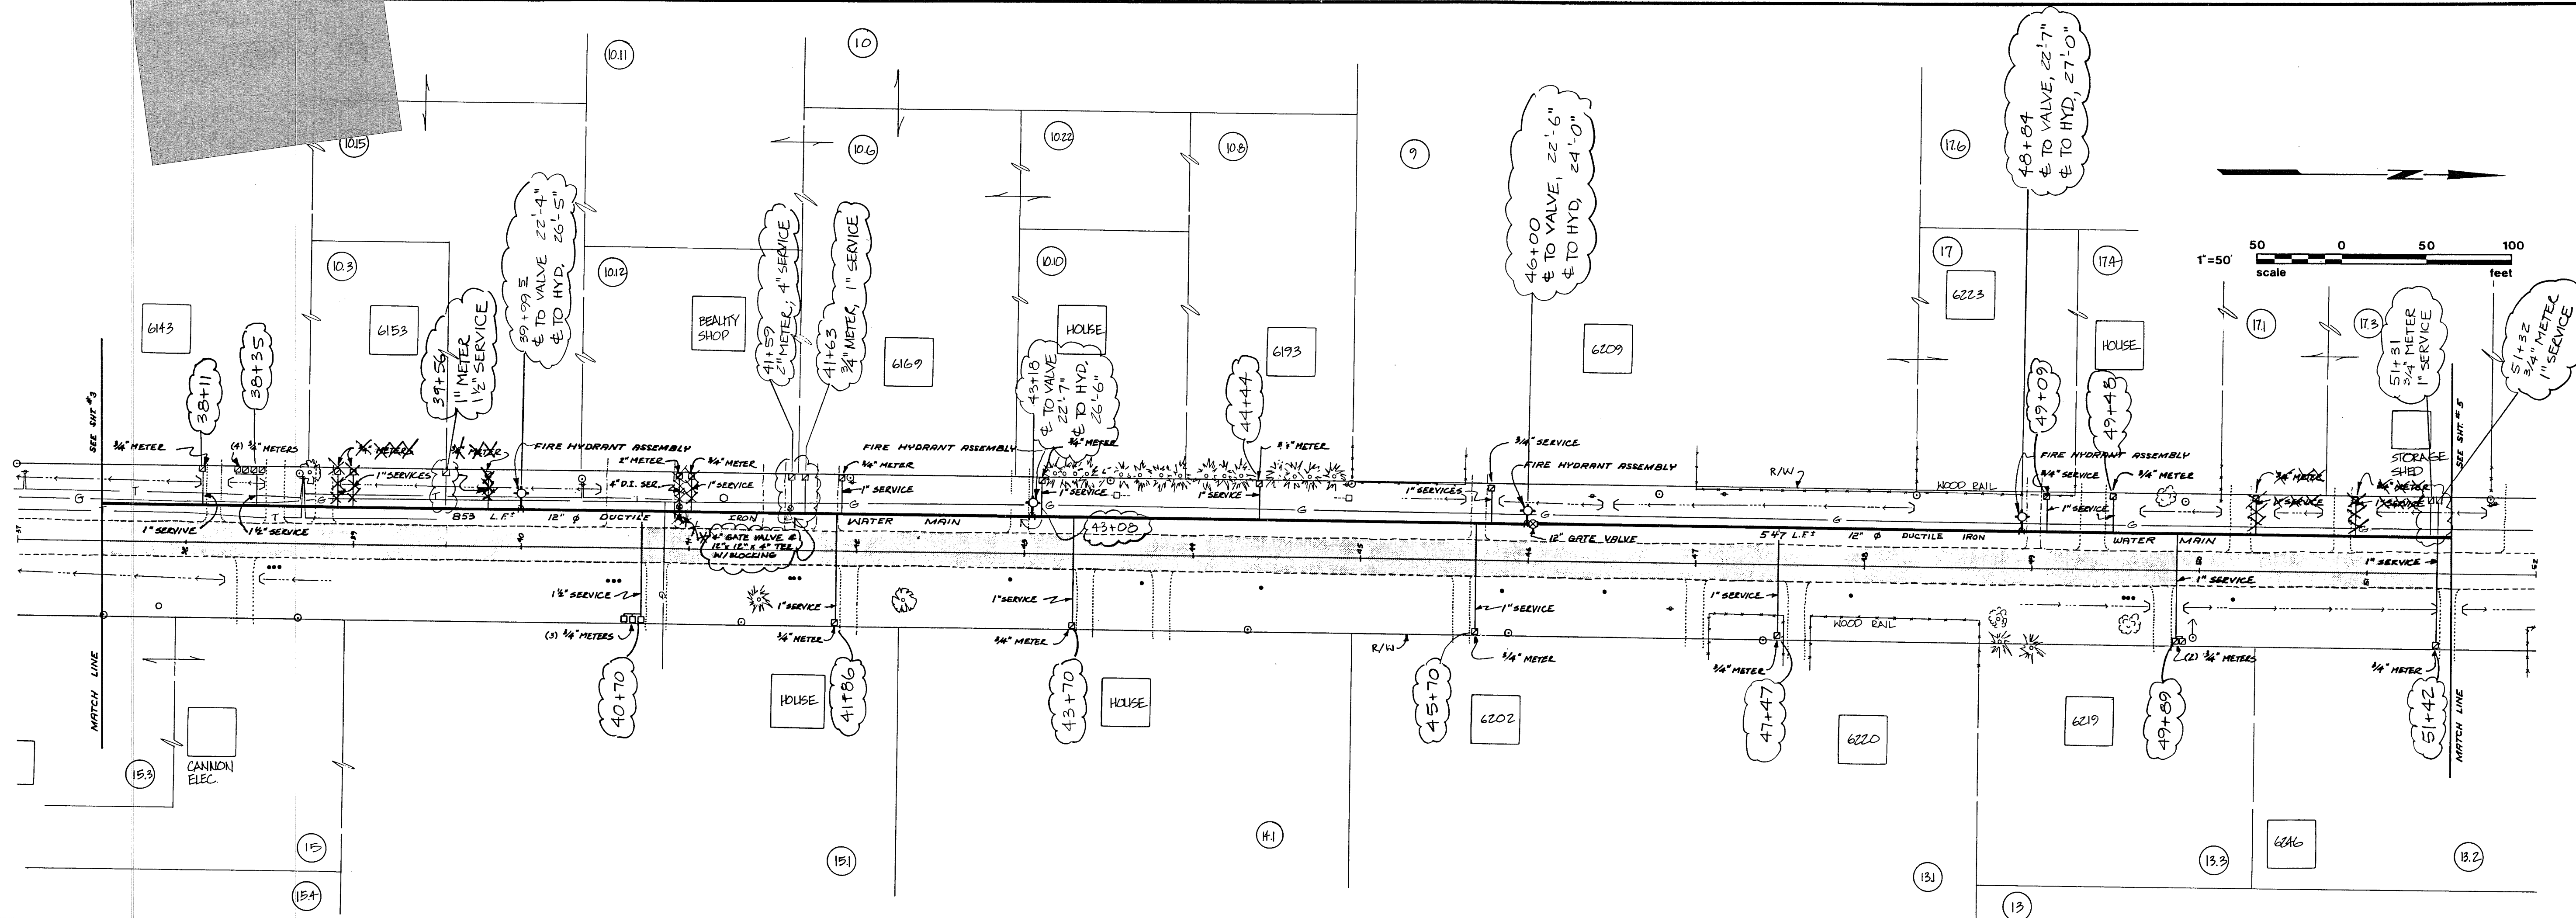



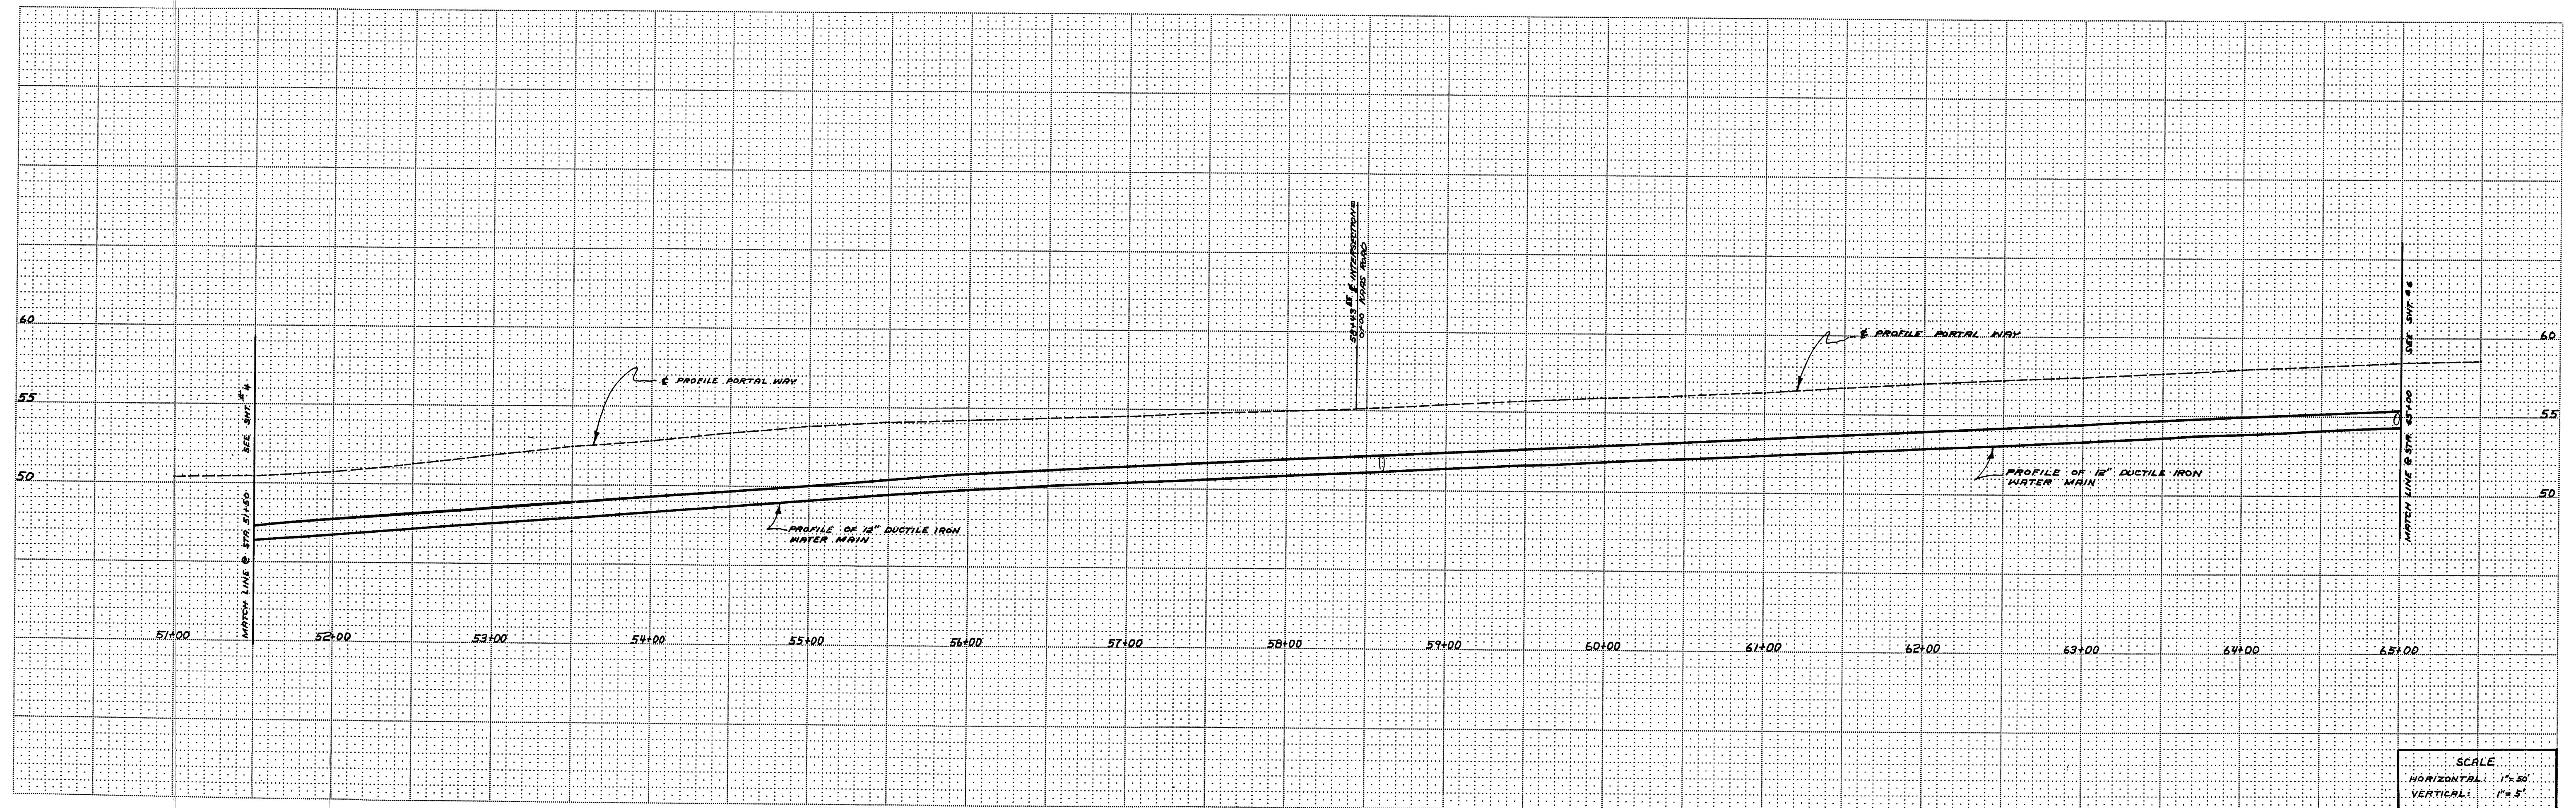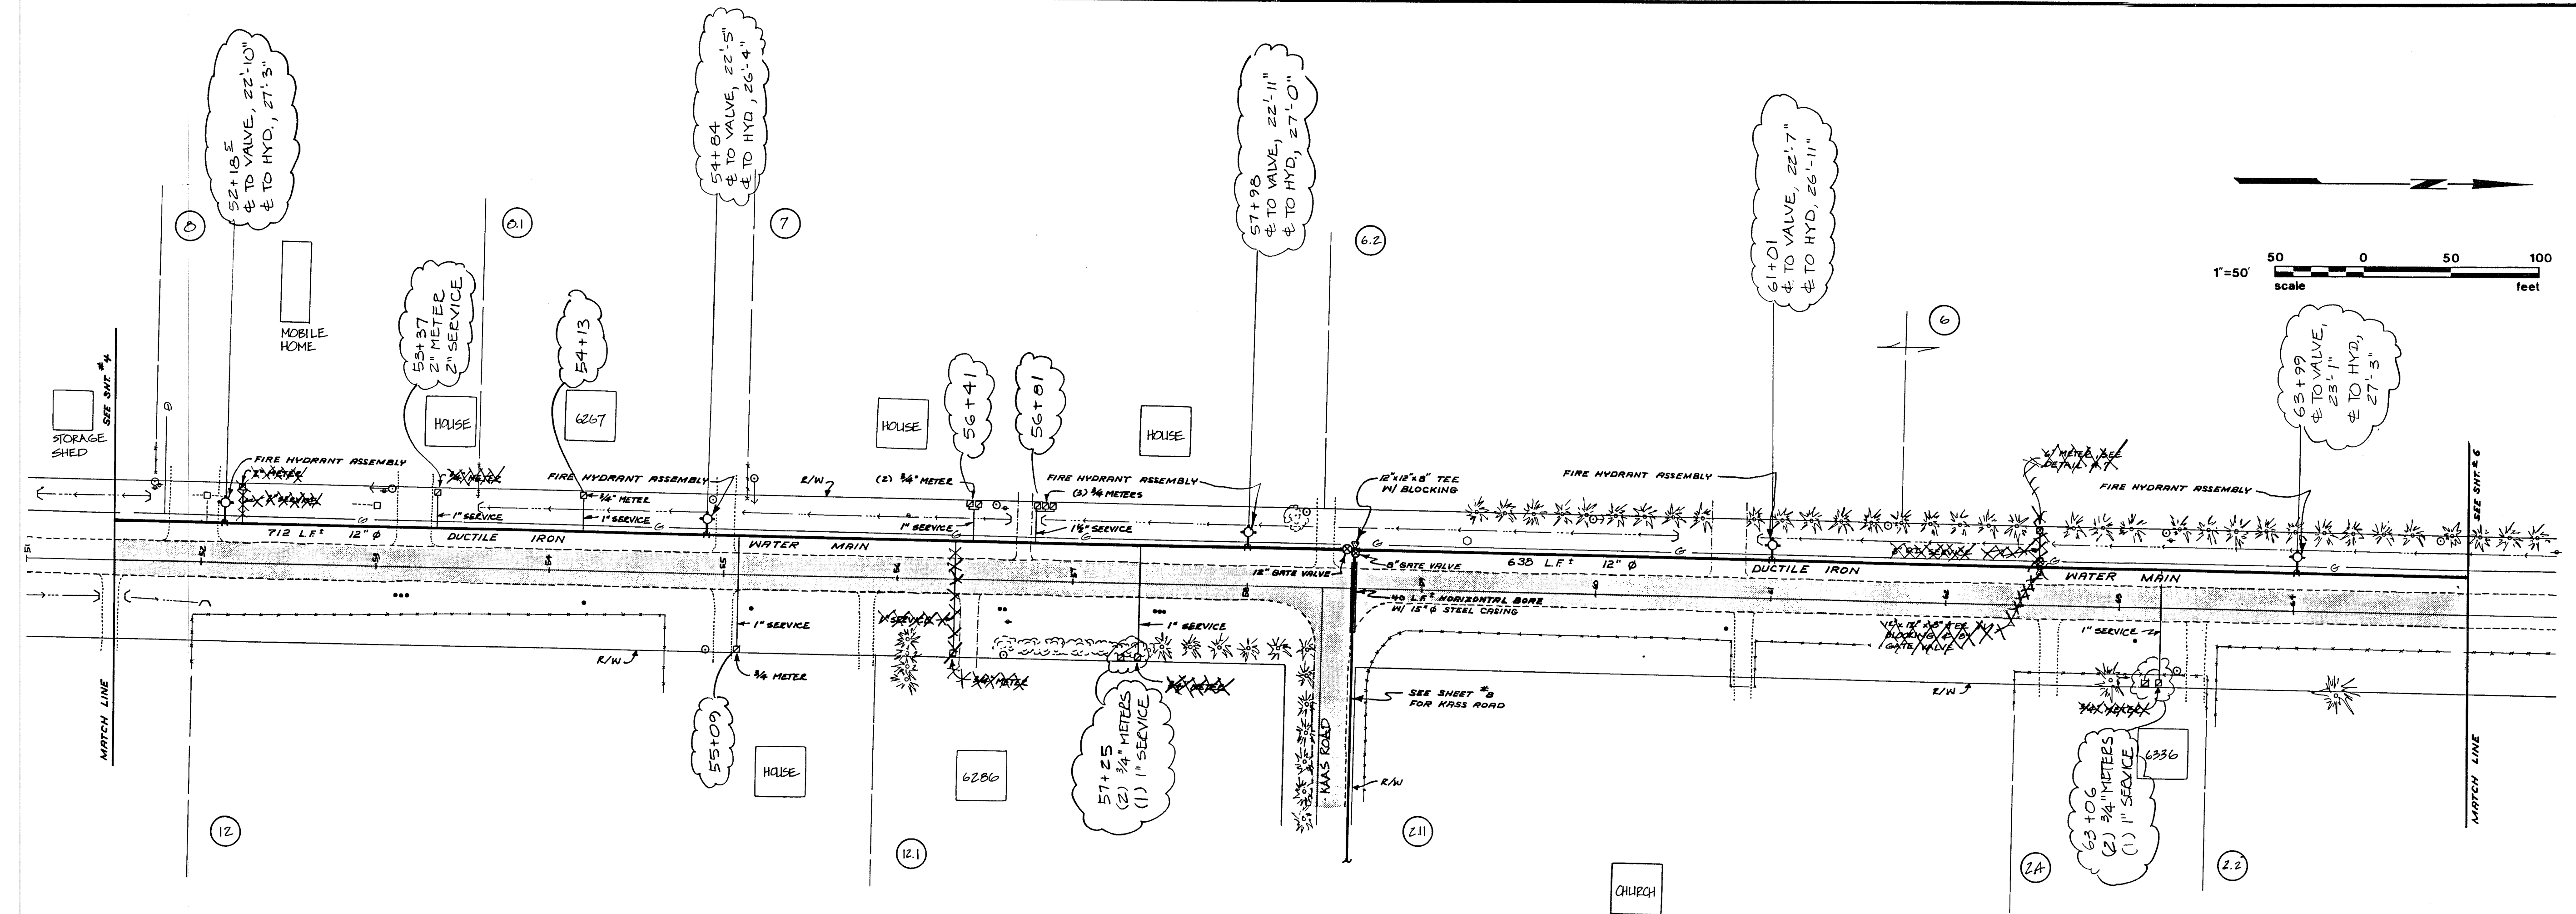

**NORTHWEST CONSULTANTS**  
 CIVIL & STRUCTURAL ENGINEERING  
 1401 ASTOR, BELLINGHAM, WA.  
 (206) 676-9058

**CITY OF FERDALE**  
 P.O. BOX 936  
 FERDALE WA, 98248 PH. 384-4302

SCALE: AS SHOWN  
 DATE: 3-10-86  
 DRAWN BY: EFN & EF  
 CHECKED BY: EF  
 JOB NO.: 85-1431

REVISIONS  
 MARK DESCRIPTION DATE BY  
 DELETE CONNECT TO 65+00 3-10-86  
 6\"/>

**PORTAL WAY IMPROVEMENTS**

**WATER DISTRIBUTION SYSTEM  
 PLAN AND PROFILE**






SHEET  
 5  
 OF  
 10

00457.007 CL 6/19/12







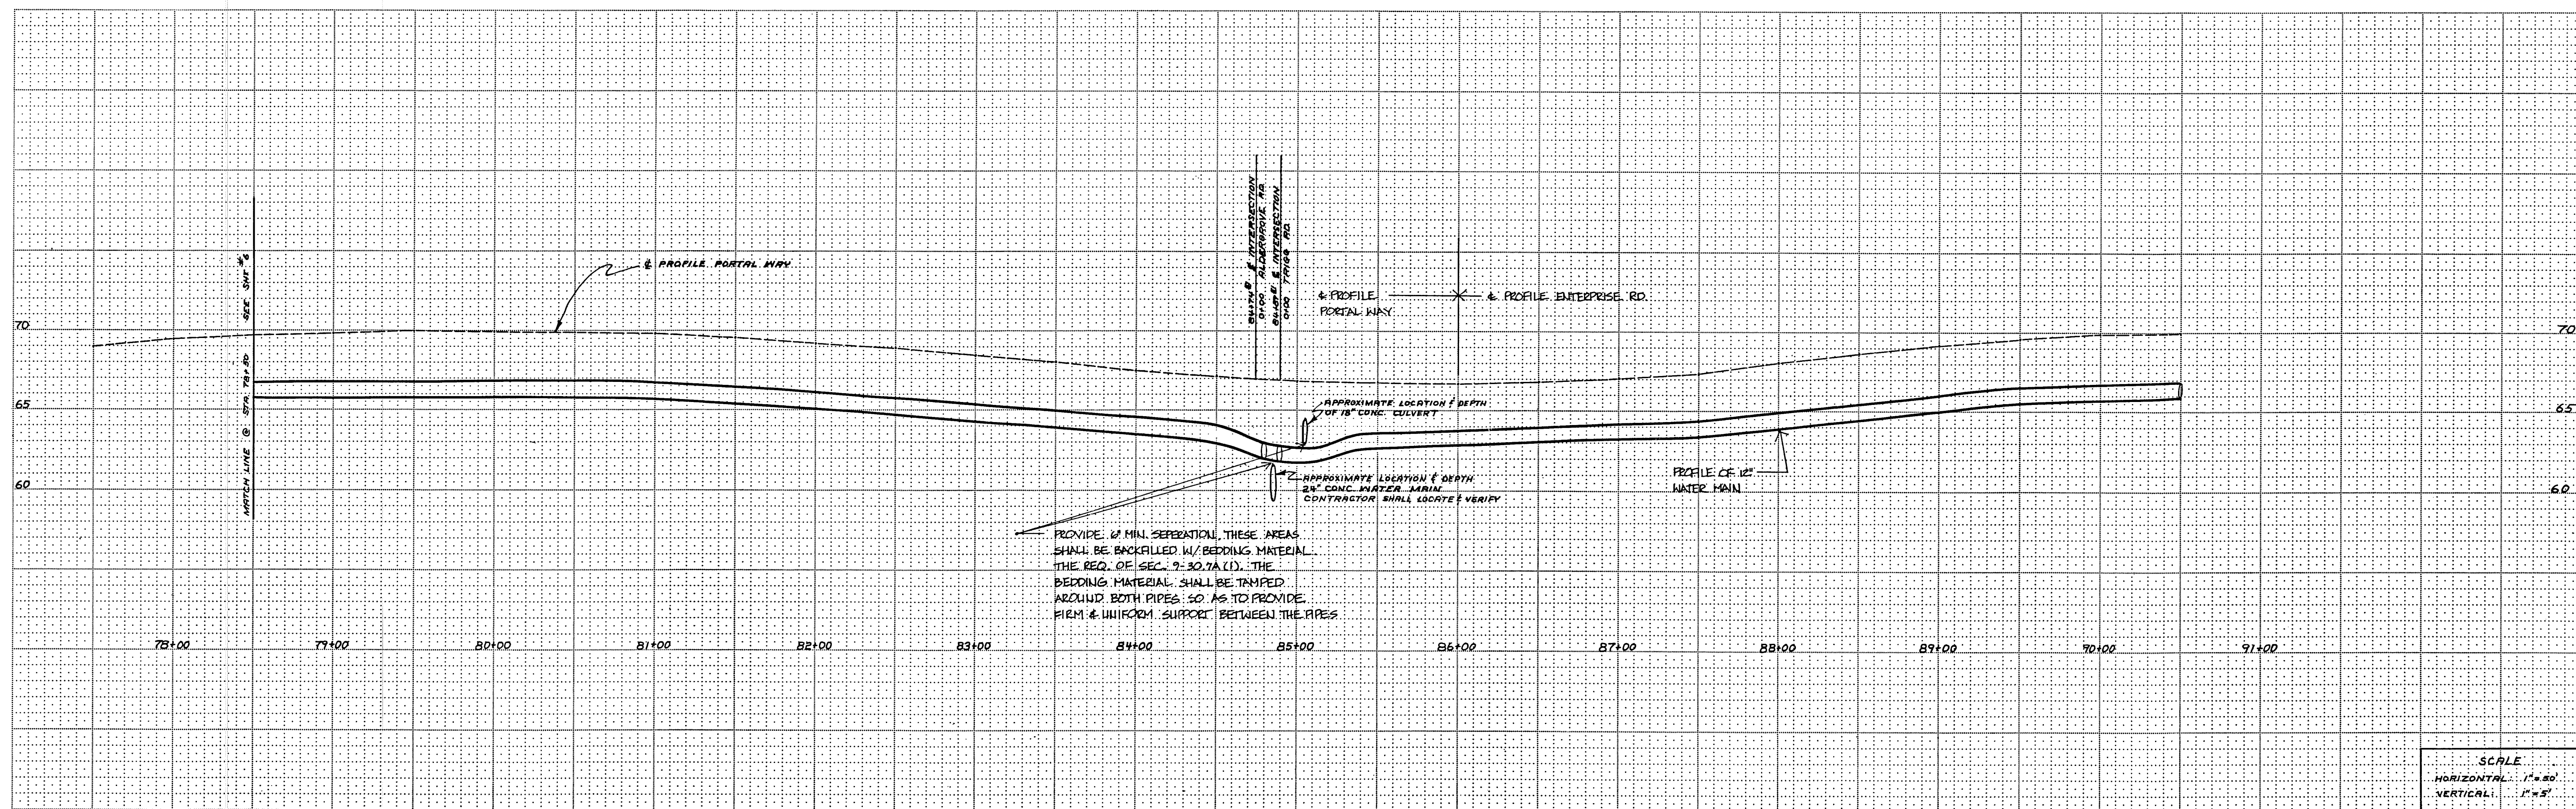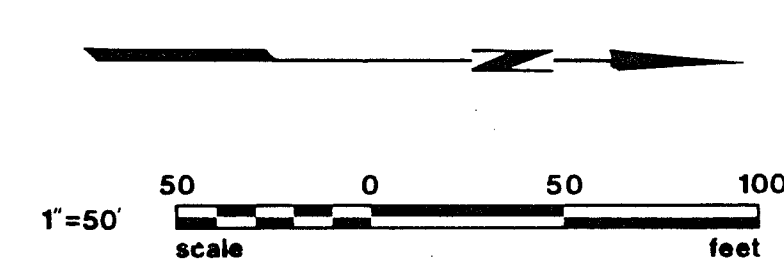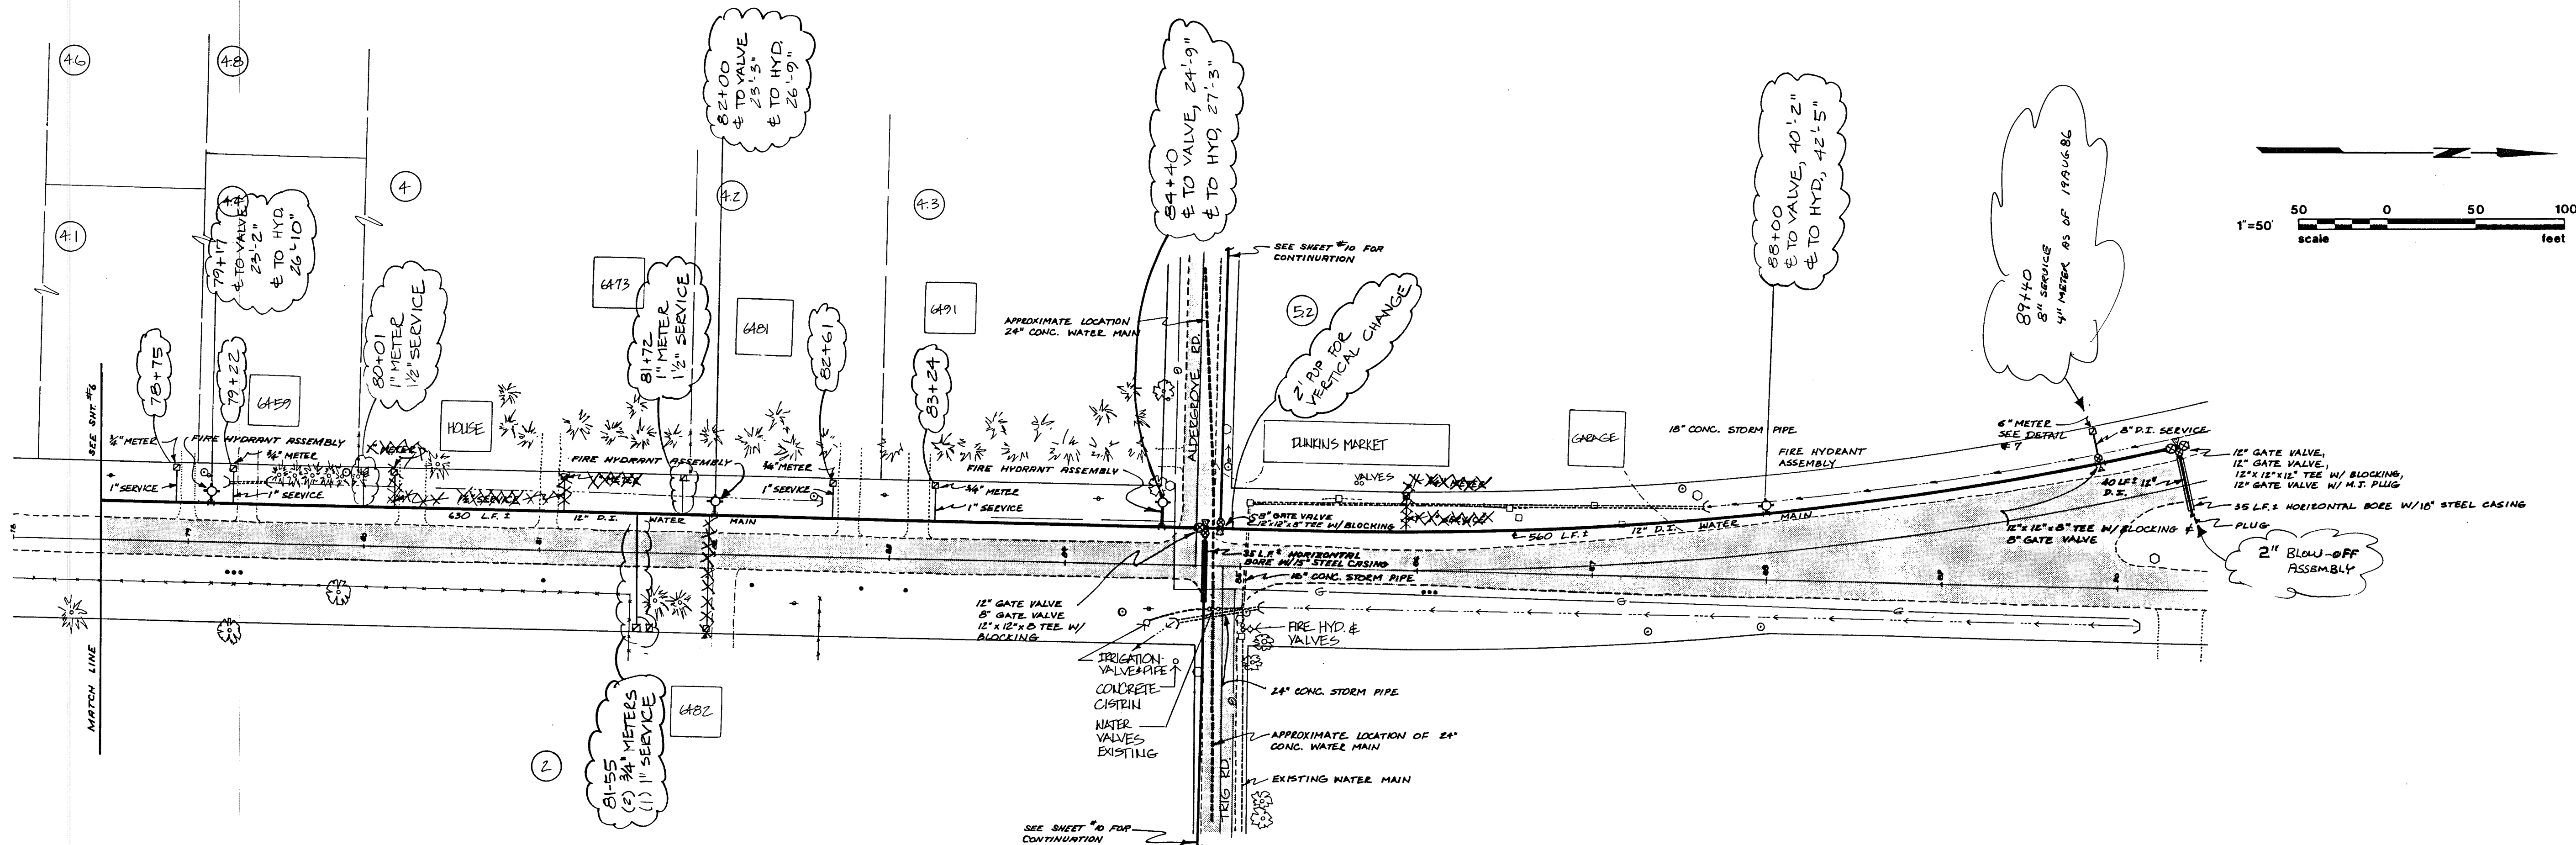

SCALE  
HORIZONTAL: 1"=50'  
VERTICAL: 1"=5'



