


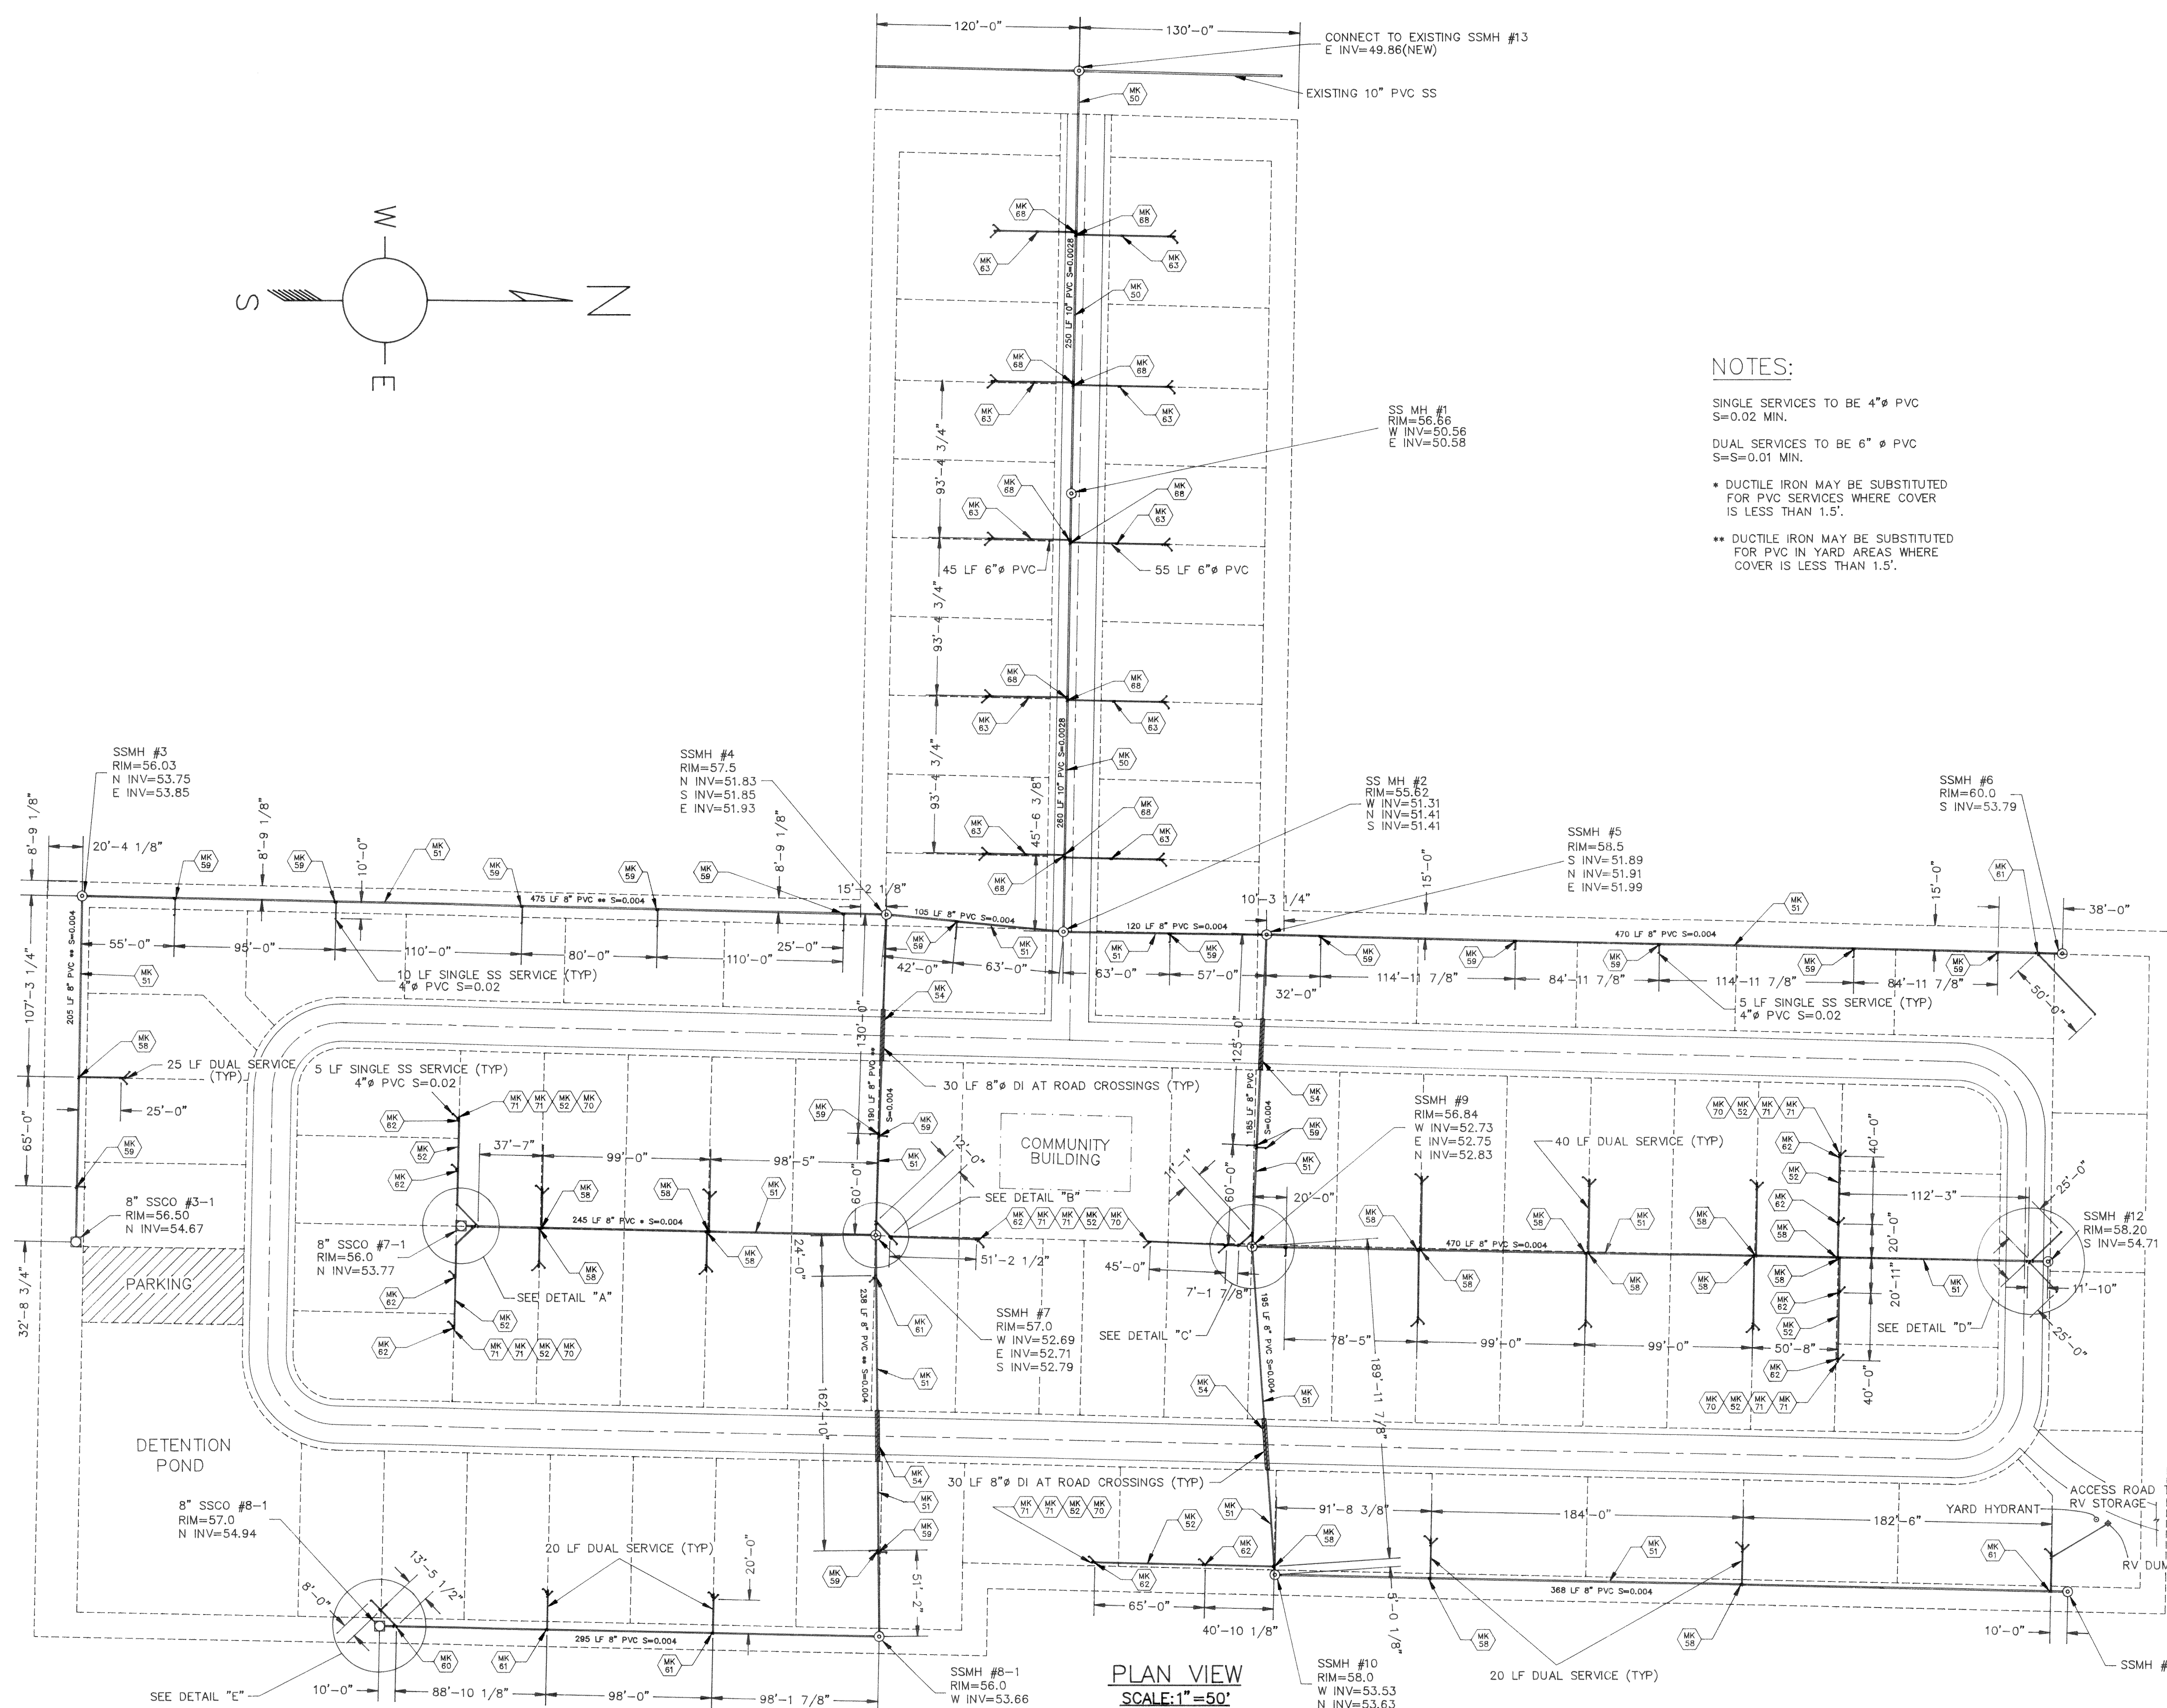



 
SINGLE SERVICES TO BE 4" Ø PVC
S=0.02 MIN.

DUAL SERVICES TO BE 6" Ø PVC
S=0.01 MIN.



* DUCTILE IRON MAY BE SUBSTITUTED
FOR PVC SERVICES WHERE COVER
IS LESS THAN 1.5'.

** DUCTILE IRON MAY BE SUBSTITUTED
FOR PVC IN YARD AREAS WHERE
COVER IS LESS THAN 1.5'.

00157.001	2.2.06	XR
-----------	--------	----

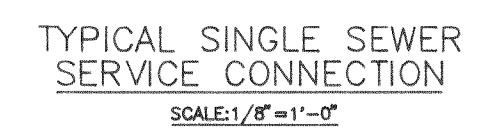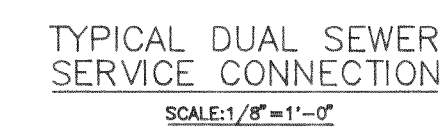[illegible]

200.100 77.77

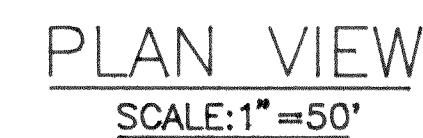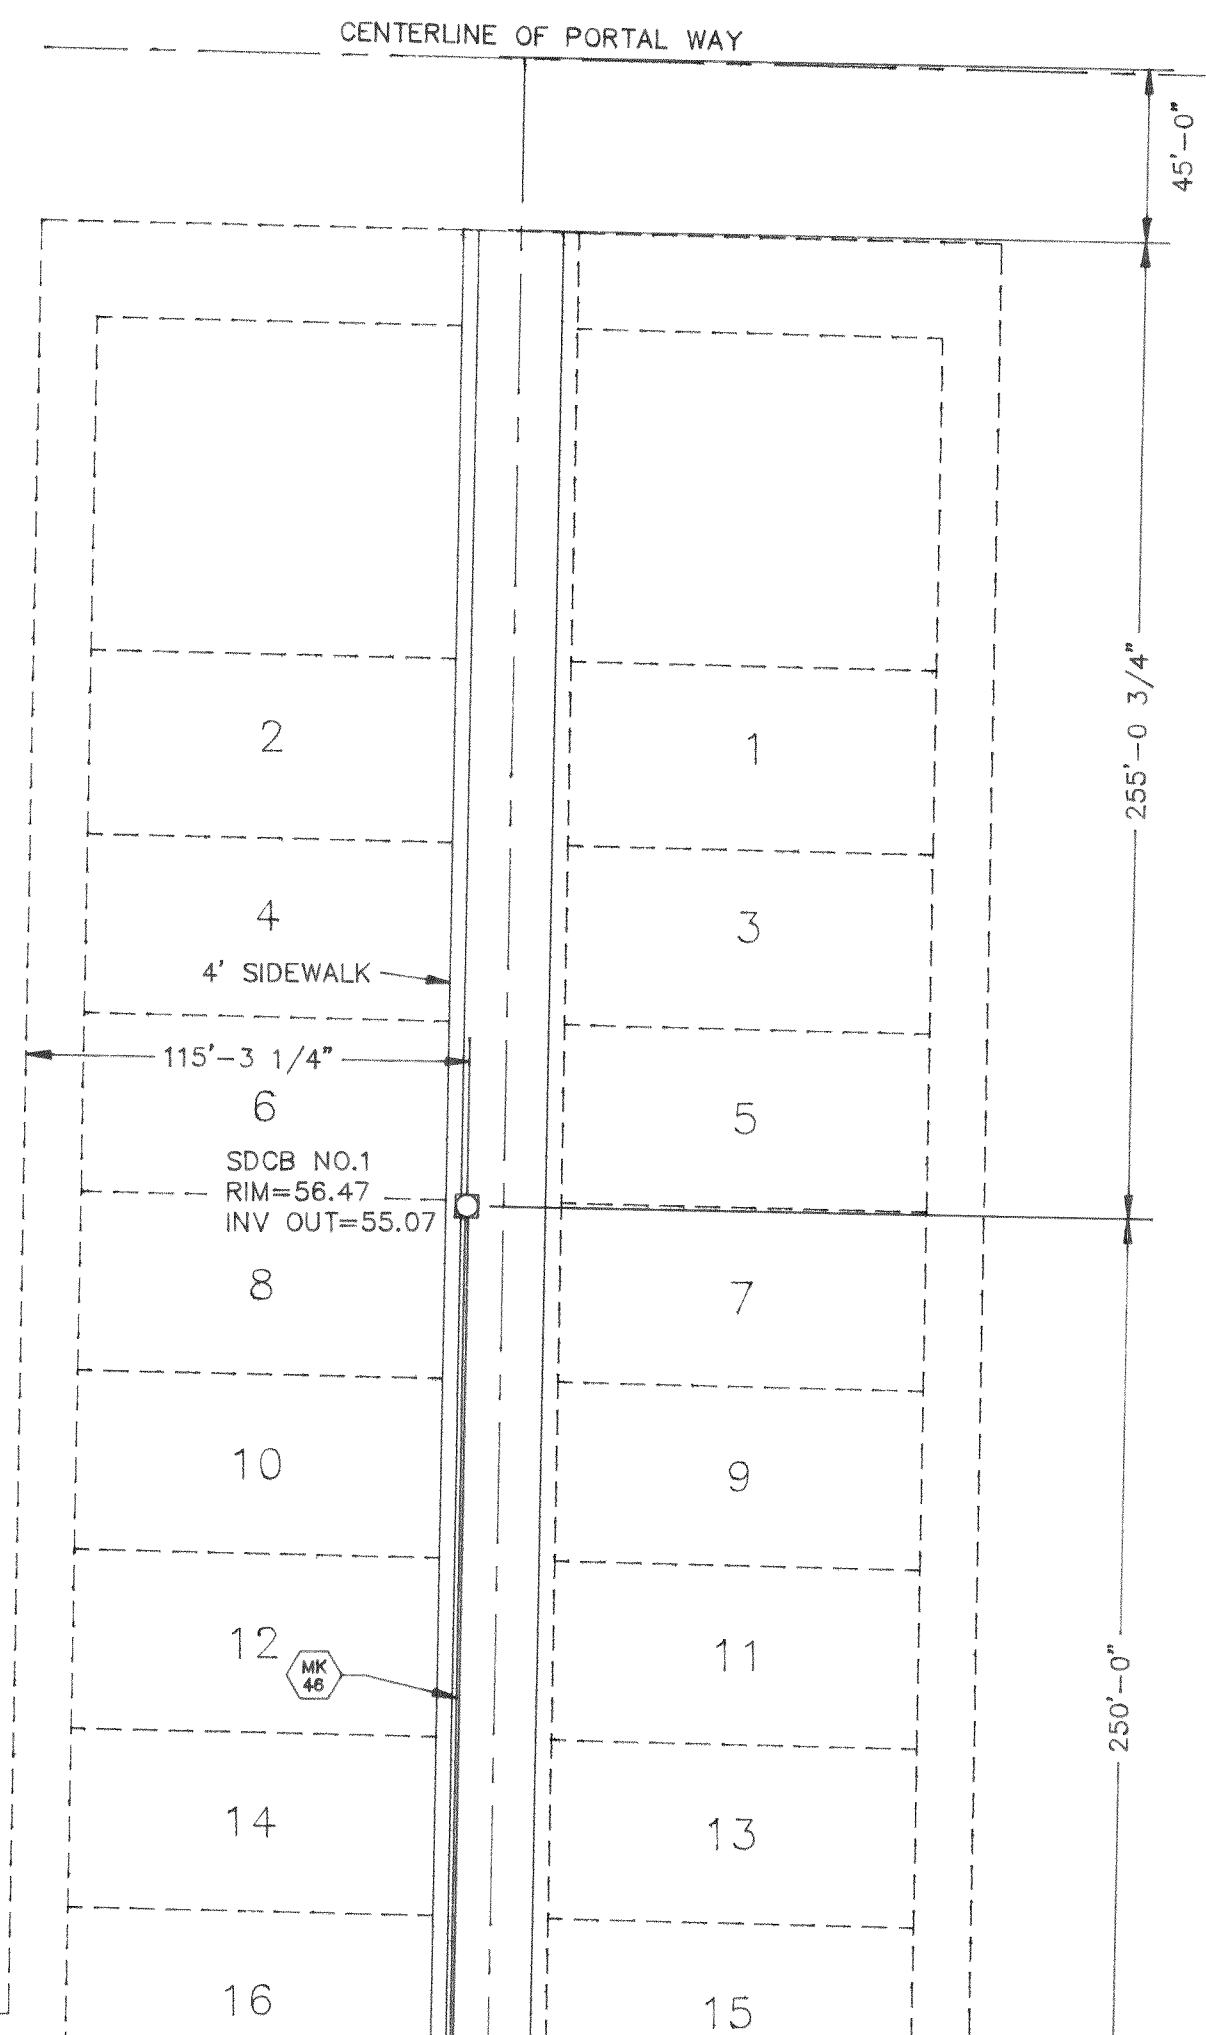

49	24" ABS COUPLING			1			
48	24" ADS FLOW RESTRICTOR			1			
47	24" GSKD P.V.C. SMR PIPE 13L			240'	14'		
46	8" GSKD P.V.C. SMR PIPE 13L			2300'	20'		
BID ITEM	MARK NO.	DESCRIPTION			1/2" EACH	QUANTITIES	EXTRA SUPPLIER P.O. NO.
BILL OF MATERIALS							
				1	ADDED LOT NUMBERS ADDED RV STORAGE, ACCESS ROAD, & CHANGED MH RM ELEVATIONS	L.W.	11/14/95
				REV.	DESCRIPTION	INITIAL	DATE
							
				PORTAL CREEK PARK			
				STORM DRAIN PLAN			
4010-S				2	1	SITE PLAN	
DRAWING NO.	REV. NO.	SHEET NO.	DESCRIPTION				
REFERENCE DRAWINGS							
DRAWN: L.W.				DATE: 11-14-94		CHECKED:	
DWG. NO.: 1403-2665-B				P-3R1			

11-15-13