
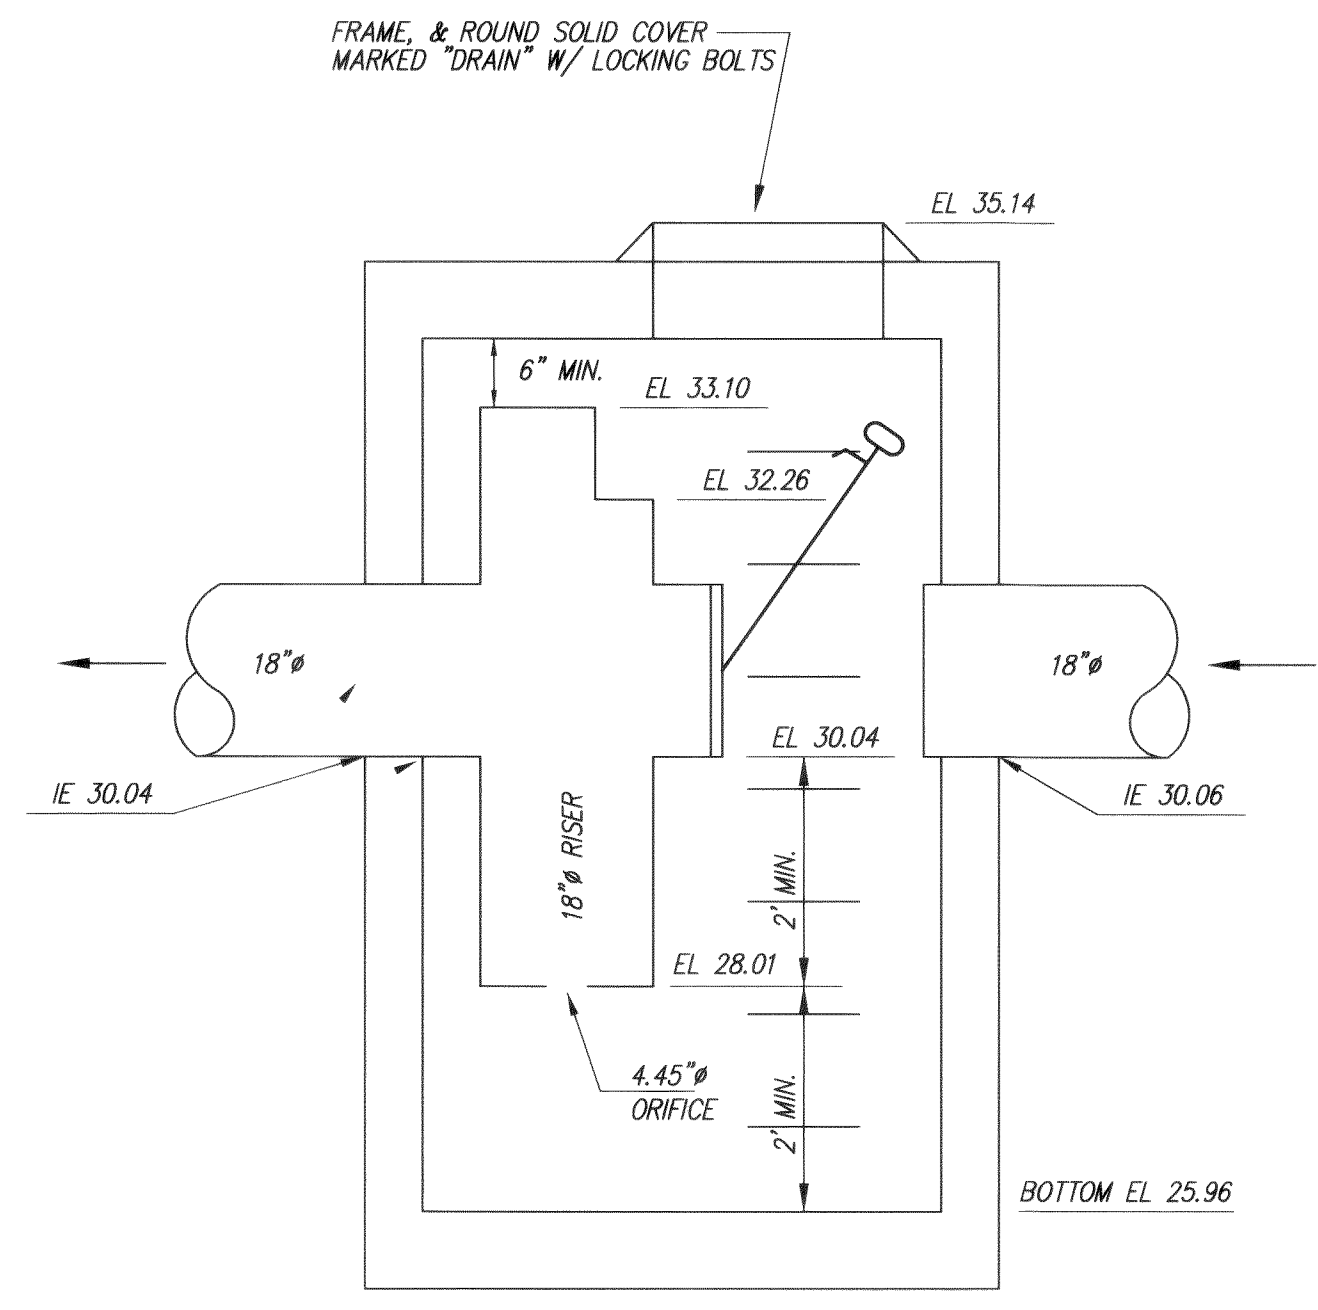
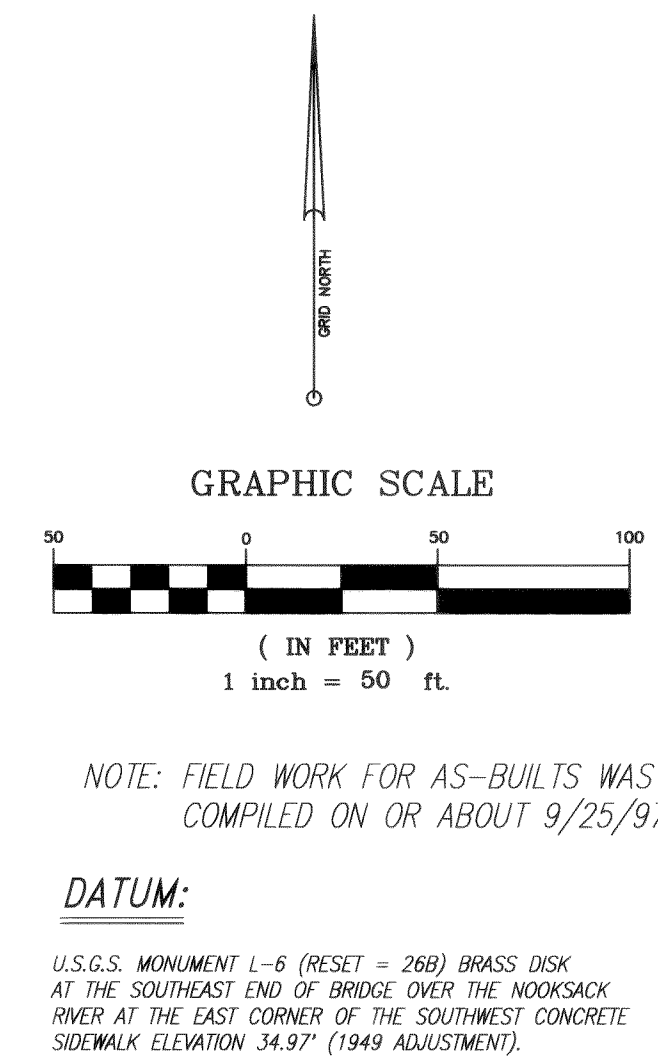


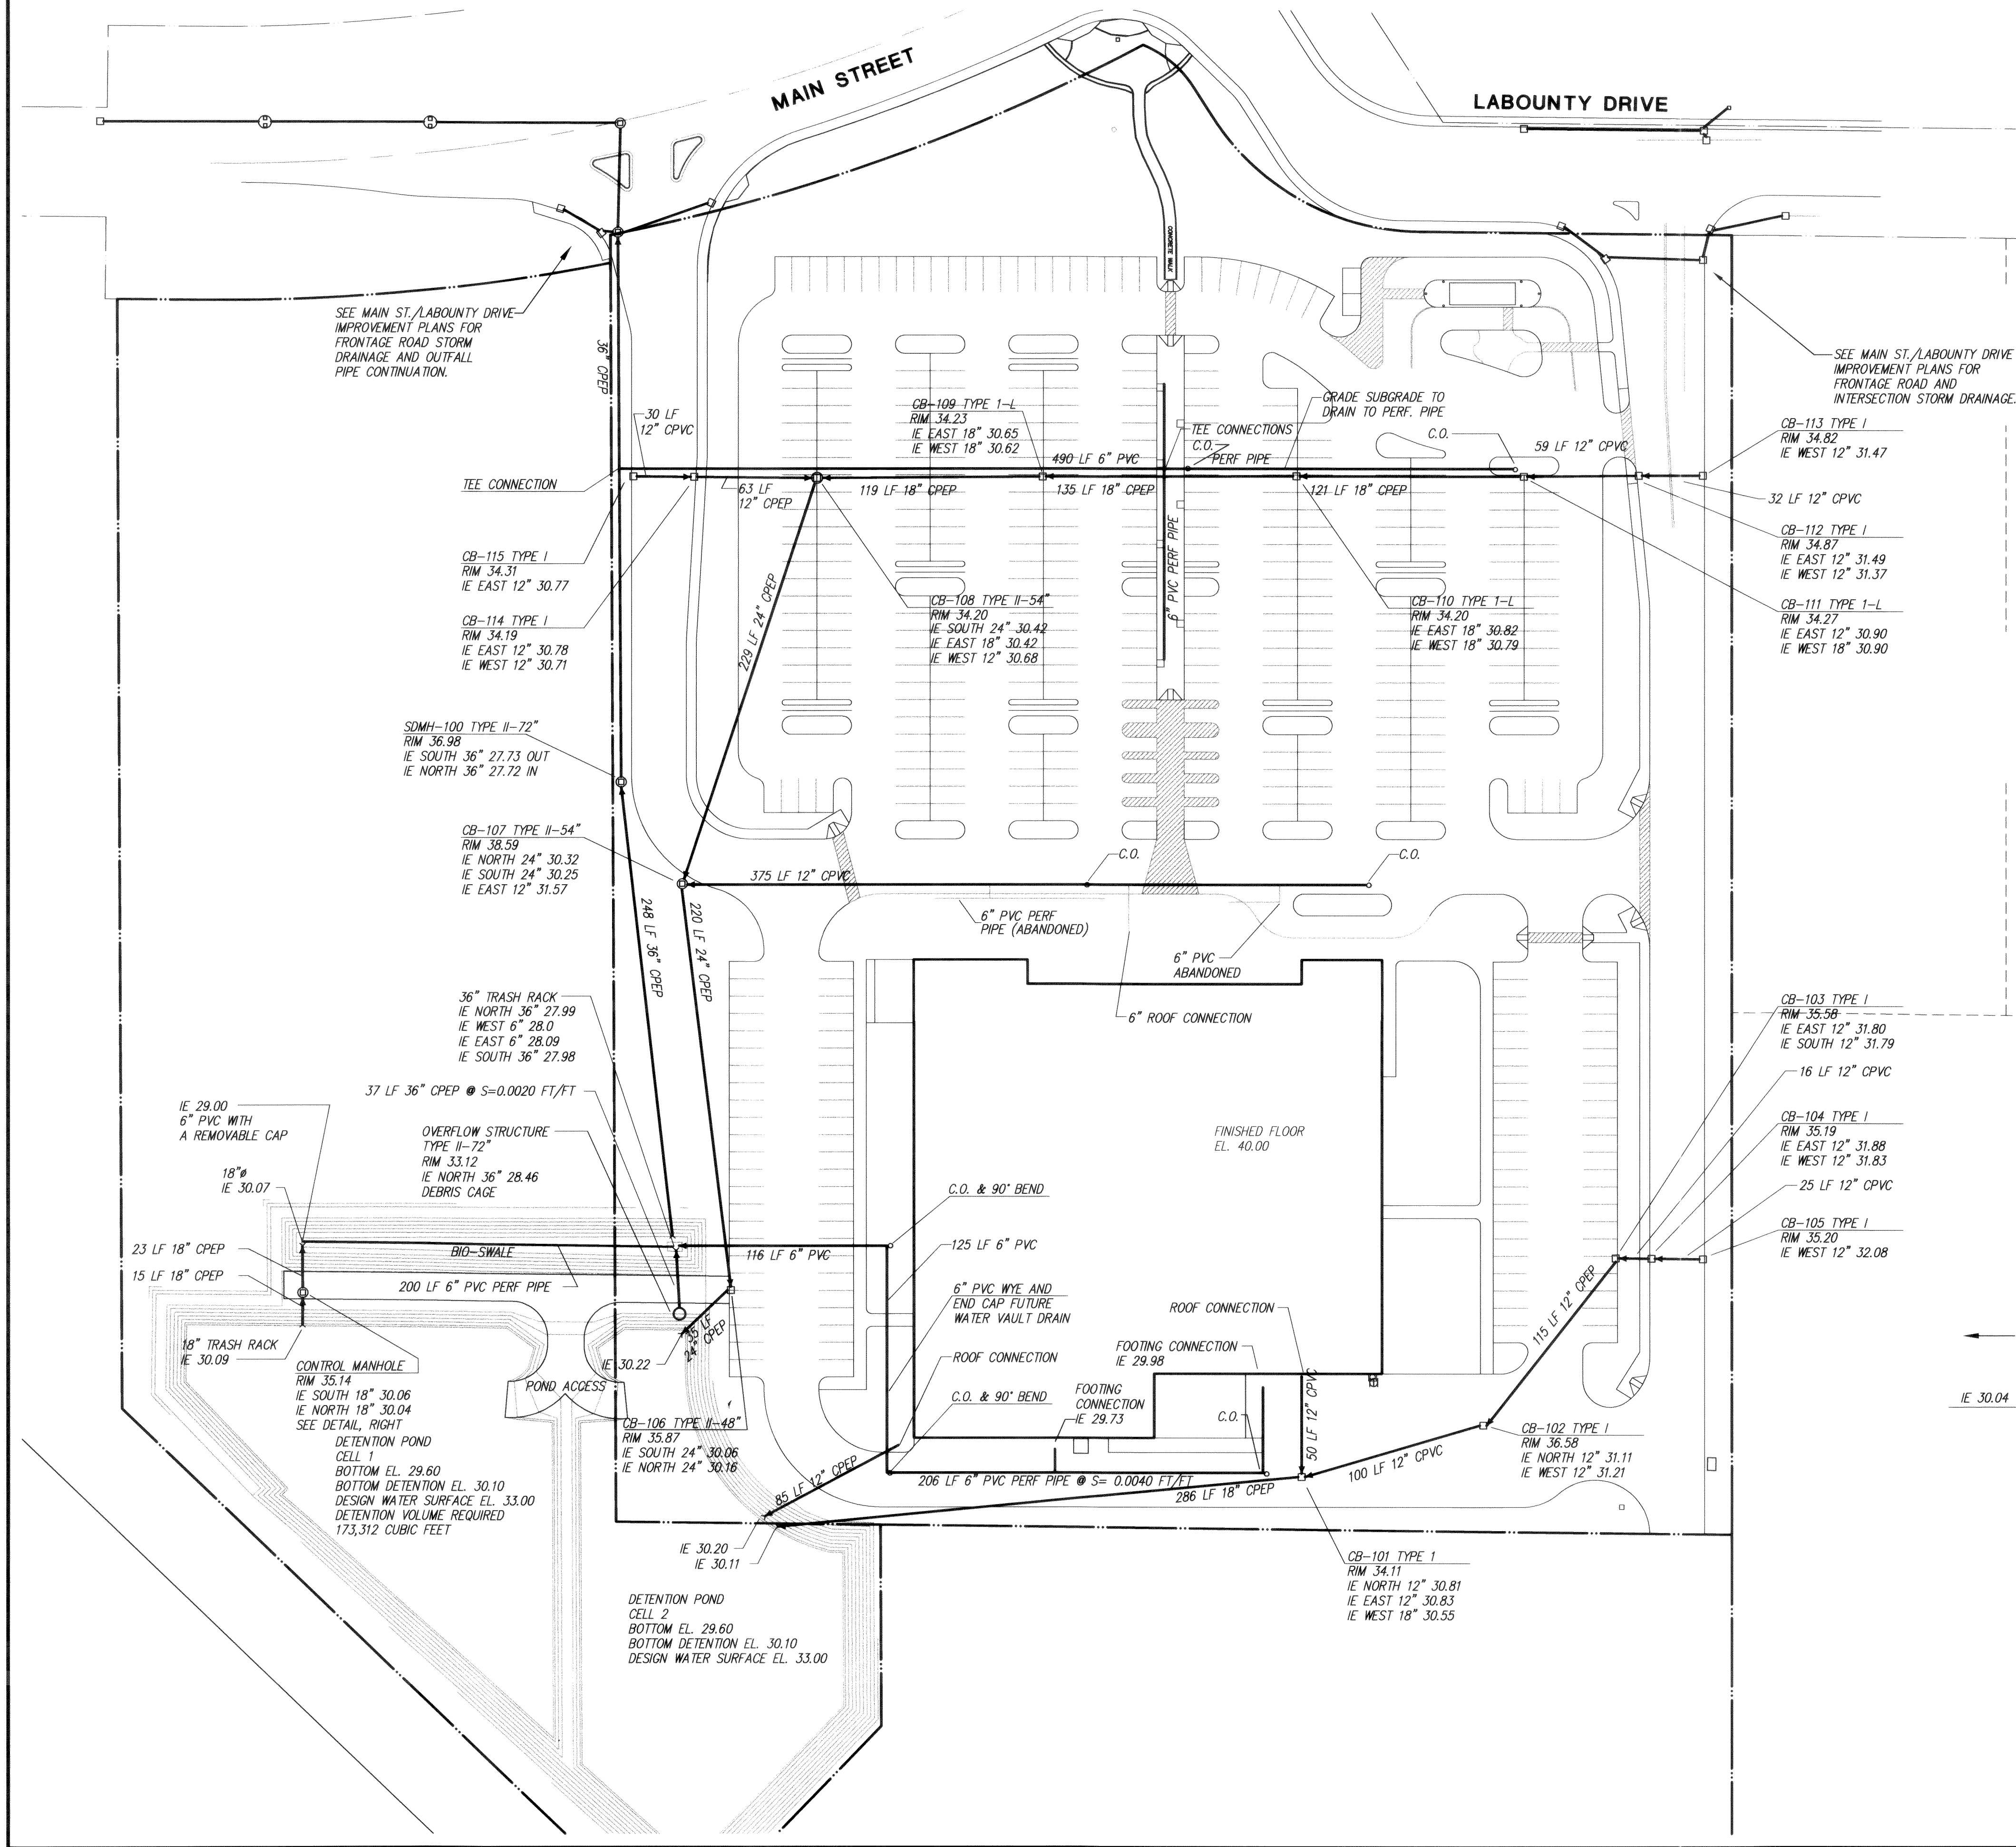

SECTION

CONTROL STRUCTURE RECORD DETAIL

SCALE: NONE

Northwest Engineering Company
12828 Northrup Way, Suite 310
Bellevue, Washington 98006-867-9800

FERDIE E. HALLIS
REGISTERED PROFESSIONAL ENGINEER
EXPIRES DEC 15, 1997

BRIAR DEVELOPMENT COMPANY
HAGGEN FOOD AND PHARMACY
STORM DRAINAGE PLAN
RECORD DRAWINGS



WASHINGTON
FERDALE

DESIGNED: WSP/LMR
DRAWN: TRT/KJG
CHECKED: REW
REVISED:

DRAWING NO: S106A801.DWG

918-05

SHEET
1 / 3

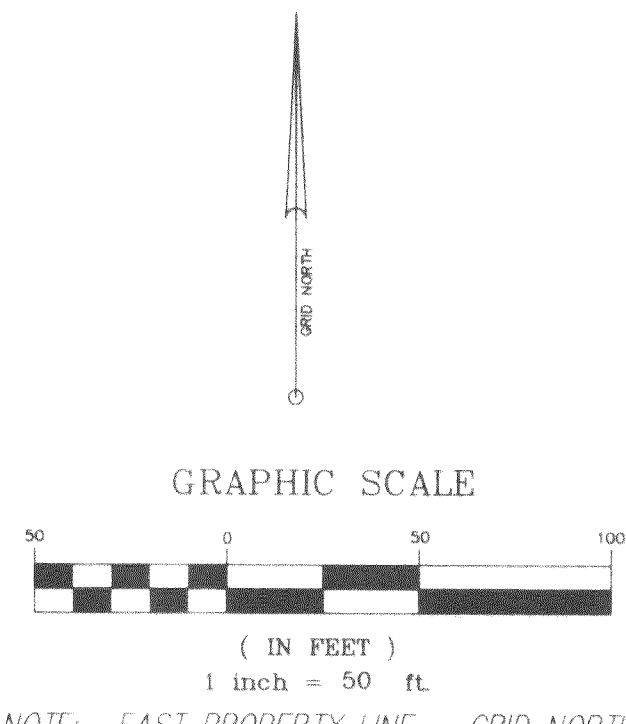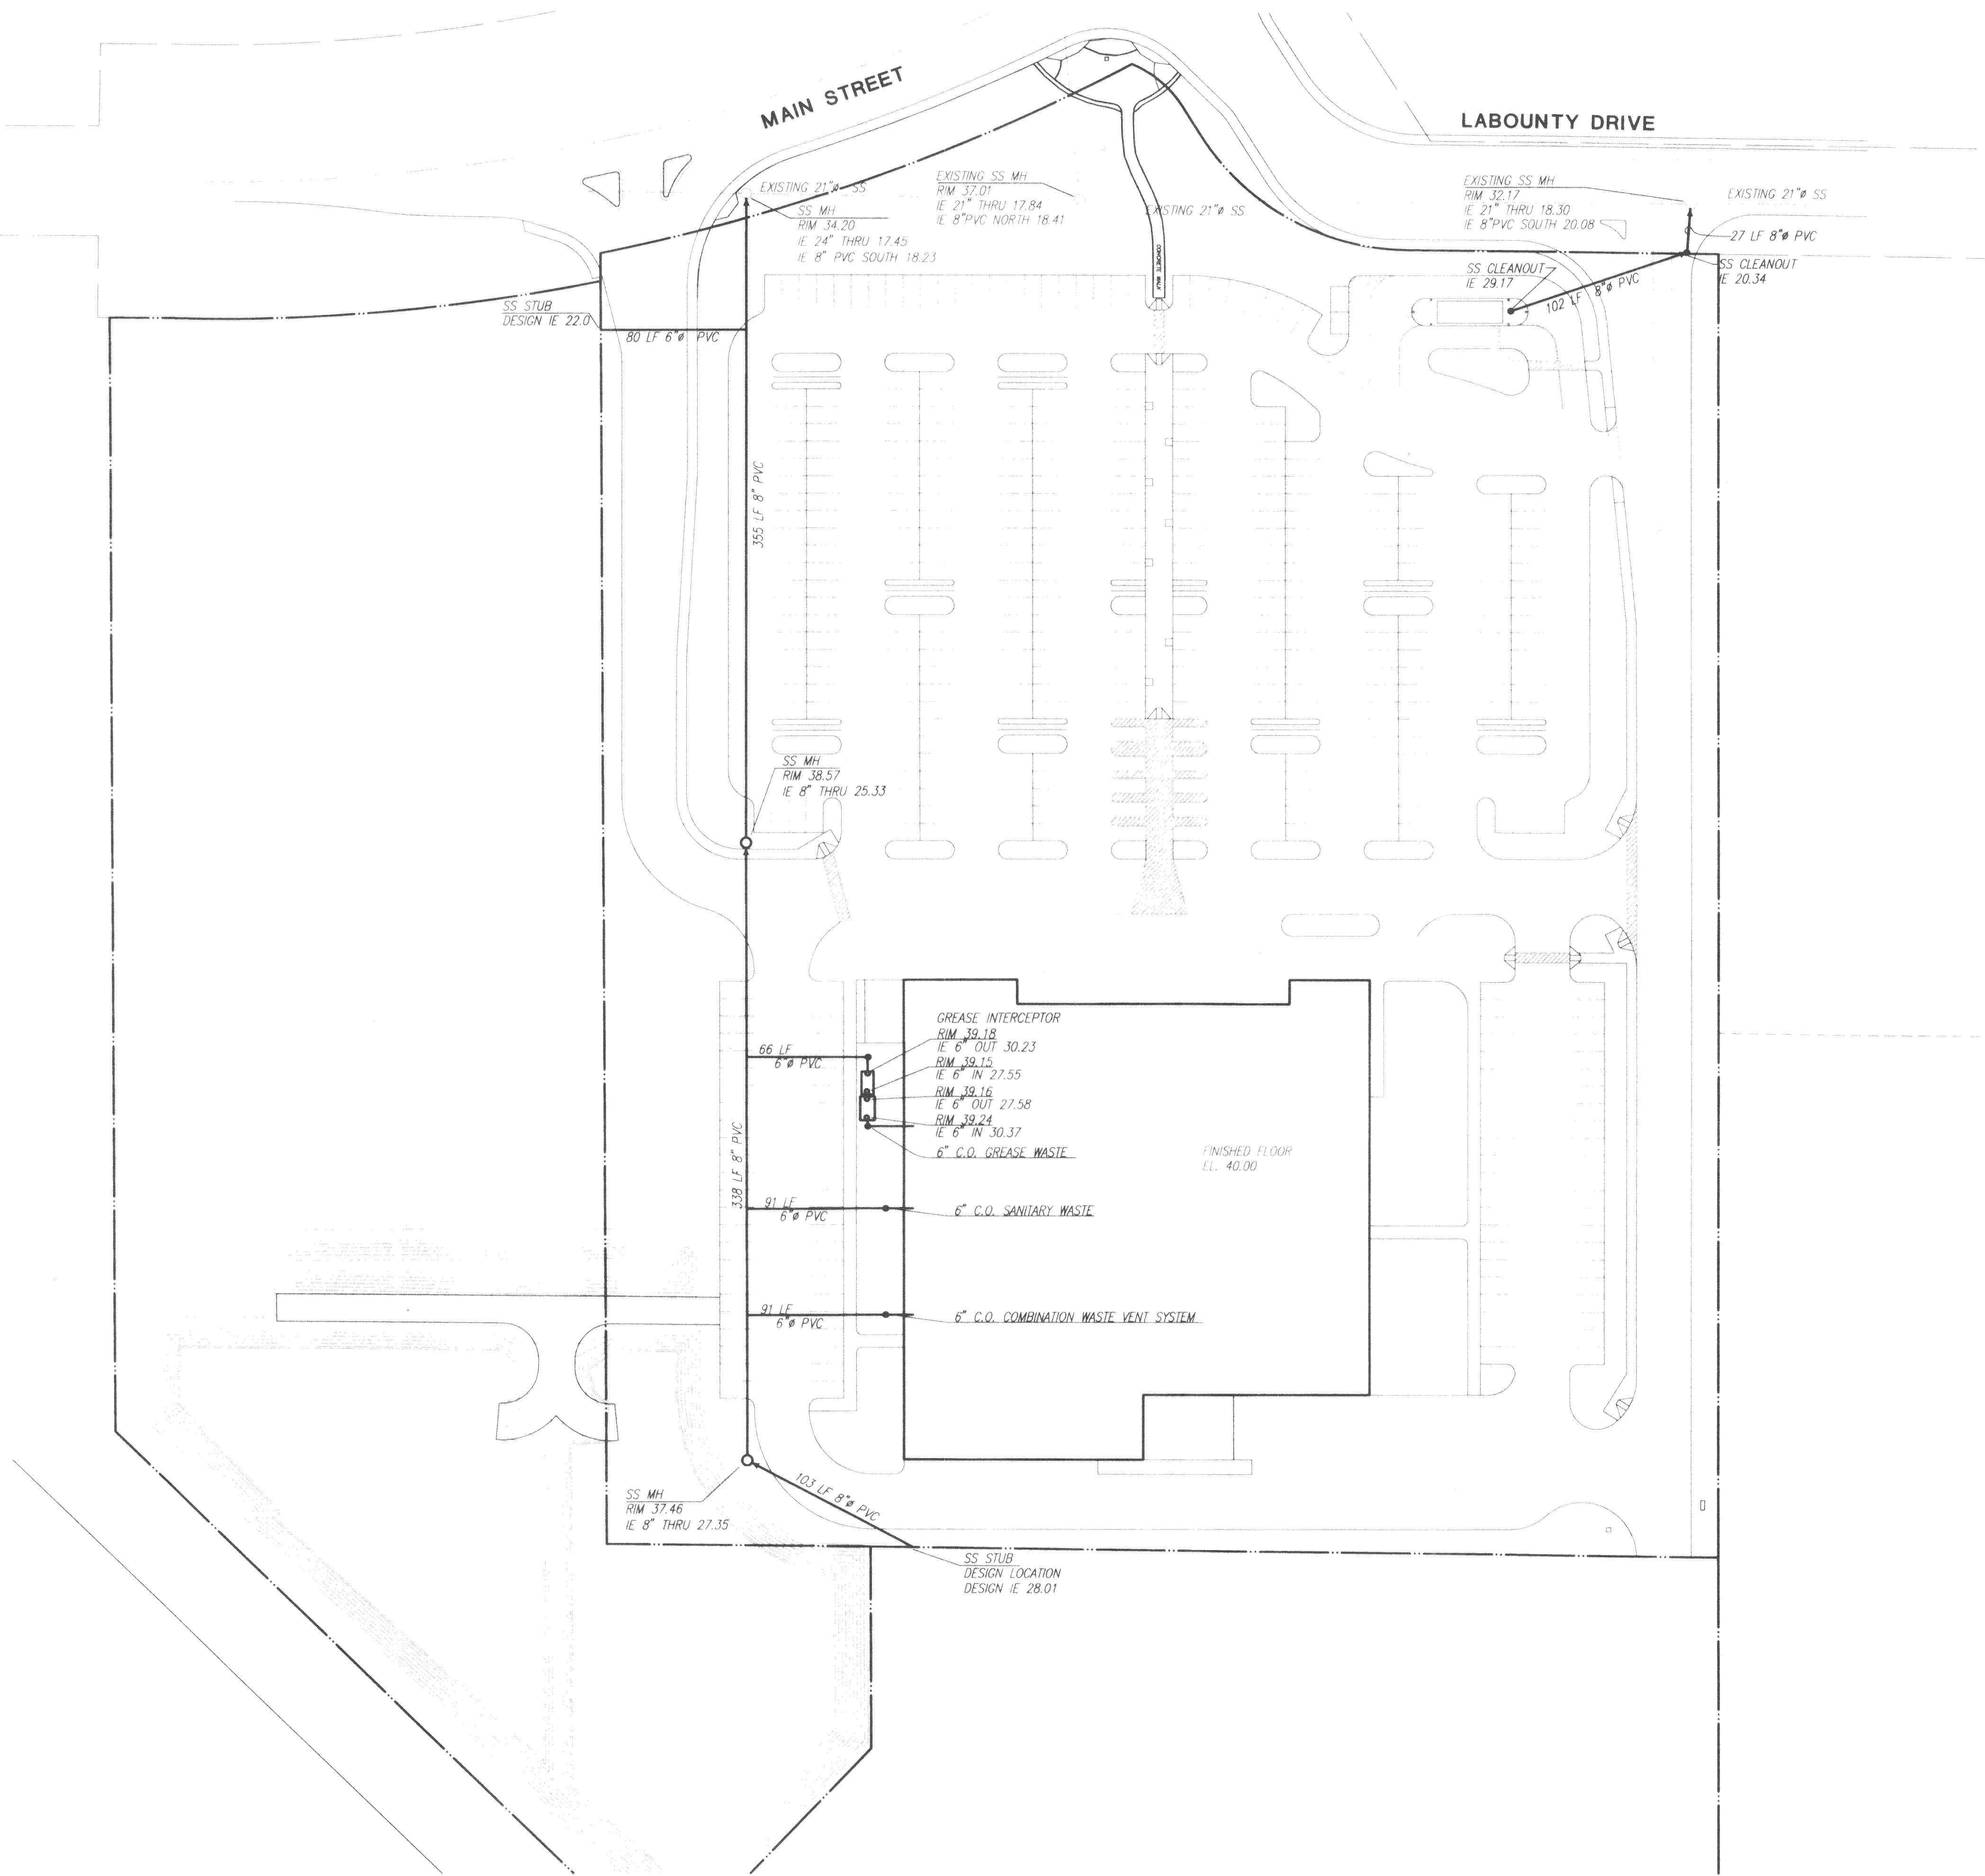

DATUM:
U.S.G.S. MONUMENT L-6 (RESET = 268) BRASS DISK
AT THE SOUTHEAST END OF BRIDGE OVER THE MOONSHACK
RIVER AT THE EAST CORNER OF THE SOUTHWEST CONCRETE
SIDEWALK ELEVATION 34.97' (1949 ADJUSTMENT)

Northwest Engineering Company
12828 Northrup Way, Suite 310
Bellevue, Washington 98005-8677-9800




BRIAR DEVELOPMENT COMPANY
HAGGEN FOOD AND PHARMACY
SANITARY SEWER PLAN
RECORD DRAWINGS

WASHINGTON
FERDALE

DESIGNED: WSP/LMR
DRAWN: TRT/KJG
CHECKED: REW
REVISED:
DRAWING NO.: ST06A001.DWG

918-05

SHEET
2 / 3

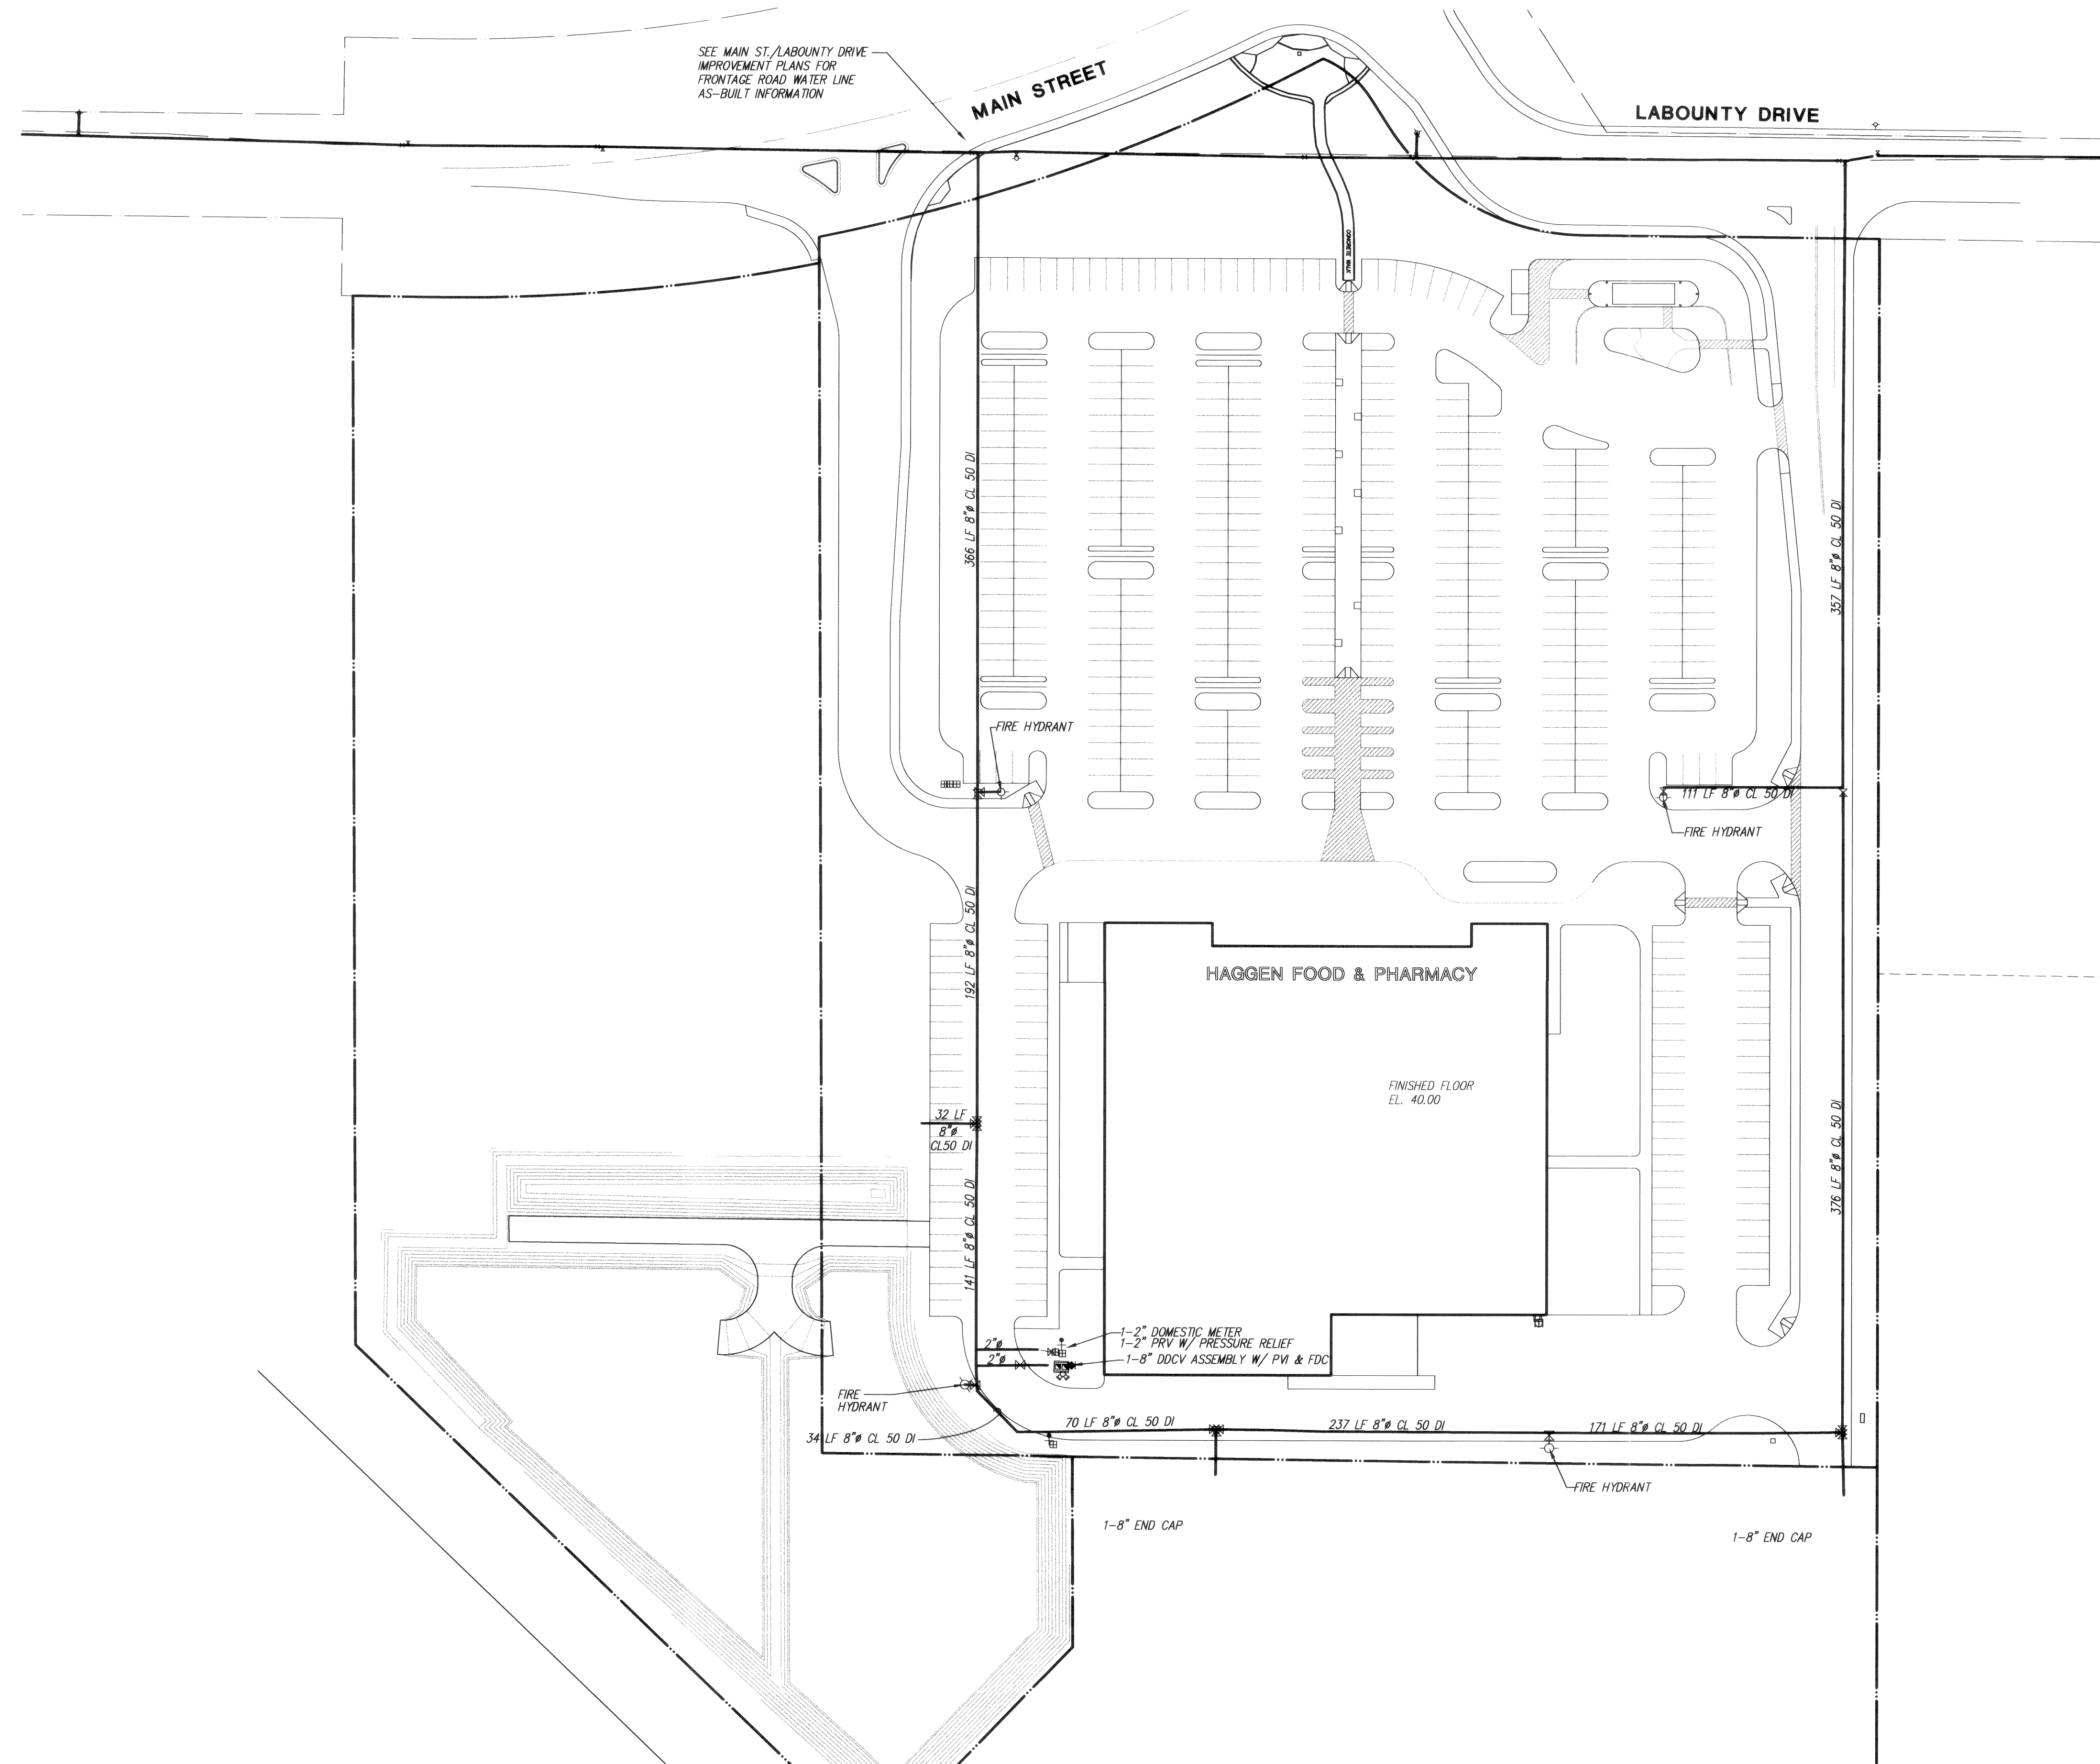



LEGEND

□	CATCH BASIN
⊕	STORM DRAIN MANHOLE
○	SANITARY SEWER MANHOLE
◊	SANITARY SEWER CLEANOUT
⌈	TELEPHONE RISER
⊖	TELEPHONE MANHOLE
○	PEDESTRIAN SIGNAL POST
⊗	TRAFFIC CONTROL BOX
	TRAFFIC SIGNAL POST
	TRAFFIC SIGNAL POST W/ LUMINAIRE
⊗	TRAFFIC SIGNAL CONTROLLER
⊕	GAS METER
⊕	GAS VALVE
	POWER VAULT
⊖	UTILITY POLE
	GUY ANCHOR
	LUMINAIRE ON ARM
	LUMINAIRE
	WATER VALVE
	WATER MANHOLE
◊	GUARD POST
⊗	IRRIGATION CONTROL VALVE
⊕	WATER METER
	FIRE HYDRANT
	FIRE DEPT CONNECTION
	DOUBLE DETECTOR CHECK VALVE
	POST INDICATOR VALVE
⊕	WATER BELOW OFF



**Northwest
Engineering
Company**

*12828 Northrup Way, Suite 310
Bellevue, Washington 206-867-9800*

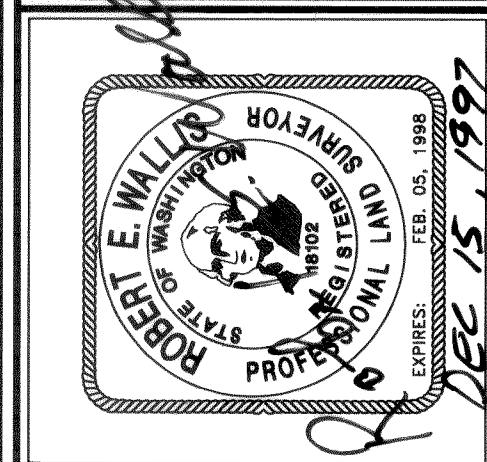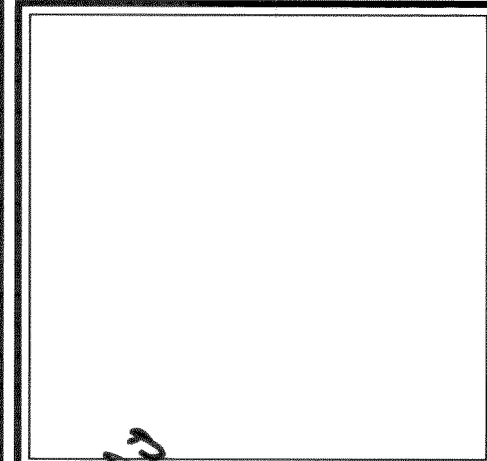

BRIAR DEVELOPMENT COMPANY
HAGGEN FOOD AND PHARMACY
WATER PLAN
RECORD DRAWINGS

FERNDALE **WASHINGTON**

DESIGNED: *WSP/LMR*
DRAWN: *TRT/KJG*
CHECKED: *REW*
REVISED:

DRAWING NO: *S106AB01.DWG*

918-05

SHEET

3 / 3