

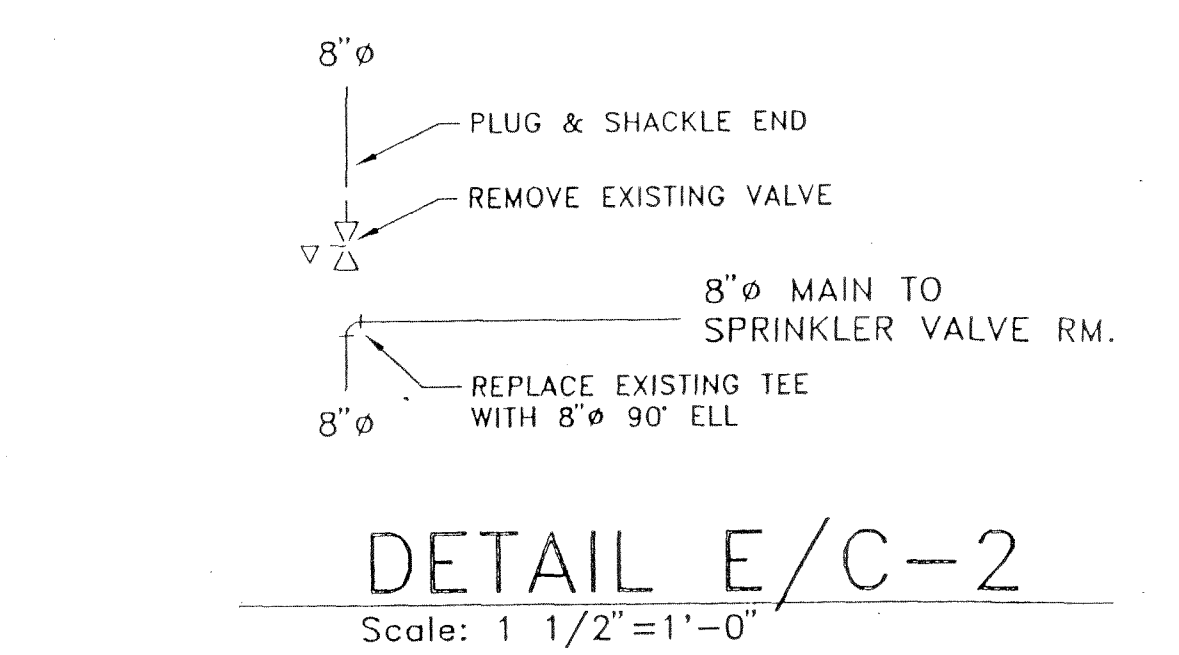
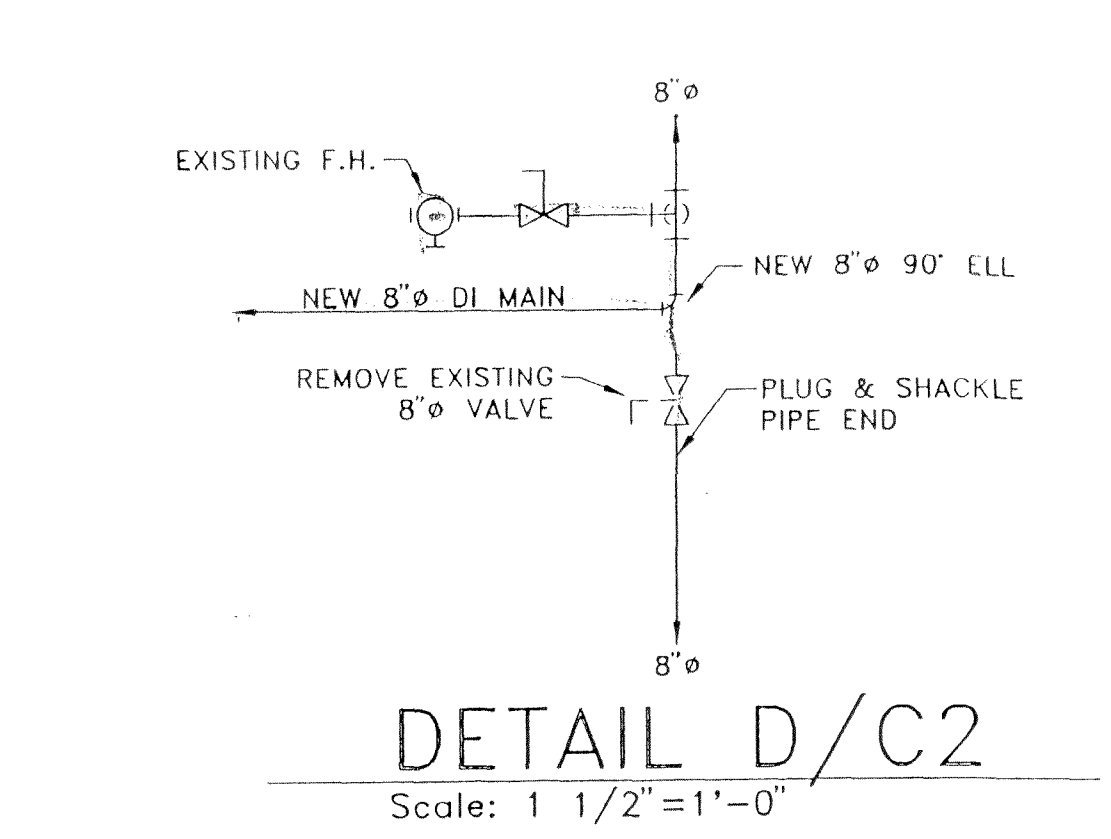
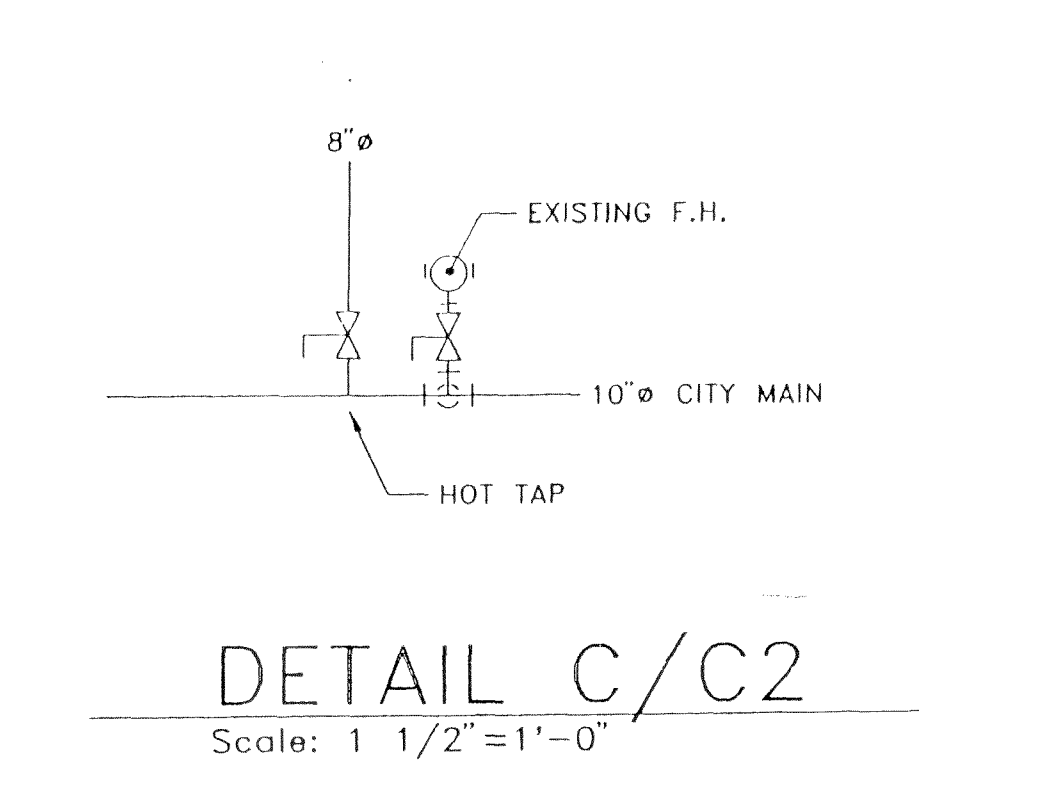
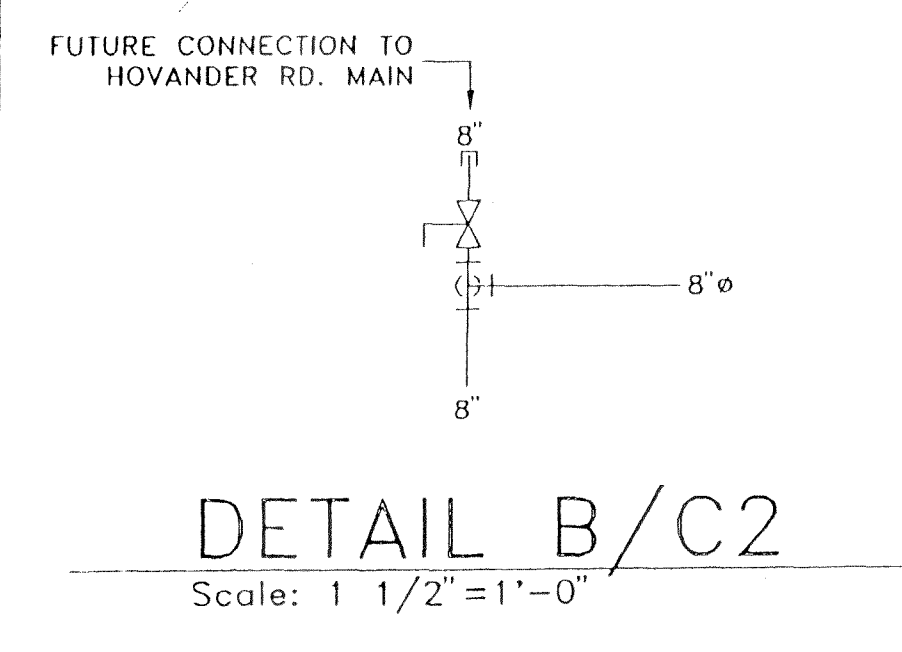


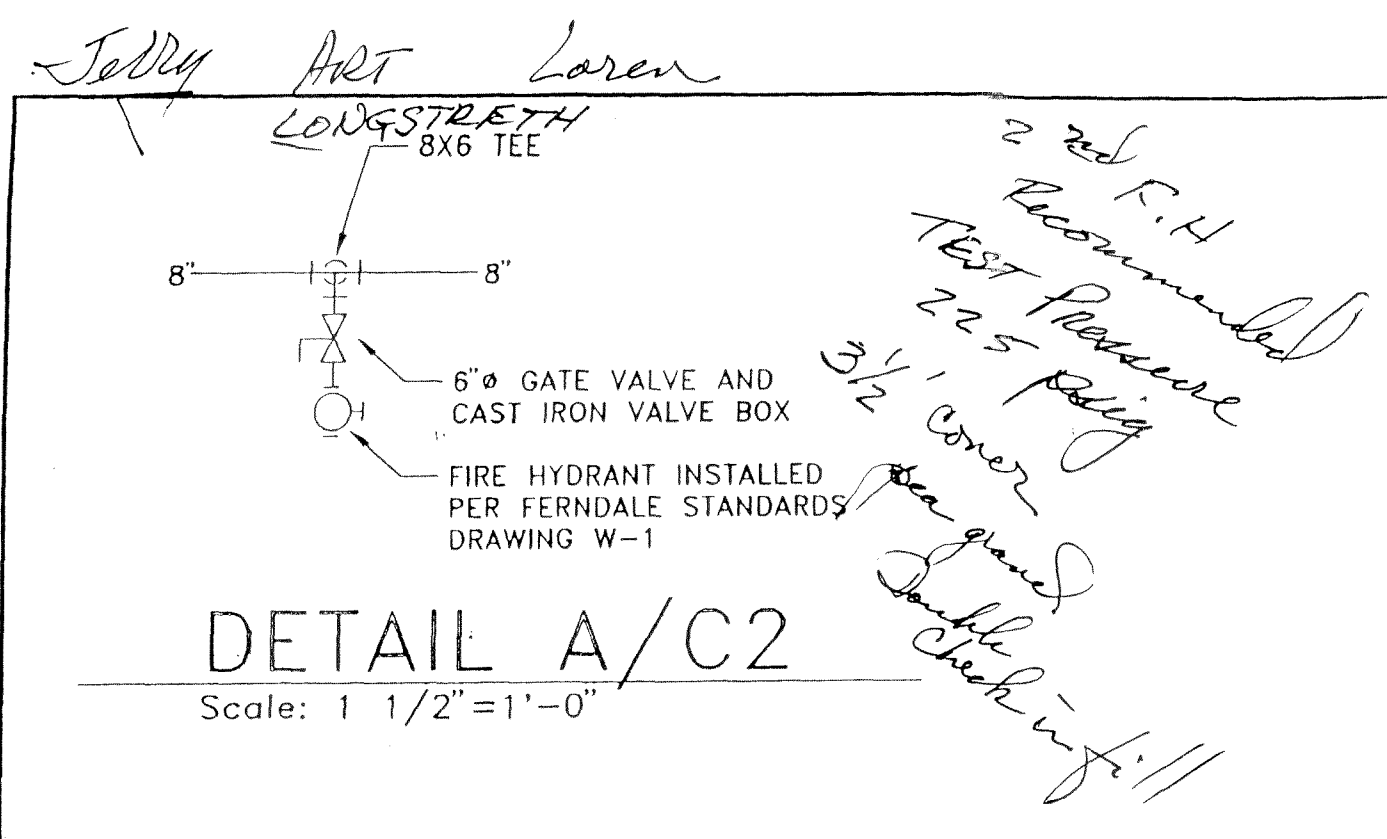

WATER MAIN EXTENTION

ALL WATER MAIN CONSTRUCTION SHALL BE IN ACCORDANCE WITH CITY OF FERDALE DEVELOPMENT STANDARDS, CHAPTER 7 UTILITIES, AND PER STANDARD DETAILS DRAWINGS W-1 THROUGH W-3 AND DRAWING W-12.

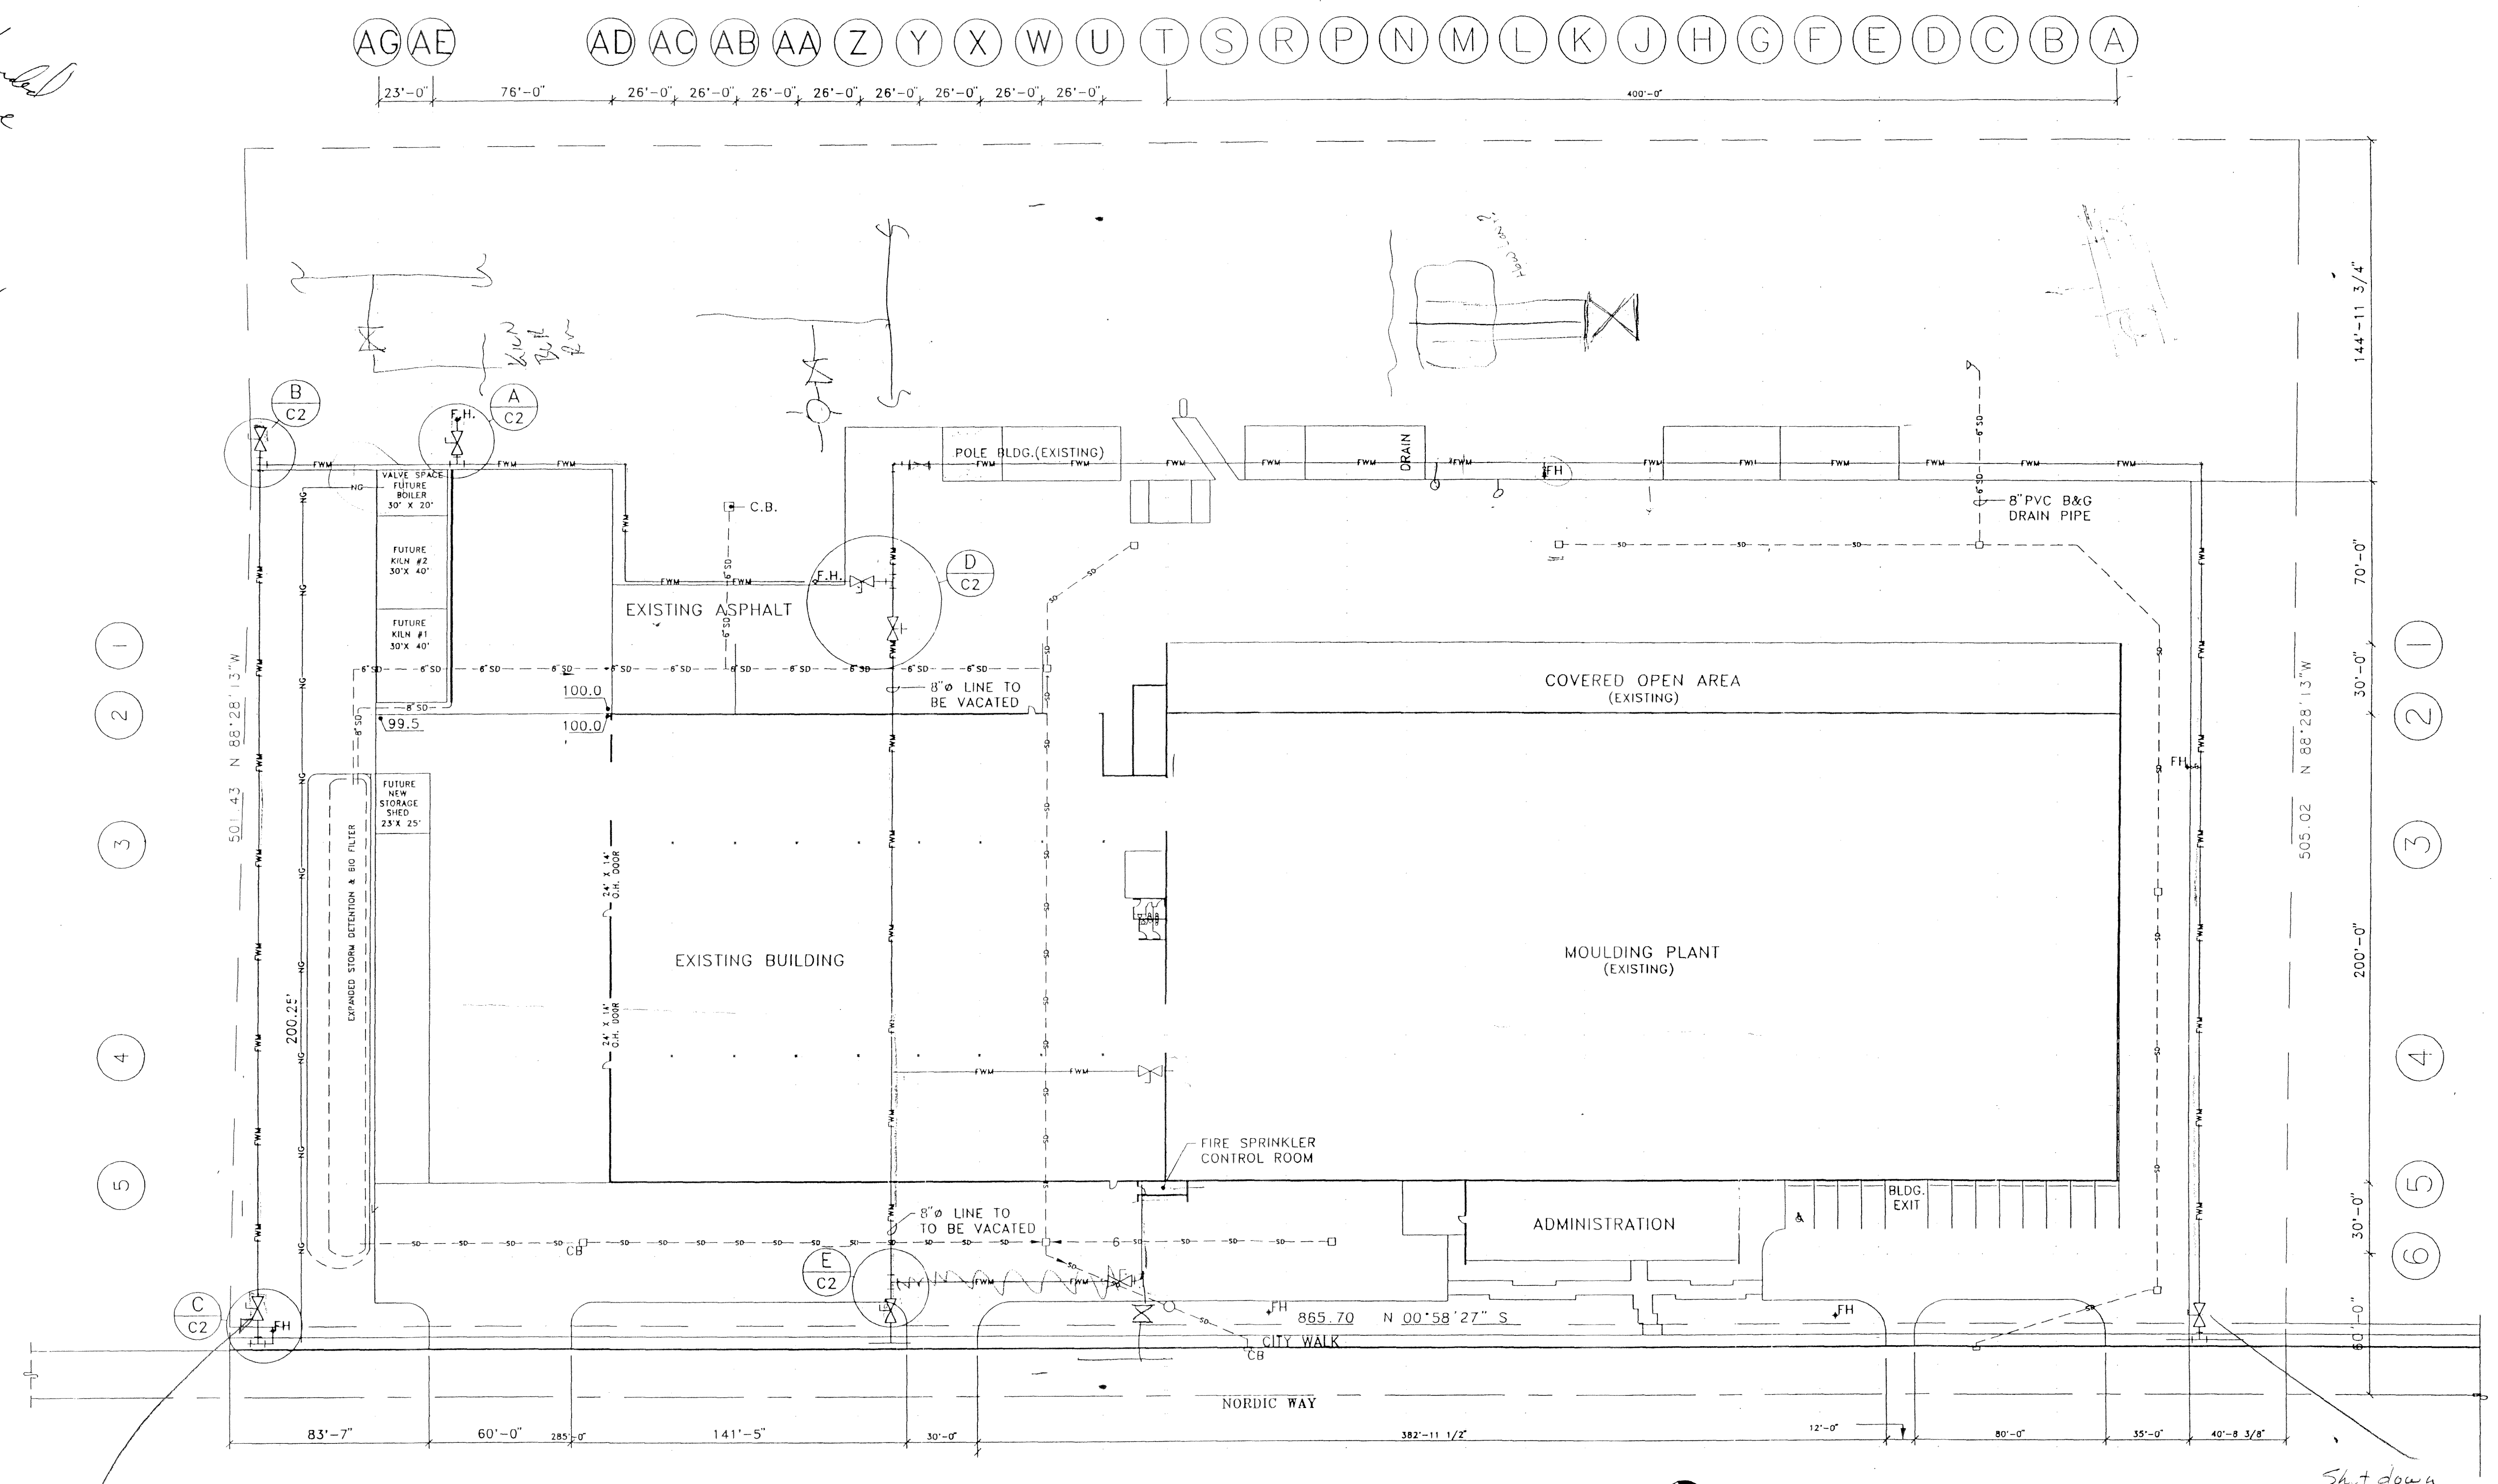

Shot Down
11-14-00
@ 9:00 am
Call Ched

Shot down
11-14-00

CIVIL SITE PLAN
 Scale: 1" = 40.00'

- LEGEND:**
- S--- STORM DRAINS (PVC)
 - FW--- FIRE WATER MAINS (8")
 - NG--- NATURAL GAS MAIN

Don Smith
 733-3769
 08/27/97 08:16 am

HASKELL CORP
 INDUSTRIAL/MECHANICAL/GENERAL CONTRACTOR/BELLINGHAM, WA

CONTRACTORS LICENSES:
 Washington: HASKE**374NT
 Alaska: AA11
 California: CLASS A 540106
 Oregon: 55258

This drawing, including the information hereon, remains the property of Haskell Corporation. It is provided solely for construction of the project described by or under the direction of Haskell Corporation. The drawing shall not be modified, reproduced or used for any other purpose without prior written approval of Haskell Corporation.

DATE	DESCRIPTION	BY
8-26-97	ON SITE WATER MAIN EXTENTION	RDS
REVISIONS		

SITE PLAN

SAUDER 97
 5575 NORDIC WAY
 FERDALE, WA

HASKELL CORPORATION
 P.O. BOX 917, BELLINGHAM, WA 98227 (206) 734-1100
 SCALE: 1"=40.00' DATE: 8-25-97 DR.F

JOB NO. 1148 DWG. NO. **C-2** REV