





0284.001 2-3-04 KR

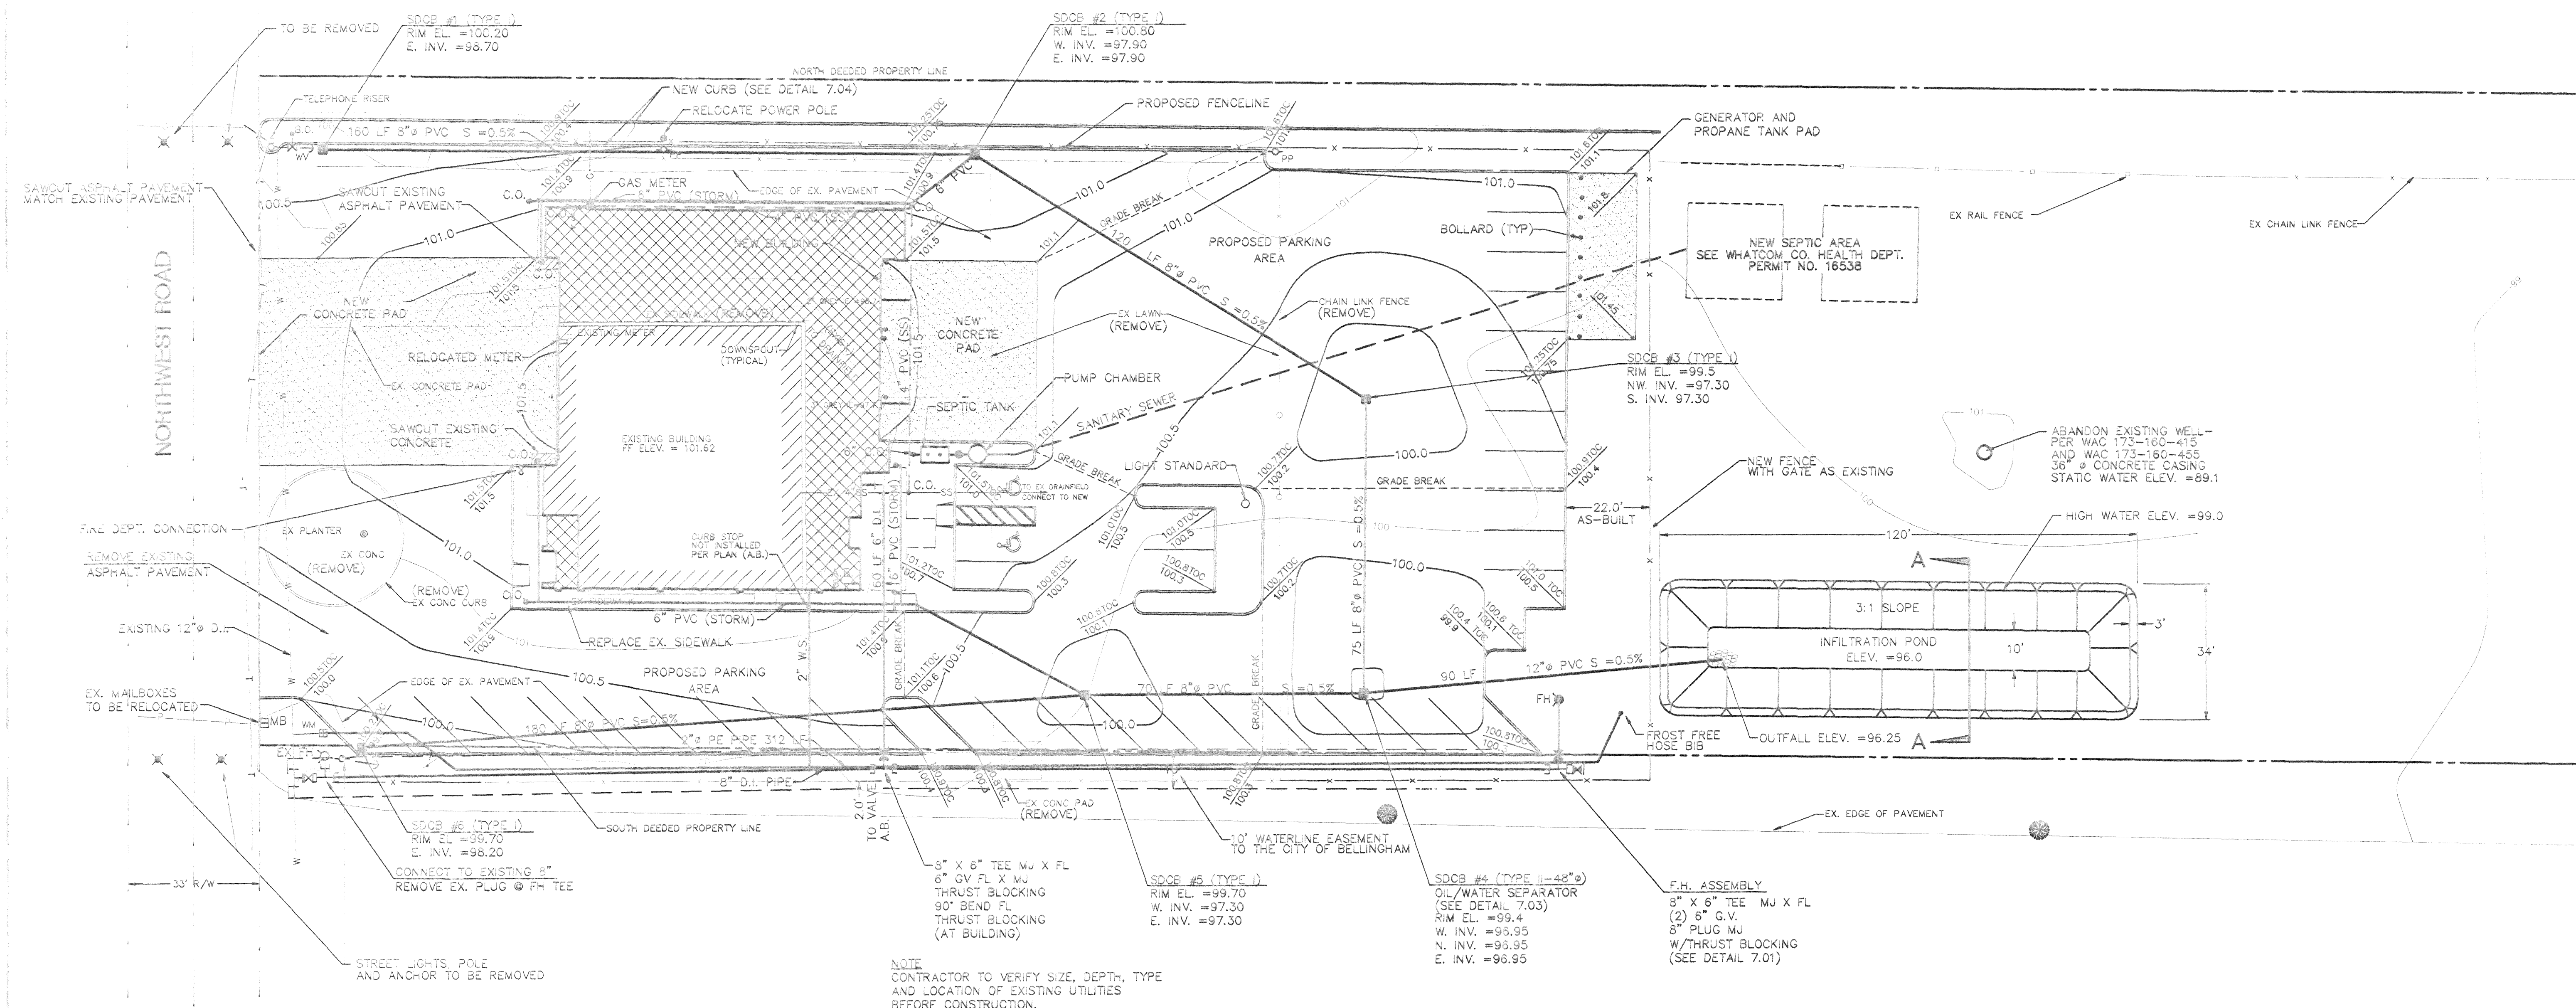

NOTE
CONTRACTOR TO VERIFY SIZE, DEPTH, TYPE
AND LOCATION OF EXISTING UTILITIES
BEFORE CONSTRUCTION.

LEGEND

EXISTING	PROPOSED	
		STORM DRAIN CATCH BASIN
		TOP OF CURB ELEV. @ ASPHALT
		FENCE LINE
		CONTOUR
		CURB (SEE DETAIL)
		FIRE HYDRANT
		WATER VALVE
		WATER METER
		WATER MAIN
		TELEPHONE
		POWER POLE
		POLE ANCHOR
		PROPERTY LINE

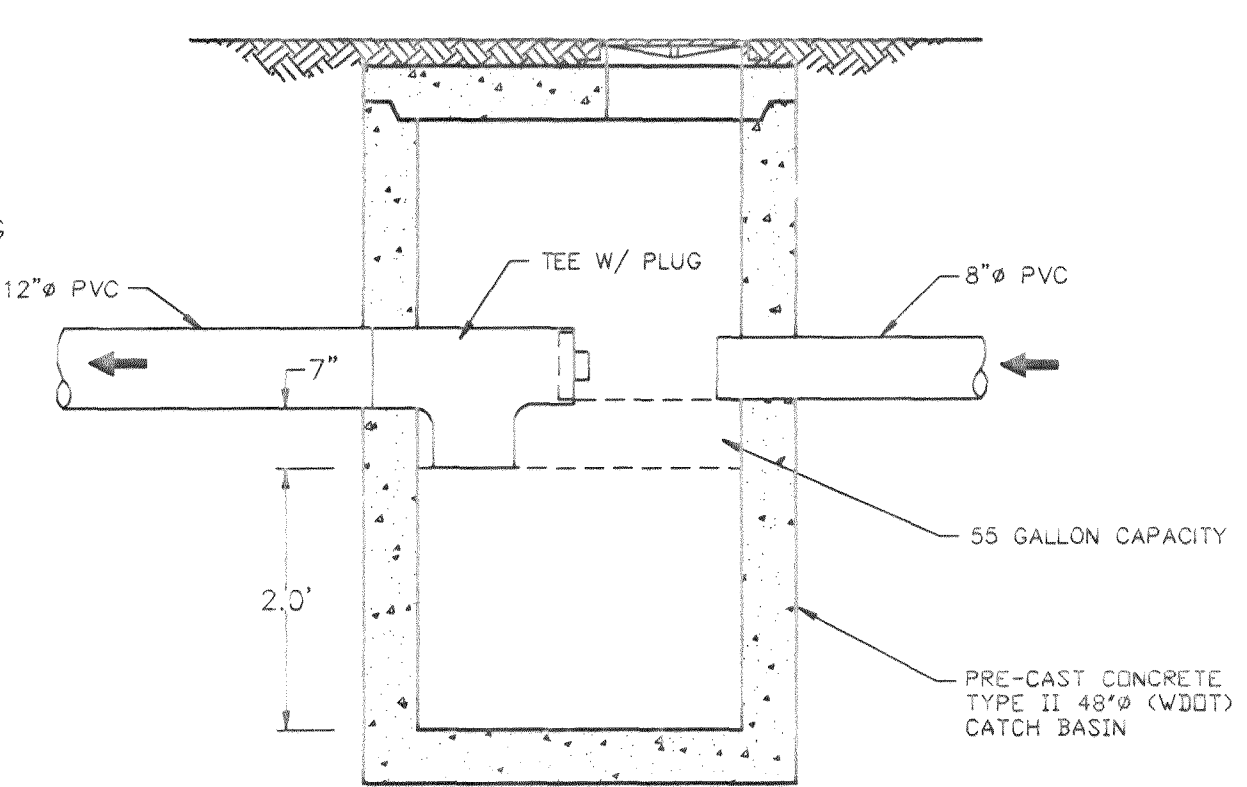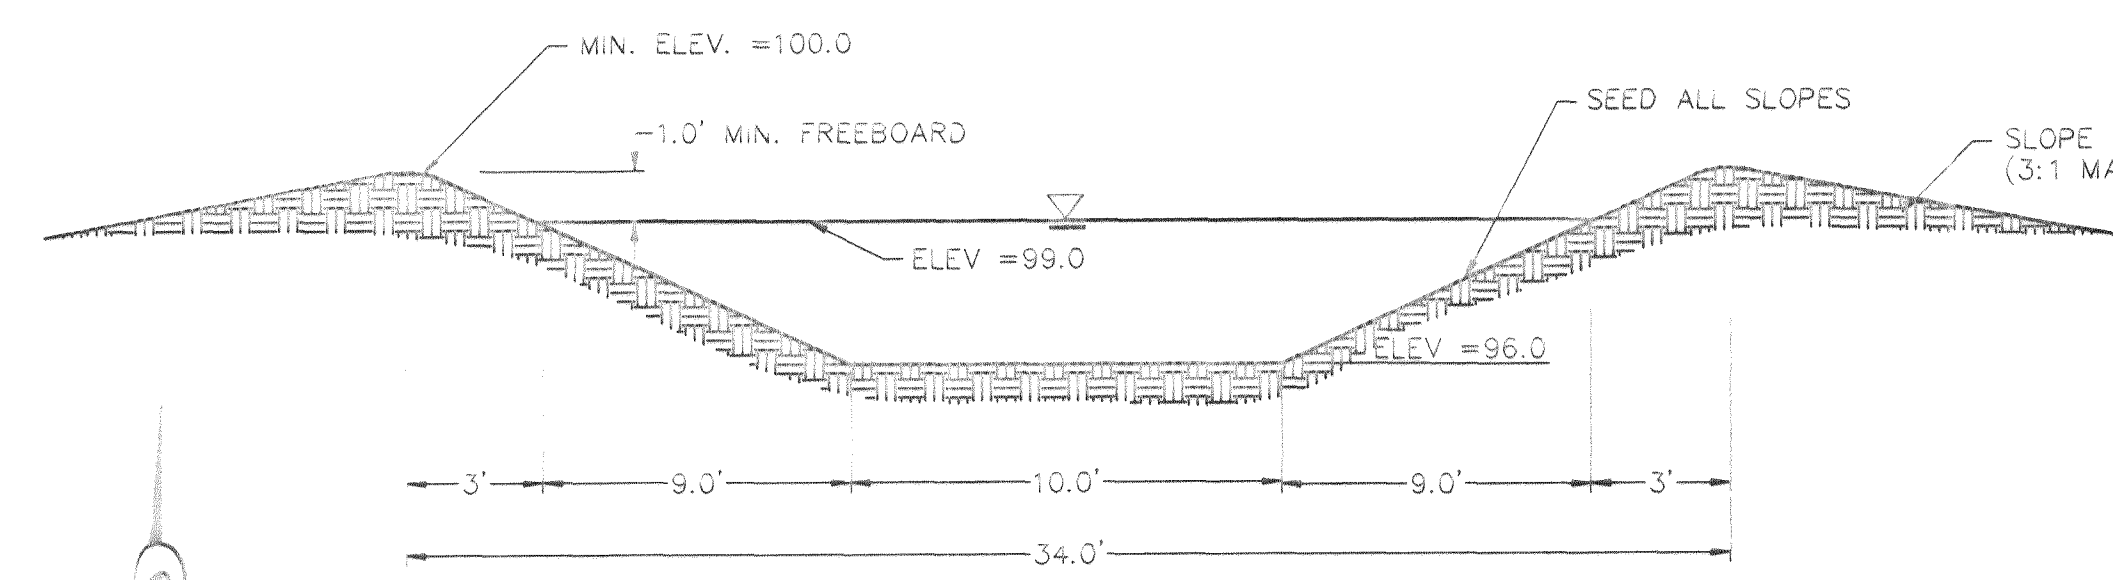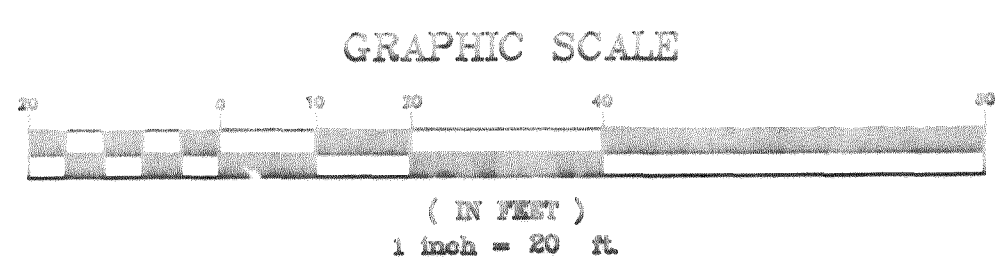

NOTE:

- THIS MAP DOES NOT REPRESENT A BOUNDARY SURVEY. TOPOGRAPHIC INFORMATION PROVIDED BY NORTHWEST SURVEYING, LYNDEN, WA. DATUM ASSUMED.
- FOR ALL DIMENSIONS REFER TO ARCHITECTS SITE PLAN.

LEGAL DESCRIPTION:

AS PER A.F. NO. 1155933, JONES TO W.C.F.D. NO.7 THE NORTH HALF OF THE SOUTH HALF OF THE NORTH HALF OF THE SOUTHWEST QUARTER OF THE SOUTHWEST QUARTER OF SECTION 27, TOWNSHIP 39 NORTH, RANGE 2 EAST, W.M., LESS ROAD.


ISSUE	DATE	BY	REVISIONS
G			
F			
E	2/20/95	GDE	AS BUILT WATER LINE
D	10/6/93	GDE	REMOVE TEE @ CONNECTION, RELOCATE FIRE DEPT. CONN.
C	7/28/93	GDE	ARCHITECT'S REVISIONS, ADD OWS DETAIL
B	7/16/93	GDE	MOVED W.L. F.D.C., SEPTIC
A	7/2/93	GDE	SUBMITTED FOR REVIEW

REICHARDT & EBE
ENGINEERING, INC.
CONSULTING ENGINEERS

2380 Grandview Rd.
Ferndale, Washington 98248

Phone 366-3456
Fax 366-3139

DRAWN BY: CWT
DESIGNED BY: GDE
CHECKED BY: GDE
JOB# / DRAWING: 3015 / SITE

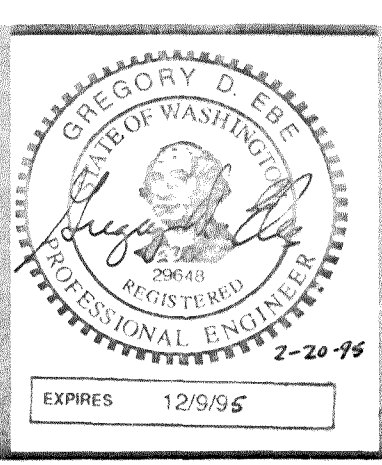

AS BUILT WATER LINE 2/20/95		
SITE PLAN W.C.F.D. NO.7 STATION 3 NORTHWEST ROAD, WHATCOM CO.		
DATE	SCALE	SHEET
5/12/93	H: 1"=10'	v: n/a
		1 of 1