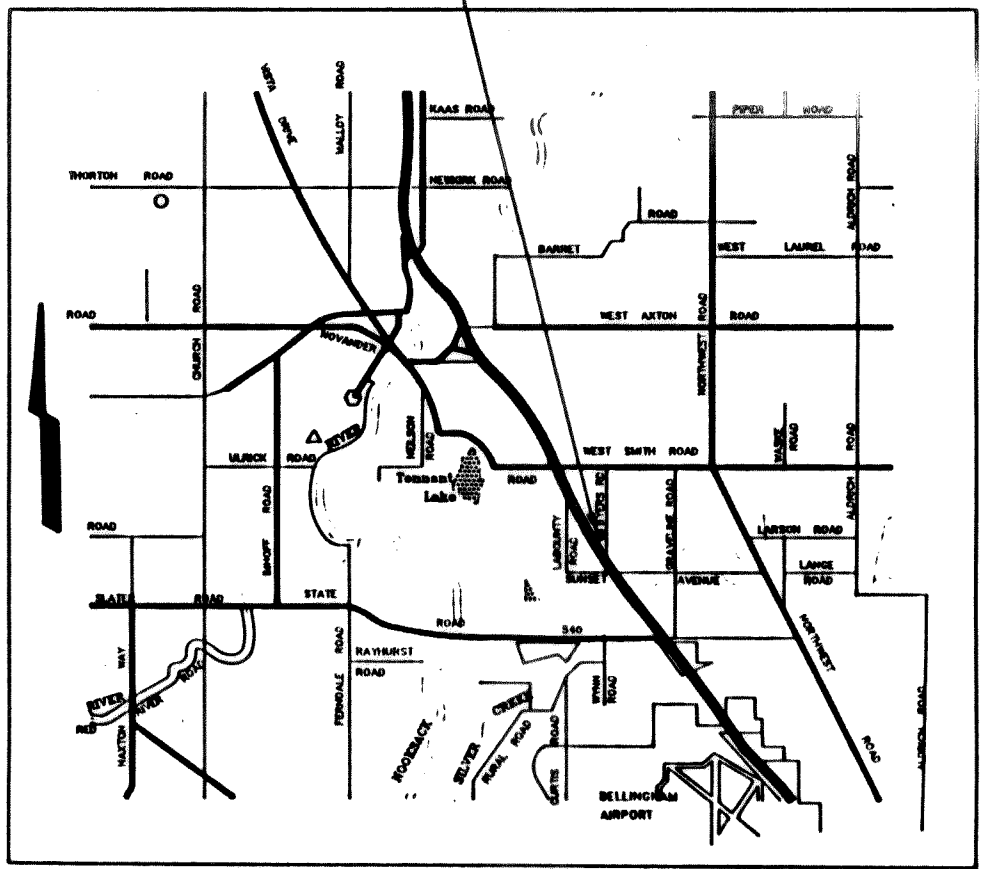
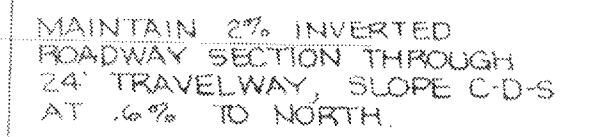


SITE LOCATION

- 1" SADDLE COPPER PIPE
INSTALL FORD V72-15 METER
SETTER W/ METER
TO CITY OF FERNDALE STANDARDS
CAP & BLOCK EXIST. 1 1/2" PVC WATER LINE
& CONNECT TO METER AFTER TESTING APPROVED

VICINITY MAP
NTS

CONSTRUCT CHAIN
LINK FENCE

**CAUTION: UTILITIES IN AREA
CALL BEFORE YOU DIG!**

SEE SHEET 2 OF 2

15' OPERATION
MAINTENANCE
EASEMENT_____

BEGIN PROJECT
STA 7+35

~~CONNECT TO EXISTING~~

EASEMENT

RECORD _ DRAWING

EXPIRES 9/26/94

GENERAL NOTES

1. THE LOCATION OF EXISTING UTILITIES SHOWN IS APPROXIMATE. IT IS THE RESPONSIBILITY OF THE CONTRACTOR TO FIELD VERIFY THESE LOCATIONS PRIOR TO CONSTRUCTION.
2. ALL WORK SHALL CONFORM TO THE STANDARD PLANS AND SPECIFICATIONS OF THE WASHINGTON STATE DEPARTMENT OF TRANSPORTATION (WSDOT), AND CITY OF FERNDALE STANDARDS UNLESS INDICATED OTHERWISE BY THE CONTRACT DOCUMENTS. IN CASE OF A CONFLICT BETWEEN THE REGULATORY STANDARDS OR SPECIFICATIONS, THE MORE STRINGENT REQUIREMENT WILL PREVAIL.
3. UNDERGROUND UTILITIES ARE KNOWN TO EXIST IN THE AREA OF CONSTRUCTION. IT IS THE RESPONSIBILITY OF THE CONTRACTOR TO NOTIFY THE UTILITY OWNERS FOR LOCATIONS AND TO NOTIFY THE ENGINEER PROMPTLY OF ANY CONFLICT.
4. THE CONTRACTOR SHALL BE RESPONSIBLE FOR MAINTAINING THE INTEGRITY OF ADJACENT UTILITIES WHICH INCLUDE, BUT ARE NOT LIMITED TO, WATER, SEWER, STORM SEWER, POWER, TELEPHONE, CABLE TV, IRRIGATION, AND STREET LIGHTING.
5. THE CONTRACTOR SHALL BE RESPONSIBLE FOR MAINTAINING EROSION CONTROL MEASURES (SILT FENCE, STRAW BALE DAMS, SILT POUNDS, ETC.) DIRECTED BY THE ENGINEER) THROUGHOUT THE DURATION OF THE PROJECT.
6. STORM PIPE SHALL BE OF AN APPROVED MATERIAL AND OF THE SIZE NOTED ON THE PLANS.
7. CONTRACTOR SHALL RIP RAP ALL CULVERT INLETS AND OUTLETS.
8. CONTRACTOR SHALL RESTORE ALL PRIVATE AND PUBLIC PROPERTY DISRUPTED BY THE PROJECT IMMEDIATELY AFTER CONSTRUCTION.


EB /93

DATE	SHEET
JAN / 90	1
SCALE	OF
1" = 50'	2
JOB NO.	
80005A	

RECORD DRAWING

JLW 2/26/93

1	REVISE ENTRANCE ROAD TO SOUTH-ADD ASPHALT C/S	C/S	6/1/90
2	REMOVE NOTE RE IMPROVING BYERS RD/ACCESS FOR FACILITY	REP	8/2/90
3	ADD SHEET 2 DESIGN OF ENTRANCE ROAD	C/S	8/20/90
4	ADD FIRE LINES- ADD SHEET 2/2 PROFILE & DETAILS	RFF	12/2/92
5	RELOCATE ALIGNMENT WATER EXTENSION	RFF	10/19/92
6	RELOCATE ALIGNMENT WATER EXTENSION NO.2	RFF	12/23/92

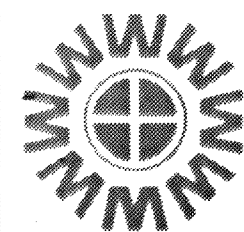


WEDEN ENGINEERING, INC.

ENGINEERING AND LAND SURVEYING
BELLINGHAM, WASHINGTON 671-8200, 354-3723


[illegible]

Year	1990	1991	1992	2099
1990	1991	1992	2099	

PACIFIC MINI STORAGE
WATER LINE EXTENSION

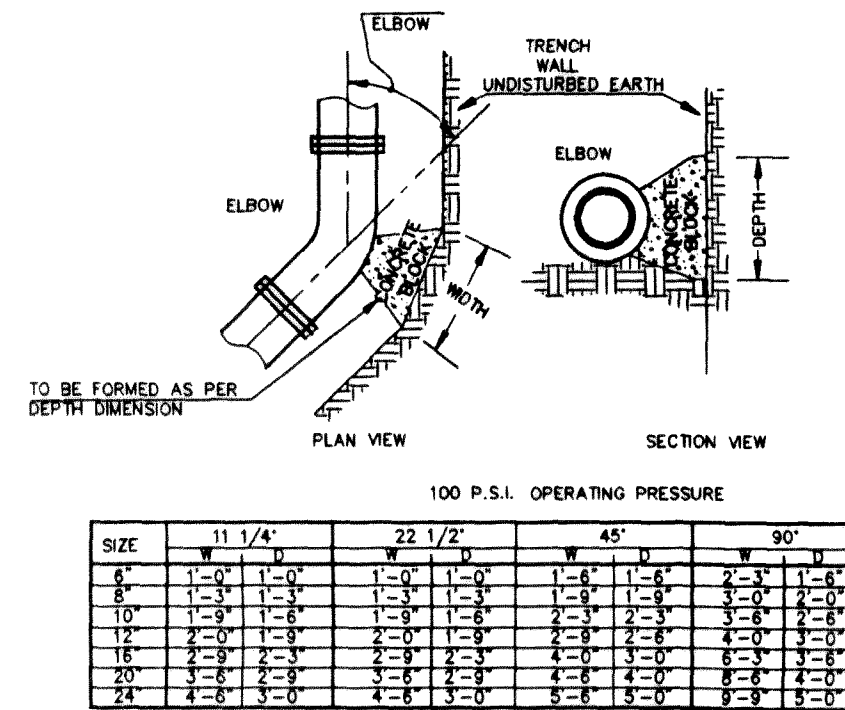


1 THRUST BLOCKING DETAIL
NTS

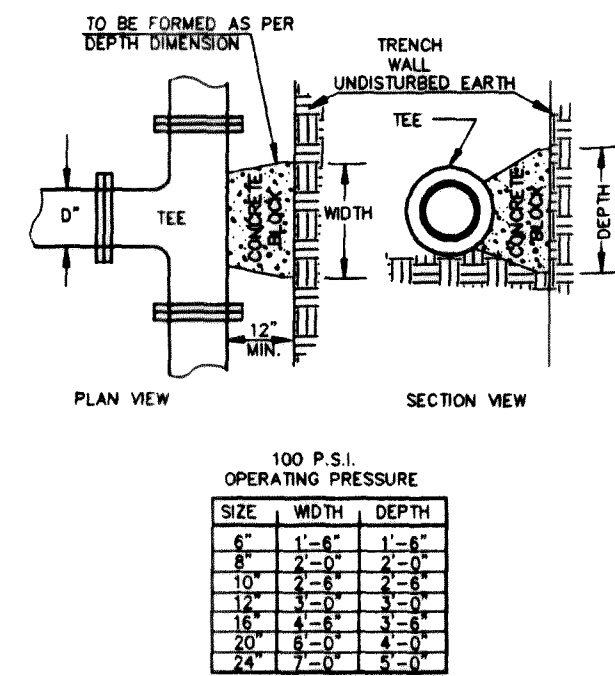


2 THRUST BLOCKING DETAIL
NTS

NOTE:
ALL ABOVE DIMENSIONS APPLY TO STABLE TRENCH WALLS, UNDER VARIABLE
CONDITIONS SIZE OF THRUST BLOCK SHALL BE DETERMINED BY ENGINEER.

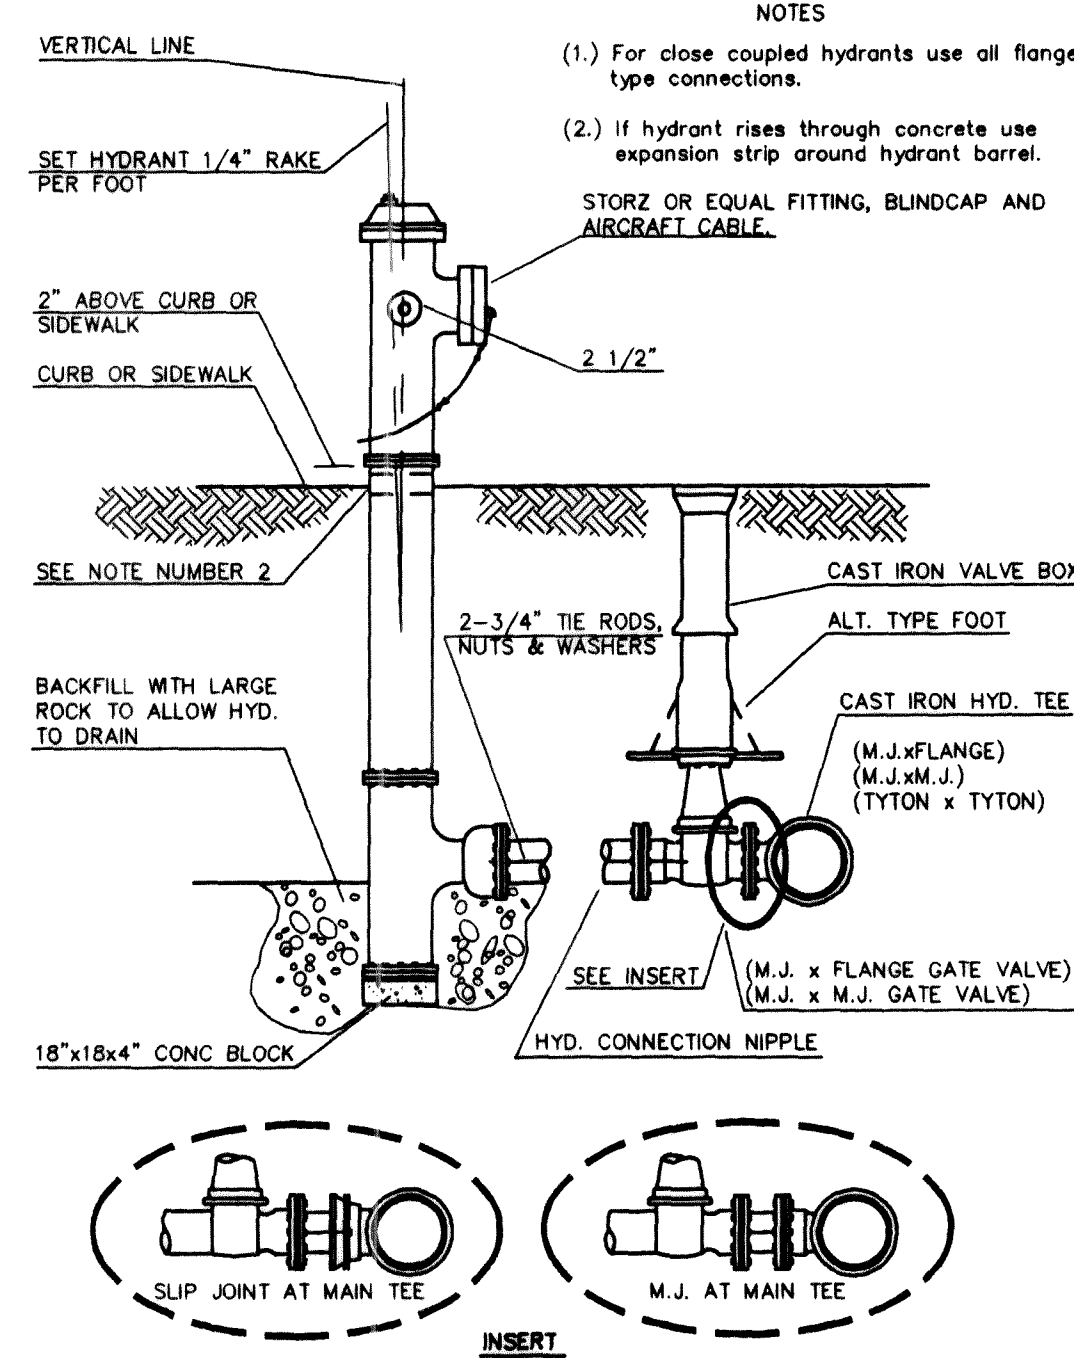


3 FIRE HYDRANT ASSEMBLY
1,2

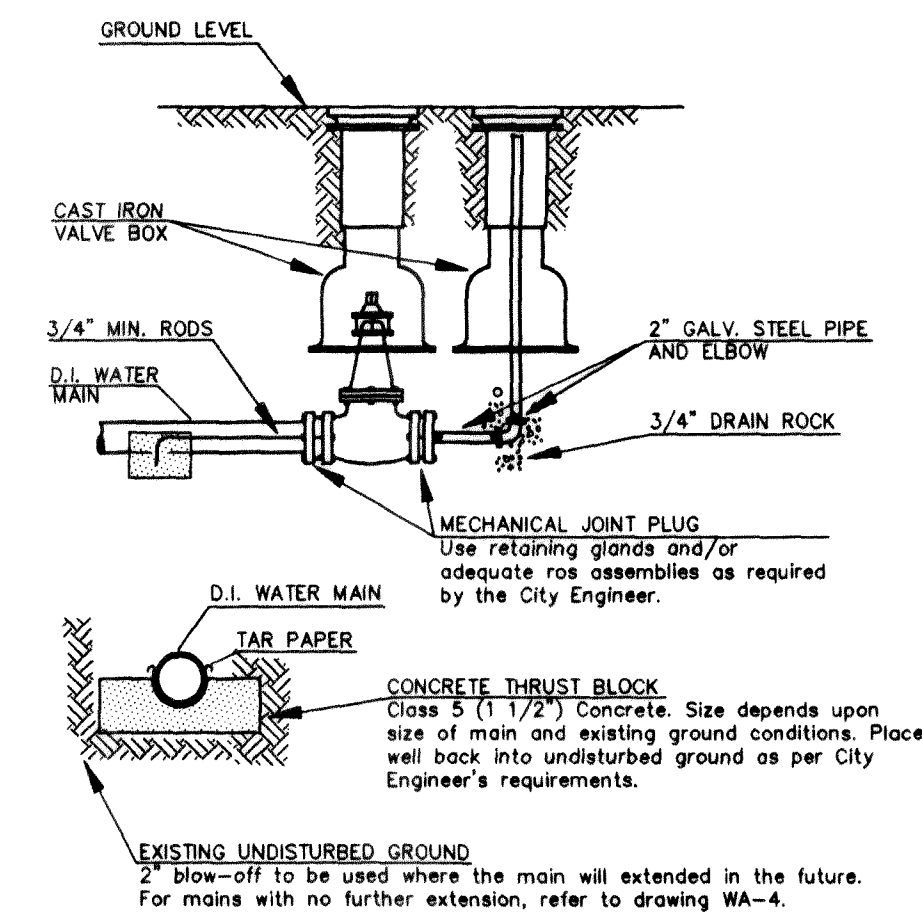


4 2" BLOW-OFF
WATER MAIN EXTENSIONS
NTS

DETAILS

RECORD DRAWING

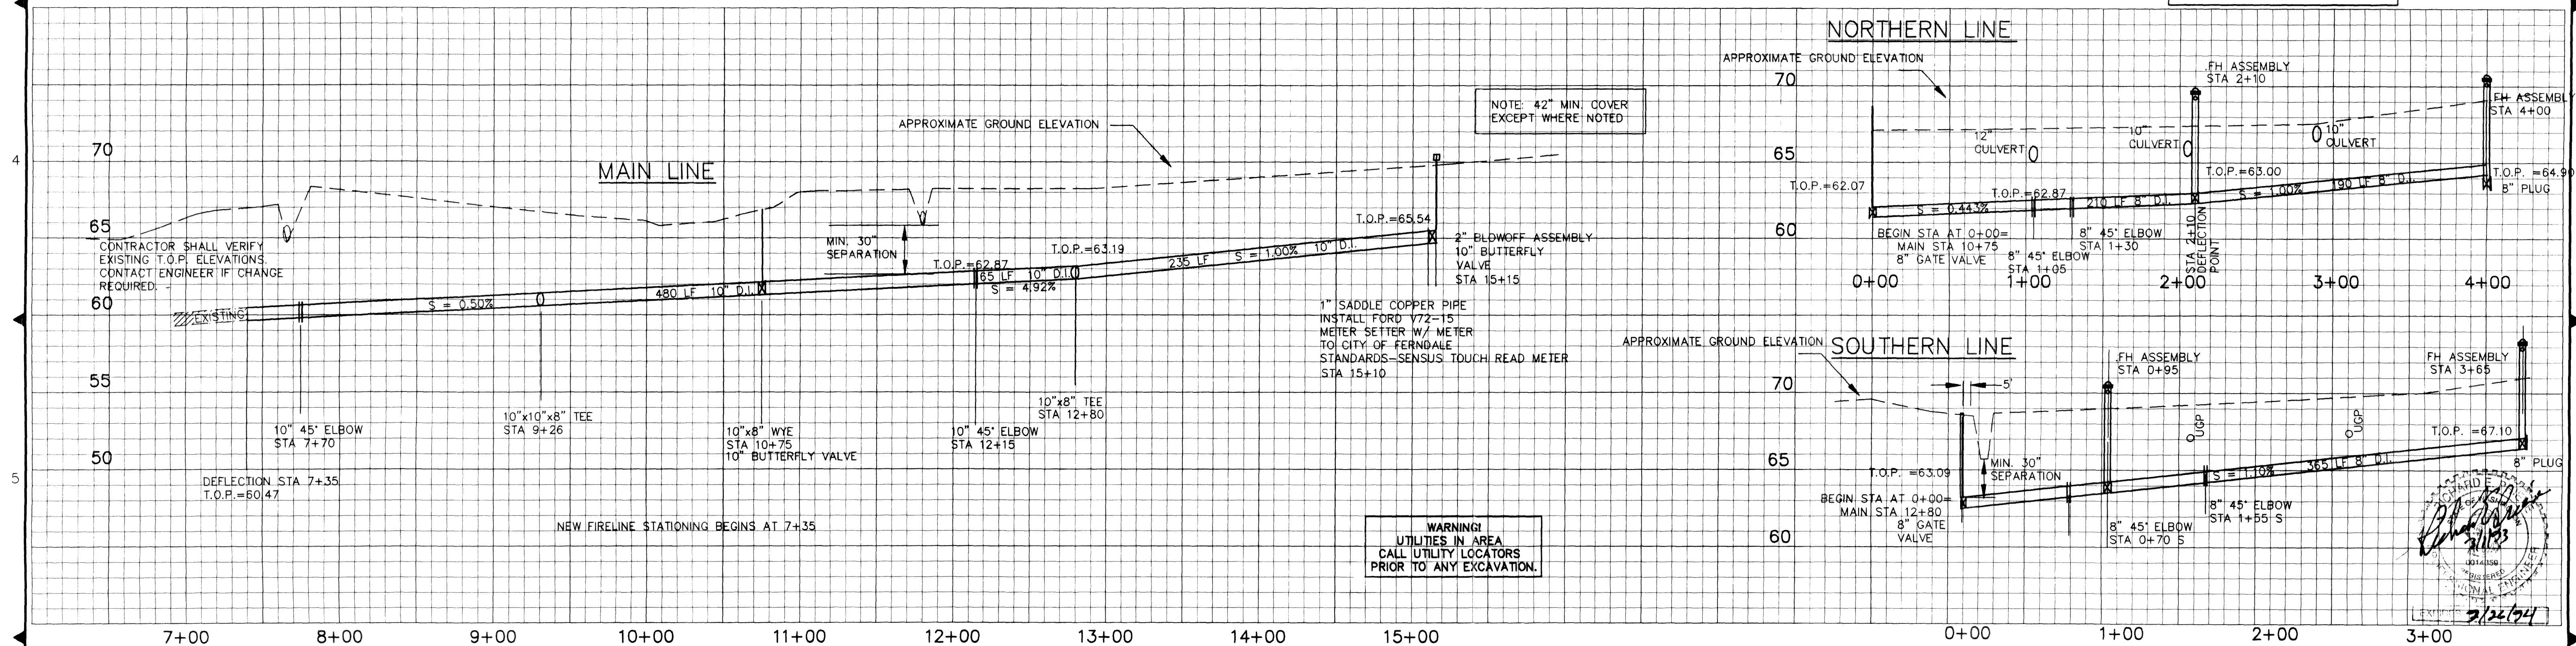

1	REVISIONS TO WATER LINE PROFILE	RF	11/19/92
2	REVISIONS TO WATER LINE PROFILE	RF	12/23/92
	RECORD DRAWING	JW	2/26/93
NO.	REVISIONS	BY	DATE

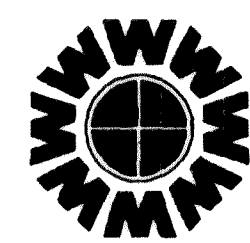

WEDEN ENGINEERING, INC.
119 GRAND AVENUE, SUITE D,
BELLINGHAM, WA. 98225 671-8200

ONE INCH AT FULL SCALE
IF NOT ONE INCH
SCALE ACCORDINGLY

DESIGNED BY
DRAWN BY
CHECKED BY

PACIFIC MINI STORAGE
WATER LINE EXTENSION

DATE
11/2/92
SCALE
1"=50' HORZ
1"=5' VERT
REC. NO.
90005A
SHEET
2
OF
2

00148.002 2:3:00 KR