

MALLOY VILLAGE PUD PHASE I, II AND III

AS-BUILTS

CITY OF FERNDALE



VICINITY MAP
NO SCALE

CONTACTS:

OWNER:
MALLOY VILLAGE LLC
C/O TIM CAREY
1954 W. CARSON ST., SUITE B
TORRANCE, CA 90501
(310) 787-6572

ENGINEER:
MILLENNIUM ENGINEERING GROUP, INC.
P.O. BOX 137 - 109 - 6TH STREET
LYNDEN, WA 98264
(360) 354-8141
CHAD SCHULHAUSER, P.E.

SURVEYOR:
LARRY STEELE & ASSOCIATES
1323 LINCOLN ST., SUITE 105
BELLINGHAM, WA 98226
(360) 676-9350
LARRY STEELE, P.L.S.

LEGEND

EXISTING		PROPOSED
SD	STORM MAIN	
	ROOF & YARD DRAIN	
	STORM DRAIN CATCH BASIN	
	STORM DRAIN MANHOLE	
W	WATER MAIN	
	GATE VALVE	
	FIRE HYDRANT	
	WATER METER	
SS	SEWER MAIN	
	SEWER MANHOLE	
	SEWER CLEANOUT	
	STREET LIGHT	
	STREET SIGN	
	MAIL BOX	
	FENCE	
	POWER VAULT	
	UTILITY POLE	
P	POWER LINE	
T	TELEPHONE LINE	
G	NATURAL GAS LINE	
	TELEPHONE/CABLE RISER	

SHT.

TITLE

- COVER SHEET
- EXISTING CONDITIONS - NOT INCLUDED
- SUBDIVISION PLAN - NOT INCLUDED
- CONSTRUCTION STORMWATER POLLUTION PREVENTION PLAN & FINISHED GRADING - NOT INCLUDED
- SITE UTILITY PLAN
- MALLOY RD. 0+00 - 5+80 STREET & STORM
- MALLOY RD. 5+80 - 12+30 STREET & STORM
- MALLOY RD. 12+30 - END STREET & STORM
- KONA COURT STREET & STORM - NOT INCLUDED
- CALICO LOOP (ENTRY) STREET & STORM - NOT INCLUDED
- CALICO LOOP 0+00 - 6+50 STREET & STORM - NOT INCLUDED
- CALICO LOOP 6+50 - 13+20 STREET & STORM - NOT INCLUDED
- CALICO LOOP 13+20 - 19+85 STREET & STORM - NOT INCLUDED
- CALICO LOOP 19+85 - 25+70 STREET & STORM - NOT INCLUDED
- CALICO LOOP 25+70 - END & FITZGERALD LANE STREET & STORM - NOT INCLUDED
- ANDRE COURT STREET & STORM - NOT INCLUDED
- ALLEY 1 & ALLEY 2 STREET & STORM - NOT INCLUDED
- ALLEY 3 STREET & STORM - NOT INCLUDED
- ALLEY 4 STREET & STORM - NOT INCLUDED
- DRIVEWAY 1, 2, 3, & 4 STREET & STORM - NOT INCLUDED
- MALLOY RD. 0+00 - 5+80 SEWER & WATER
- MALLOY RD. 5+80 - 12+30 SEWER & WATER
- MALLOY RD. 12+30 - END SEWER & WATER
- KONA ST. SEWER & WATER
- CALICO LOOP (ENTRY) SEWER & WATER
- CALICO LOOP 0+00 - 6+50 SEWER & WATER
- CALICO LOOP 6+50 - 13+20 SEWER & WATER
- CALICO LOOP 13+20 - 19+85 SEWER & WATER
- CALICO LOOP 19+85 - 25+70 SEWER & WATER
- CALICO LOOP 25+70 - END & FITZGERALD LANE SEWER & WATER
- ANDRE COURT SEWER & WATER - NOT INCLUDED

SHT.

TITLE

- ALLEY 1 & ALLEY 2 SEWER & WATER - NOT INCLUDED
- ALLEY 3 SEWER & WATER
- ALLEY 4 SEWER & WATER - NOT INCLUDED
- DRIVEWAY 1, 2, 3, & 4 SEWER & WATER
- SANITARY SEWER LIFT STATION
- SITE STORMWATER FACILITIES-WEST - NOT INCLUDED
- SITE STORMWATER FACILITIES-EAST - NOT INCLUDED
- TRAFFIC CONTROL & STREET SIGNAGE PLAN - NOT INCLUDED
- DETAILS
- DETAILS
- DETAILS

PUBLIC/PRIVATE IMPROVEMENTS NOTES:

- PRIVATE IMPROVEMENTS SHALL BE INSPECTED BY THE ENGINEER OF RECORD OR A DESIGNATED PARTY UNDER THE ENGINEER OF RECORD'S SUPERVISION. THIS PROJECT IS A PUD WITH MOST ON-SITE IMPROVEMENTS TO BE MAINTAINED BY A PRIVATE ASSOCIATION INCLUDING:
 - ALL ON-SITE ROADS
 - ALL ON-SITE STORM STRUCTURES
 - ALL ON-SITE GRADING WORK
 - ALL OTHER PRIVATE IMPROVEMENTS SHOWN ON THESE PLANS
- PUBLIC IMPROVEMENTS SHALL BE INSPECTED BY THE CITY OF FERNDALE INCLUDING:
 - ALL OFF-SITE IMPROVEMENTS
 - ALL WATER SYSTEM STRUCTURES (METERS, HYDRANTS, AND PIPE MAINS)
 - ALL SEWER STRUCTURES
- WATER AND SEWER EASEMENT NOTE:
ALL WATER AND SEWER MAINS WITHIN MALLOY VILLAGE P.U.D. ARE ASSOCIATED WITH AN ACCESS AND UTILITY EASEMENT THAT BENEFITS THE CITY OF FERNDALE. FOR LOCATION OF SAID EASEMENTS SEE EASEMENT DEED RECORDED UNDER WHATCOM COUNTY AUDITOR'S FILE NUMBERS:
#2060703634-SEWER,
#2060703635-WATER.

GENERAL NOTES:

- ALL WORK AND MATERIALS SHALL BE IN ACCORDANCE WITH THE CURRENT EDITION OF THE WASHINGTON STATE DEPARTMENT OF TRANSPORTATION (WSDOT) AND THE AMERICAN PUBLIC WORKS ASSOCIATION (APWA) WASHINGTON STATE CHAPTER STANDARD PLANS AND SPECIFICATIONS FOR ROAD, BRIDGE, AND MUNICIPAL CONSTRUCTION AND THE CITY OF FERNDALE STANDARDS. IN CASE OF A CONFLICT BETWEEN THE REGULATORY STANDARDS OR SPECIFICATIONS, THE MORE STRINGENT REQUIREMENT WILL PREVAIL.
- ALL WORK AND MATERIALS SHALL BE SUBJECT TO APPROVAL BY THE CITY OF FERNDALE.
- UTILITY CONSTRUCTION SHALL BE DONE IN ACCORDANCE TO THE CITY OF FERNDALE DEVELOPMENT STANDARDS.
- THE CONTRACTOR SHALL SCHEDULE A PRE-CONSTRUCTION CONFERENCE WITH REPRESENTATIVES FROM THE CITY OF FERNDALE PUBLIC WORKS DEPARTMENT A MINIMUM OF THREE (3) WORKING DAYS PRIOR TO BEGINNING CONSTRUCTION.
- THE CONTRACTOR SHALL OBTAIN A REVOCABLE ENCROACHMENT PERMIT FROM THE CITY OF FERNDALE PRIOR TO COMMENCING WORK IN THE RIGHTS-OF-WAY.
- ALL OFF-SITE WORK AND ALL PUBLICLY MAINTAINED ON-SITE WORK MUST BE INSPECTED BY REPRESENTATIVES FROM THE CITY OF FERNDALE PUBLIC WORKS DEPARTMENT. THE CONTRACTOR SHALL CALL AT LEAST 24 HOURS IN ADVANCE FOR INSPECTIONS AS FOLLOWS:
 - PLACEMENT OF TEMPORARY EROSION CONTROL MEASURES.
 - PLACEMENT OF WATER LINE AND BACKFILLING OF WATER LINE WITHIN CITY OF FERNDALE EASEMENT OR ROAD RIGHT-OF-WAY.
 - PLACEMENT AND BACKFILLING OF PUBLICLY MAINTAINED UNDERGROUND UTILITIES, STORM SEWER AND SANITARY SEWER WITHIN EASEMENT OR ROAD RIGHT-OF-WAY.
 - PUBLIC ROADWAY GRADING AT:
 - COMPLETION OF SUBGRADE
 - COMPLETION OF BALLAST
 - COMPLETION OF CRUSHED SURFACING
 - POURING OF CURB/GUTTER AND SIDEWALK IN PUBLIC ROADWAY
 - ASPHALT PAVING IN PROGRESS IN PUBLIC ROADWAY
 - OVERALL INSPECTION FOR FINISHED SHOULDERS, DITCHES, PERMANENT SEEDING AND MONUMENT PLACEMENT.
 - END OF MAINTENANCE PERIOD.
- ALL PRIVATE IMPROVEMENTS WORK MUST BE INSPECTED BY THE ENGINEER OF RECORD OR A DESIGNATED PARTY UNDER THE ENGINEER OF RECORD'S SUPERVISION.
- ALL TESTING REQUIREMENTS FOR THE IMPROVEMENTS SHALL BE THE RESPONSIBILITY OF THE CONTRACTOR AND SHALL BE IN CONFORMANCE WITH THE CITY OF FERNDALE DEVELOPMENT STANDARDS AS FOLLOWS:
 - CURB/GUTTER, SIDEWALK, ROADWAY BASE, COMPACTION - MINIMUM 1 TEST EVERY 3 STATIONS, MIN. 2 TESTS PER CATEGORY.
 - CONCRETE CYLINDER COMPRESSION - 1 CYLINDER EVERY THIRD LOAD, MIN. 2 SAMPLES.
 - A.C. PAVING DENSITY
- TESTING OF NEW WATER, SEWER, AND STORM SEWER SYSTEMS SHALL NOT BE PERFORMED UNTIL ALL OTHER ADJACENT UTILITIES HAVE BEEN INSTALLED.
- UNDERGROUND UTILITIES ARE KNOWN TO EXIST IN THE AREA OF CONSTRUCTION. THE SHOWN LOCATION OF THE EXISTING UTILITIES IS APPROXIMATE. IT IS THE RESPONSIBILITY OF THE CONTRACTOR TO CONTACT THE UTILITY OWNERS FOR LOCATIONS AND FIELD VERIFY THESE LOCATIONS PRIOR TO CONSTRUCTION. THE CONTRACTOR SHALL NOTIFY THE ENGINEER PROMPTLY OF ANY CONFLICT. THE CONTRACTOR SHALL CONTACT UTILITY LOCATION SERVICE (1-800-424-5555) 48 HOURS PRIOR TO STARTING CONSTRUCTION.
- THE CONTRACTOR SHALL BE RESPONSIBLE FOR MAINTAINING THE INTEGRITY OF ALL ADJACENT UTILITIES WHICH INCLUDE BUT ARE NOT LIMITED TO: WATER, SEWER, STORM SEWER, POWER, TELEPHONE, CABLE TV, IRRIGATION, AND STREET LIGHTING. CONTRACTOR SHALL RESTORE ALL PRIVATE AND PUBLIC PROPERTY DISTURBED BY THE PROJECT UPON COMPLETION OF THE PROJECT.
- THE CONTRACTOR SHALL BE RESPONSIBLE FOR MAINTAINING ALL EROSION CONTROL MEASURES THROUGHOUT THE DURATION OF THE PROJECT. EXPOSED CUT AND FILL SLOPES SHALL BE SEED AND FERTILIZED FOR EROSION CONTROL. CONTRACTOR SHALL BE RESPONSIBLE FOR SLOPE EROSION UNTIL VEGETATION IS FIRMLY ESTABLISHED.
- THE CONTRACTOR SHALL MAINTAIN TRAFFIC CONTROL WHILE THE SITE IS UNDER CONSTRUCTION.
- A COPY OF THESE APPROVED PLANS MUST BE ON THE JOB SITE WHENEVER CONSTRUCTION IS IN PROGRESS.
- THE CONTRACTOR SHALL PROVIDE CERTIFIED AS BUILT DATA OF THE IMPROVEMENTS TO THE ENGINEER UPON COMPLETION OF THE PROJECT.
- THE ENGINEER SHALL PROVIDE CERTIFIED AS BUILT PLANS OF THE IMPROVEMENTS TO THE PUBLIC WORKS DEPARTMENT UPON COMPLETION OF THE PROJECT. THE ENGINEER OF RECORD SHALL AFFIX A STATEMENT ON THE AS-BUILT DRAWINGS THAT DEFINES WHICH IMPROVEMENTS WERE INSPECTED BY THE ENGINEER OF RECORD AND WHICH IMPROVEMENTS WERE INSPECTED BY THE CITY OF FERNDALE.
- POTABLE WATER IS TO BE PROVIDED BY THE CITY OF FERNDALE. ALL WATER MAINS, HYDRANTS, SERVICES, VALVES, AND ASSORTED APPURTENANCES SHALL BE INSTALLED IN ACCORDANCE WITH CITY OF FERNDALE DEVELOPMENT STANDARDS AND PLANS.
- ALL WATER MAIN PIPE SHALL HAVE A MINIMUM COVER OF 3.5 FEET.
- CONNECTION TO EXISTING CITY WATER SYSTEM SHALL BE A HOT TAP COMPLETED BY THE CONTRACTOR IN THE PRESENCE OF THE CITY INSPECTOR.
- THE CONTRACTOR MUST NOTIFY THE FERNDALE PUBLIC WORKS DIRECTOR OF A PROPOSED CONNECTION AT LEAST FOUR WORKING DAYS IN ADVANCE.
- ALL HYDROSTATIC TESTING AND DISINFECTION OF WATER MAINS SHALL CONFORM TO SECTIONS 7-11.3(11) AND 7-11.3(12) OF THE WASHINGTON STATE DEPARTMENT OF TRANSPORTATION STANDARD SPECIFICATIONS FOR ROAD, BRIDGE AND MUNICIPAL CONSTRUCTION - CURRENT EDITION. HYDROSTATIC TESTING INSPECTED BY CITY.
- STORM PIPE SHALL BE CORRUGATED POLYETHYLENE PIPE (CPEP) AND SHALL CONFORM TO WSDOT STANDARD SPECIFICATION 9-05.20.
- CONTRACTOR SHALL RIP-RAP ALL CULVERT INLETS AND OUTLETS.
- CLEANOUTS SHALL BE INSTALLED ACCORDING TO CITY OF FERNDALE STANDARD DETAIL SS-5. MANHOLES SHALL BE CHANNLED.
- PIPE BEDDING SHALL BE PLACED IN ACCORDANCE WITH CITY OF FERNDALE DETAIL SS-1.
- SIDE SEWER INSTALLATION SHALL CONFORM TO CITY OF FERNDALE STANDARD DETAILS SS THROUGH SS-8. DOUBLE SERVICES SHALL CONFORM TO CITY OF FERNDALE DETAIL SS-1.
- CONTRACTOR SHALL INFORM THE ENGINEER AND OBTAIN APPROVAL FROM THE CITY OF FERNDALE PUBLIC WORKS DEPT. OF ANY PROPOSED CHANGES IN PLAN PRIOR TO CONSTRUCTION OF THAT CHANGE. CONTRACTOR SHALL KEEP RECORD OF DEVIATIONS AND FORWARD TO THE ENGINEER AND THE CITY OF FERNDALE.
- DEVELOPER/CONTRACTOR SHALL POST A MAINTENANCE SECURITY AS REQUIRED BY THE CITY OF FERNDALE.

NOTES

- EXISTING FIELD DATA PER LARRY STEELE & ASSOCIATES.
- ALL CONSTRUCTION SHALL BE IN ACCORDANCE WITH CITY OF FERNDALE STANDARDS AND CURRENT WSDOT/APWA STANDARD SPECIFICATIONS FOR ROAD, BRIDGE, AND MUNICIPAL CONSTRUCTION.


AS-BUILT DRAWING CERTIFICATION

I hereby certify that a representative sample of the improvements in the Malloy Village PUD have been inspected by Millennium Engineering Group, Inc. and constructed in conformance with the plans approved by the Public Works Director for said development and the general specifications adopted by the City of Ferndale Department of Public Works.

DATUM
VERTICAL
NGVD 29 USING CITY OF FERNDALE MON. STATION #351
HORIZONTAL
CITY OF FERNDALE MONUMENT NETWORK

BASIS OF BEARINGS

WASHINGTON STATE NORTH ZONE NAD 83/91 COORDINATES
USING CITY OF FERNDALE MONUMENTS
STATIONS #343 AND #351

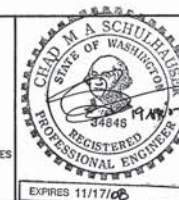

MILLENNIUM
Engineering Group, Inc.

109-6th ST., PO BOX 137, LYNDEN, WA 98264
PH: (360) 354-8141 FAX: (360) 354-3744
mail@2001egi.com www.2001egi.com

MALLOY VILLAGE PUD



COVER SHEET

FOR
MALLOY VILLAGE LLC

PTN. SW1/4, SEC.17, T39N, R2E, W.M.
CITY OF FERNDALE, WHATCOM COUNTY, WASHINGTON

SCALE: N/A
DATE: 07/17/08
DRAWN BY: CMAS
REVIEWED: 04/19/08
1 OF 4
JOB NUMBER: 03062

CALL BEFORE
YOU DIG
1-800-424-5555

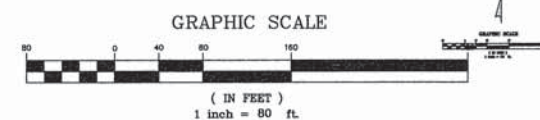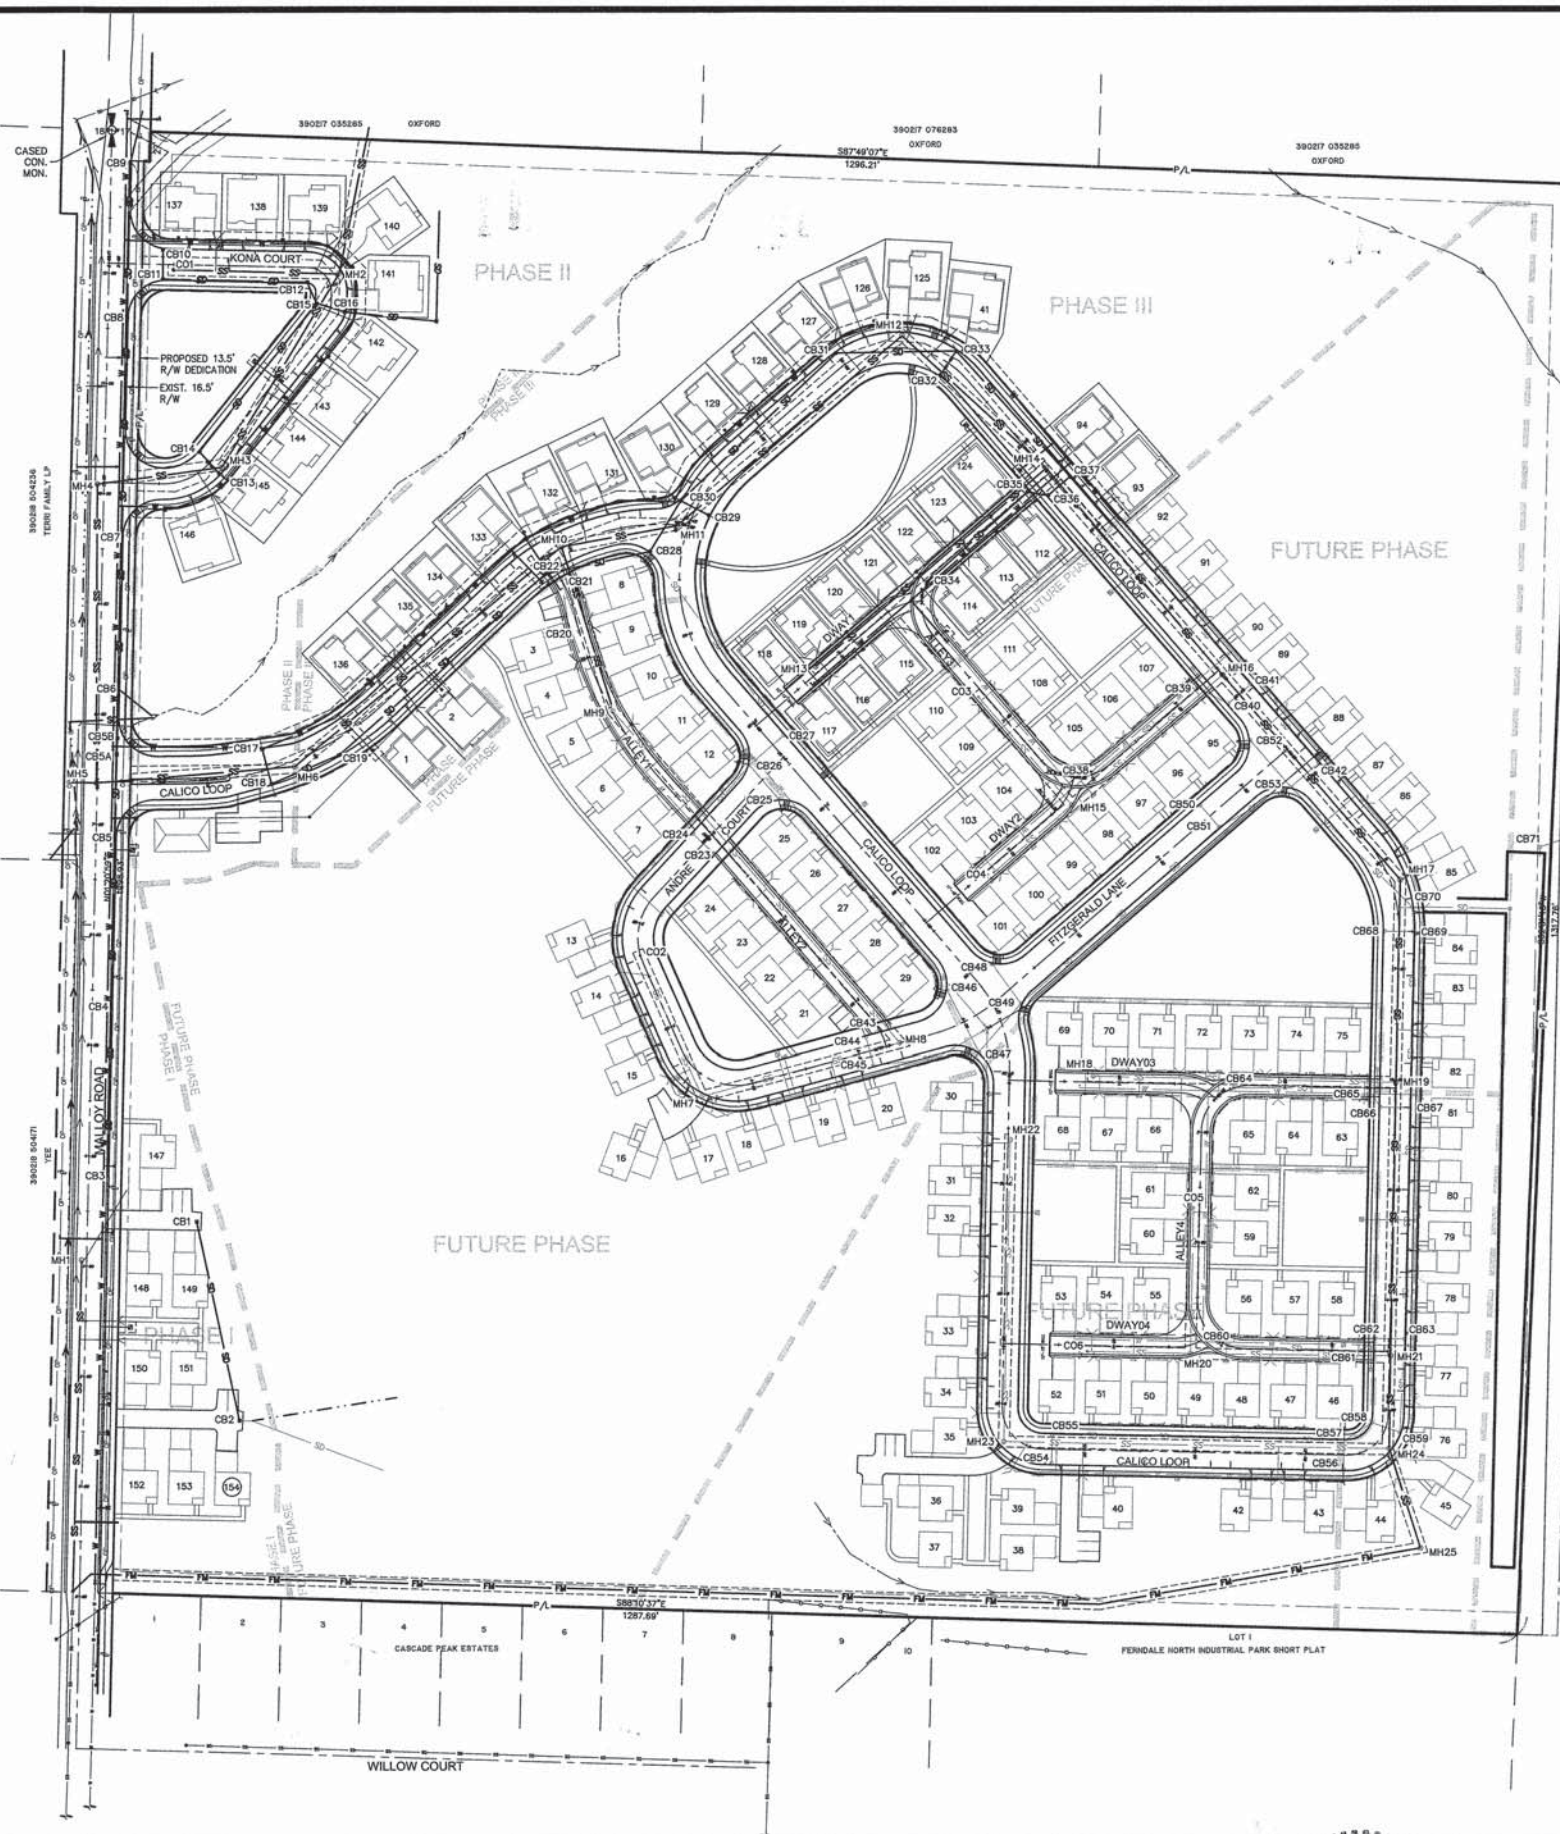

POSITIVE LOT DRAINAGE:

ALL LOTS SHALL HAVE POSITIVE LOT DRAINAGE. LOTS 8-12, 21-29, 42-84, 95-124, AND 126-139 SHALL DRAIN TO THE ROOF/YARD DRAIN SYSTEM CONSTRUCTED BEHIND THE SIDEWALK AS SHOWN ON SHEETS 9 THRU 20. LOTS 1-7, 13-20, 30-41, 85-94, 125, AND 140-154 SHALL DISCHARGE ROOF AND YARD DRAINS DIRECTLY TO ADJACENT WETLANDS IN ORDER TO MAINTAIN THE HYDROLOGY OF THE ON-SITE WETLANDS.

**CALL BEFORE
YOU DIG**
1-800-424-5555

NOTES


- EXISTING FIELD DATA PER LARRY STEELE & ASSOCIATES.
- ALL CONSTRUCTION SHALL BE IN ACCORDANCE WITH CITY OF FERDALE STANDARDS AND CURRENT WSDOT/APWA STANDARD SPECIFICATIONS FOR ROAD, BRIDGE, AND MUNICIPAL CONSTRUCTION.

AS-BUILT DRAWING CERTIFICATION

I hereby certify that a representative sample of the improvements in the Malloy Village PUD have been inspected by Millennium Engineering Group, Inc. and constructed in conformance with the plans approved by the Public Works Director for said development and the general specifications adopted by the City of Ferndale Department of Public Works.

DATUM
VERTICAL:
NGVD 29 USING CITY OF FERDALE MON. STATION #351
HORIZONTAL:
CITY OF FERDALE MONUMENT NETWORK

BASIS OF BEARINGS
WASHINGTON STATE NORTH ZONE NAD 83/91 COORDINATES
USING CITY OF FERDALE MONUMENTS
STATIONS #343 AND #351

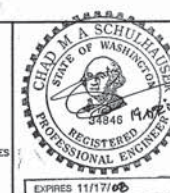

MILLENNIUM
Engineering Group, Inc.



109-6th ST., PO BOX 137, LYNDEN, WA 98264
PH: (360) 354-8141 FAX: (360) 354-3744
mail@2001egi.com www.2001egi.com

MALLOY VILLAGE PUD
SITE UTILITY PLAN

FOR
MALLOY VILLAGE LLC
PTN. SW1/4, SEC.17, T39N, R2E, W.M.
CITY OF FERDALE, WHATCOM COUNTY, WASHINGTON

SCALE: 1" = 80'
DATE: 07/17/06
DRAWN BY: CMAS
REVIEWED: 04/19/07
SHEET: 5 OF 4
JOB NUMBER: 0306

FEB 11 2003
Robert C. [Signature]
CITY OF FERDALE

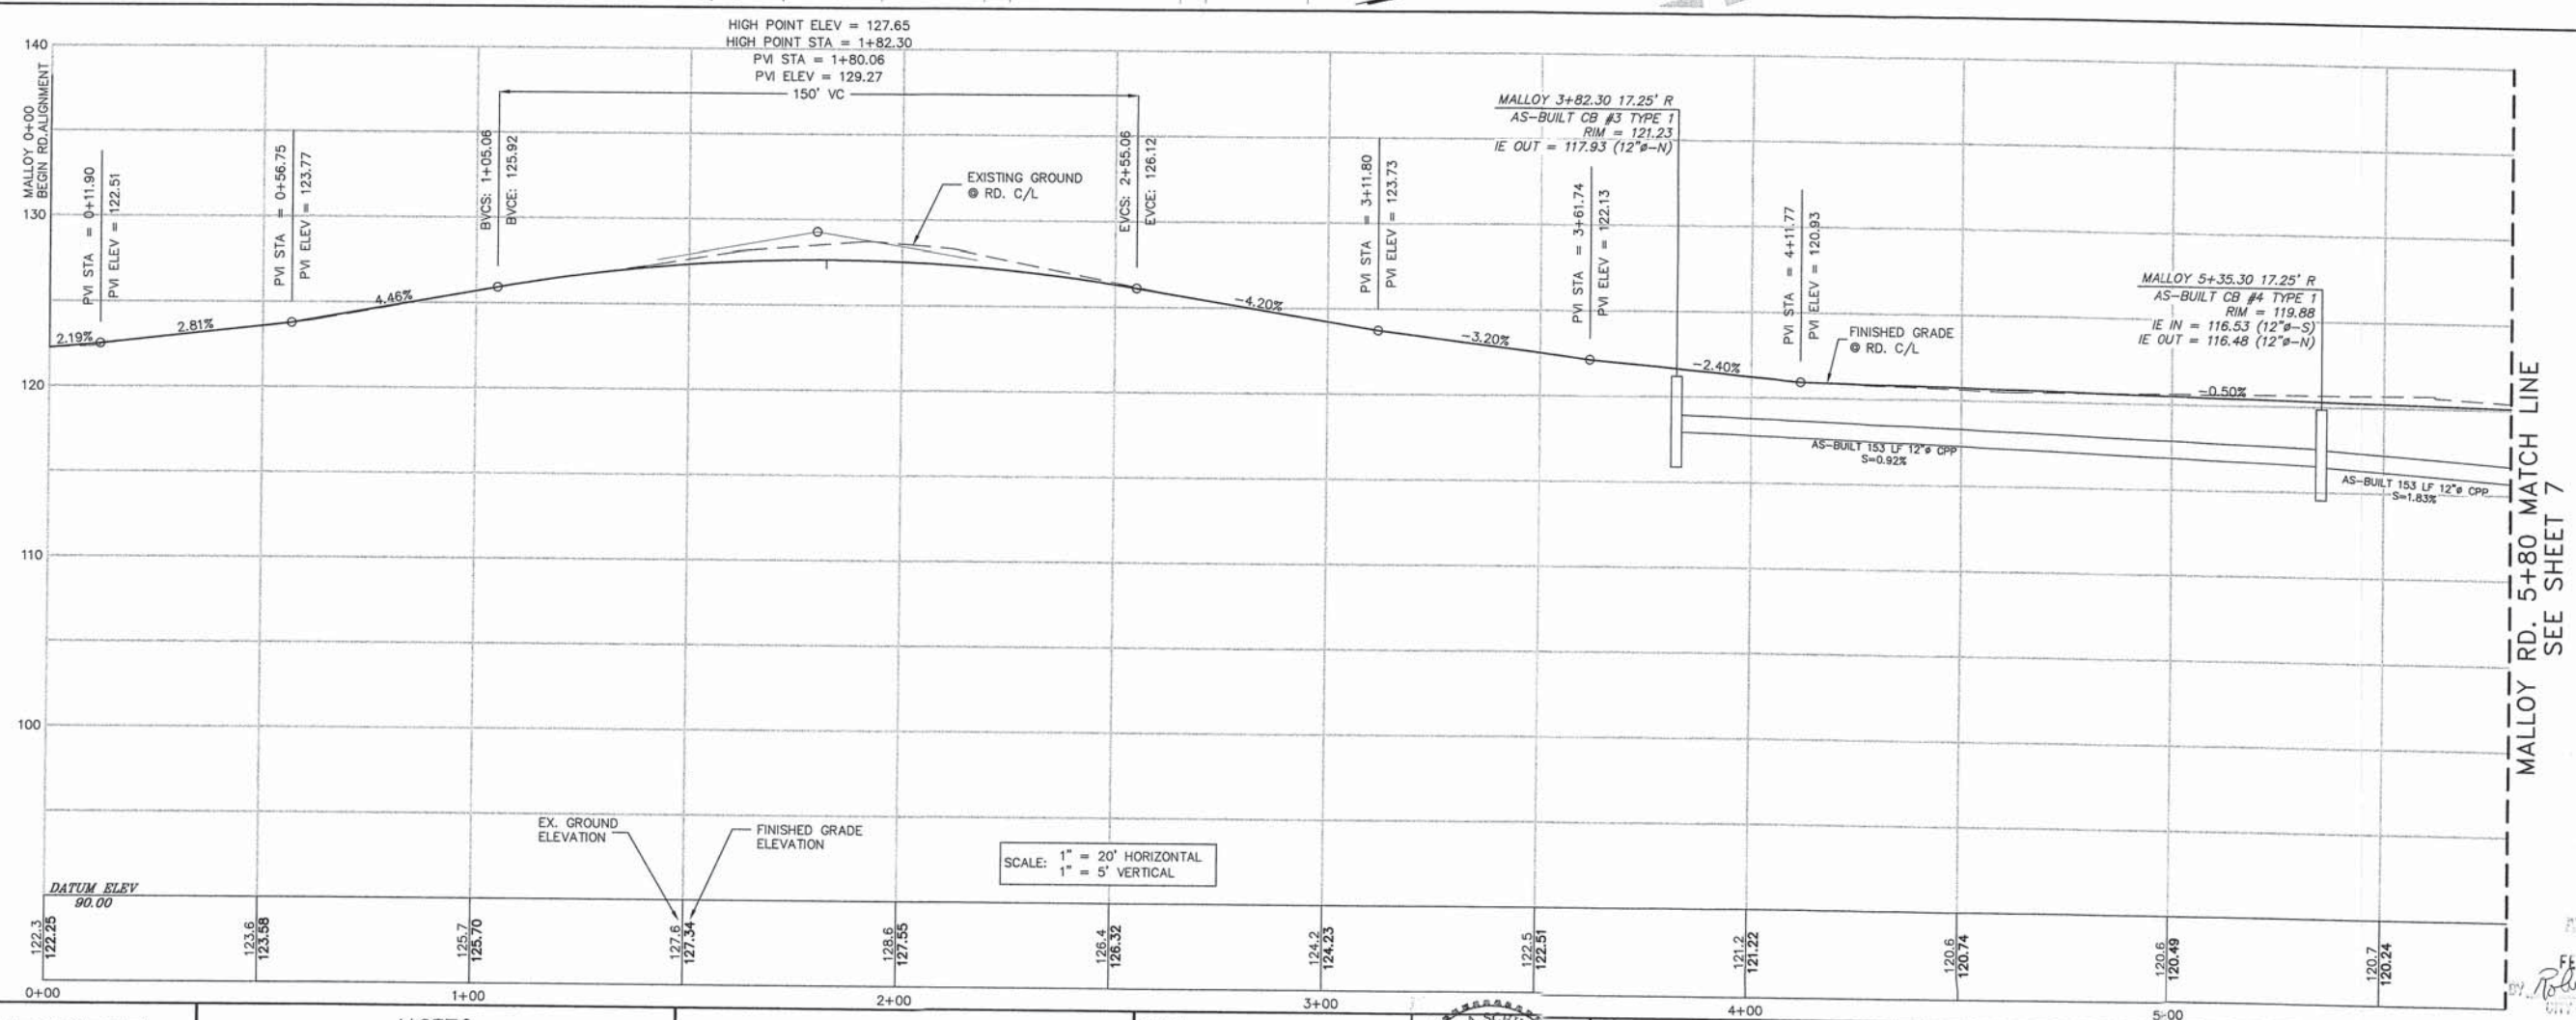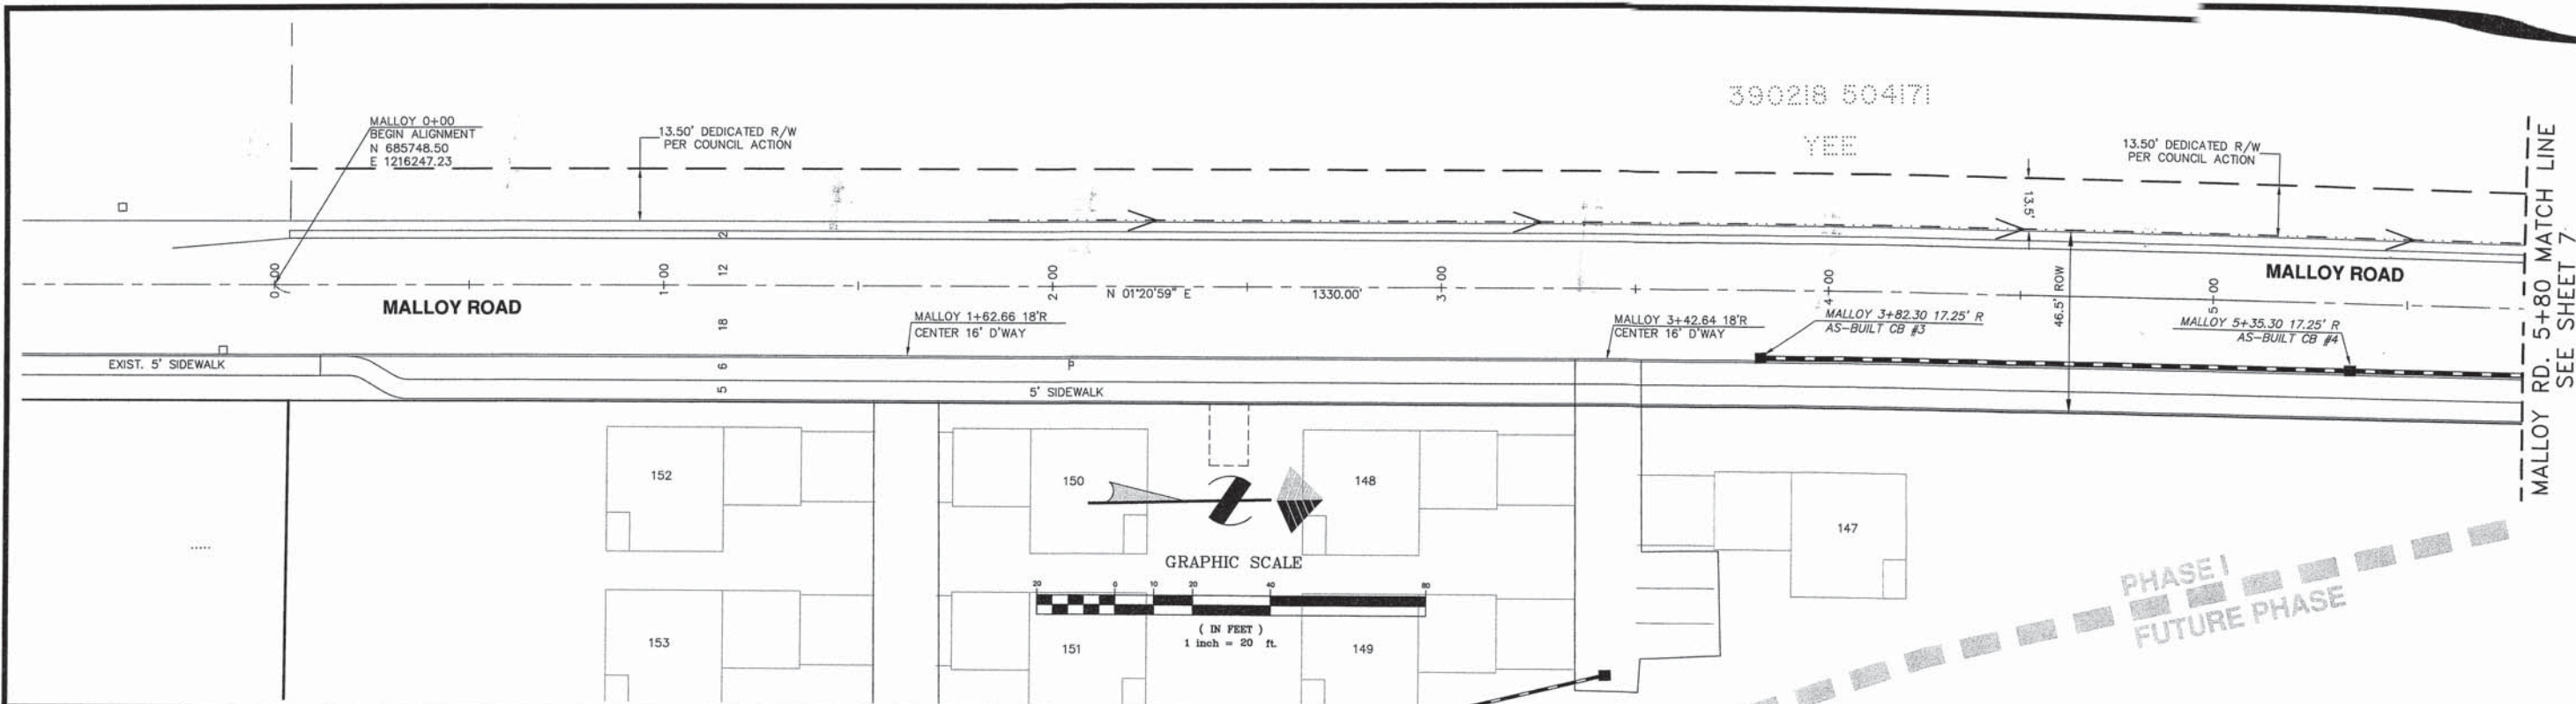

**CALL BEFORE
YOU DIG**

1-800-424-5555

NOTES

- EXISTING FIELD DATA PER LARRY STEELE & ASSOCIATES.
- ALL CONSTRUCTION SHALL BE IN ACCORDANCE WITH CITY OF FERDALE STANDARDS AND CURRENT WSDOT/APWA STANDARD SPECIFICATIONS FOR ROAD, BRIDGE, AND MUNICIPAL CONSTRUCTION.

AS-BUILT DRAWING CERTIFICATION

I hereby certify that a representative sample of the improvements in the Malloy Village PUD have been inspected by Millennium Engineering Group, Inc. and constructed in conformance with the plans approved by the Public Works Director for said development and the general specifications adopted by the City of Ferndale Department of Public Works.

DATUM
NAD 83 USING CITY OF FERDALE MON. STATION #351
HORIZONTAL
CITY OF FERDALE MONUMENT NETWORK

BASIS OF BEARINGS
WASHINGTON STATE NORTH ZONE NAD 83/91 COORDINATES
USING CITY OF FERDALE MONUMENTS
STATIONS #343 AND #351

MILLENNIUM
Engineering Group, Inc.

109-6th ST., PO BOX 137, LYNDEN, WA 98264
PH: (360) 354-8141 FAX: (360) 354-3744
mail@2001egi.com www.2001egi.com

MALLOY VILLAGE PUD
AS-BUILT
MALLOY RD. 0+00 - 5+80
STREET & STORM

FOR
MALLOY VILLAGE LLC

PTN. SW1/4, SEC.17, T39N, R2E, W.M.
CITY OF FERDALE, WHATCOM COUNTY, WASHINGTON


DATE: 07/17/06
DRAWN BY: CMAS
REVIEWED: 04/19/07

6 OF 42

JOB NUMBER:
03062


00531.003 12/19/12 SH

MALLOY RD. 5+80 MATCH LINE
SEE SHEET 6

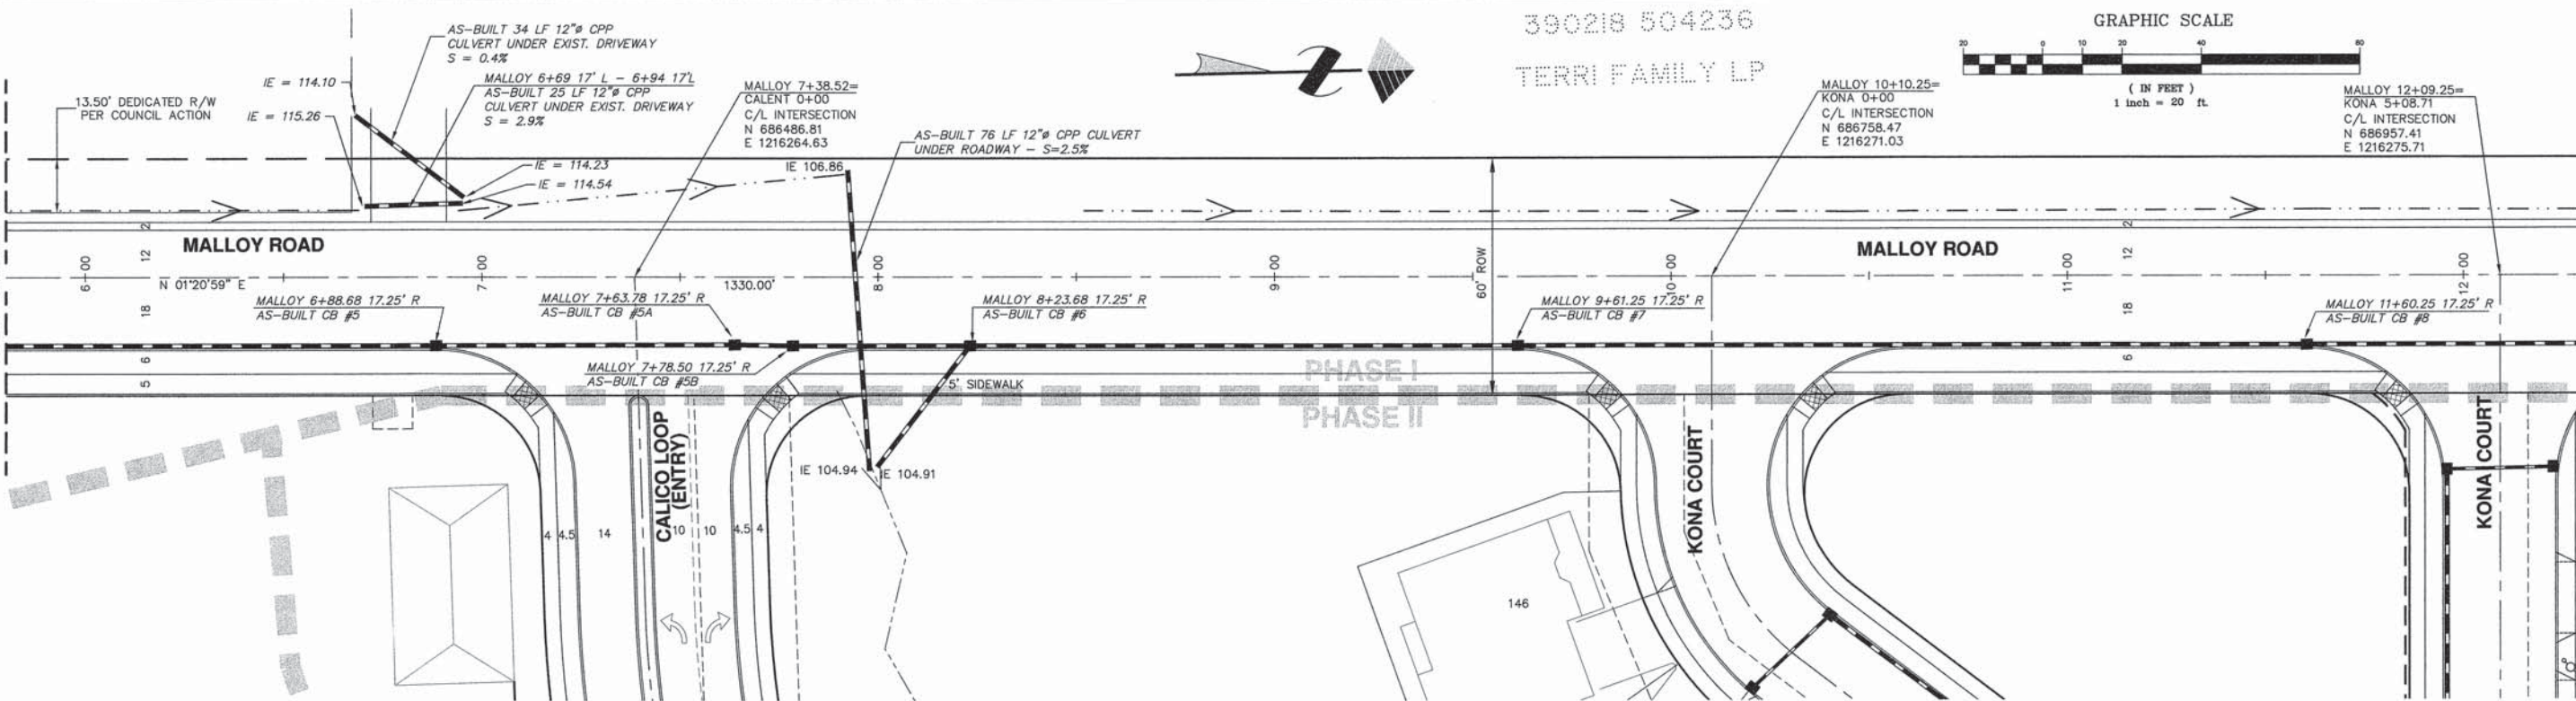

MALLOY RD. 12+30 MATCH LINE
SEE SHEET 8

MALLOY RD. 5+80 MATCH LINE
SEE SHEET 6

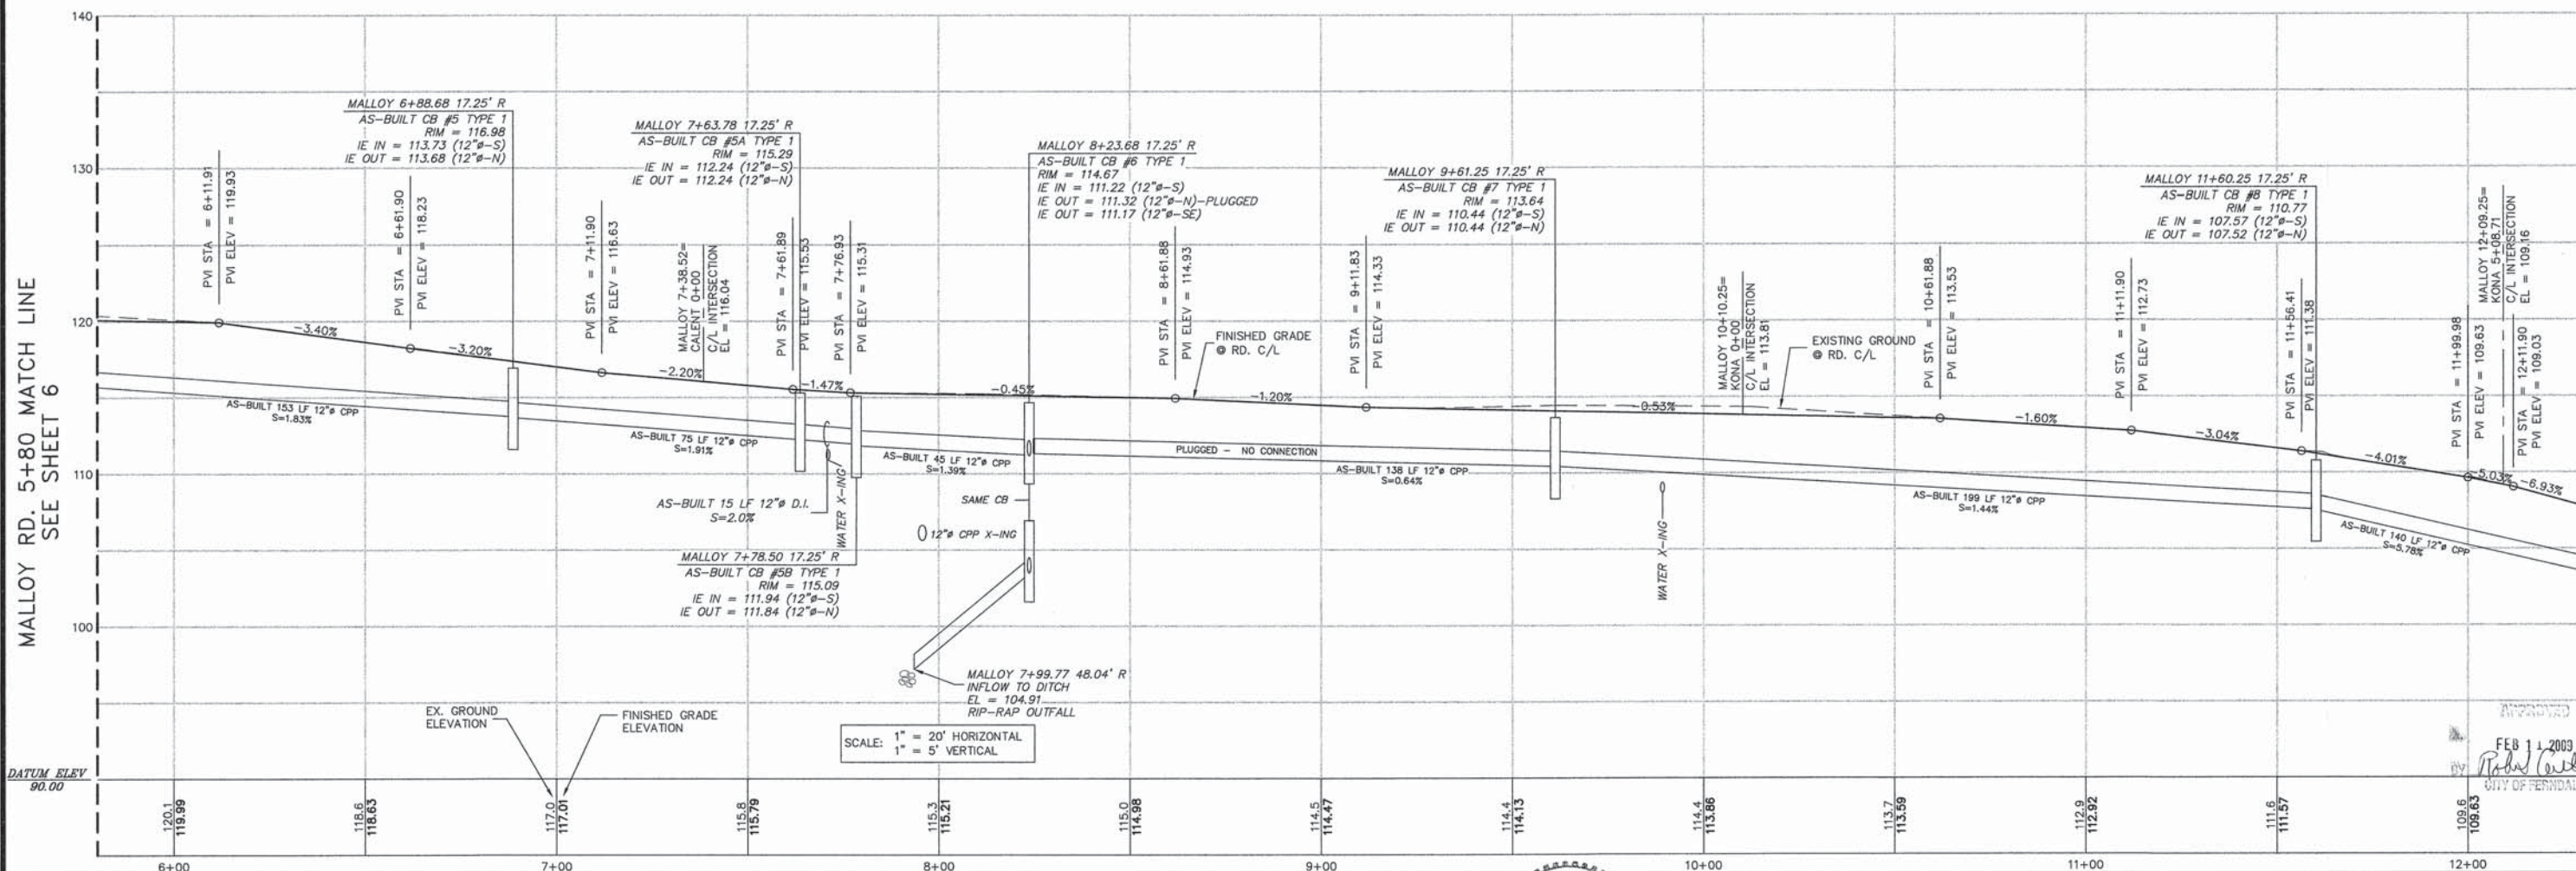

MALLOY RD. 12+30 MATCH LINE
SEE SHEET 8

CALL BEFORE
YOU DIG
1-800-424-5555


NOTES

- EXISTING FIELD DATA PER LARRY STEELE & ASSOCIATES.
- ALL CONSTRUCTION SHALL BE IN ACCORDANCE WITH CITY OF FERDALE STANDARDS AND CURRENT WSDOT/APWA STANDARD SPECIFICATIONS FOR ROAD, BRIDGE, AND MUNICIPAL CONSTRUCTION.

AS-BUILT DRAWING CERTIFICATION

I hereby certify that a representative sample of the Improvements in the Malloy Village PUD have been inspected by Millennium Engineering Group, Inc. and constructed in conformance with the plans approved by the Public Works Director for said development and the general specifications adopted by the City of Ferndale Department of Public Works.

DATUM
NAD 83
HORIZONTAL
CITY OF FERDALE MONUMENT NETWORK
BASIS OF BEARINGS
WASHINGTON STATE NORTH ZONE NAD 83/91 COORDINATES
USING CITY OF FERDALE MONUMENTS
STATIONS #543 AND #351


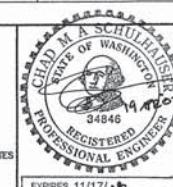


MILLENNIUM
Engineering Group, Inc.

109-6th ST., PO BOX 137, LYNDEN, WA 98264
PH: (360) 354-8141 FAX: (360) 354-3744
mail@2001egi.com www.2001egi.com

MALLOY VILLAGE FUD
AS-BUILT
MALLOY RD. 5+80 - 12+30
STREET & STORM
FOR
MALLOY VILLAGE LLC
PTN. SW1/4, SEC.17, T39N, R2E, W.M.
CITY OF FERDALE, WHATCOM COUNTY, WASHINGTON

SCALE: 1" = 20'
DATE: 07/17/06
DRAWN BY: CMAS
REVIEWED: 04/19/07
JOB NUMBER:
03062

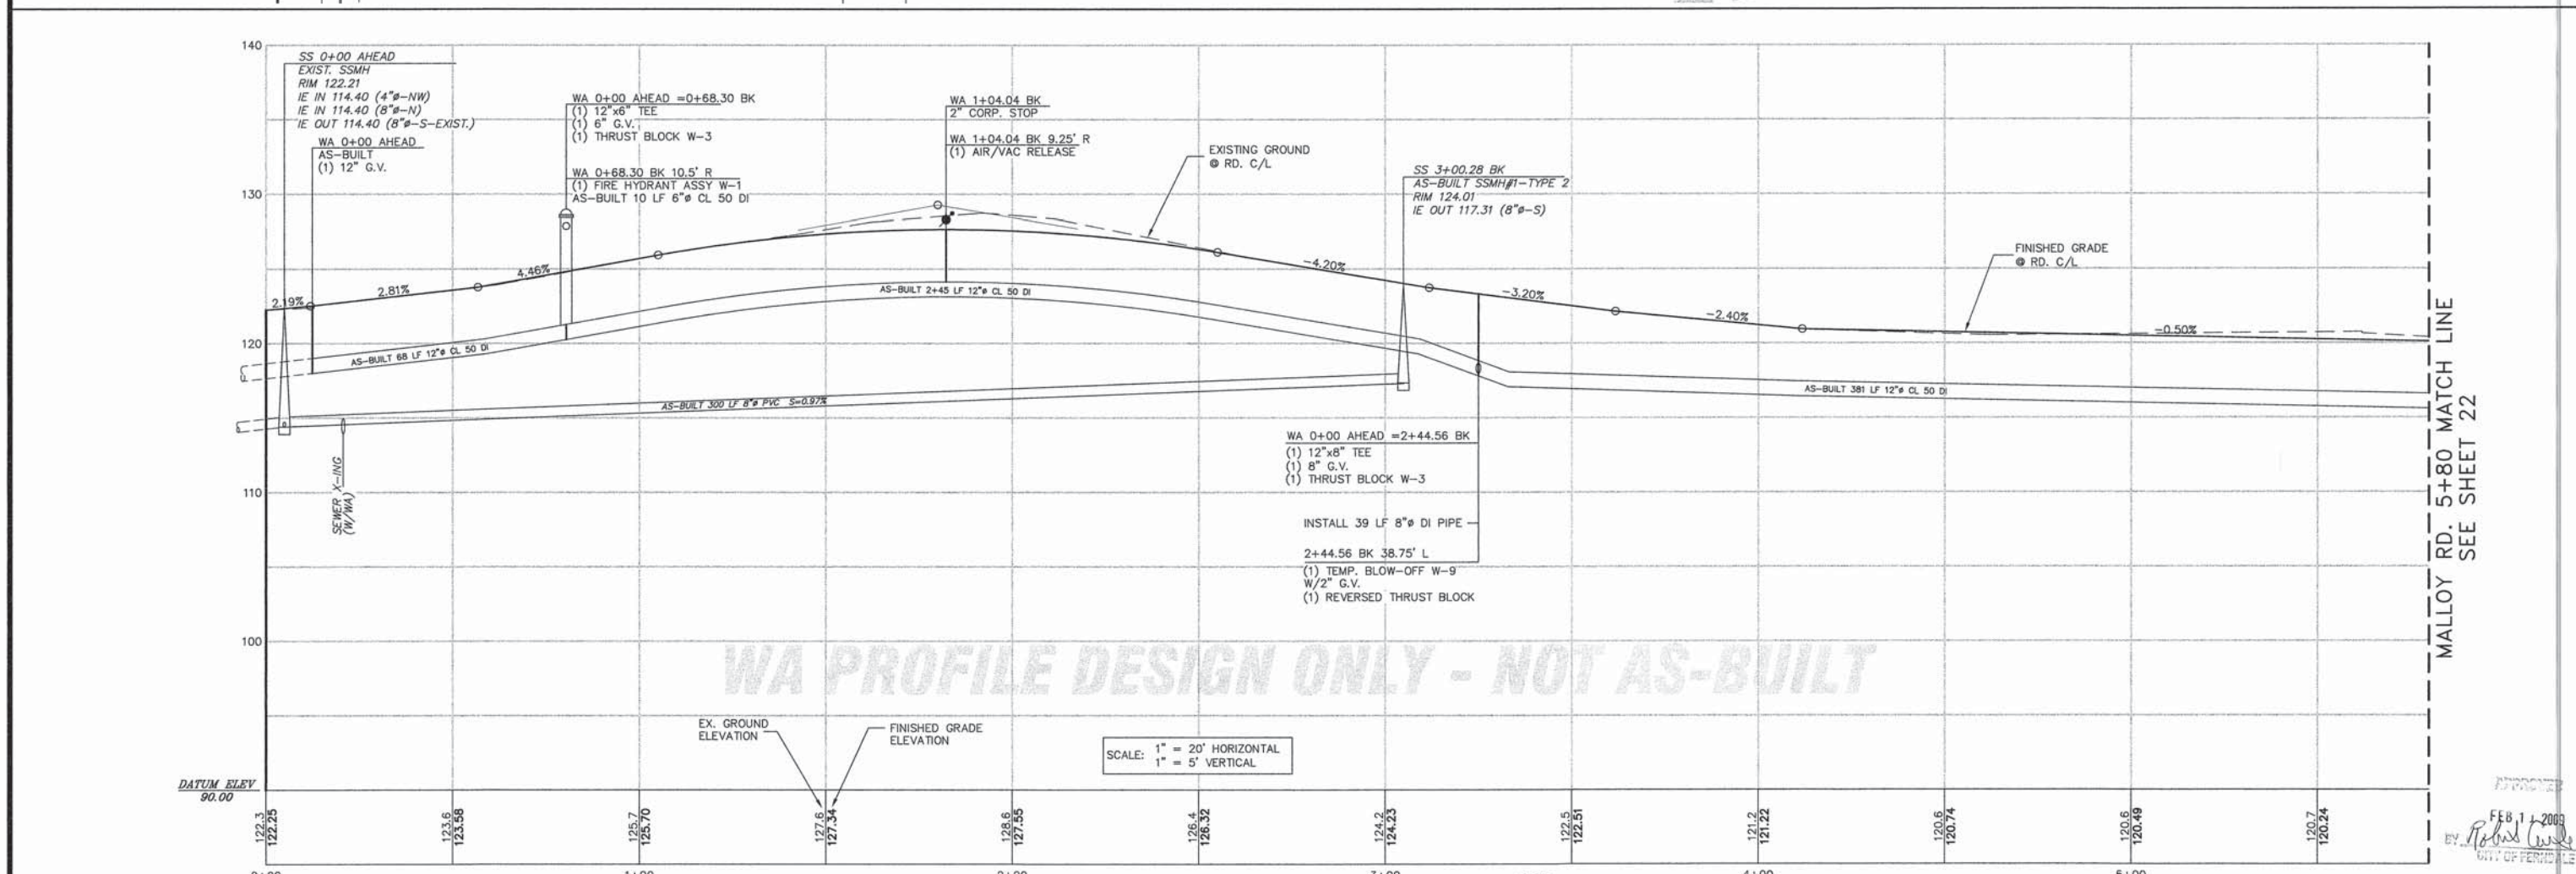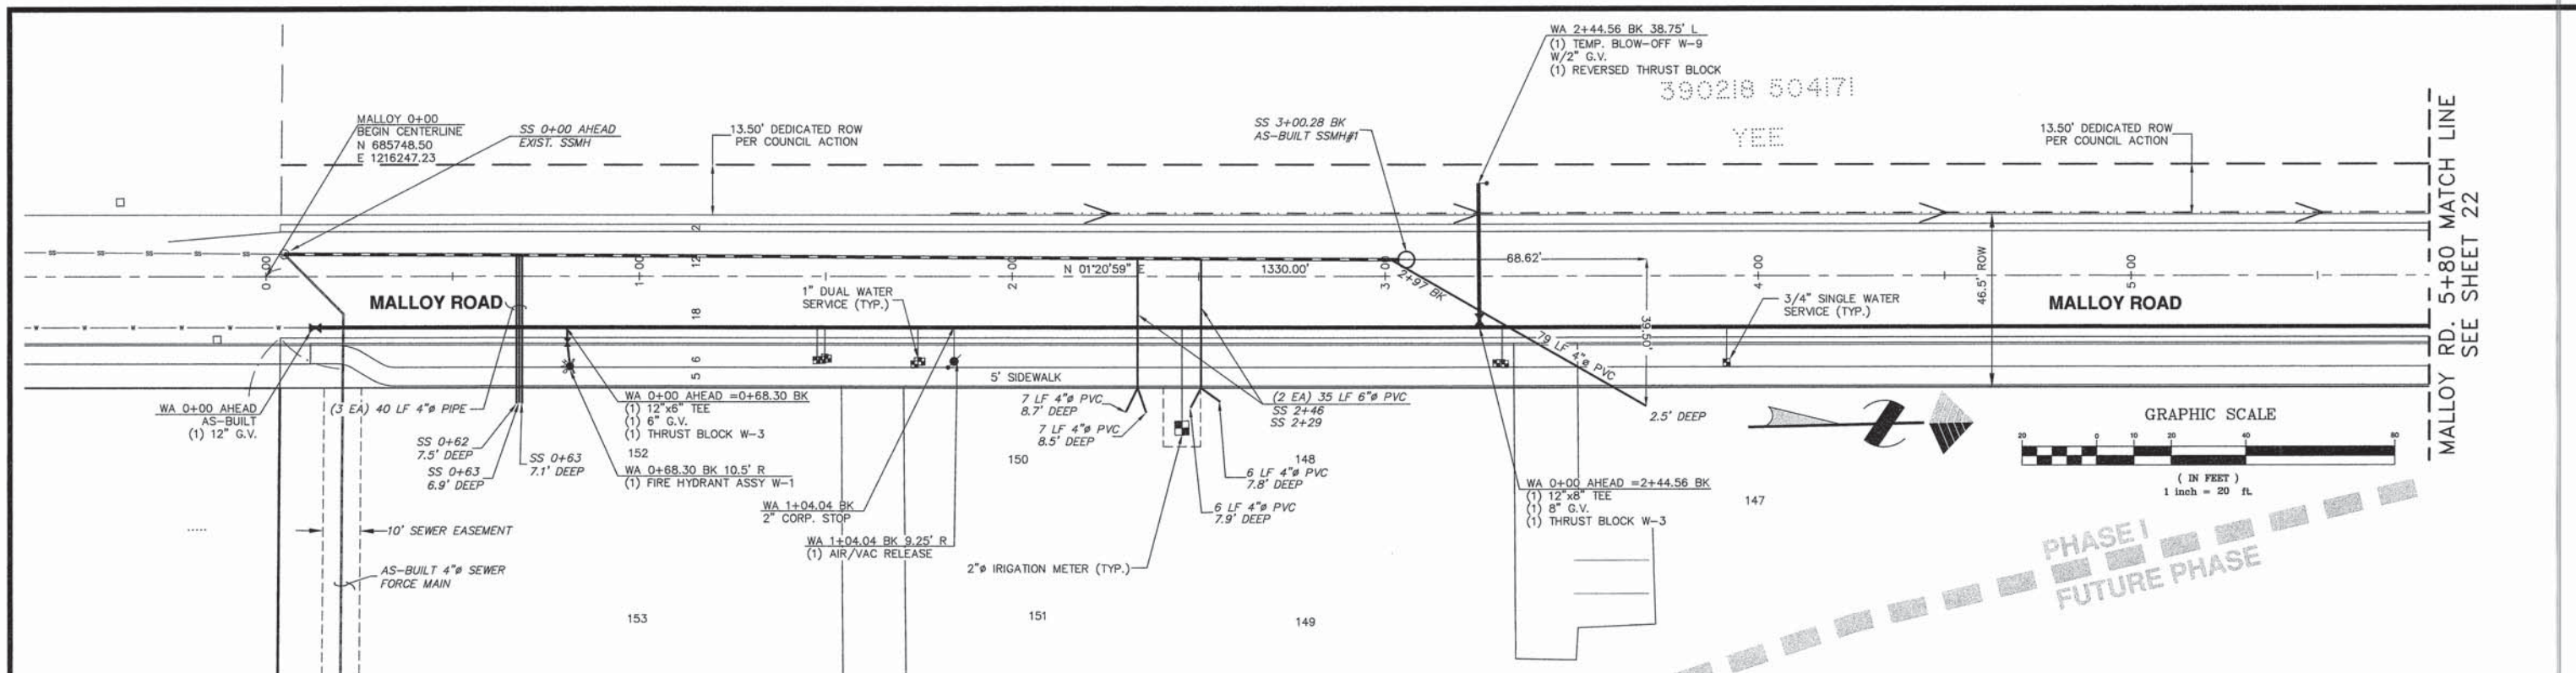

**CALL BEFORE
YOU DIG**
1-800-424-5555

NOTES


- EXISTING FIELD DATA PER LARRY STEELE & ASSOCIATES.
- ALL CONSTRUCTION SHALL BE IN ACCORDANCE WITH CITY OF FERDALE STANDARDS AND CURRENT WSDOT/APWA STANDARD SPECIFICATIONS FOR ROAD, BRIDGE, AND MUNICIPAL CONSTRUCTION.

AS-BUILT DRAWING CERTIFICATION

I hereby certify that a representative sample of the improvements in the Malloy Village PUD have been inspected by Millennium Engineering Group, Inc. and constructed in conformance with the plans approved by the Public Works Director for said development and the general specifications adopted by the City of Ferndale Department of Public Works.

DATUM
VERTICAL
NOVD 29 USING CITY OF FERDALE MON. STATION #351
HORIZONTAL
CITY OF FERDALE MONUMENT NETWORK

BASIS OF BEARINGS
WASHINGTON STATE NORTH ZONE NAD 83/91 COORDINATES
USING CITY OF FERDALE MONUMENTS
STATIONS #343 AND #351

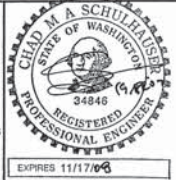

MILLENNIUM
Engineering Group, Inc.

109-6th ST., PO BOX 137, LYNDEN, WA 98264
PH: (360) 354-8141 FAX: (360) 354-3744
mail@2001egi.com www.2001egi.com

MALLOY VILLAGE PUD
AS-BUILT
MALLOY RD. 0+00 - 5+80
SEWER & WATER


FOR
MALLOY VILLAGE LLC

PTN. SW1/4, SEC.17, T39N, R2E, W.M.
CITY OF FERDALE, WHATCOM COUNTY, WASHINGTON

SCALE: 1" = 20'
DATE: 07/17/06
DRAWN BY: CMAS
REVIEWED: 04/19/07
21 OF 42
JOB NUMBER: 03062

00531.006 12/19/12 SH


MALLOY RD. 5+80 MATCH LINE
SEE SHEET 21

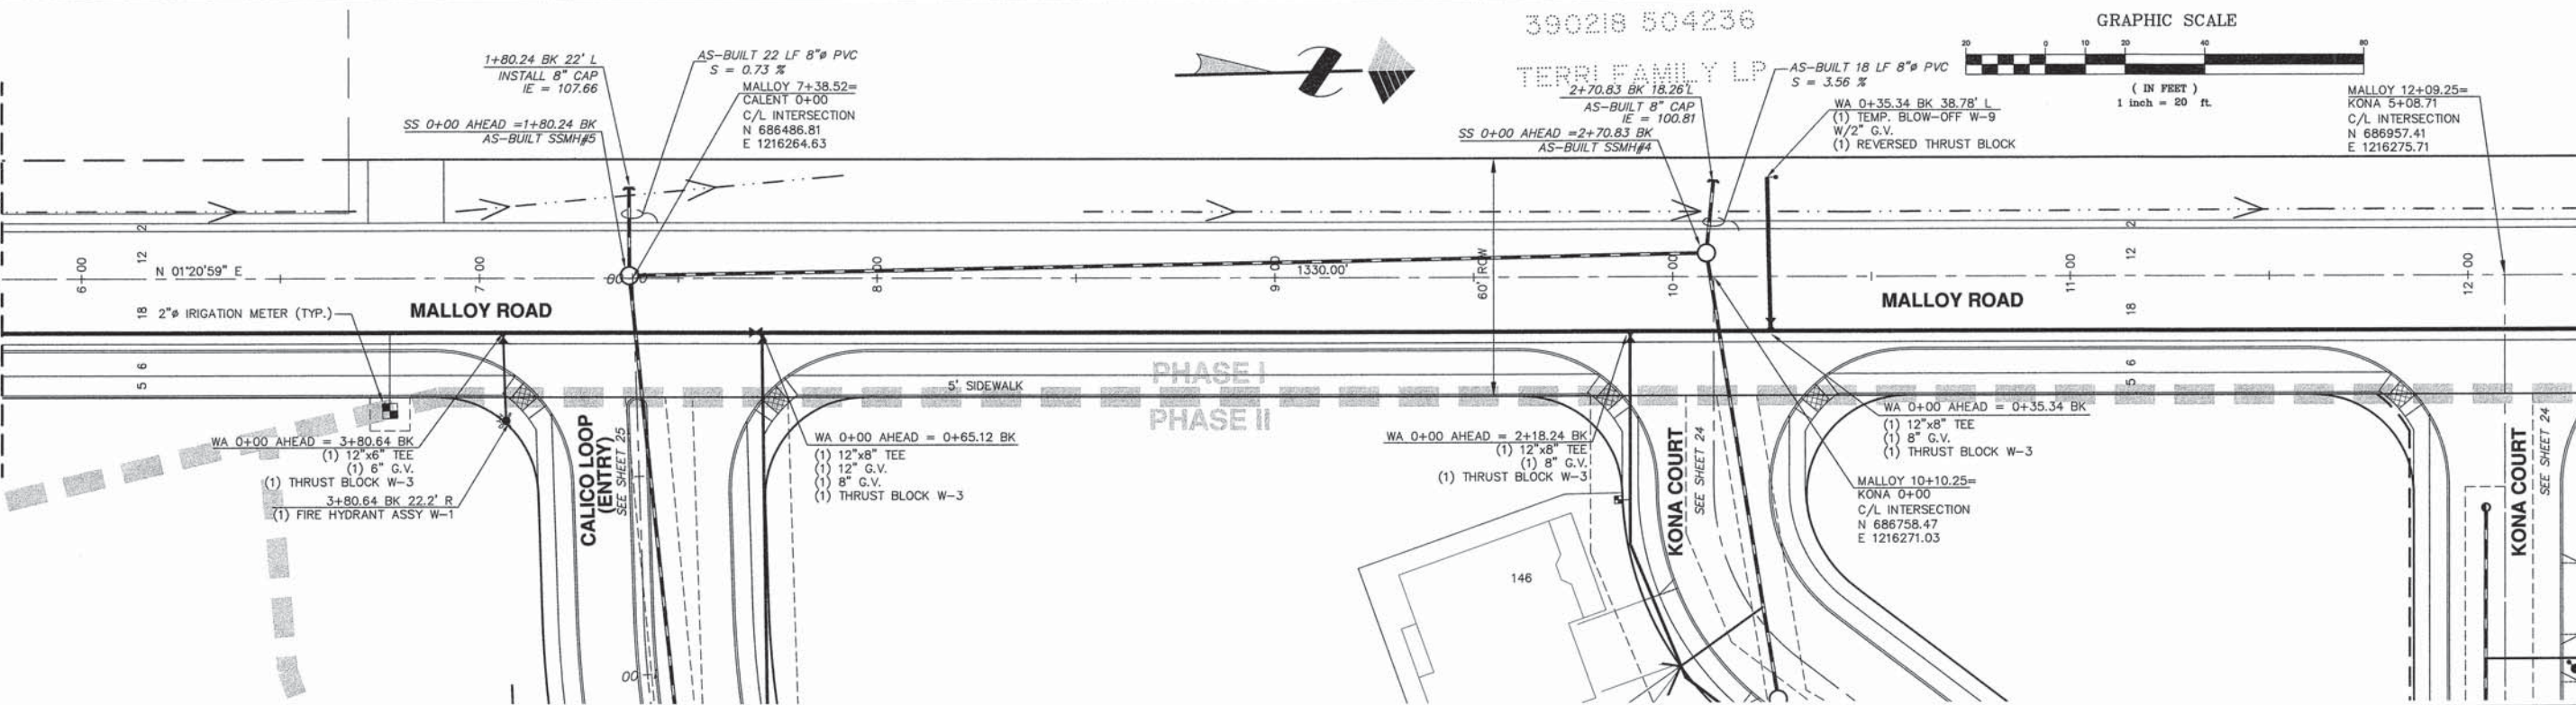

390218 504236

TERRELL FAMILY LP

 
GRAPHIC SCALE



MALLOY 12+09.25=
KONA 5+08.71
C/L INTERSECTION
N 686957.41
E 1216275.71

MALLOY RD. 12+30 MATCH LINE
SEE SHEET 23

MALLOY RD. 5+80 MATCH LINE
SEE SHEET 21

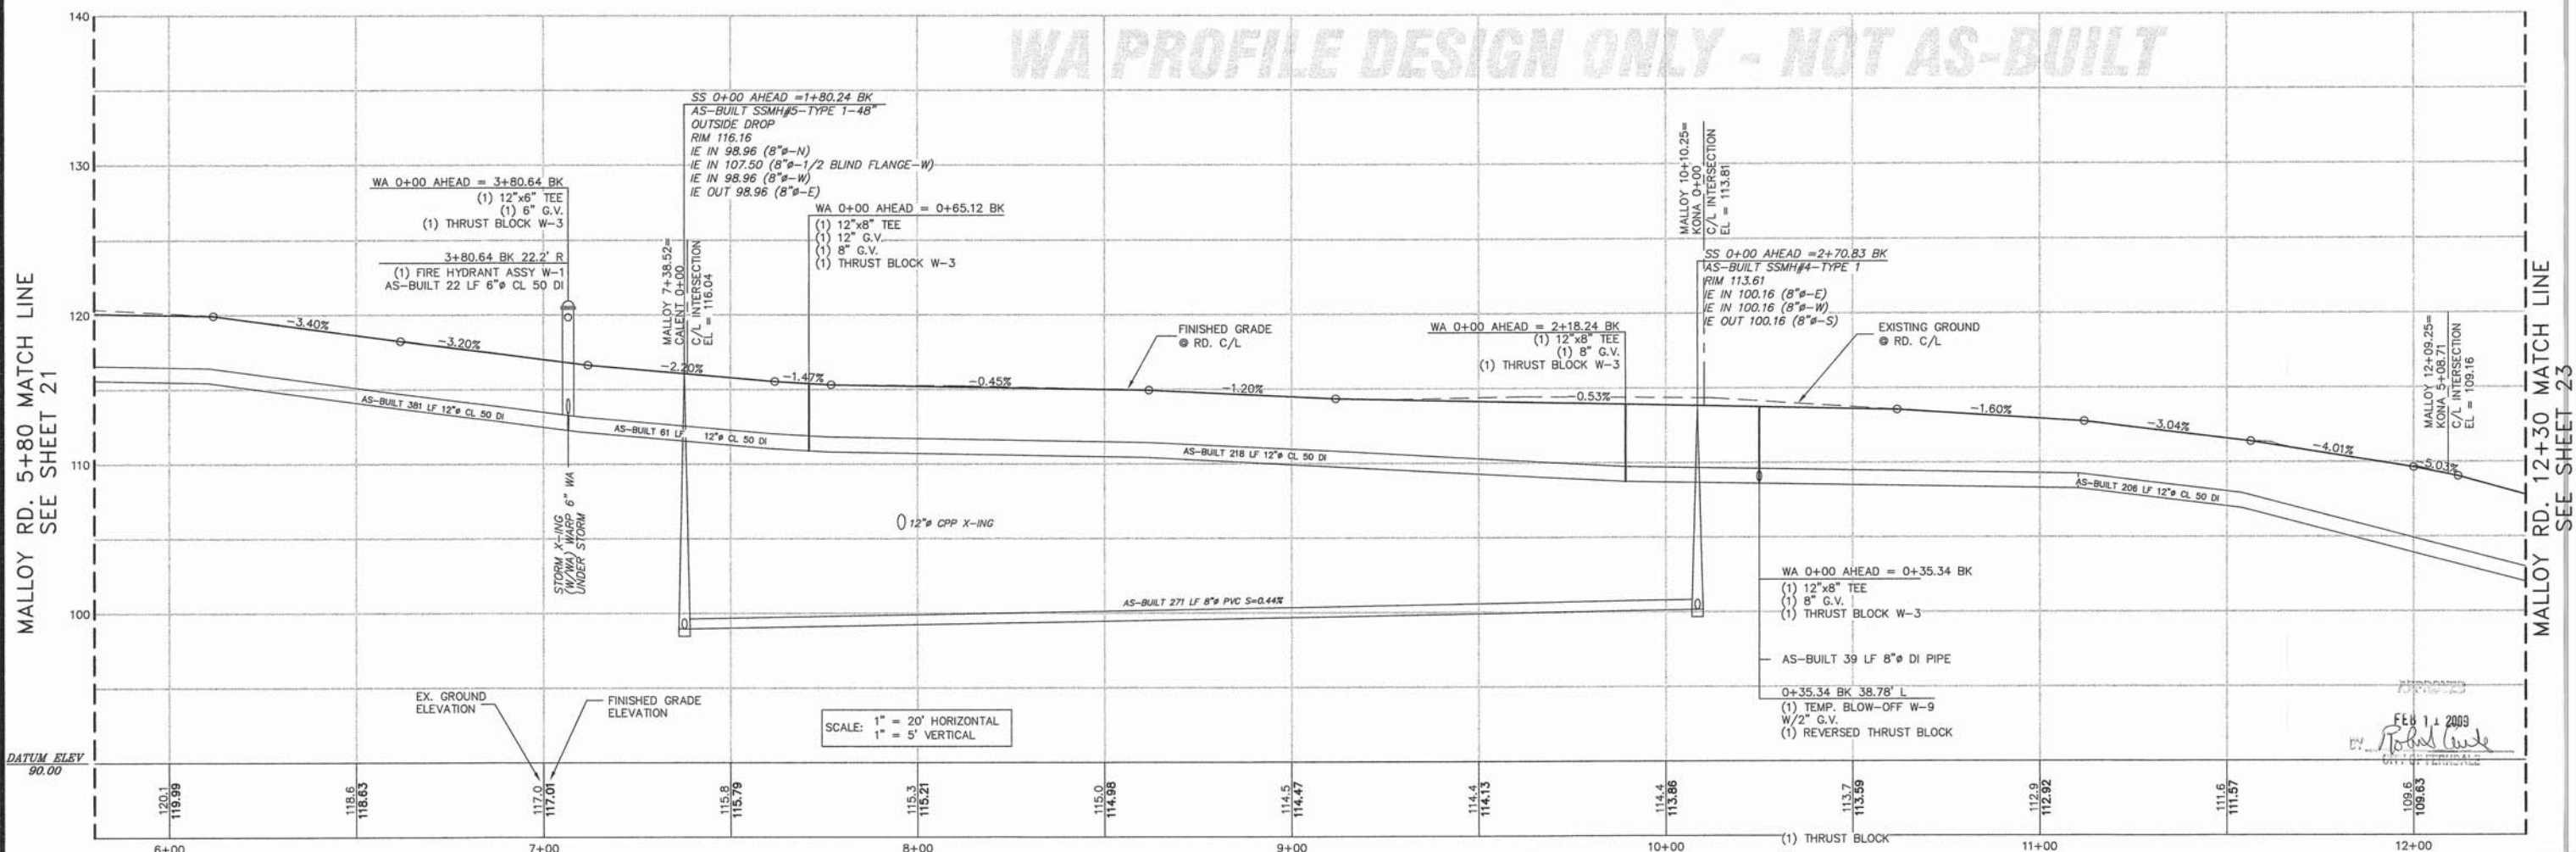

WA PROFILE DESIGN ONLY - NOT AS-BUILT

MALLOY RD. 12+30 MATCH LINE
SEE SHEET 23

CALL BEFORE
YOU DIG
1-800-424-5555


NOTES

- EXISTING FIELD DATA PER LARRY STEELE & ASSOCIATES.
- ALL CONSTRUCTION SHALL BE IN ACCORDANCE WITH CITY OF FERDALE STANDARDS AND CURRENT WSDOT/APWA STANDARD SPECIFICATIONS FOR ROAD, BRIDGE, AND MUNICIPAL CONSTRUCTION.

AS-BUILT DRAWING CERTIFICATION

I hereby certify that a representative sample of the improvements in the Malloy Village PUD have been inspected by Millennium Engineering Group, Inc. and constructed in conformance with the plans approved by the Public Works Director for solid development and the general specifications adopted by the City of Ferndale Department of Public Works.

DATUM
VERTICAL
NOVO 29 USING CITY OF FERDALE MON. STATION #351
HORIZONTAL
CITY OF FERDALE MONUMENT NETWORK
BASIS OF BEARINGS
WASHINGTON STATE NORTH ZONE NAD 83/91 COORDINATES
USING CITY OF FERDALE MONUMENTS
STATIONS #343 AND #351

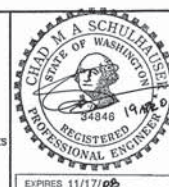

MILLENNIUM
Engineering Group, Inc.

109-6th ST., PO BOX 137, LYNDEN, WA 98264
PH: (360) 354-8141 FAX: (360) 354-3744
mail@2001egi.com www.2001egi.com



MALLOY VILLAGE PUD
AS-BUILT
MALLOY RD. 5+80 - 12+30
SEWER & WATER

FOR
MALLOY VILLAGE LLC


PTN. SW1/4, SEC.17, T39N, R2E, W.M.
CITY OF FERDALE, WHATCOM COUNTY, WASHINGTON

SCALE: 1" = 20'
DATE: 07/17/06
DRAWN BY: CMAS
REVIEWED: 04/19/07
SHEET:
22 OF 42
JOB NUMBER:
03062

MALLOY RD. 12+30 MATCH LINE
SEE SHEET 22

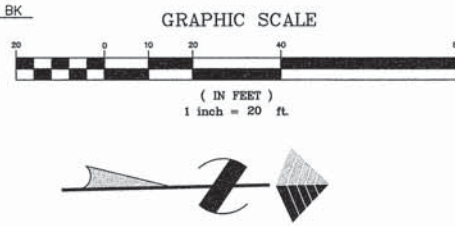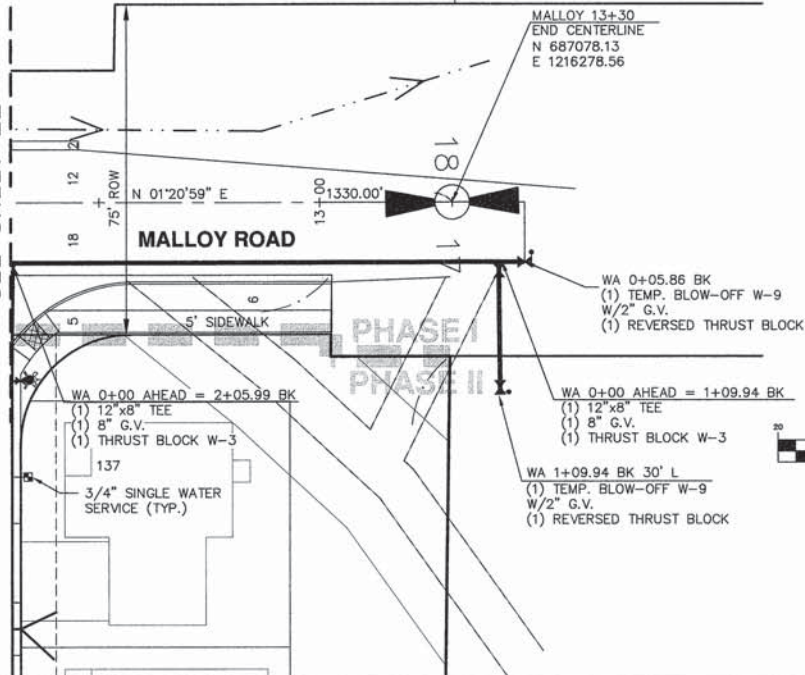

MALLOY RD. 12+30 MATCH LINE
SEE SHEET 22

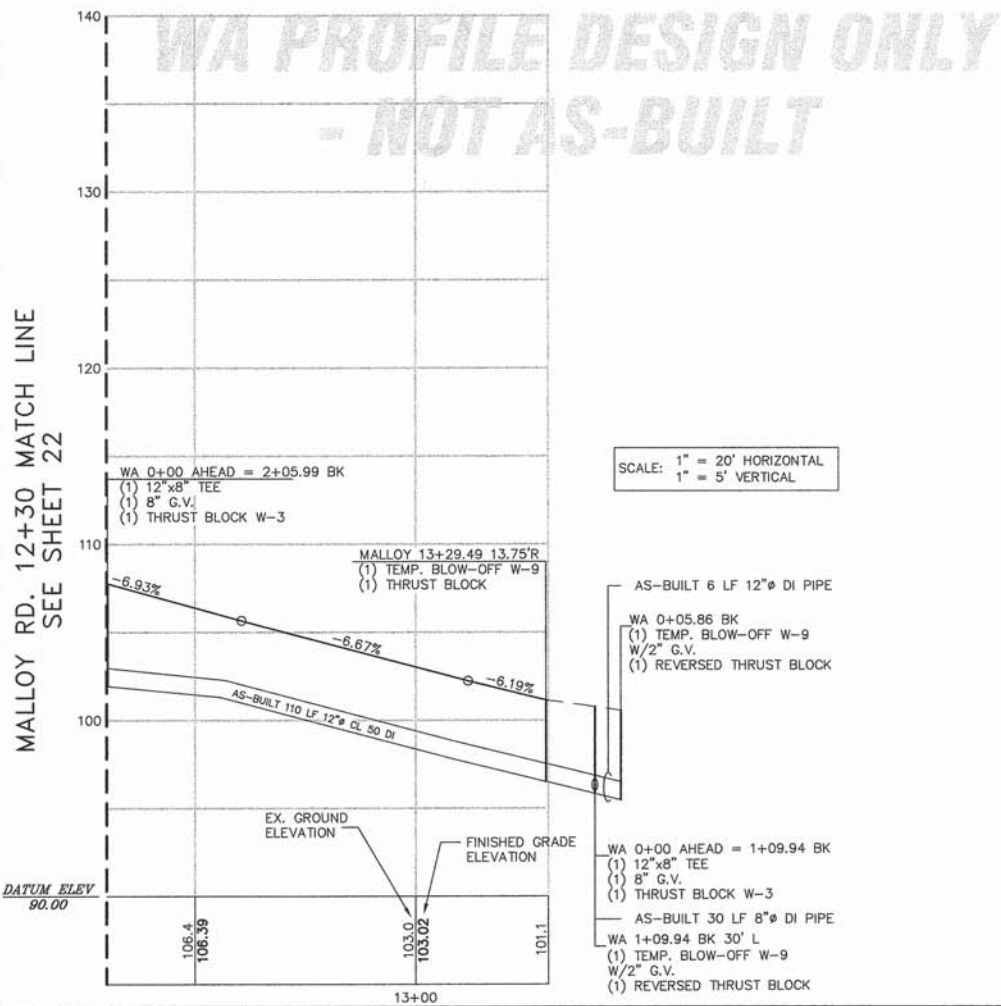

SCALE: 1" = 20' HORIZONTAL
1" = 5' VERTICAL

NOTES


- EXISTING FIELD DATA PER LARRY STEELE & ASSOCIATES.
- ALL CONSTRUCTION SHALL BE IN ACCORDANCE WITH CITY OF FERDALE STANDARDS AND CURRENT WSDOT/APWA STANDARD SPECIFICATIONS FOR ROAD, BRIDGE, AND MUNICIPAL CONSTRUCTION.

AS-BUILT DRAWING CERTIFICATION

I hereby certify that a representative sample of the improvements in the Malloy Village PUD have been inspected by Millennium Engineering Group, Inc. and constructed in conformance with the plans approved by the Public Works Director for said development and the general specifications adopted by the City of Ferndale Department of Public Works.

DATUM
VERTICAL:
NOVD 29 USING CITY OF FERDALE MON. STATION #301
HORIZONTAL:
CITY OF FERDALE MONUMENT NETWORK

BASIS OF BEARINGS
WASHINGTON STATE NORTH ZONE NAD 83/91 COORDINATES
USING CITY OF FERDALE MONUMENTS
STATIONS #343 AND #351

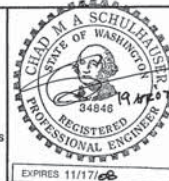

MILLENNIUM
Engineering Group, Inc.

109-6th ST., PO BOX 137, LYNDEN, WA 98264
PH: (360) 354-8141 FAX: (360) 354-3744
mail@2001egi.com www.2001egi.com


MALLOY VILLAGE PUD
AS-BUILT
MALLOY RD. 12+30 - END
SEWER & WATER

FOR
MALLOY VILLAGE LLC


PTN. SW1/4, SEC.17, T39N, R2E, W.M.
CITY OF FERDALE, WHATCOM COUNTY, WASHINGTON

SCALE: 1" = 20'
DATE: 07/17/06
DRAWN BY: CMAS
CHECKED: 04/19/07
SHEET: **23 OF 42**
JOB NUMBER: 03062

**CALL BEFORE
YOU DIG
1-800-424-5555**

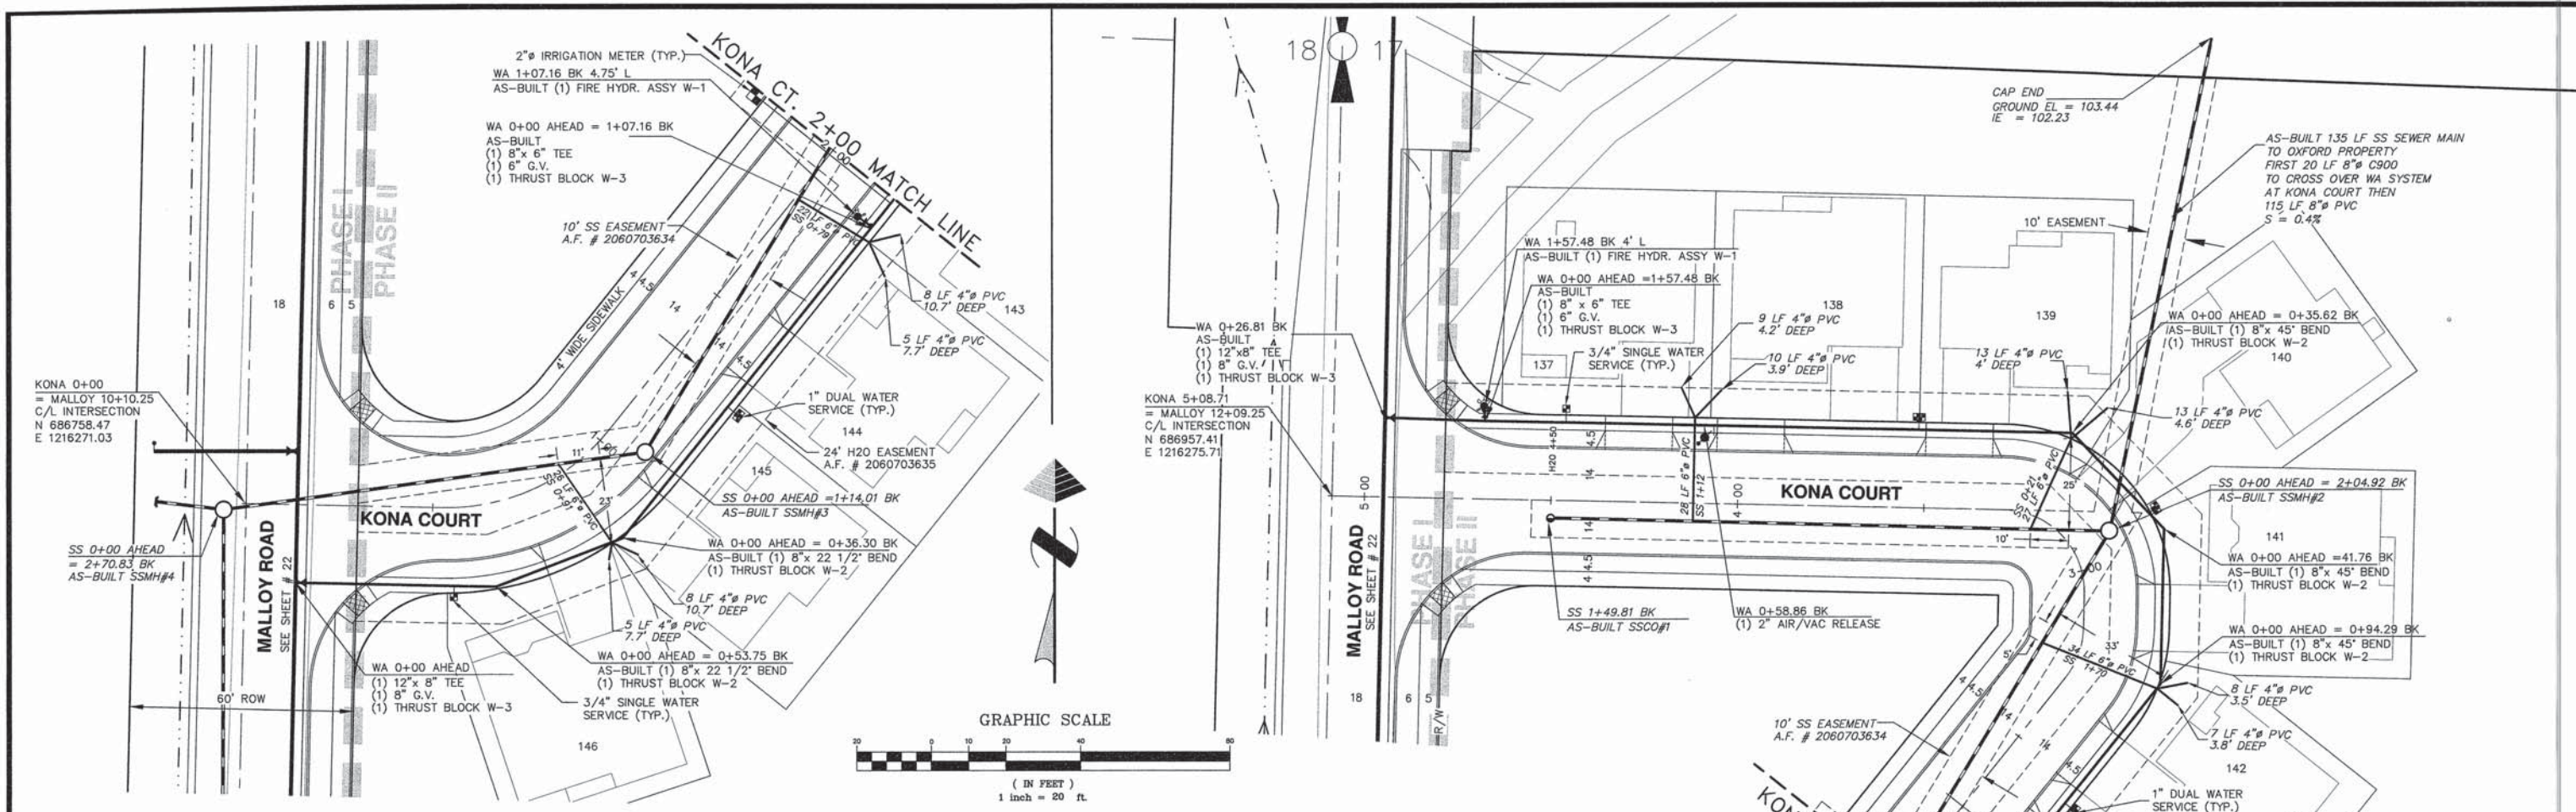

WA PROFILE DESIGN ONLY - NOT AS-BUILT

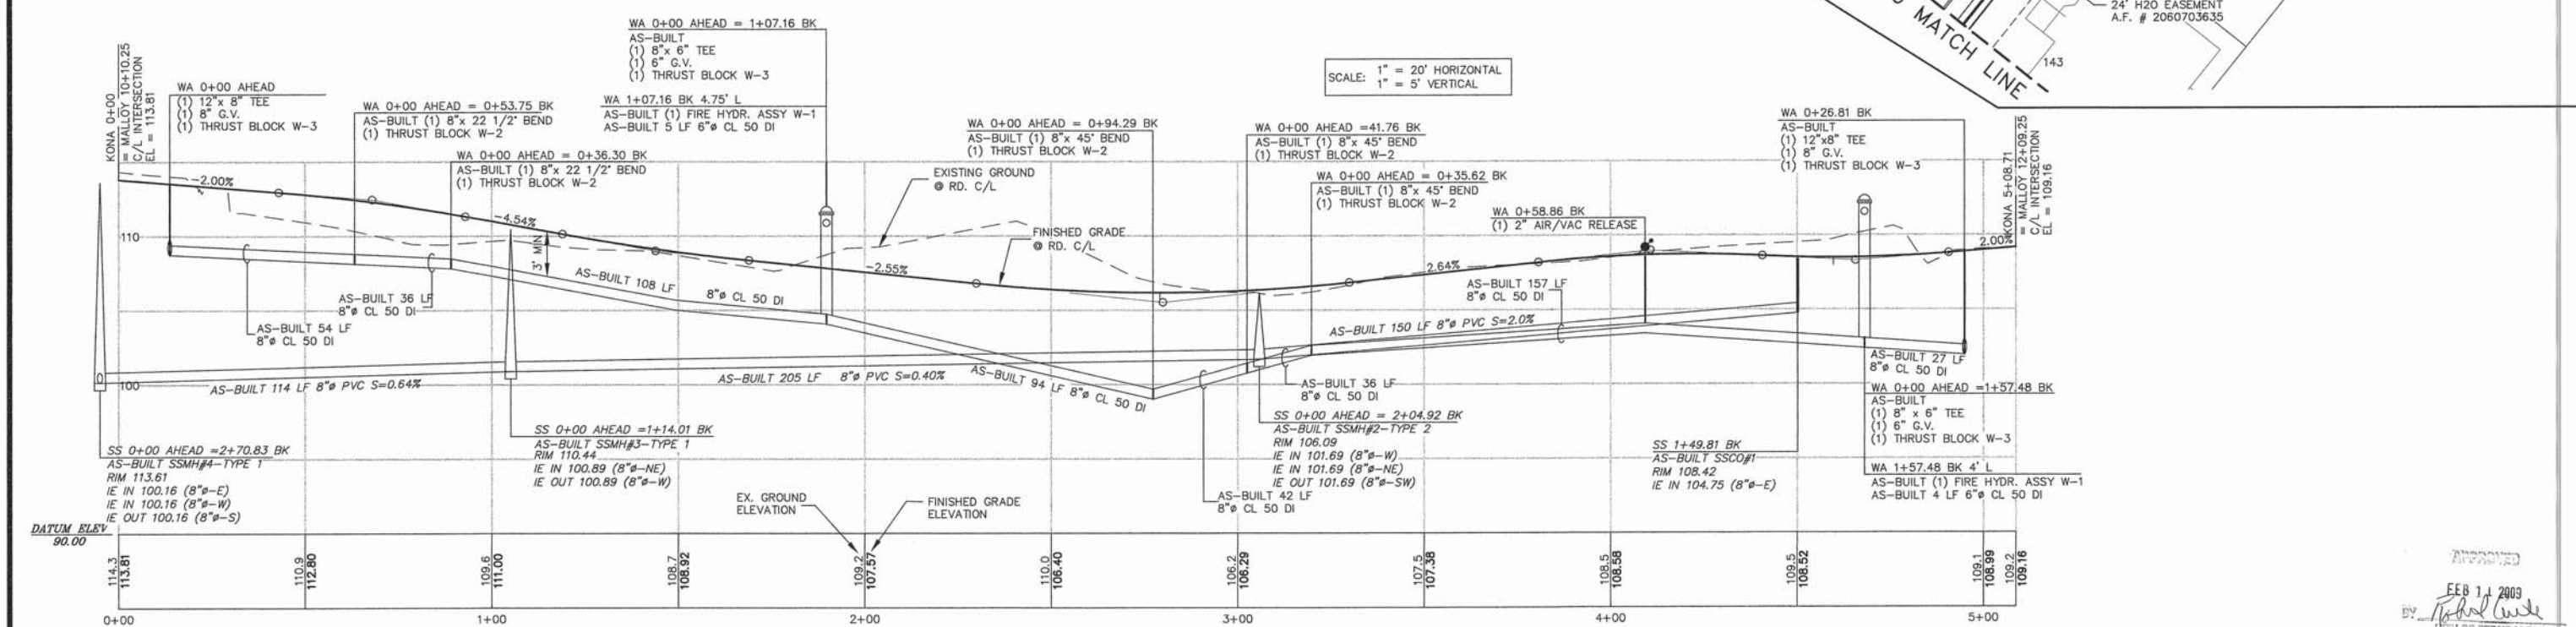

**CALL BEFORE
YOU DIG**
1-800-424-5555

NOTES

- EXISTING FIELD DATA PER LARRY STEELE & ASSOCIATES.
- ALL CONSTRUCTION SHALL BE IN ACCORDANCE WITH CITY OF FERDALE STANDARDS AND CURRENT WSDOT/APWA STANDARD SPECIFICATIONS FOR ROAD, BRIDGE, AND MUNICIPAL CONSTRUCTION.

AS-BUILT DRAWING CERTIFICATION

I hereby certify that a representative sample of the improvements in the Malloy Village PUD have been inspected by Millennium Engineering Group, Inc. and constructed in conformance with the plans approved by the Public Works Director for said development and the general specifications adopted by the City of Ferndale Department of Public Works.

DATUM
VERTICAL
NOV 29 USING CITY OF FERDALE MON. STATION #351
HORIZONTAL
CITY OF FERDALE MONUMENT NETWORK

BASIS OF BEARINGS
WASHINGTON STATE NORTH ZONE NAD 83/91 COORDINATES
USING CITY OF FERDALE MONUMENTS
STATIONS #343 AND #351



MILLENNIUM
Engineering Group, Inc.

109-6th ST., PO BOX 137, LYNDEN, WA 98264
PH: (360) 354-8141 FAX: (360) 354-3744
mail@2001egi.com www.2001egi.com

MALLOY VILLAGE PUD
AS-BUILT
KONA COURT
SEWER & WATER



FOR
MALLOY VILLAGE LLC

PTN. SW1/4, SEC.17, T39N, R2E, W.M.
CITY OF FERDALE, WHATCOM COUNTY, WASHINGTON

SCALE: 1" = 20'
DATE: 07/17/06
DRAWN BY: LLC/F
REVIEWED: 04/19/07
24 OF 42
JOB NUMBER: 03062



SCALE: 1" = 20'
DATE: 03/31/05
DRAWN BY: LLC
REVISED: 04/19/07
SHEET:
27 OF 42
JOB NUMBER:
03062

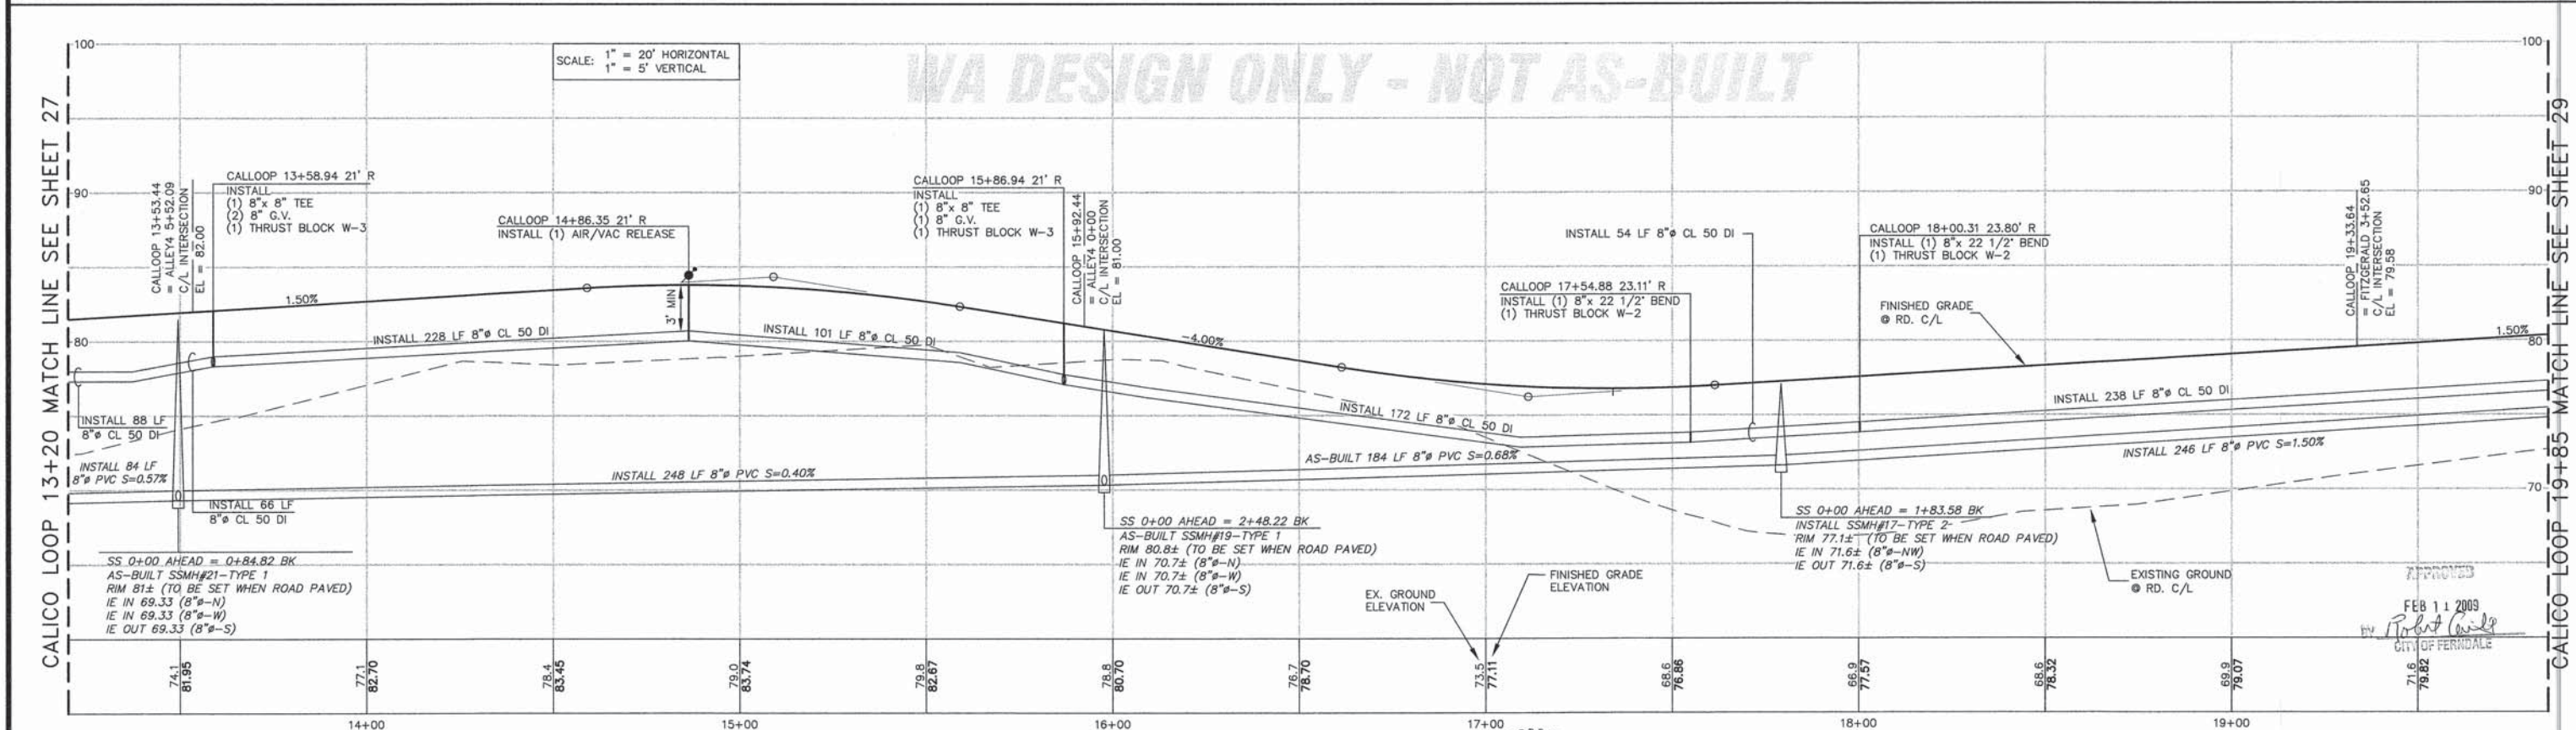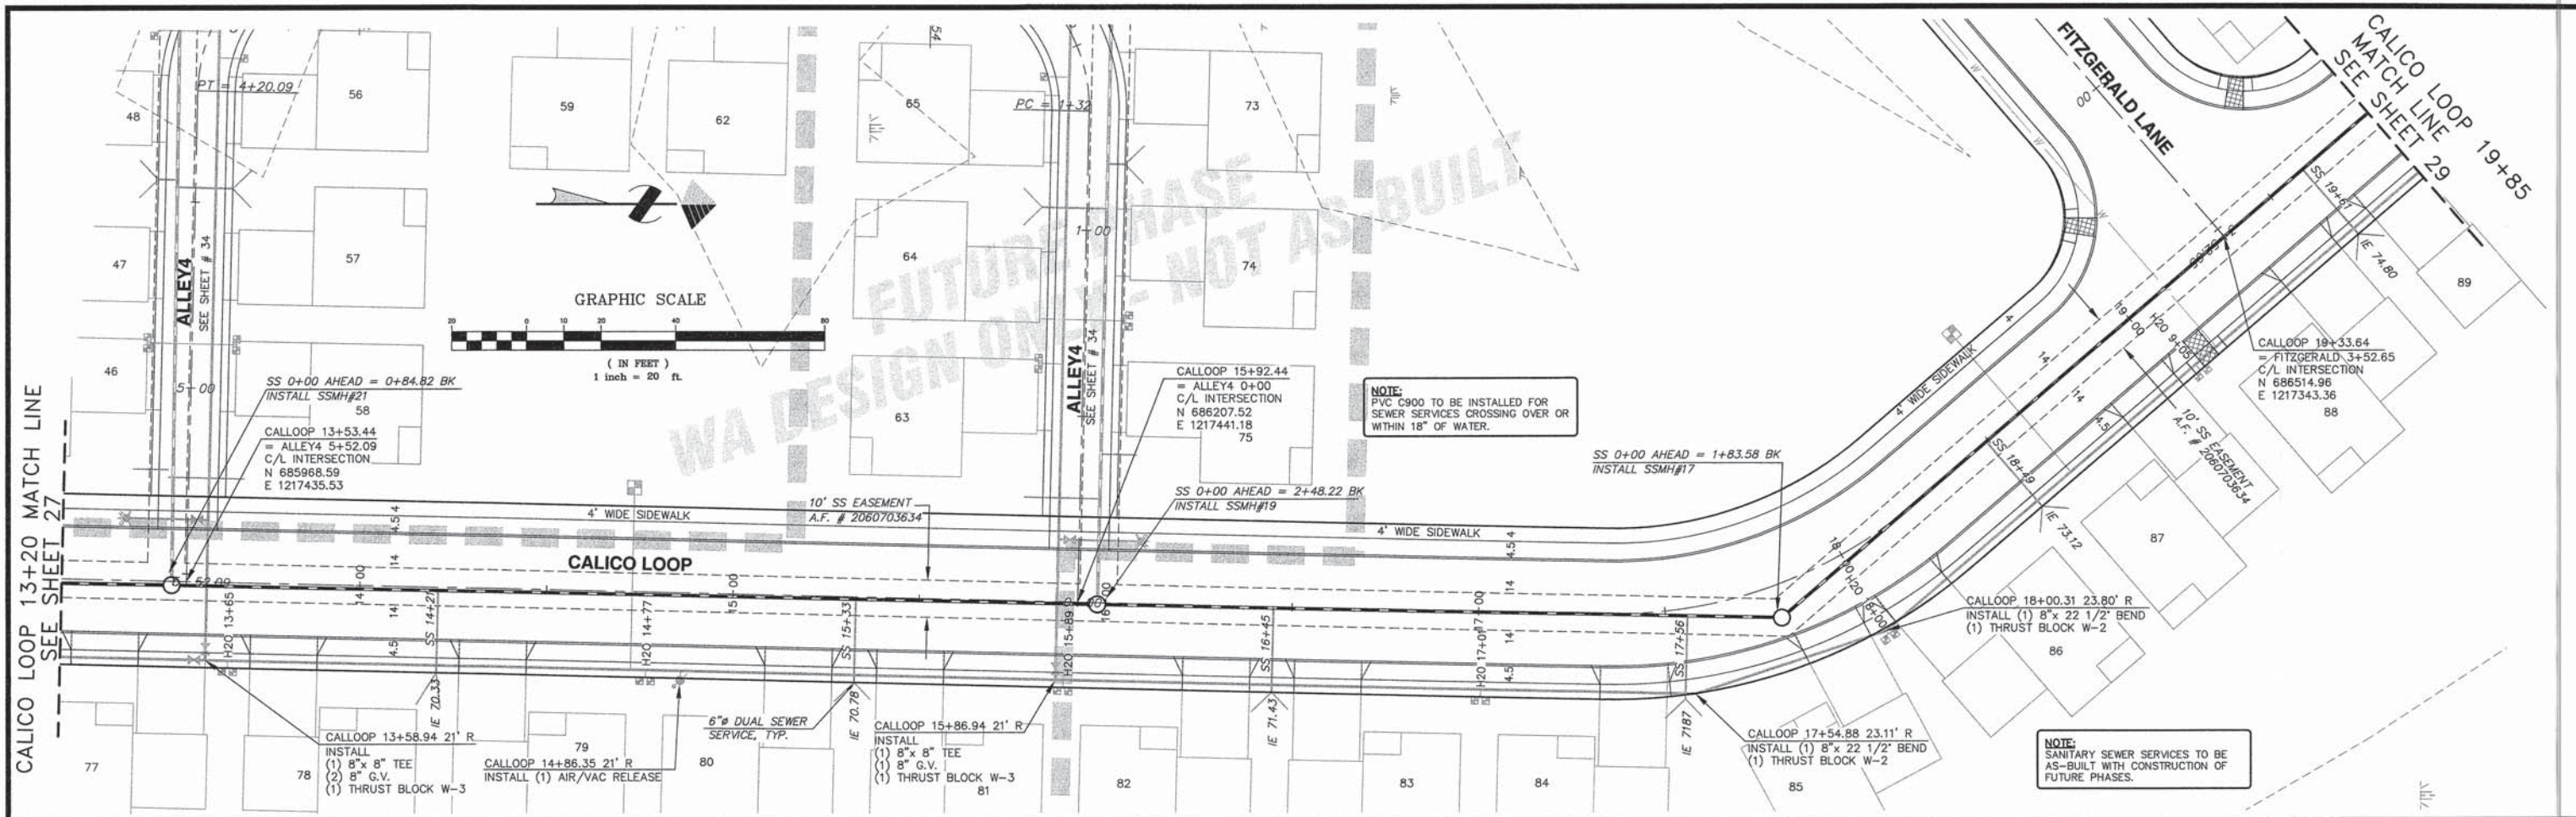

**CALL BEFORE
YOU DIG**
1-800-424-5555


NOTES

- EXISTING FIELD DATA PER LARRY STEELE & ASSOCIATES.
- ALL CONSTRUCTION SHALL BE IN ACCORDANCE WITH CITY OF FERDALE STANDARDS AND CURRENT WSDOT/APWA STANDARD SPECIFICATIONS FOR ROAD, BRIDGE, AND MUNICIPAL CONSTRUCTION.

APPROVAL STAMPS

DATUM
VERTICAL
NGVD 29 USING CITY OF FERDALE MON. STATION #351
HORIZONTAL
CITY OF FERDALE MONUMENT NETWORK

BASIS OF BEARINGS
WASHINGTON STATE NORTH ZONE NAD 83/91 COORDINATES
USING CITY OF FERDALE MONUMENTS
STATIONS #343 AND #351

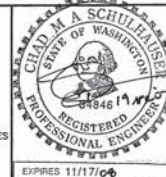


MILLENNIUM
Engineering Group, Inc.

109-6th ST., PO BOX 137, LYNDEN, WA 98264
PH: (360) 354-8141 FAX: (360) 354-3744
mail@2001egi.com www.2001egi.com

MALLOY VILLAGE PUD
AS-BUILT
CALICO LOOP 13+20 - 19+85
SEWER & STORM

FOR
MALLOY VILLAGE LLC
PTN. SW1/4, SEC.17, T39N, R2E, W.M.
CITY OF FERDALE, WHATCOM COUNTY, WASHINGTON

 
SCALE: 1" = 20'
DATE: 03/31/05
DRAWN BY: LLCP
REVIEWED: 04/19/07
28 OF 42
JOB NUMBER: 03062



NOTE:
SANITARY SEWER SERVICES TO BE
AS-BUILT WITH CONSTRUCTION OF
FUTURE PHASES.

CALICO LOOP 19+85 MATCH LINE
SEE SHEET 28

CALICO LOOP 25+70 MATCH LINE
SEE SHEET 30

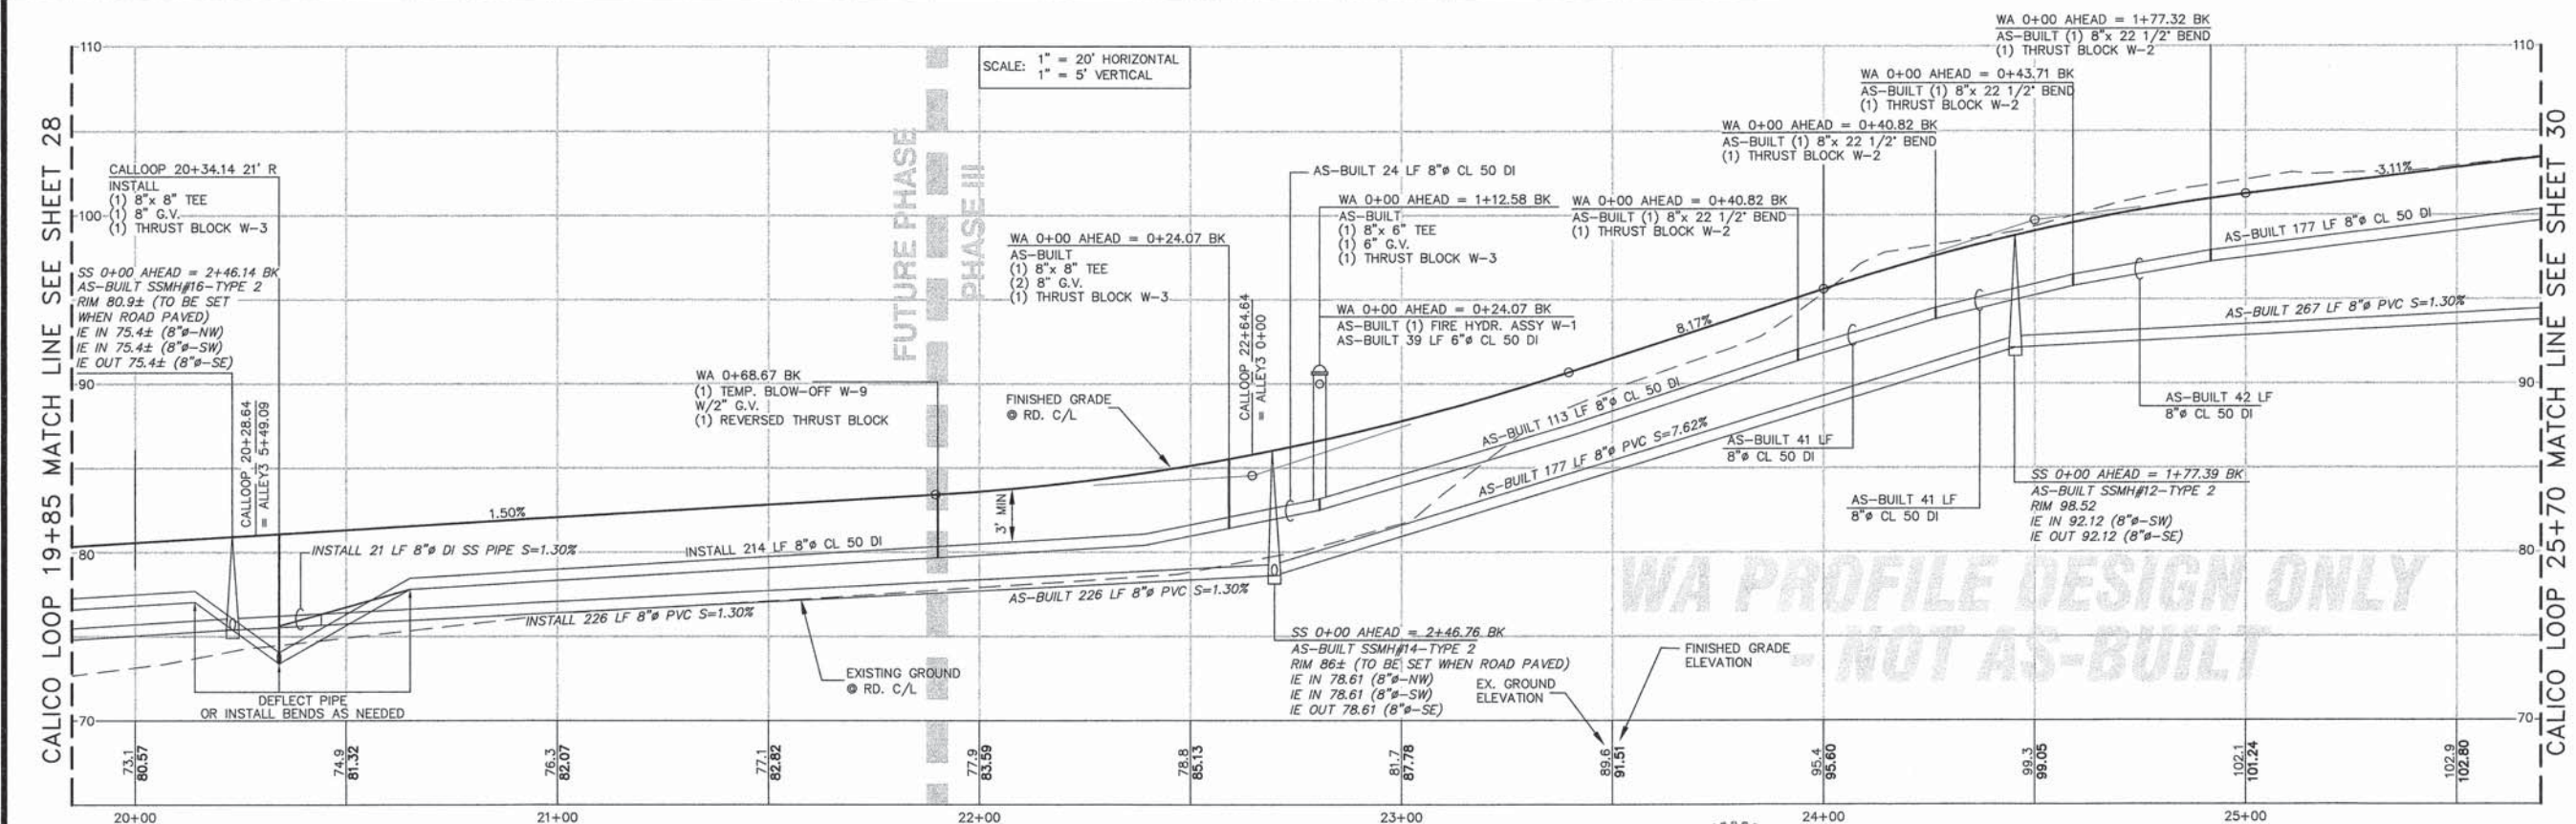

CALL BEFORE
YOU DIG
1-800-424-5555

NOTES


- EXISTING FIELD DATA PER LARRY STEELE & ASSOCIATES.
- ALL CONSTRUCTION SHALL BE IN ACCORDANCE WITH CITY OF FERNDALE STANDARDS AND CURRENT WSDOT/APWA STANDARD SPECIFICATIONS FOR ROAD, BRIDGE, AND MUNICIPAL CONSTRUCTION.

AS-BUILT DRAWING CERTIFICATION

I hereby certify that a representative sample of the improvements in the Malloy Village PUD have been inspected by Millennium Engineering Group, Inc. and constructed in conformance with the plans approved by the Public Works Director for said development and the general specifications adopted by the City of Ferndale Department of Public Works.

DATUM
VERTICAL
NOV. 29 USING CITY OF FERNDALE MON. STATION #351
HORIZONTAL
CITY OF FERNDALE MONUMENT NETWORK

BASIS OF BEARINGS
WASHINGTON STATE NORTH ZONE NAD 83/91 COORDINATES
USING CITY OF FERNDALE MONUMENTS
STATIONS #343 AND #351

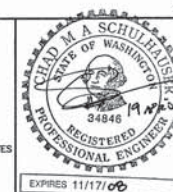

MILLENNIUM
Engineering Group, Inc.

109-6th ST., PO BOX 137, LYNDEN, WA 98264
PH: (360) 354-8141 FAX: (360) 354-3744
mail@2001egi.com www.2001egi.com



MALLOY VILLAGE PUD
AS-BUILT
CALICO LOOP 19+85 - 25+70
SEWER & WATER


FOR
MALLOY VILLAGE LLC

PTN. SW1/4, SEC.17, T39N, R2E, W.M.
CITY OF FERNDALE, WHATCOM COUNTY, WASHINGTON




SCALE: 1" = 20'
DATE: 07/17/06
DRAWN BY: LUCP
REVISED: 04/19/07
JOB NUMBER:
03062

29 OF 42

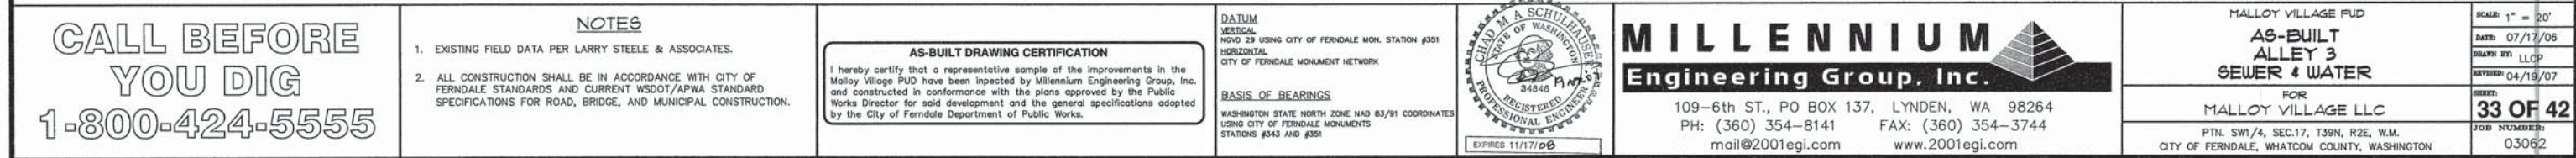
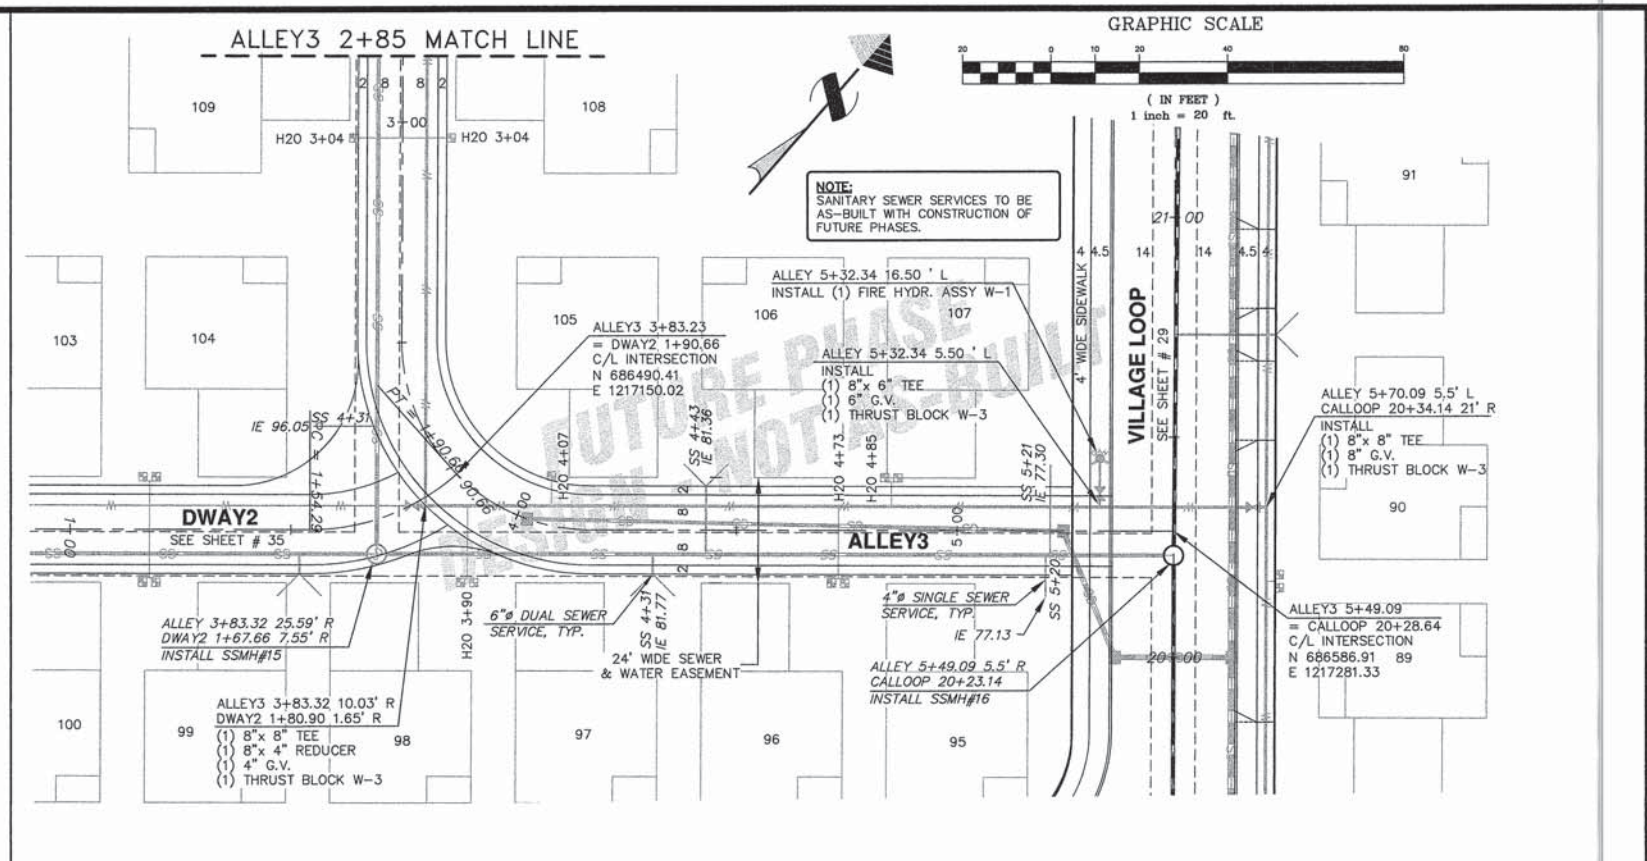


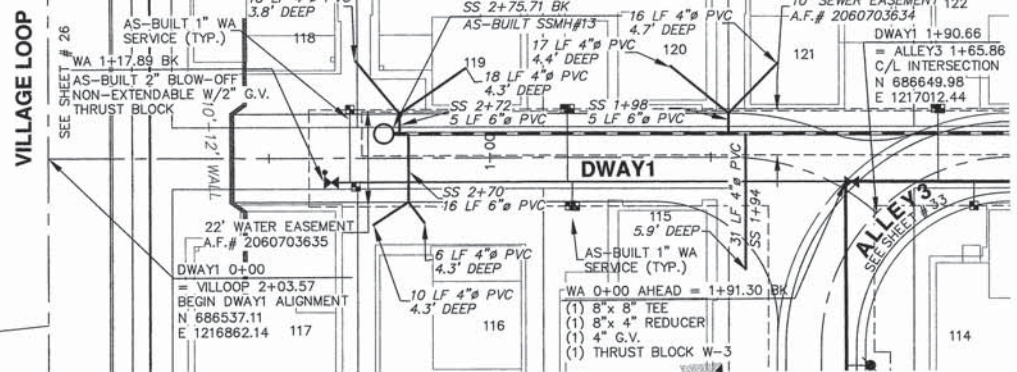

GRAPHIC SCALE

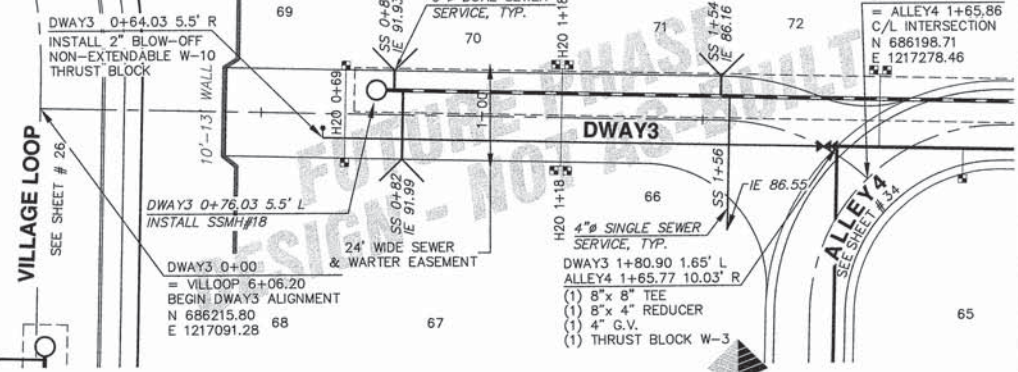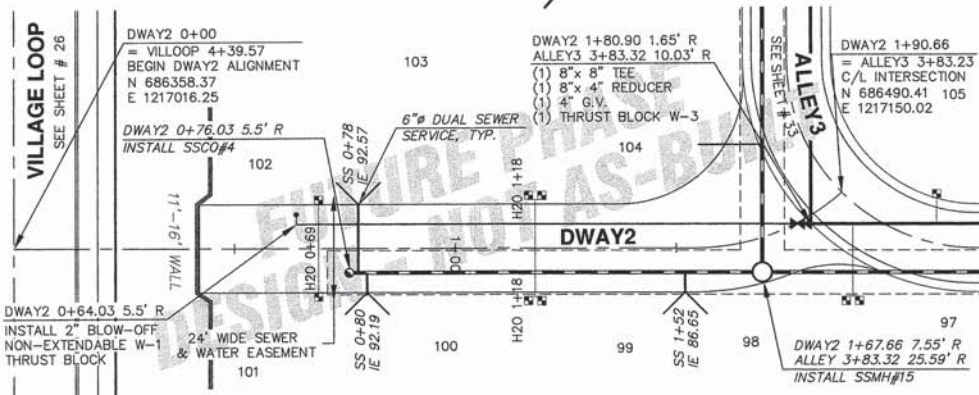 


GRAPHIC SCALE

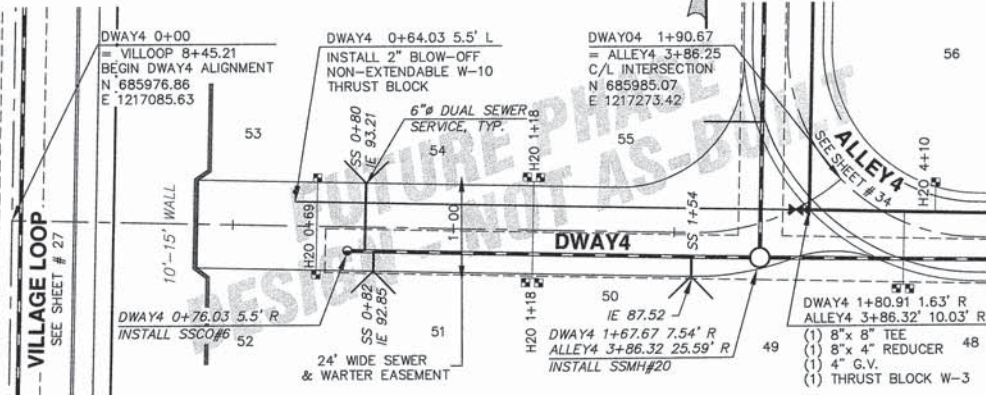 

NOTE:
PVC C900 TO BE INSTALLED FOR
SEWER SERVICES CROSSING OVER OR
WITHIN 18" OF WATER.


DWAY4 PROFILE

SCALE: 1" = 20' HORIZONTAL
1" = 5' VERTICAL

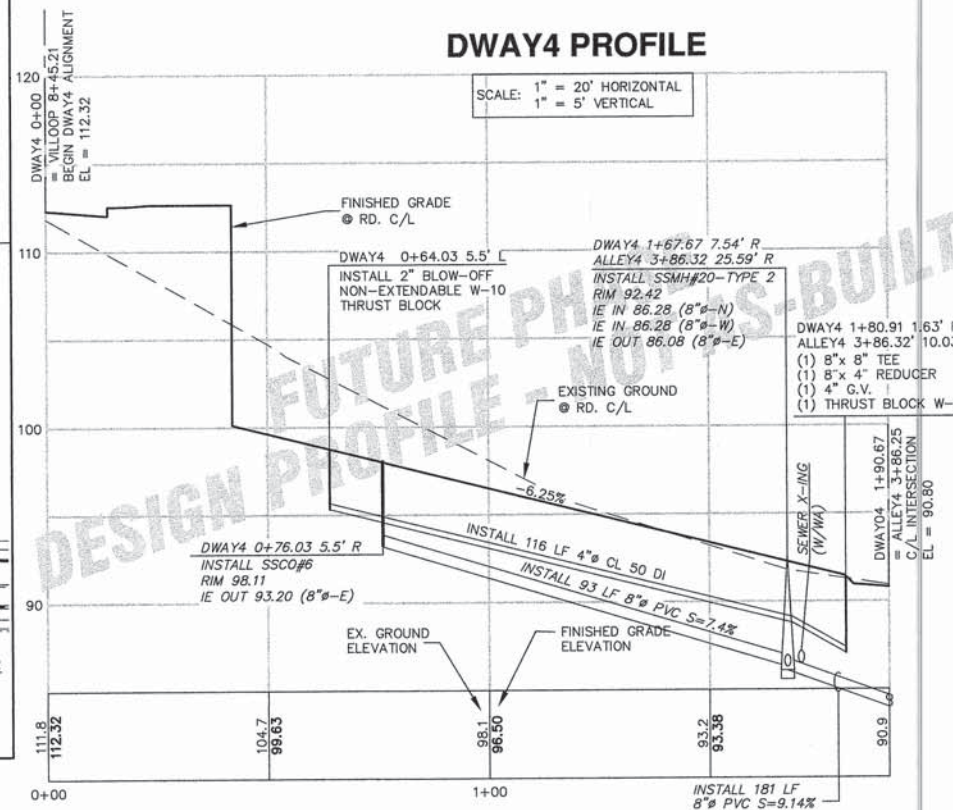


DWAY1 PROFILE

SCALE: 1" = 20' HORIZONTAL
1" = 5' VERTICAL

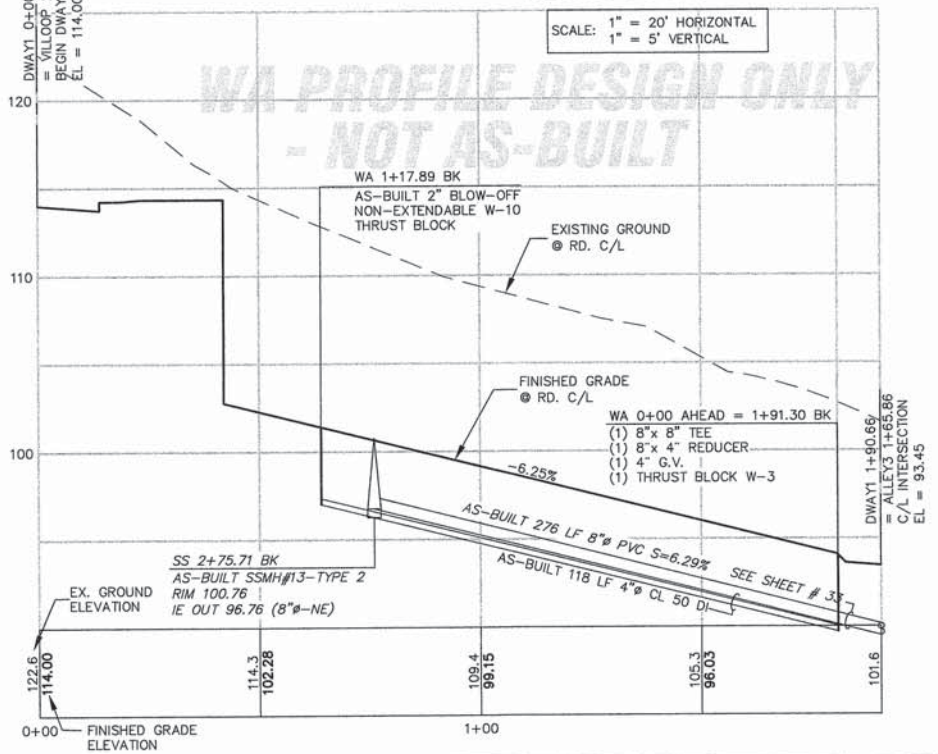


DWAY2 PROFILE

SCALE: 1" = 20' HORIZONTAL
1" = 5' VERTICAL

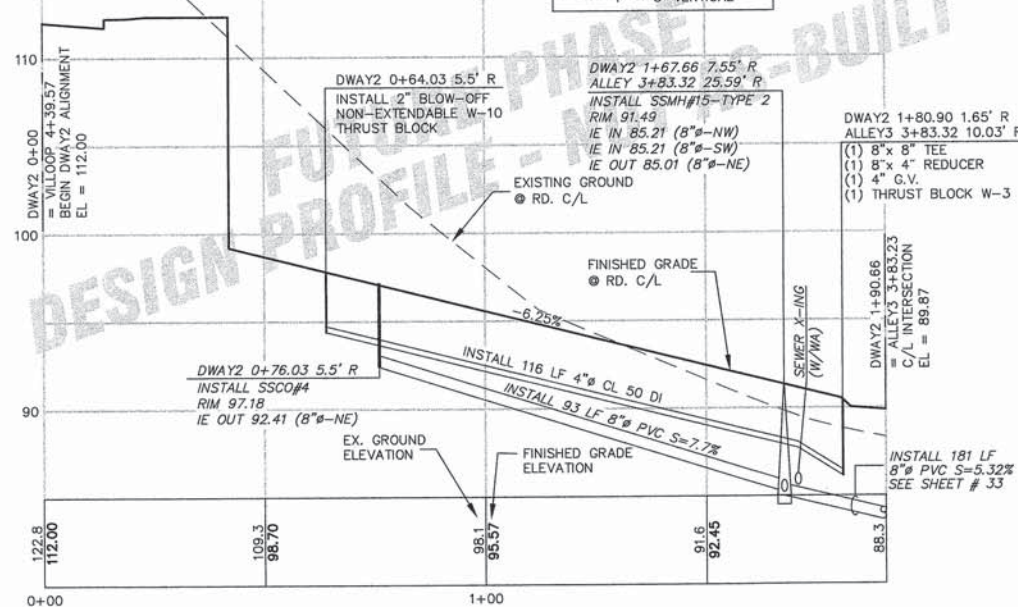

DWAY3 PROFILE

SCALE: 1" = 20' HORIZONTAL
1" = 5' VERTICAL

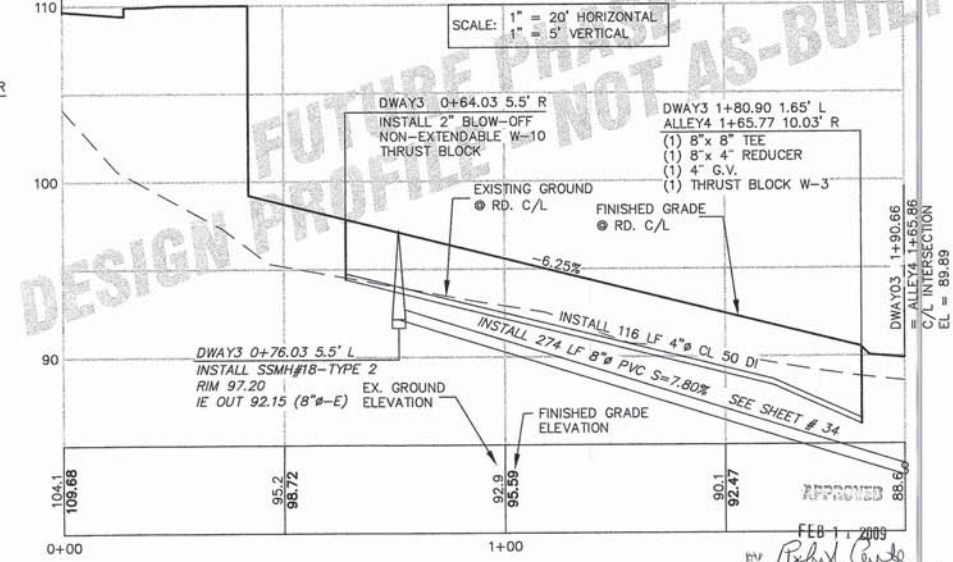

CALL BEFORE
YOU DIG
1-800-424-5555


NOTES

- EXISTING FIELD DATA PER LARRY STEELE & ASSOCIATES.
- ALL CONSTRUCTION SHALL BE IN ACCORDANCE WITH CITY OF FERNDALE STANDARDS AND CURRENT WSDOT/APWA STANDARD SPECIFICATIONS FOR ROAD, BRIDGE, AND MUNICIPAL CONSTRUCTION.

AS-BUILT DRAWING CERTIFICATION

I hereby certify that a representative sample of the Improvements in the Malloy Village PUD have been inspected by Millennium Engineering Group, Inc. and constructed in conformance with the plans approved by the Public Works Director for said development and the general specifications adopted by the City of Ferndale Department of Public Works.

DATUM
VERTICAL
NAD 83
HORIZONTAL
CITY OF FERNDALE MONUMENT NETWORK

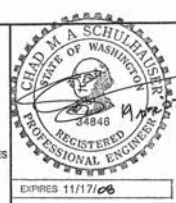

MILLENNIUM
Engineering Group, Inc.




109-6th ST., PO BOX 137, LYNDEN, WA 98264
PH: (360) 354-8141 FAX: (360) 354-3744
mail@2001egi.com www.2001egi.com

MALLOY VILLAGE PUD
AS-BUILT DRIVEWAY 1 & ALLEY 3
SEWER & WATER
FOR
MALLOY VILLAGE LLC
PTN. SW1/4, SEC.17, T39N, R2E, W.M.
CITY OF FERNDALE, WHATCOM COUNTY, WASHINGTON

DATE: 07/17/06
DRAWN BY: LUCP
CHECKED: 04/19/07
SHEET: 35 OF 42
JOB NUMBER: 03062

00531.017 12/19/12 SH

J:\proj\2510000\2510000-09-AS-BUILT-PO-2-3-REV1\AS-BUILT-PO-2-3-REV1.dwg, 4/19/2007 11:56:18 AM, TBM

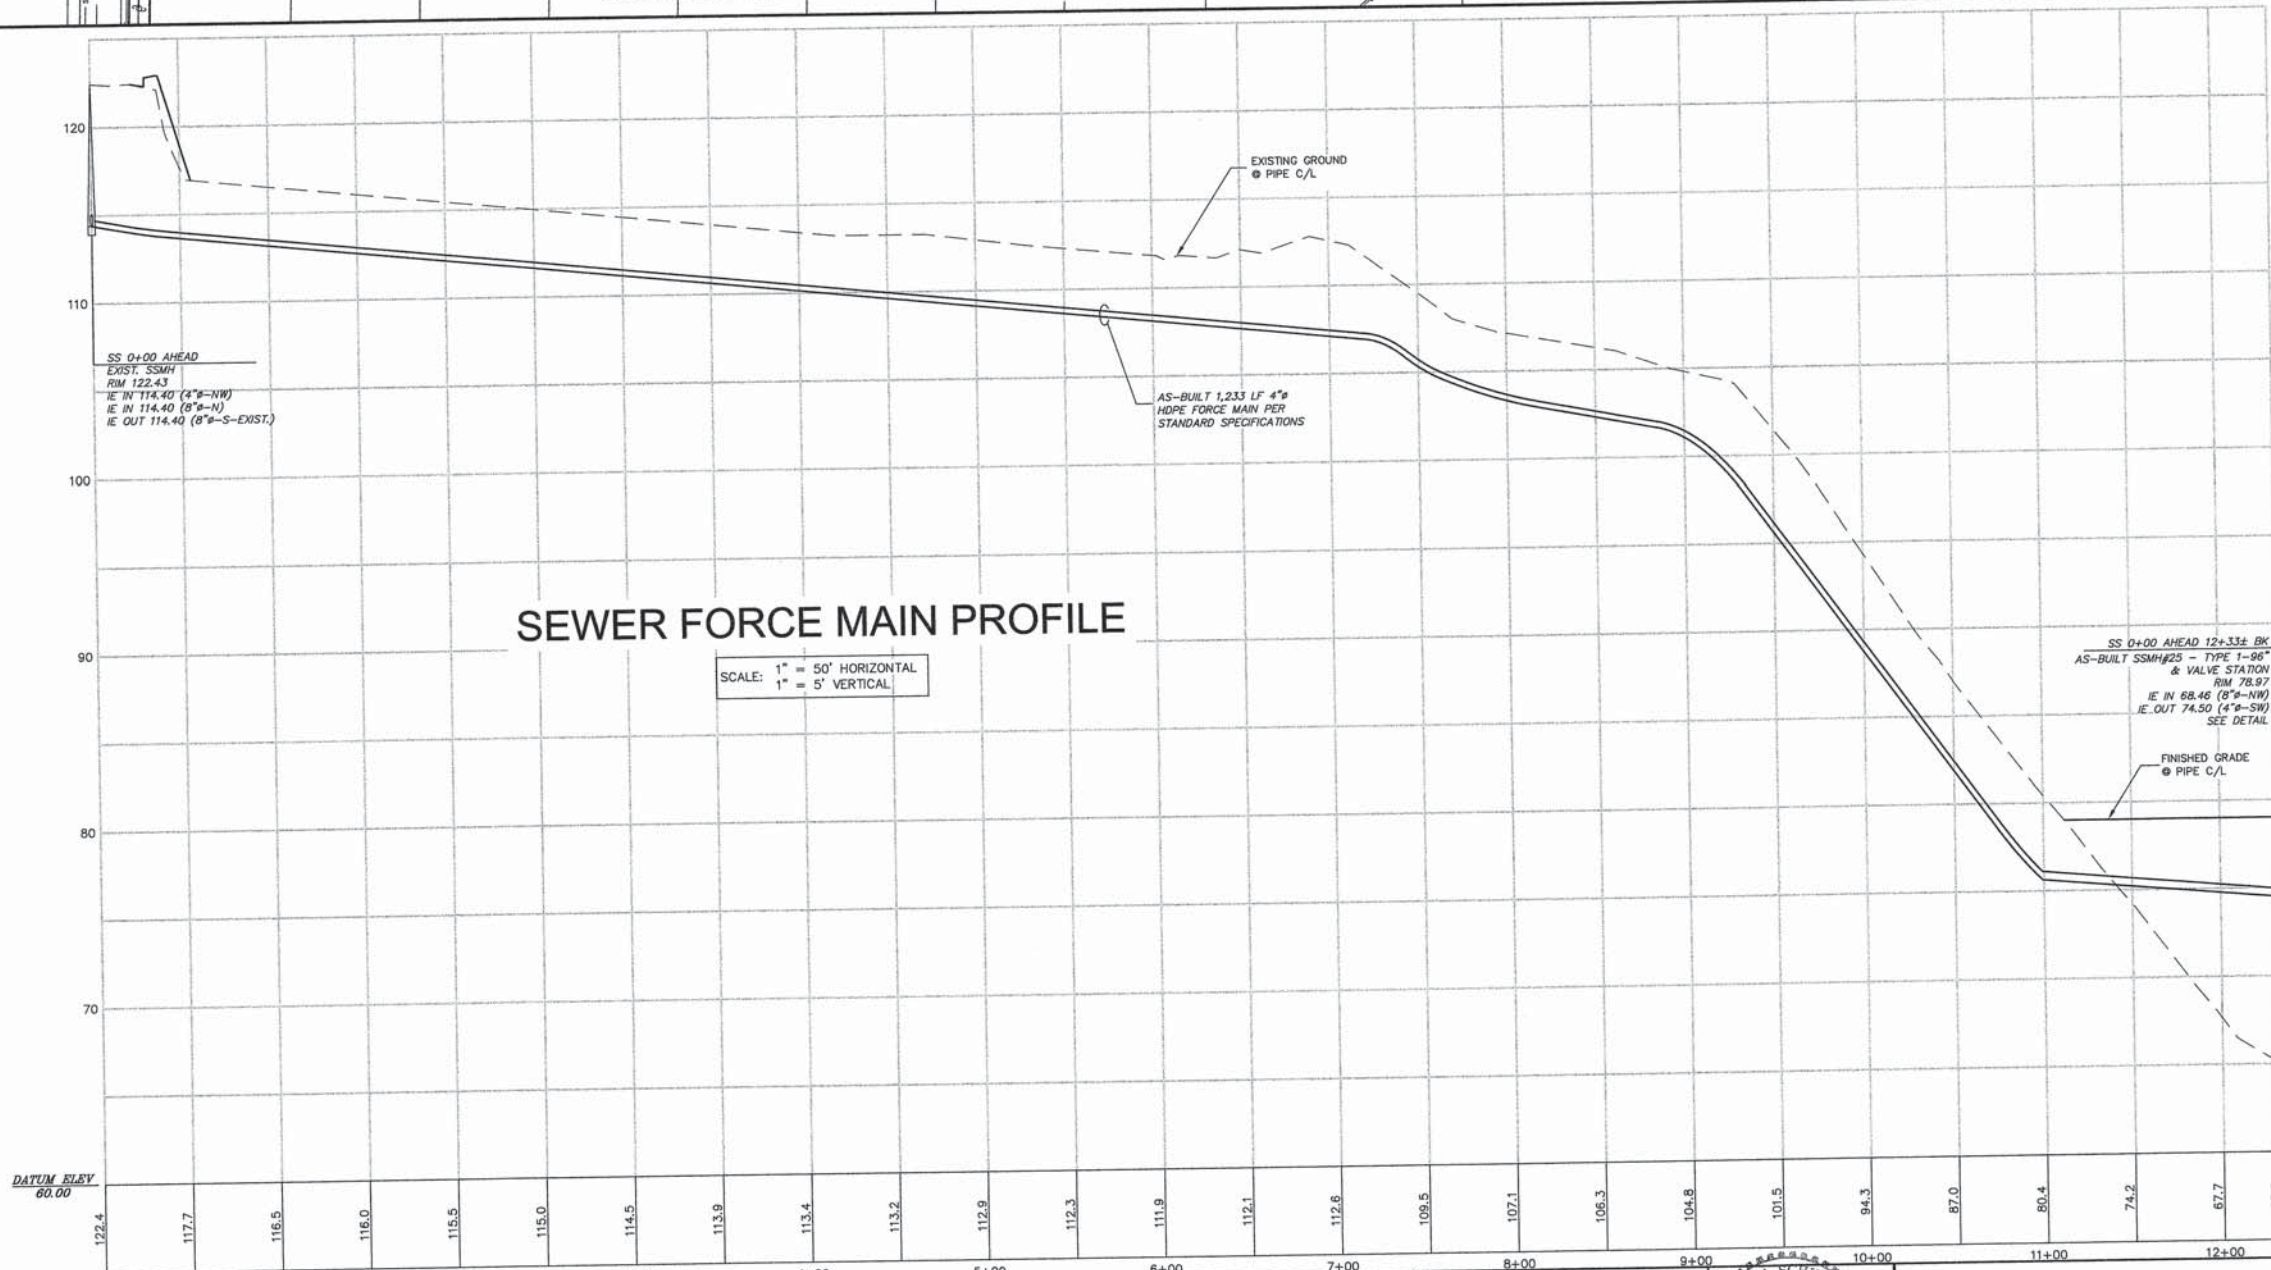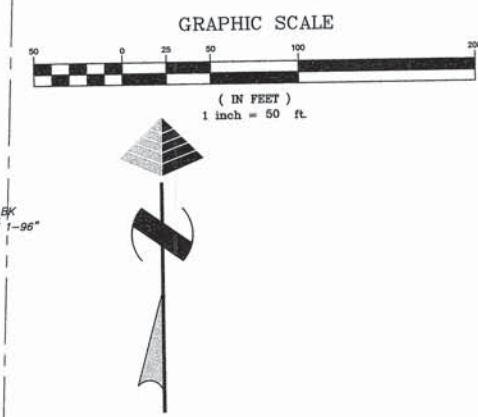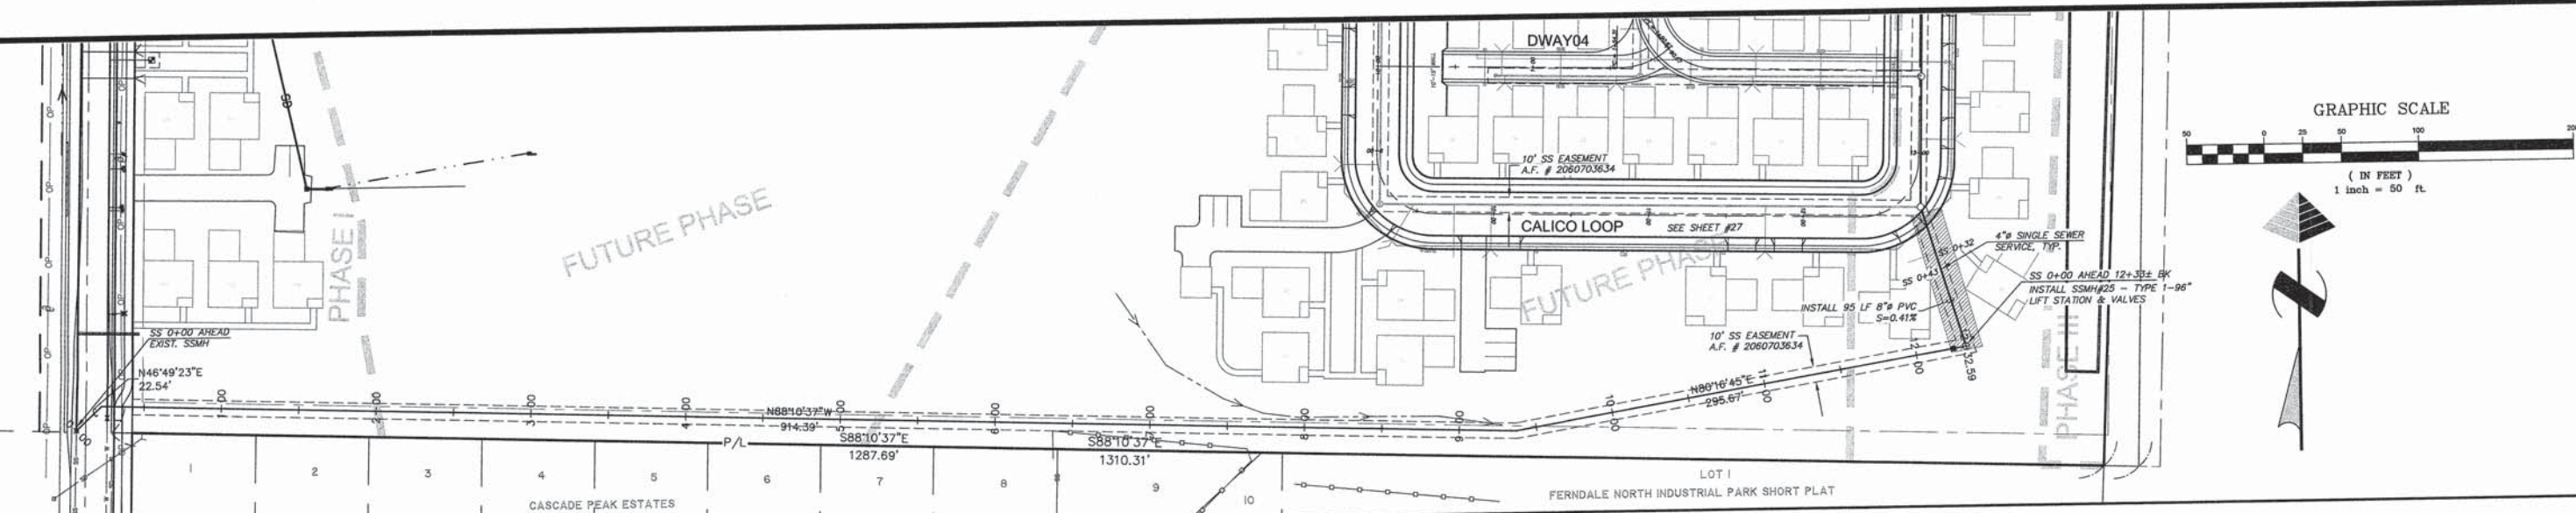

SEWER FORCE MAIN PROFILE

SCALE: 1" = 50' HORIZONTAL
1" = 5' VERTICAL

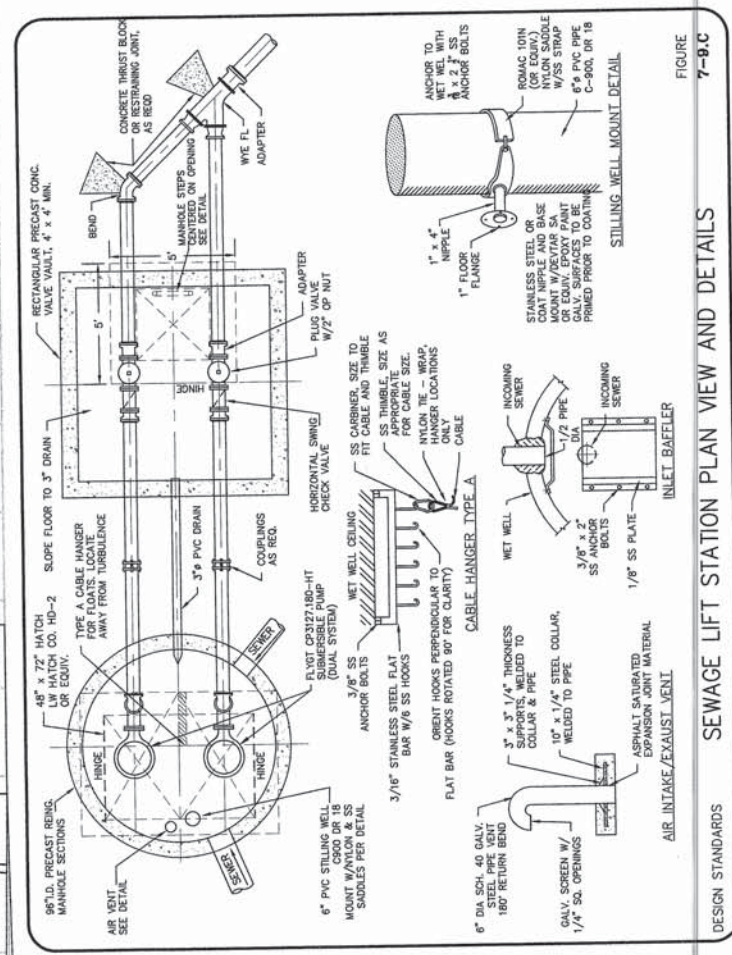


FIGURE 7-9.C

SEWAGE LIFT STATION PLAN VIEW AND DETAILS


DESIGN STANDARDS

**CALL BEFORE
YOU DIG**
1-800-424-5555

- NOTES**
- EXISTING FIELD DATA PER LARRY STEELE & ASSOCIATES.
 - ALL CONSTRUCTION SHALL BE IN ACCORDANCE WITH CITY OF FERNDALE STANDARDS AND CURRENT WSDOT/APWA STANDARD SPECIFICATIONS FOR ROAD, BRIDGE, AND MUNICIPAL CONSTRUCTION.

DATUM
VERTICAL
NAD 83 USING CITY OF FERNDALE MON. STATION #351
HORIZONTAL
CITY OF FERNDALE MONUMENT NETWORK

BASIS OF BEARINGS
WASHINGTON STATE NORTH ZONE NAD 83/91 COORDINATES
USING CITY OF FERNDALE MONUMENTS
STATIONS #343 AND #351

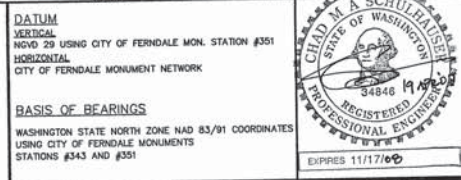


MILLENNIUM
Engineering Group, Inc.

109-6th ST., PO BOX 137, LYNDEN, WA 98264
PH: (360) 354-8141 FAX: (360) 354-3744
mail@2001egi.com www.2001egi.com

MALLOY VILLAGE FUD		SCALE: 1" = 50'
AS-BUILT		DATE: 03/31/05
SANITARY SEWER LIFT STATION		DRAWN BY: CMAS
FOR		REVISION: 04/19/07
MALLOY VILLAGE LLC		SHEET: 36 OF 42
PTN. SW1/4, SEC.17, T39N, R2E, W.M.		JOB NUMBER: 03062
CITY OF FERNDALE, WHATCOM COUNTY, WASHINGTON		

APPROVED
FEB 1 2009
BY: [Signature]
CITY OF FERNDALE

00531.018 12/19/12 SH














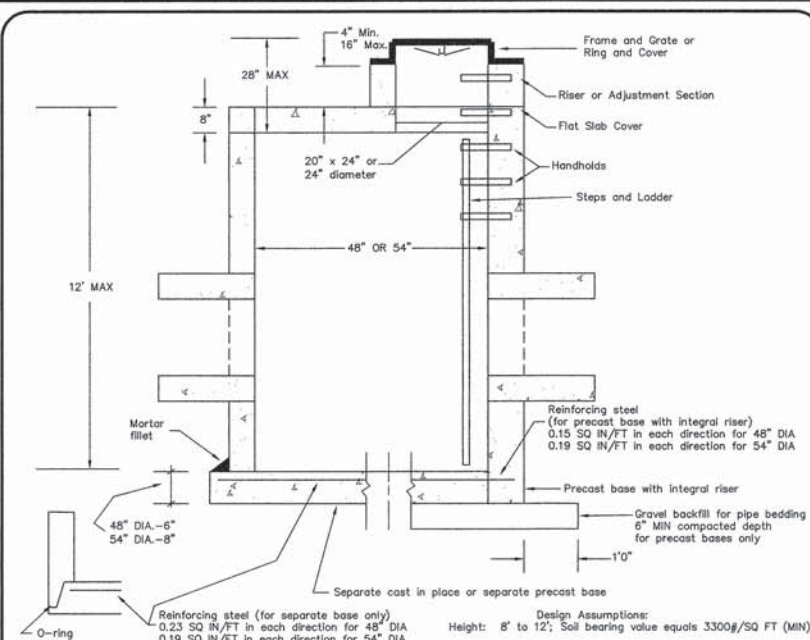


TYPE 2 CATCH BASIN 48" & 54"

NOT TO SCALE

DESIGN ASSUMPTIONS:
Height: 8" to 12"; Soil bearing value equals 3300#/SQ FT (MIN)

NOTES:
CATCH BASINS TO BE CONSTRUCTED IN ACCORDANCE WITH ASTM C478 (AASHTO M199) UNLESS OTHERWISE SHOWN ON PLANS OR NOTED IN THE STANDARD SPECIFICATIONS.
HANDHOLDS IN RISER OR ADJUSTMENT SECTION SHALL HAVE 3" MINIMUM CLEARANCE. STEPS IN CATCH BASIN SHALL HAVE 6" MINIMUM CLEARANCE. NO STEPS ARE REQUIRED WHEN HEIGHT IS 4" OR LESS.
ALL REINFORCED CAST IN PLACE CONCRETE SHALL BE CLASS A. NON-REINFORCED CONCRETE IN CHANNEL AND SHELF SHALL BE CLASS C.
ALL PRECAST CONCRETE SHALL OBTAIN 4000 PSI @ 28 DAYS.
PRECAST BASES SHALL BE FURNISHED WITH CUTOUT OR KNOCKOUTS. KNOCKOUTS SHALL HAVE A WALL THICKNESS OF 2" MINIMUM. KNOCKOUT OR CUTOUT HOLE SIZE IS EQUAL TO PIPE OUTER DIAMETER PLUS CATCH BASIN WALL THICKNESS. MAXIMUM HOLE SIZE IS 36" FOR 48" CATCH BASIN; 42" FOR 54" CATCH BASIN. MINIMUM DISTANCE BETWEEN HOLES IS 8".
FRAME AND GRATE OR RING AND COVER SHALL BE IN ACCORDANCE WITH STANDARD SPECIFICATIONS AND MEET THE STRENGTH REQUIREMENTS OF FEDERAL SPECIFICATION RR-F-6210. MATING SURFACES SHALL BE FINISHED TO ASSURE A NON-ROCKING FIT.
ALL BASE REINFORCING STEEL SHALL HAVE A MINIMUM YIELD STRENGTH OF 60,000 PSI AND BE PLACED IN THE UPPER HALF OF THE BASE WITH 1" MINIMUM CLEARANCE.
THE BOTTOM OF THE PRECAST CATCH BASIN MAY BE ROUNDED.

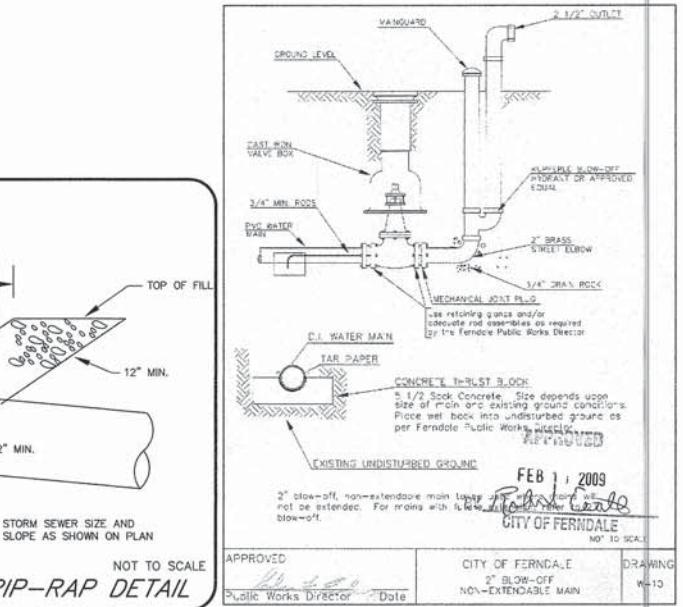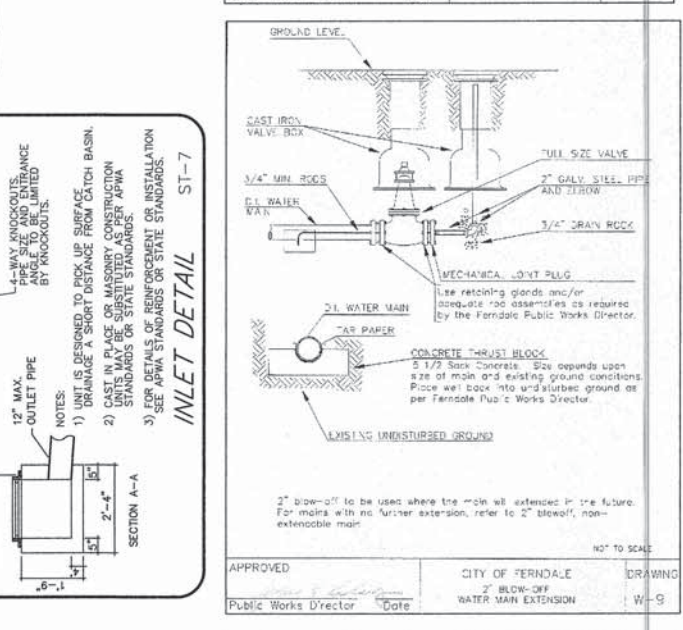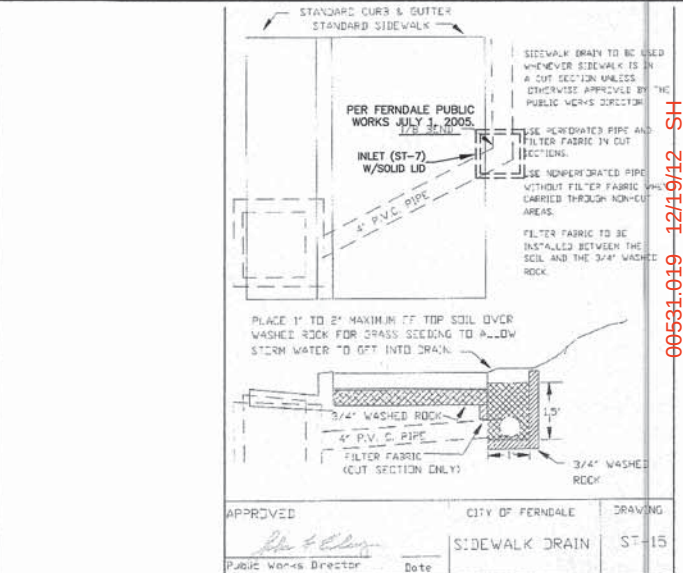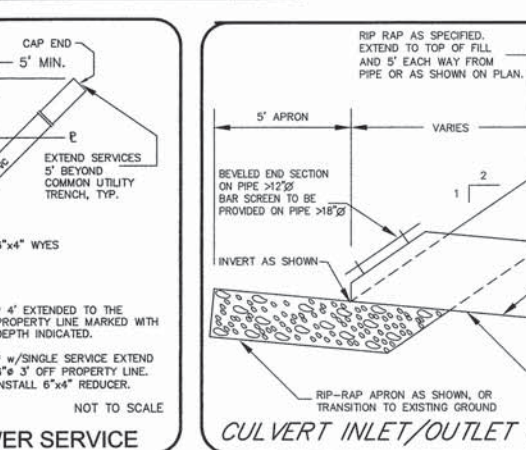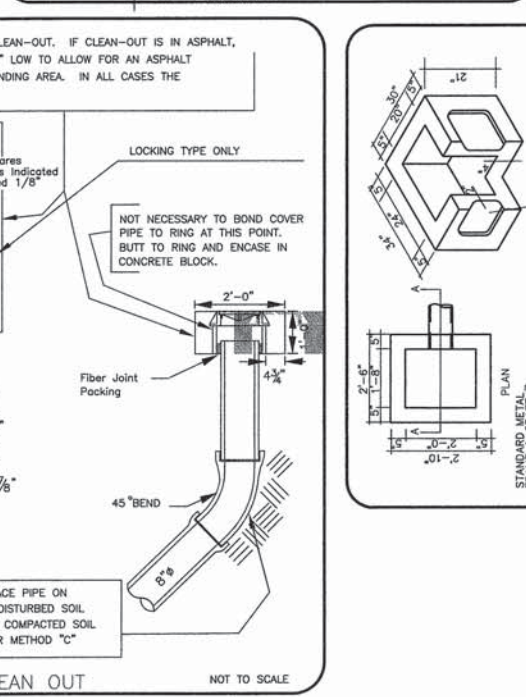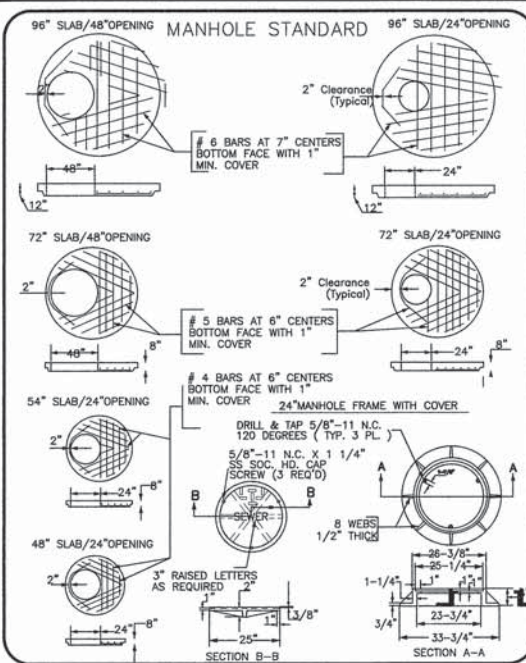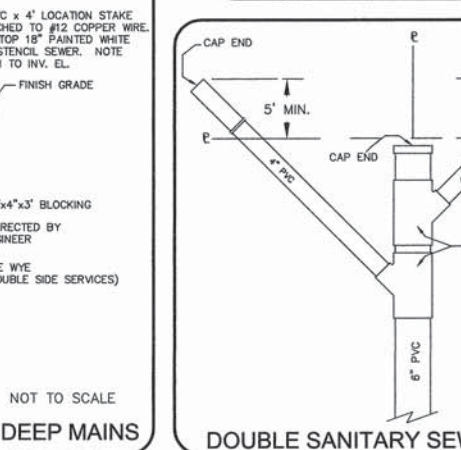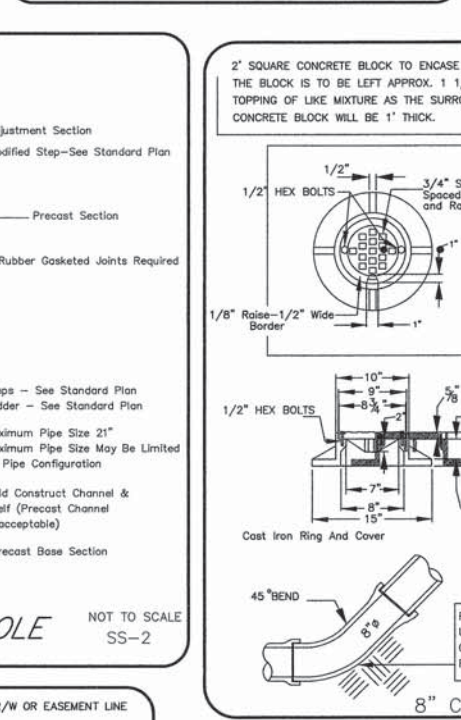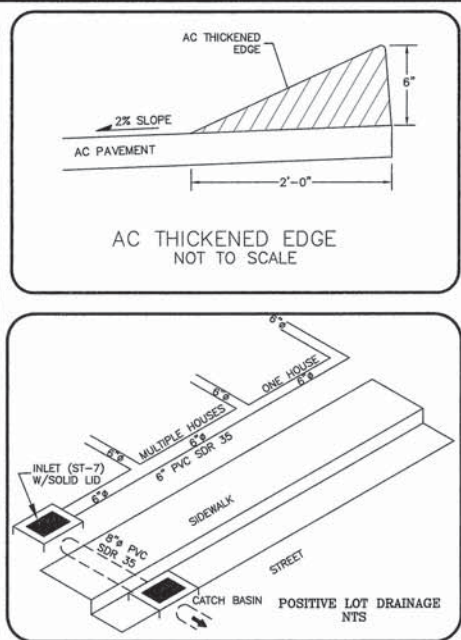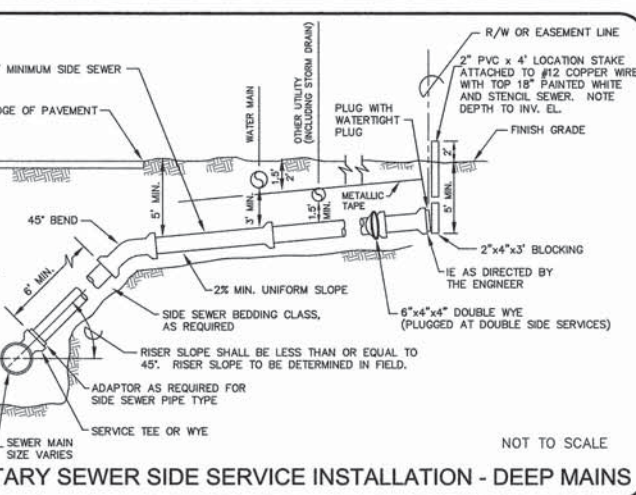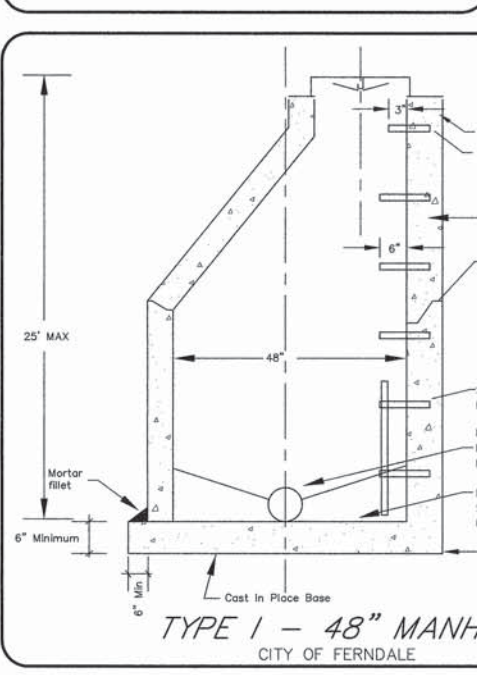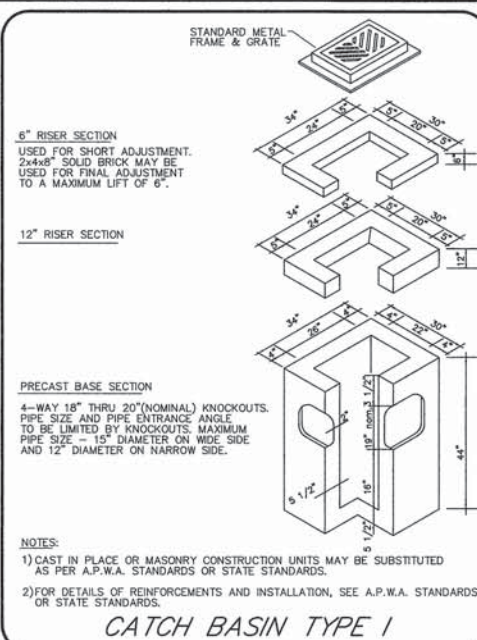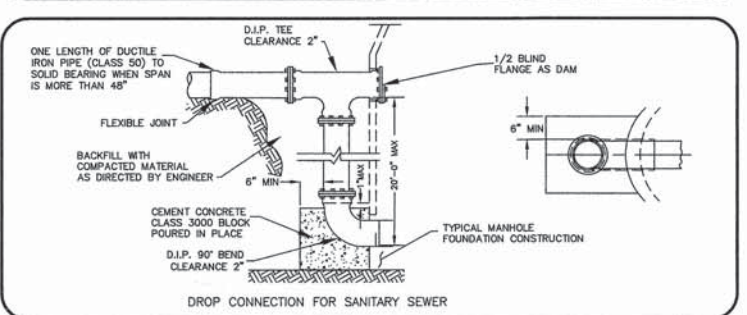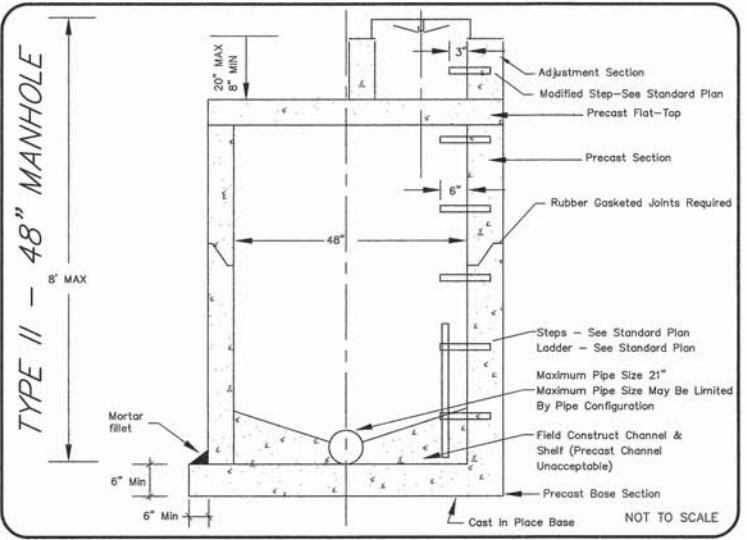

CALL BEFORE YOU DIG

1-800-424-5555

NOTES

- EXISTING FIELD DATA PER LARRY STEELE & ASSOCIATES.
- ALL CONSTRUCTION SHALL BE IN ACCORDANCE WITH CITY OF FERNDALE STANDARDS AND CURRENT WSDOT/APWA STANDARD SPECIFICATIONS FOR ROAD, BRIDGE, AND MUNICIPAL CONSTRUCTION.

APPROVAL STAMPS





DATE: 03/31/05
DRAWN BY: CMAS
REVIEWED: 04/19/07

MILLENNIUM Engineering Group, Inc.

109-6th ST., PO BOX 137, LYNDEN, WA 98264
PH: (360) 354-8141 FAX: (360) 354-3744
mail@2001egi.com www.2001egi.com

FOR MALLOY VILLAGE LLC





PTN. SW/4, SEC.17, T39N, R2E, W4M.
CITY OF FERNDALE, WHATCOM COUNTY, WASHINGTON

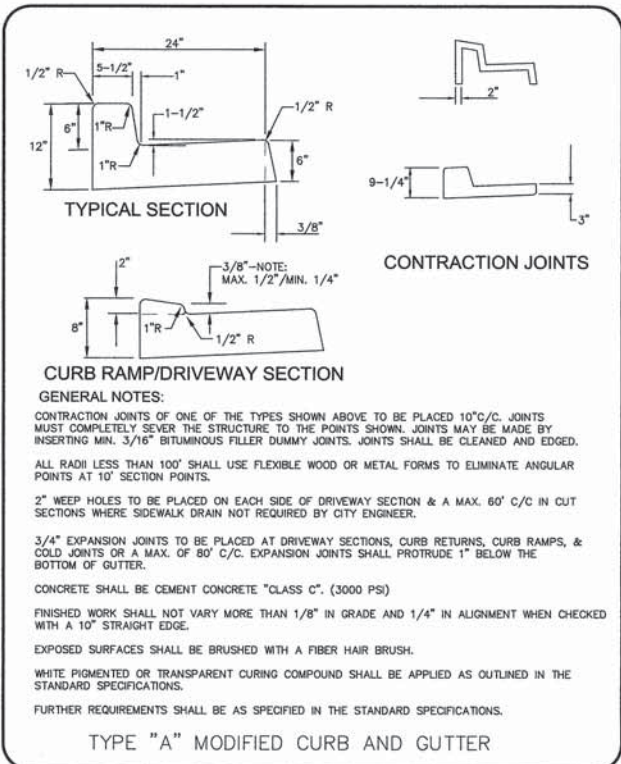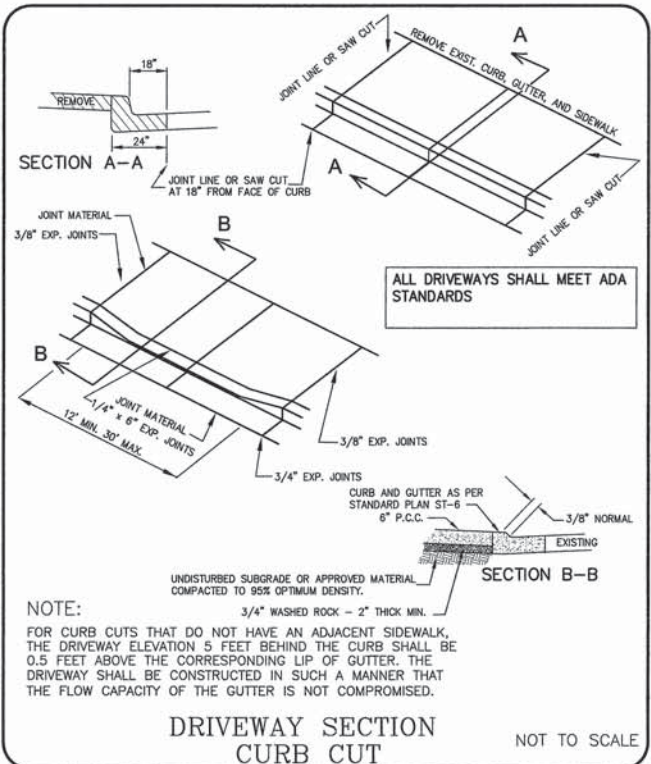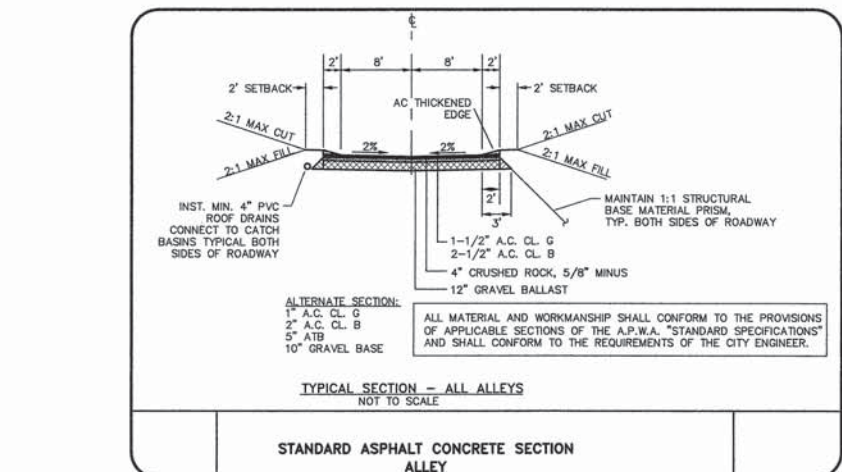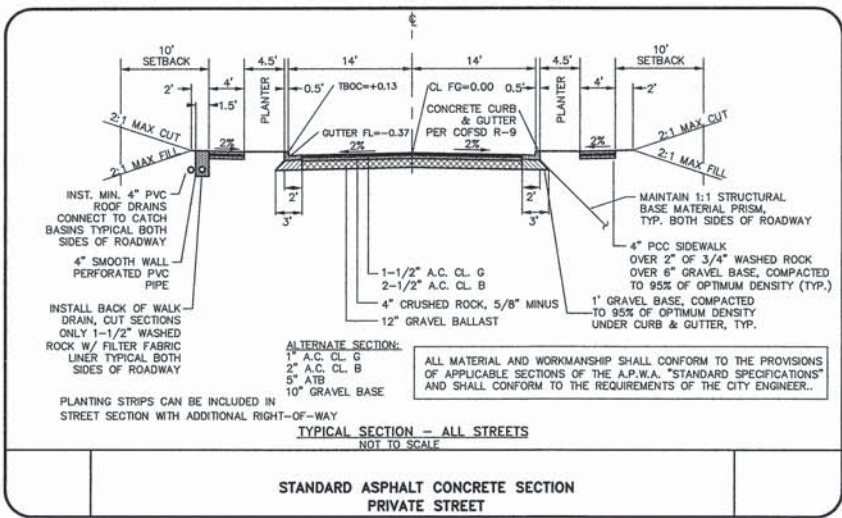

**CALL BEFORE
YOU DIG**
1-800-424-5555

- NOTES**
- EXISTING FIELD DATA PER LARRY STEELE & ASSOCIATES.
 - ALL CONSTRUCTION SHALL BE IN ACCORDANCE WITH CITY OF FERNDALE STANDARDS AND CURRENT WSDOT/APWA STANDARD SPECIFICATIONS FOR ROAD, BRIDGE, AND MUNICIPAL CONSTRUCTION.

APPROVAL STAMPS

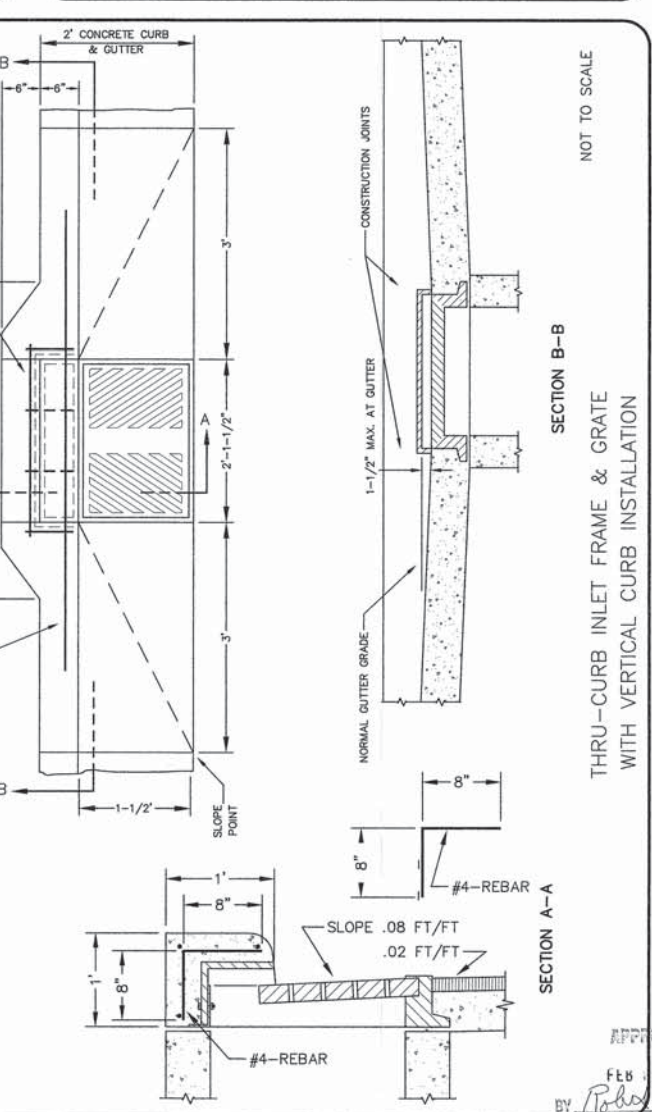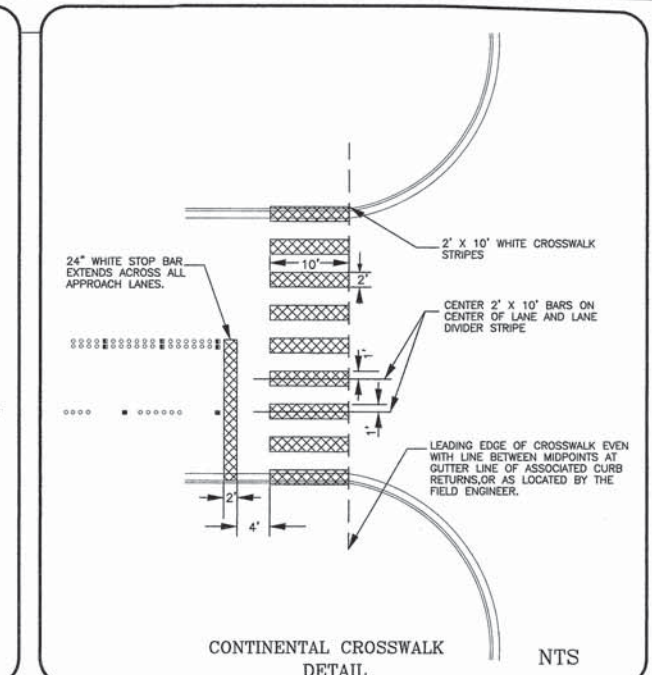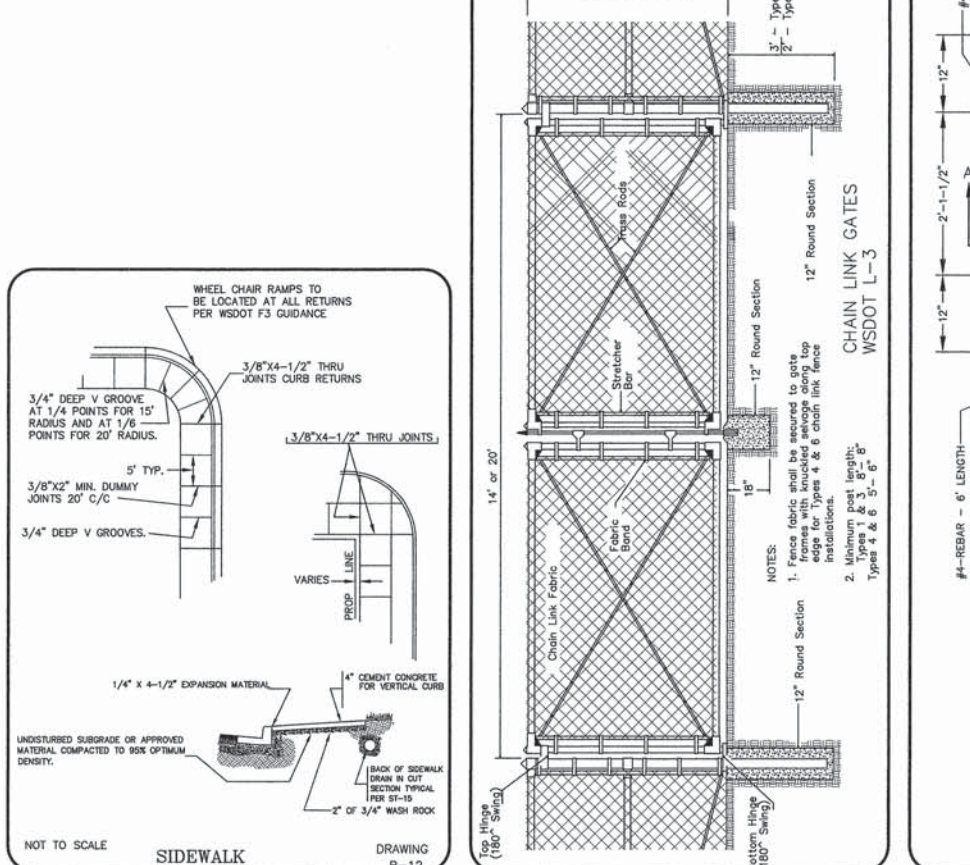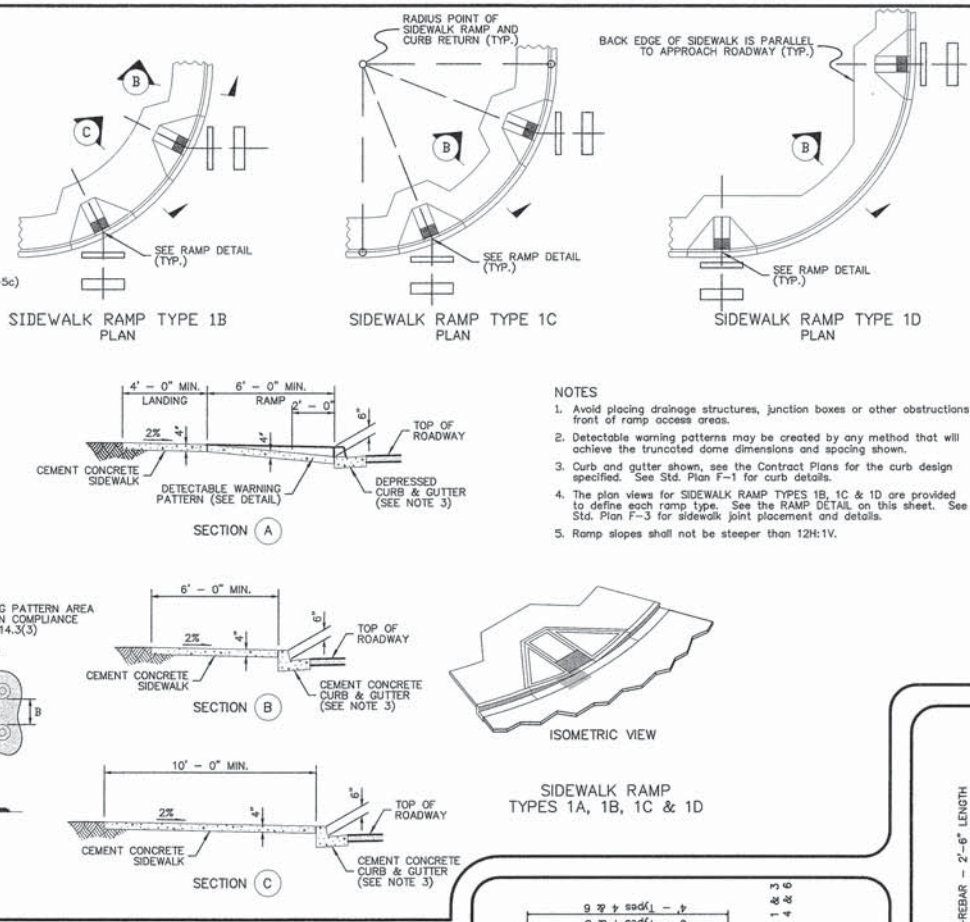

DATUM
NOV 29 USING CITY OF FERNDALE MON. STATION #351
HORIZONTAL
CITY OF FERNDALE MONUMENT NETWORK

BASE OF BEARINGS
WASHINGTON STATE NORTH ZONE NAD 83/91 COORDINATES
USING CITY OF FERNDALE MONUMENTS
STATIONS #343 AND #351

CHAD M. A. SCHILLMEYER
REGISTERED PROFESSIONAL ENGINEER
STATE OF WASHINGTON
#3846 (MAY 04)
EXPIRES 11/17/06

MILLENNIUM
Engineering Group, Inc.
109-6th ST., PO BOX 137, LYNDEN, WA 98264
PH: (360) 354-8141 FAX: (360) 354-3744
mail@2001egi.com www.2001egi.com

MALLOY VILLAGE PUD
AS-BUILT
DETAILS

FOR
MALLOY VILLAGE LLC
PTN. SW1/4, SEC.17, T39N, R2E, W.M.
CITY OF FERNDALE, WHATCOM COUNTY, WASHINGTON

SCALE: N/A
DATE: 03/31/05
DRAWN BY: CMAS
REVIEWED: 04/19/07
JOB NUMBER: 03062

00531.021 12/19/12 SH